
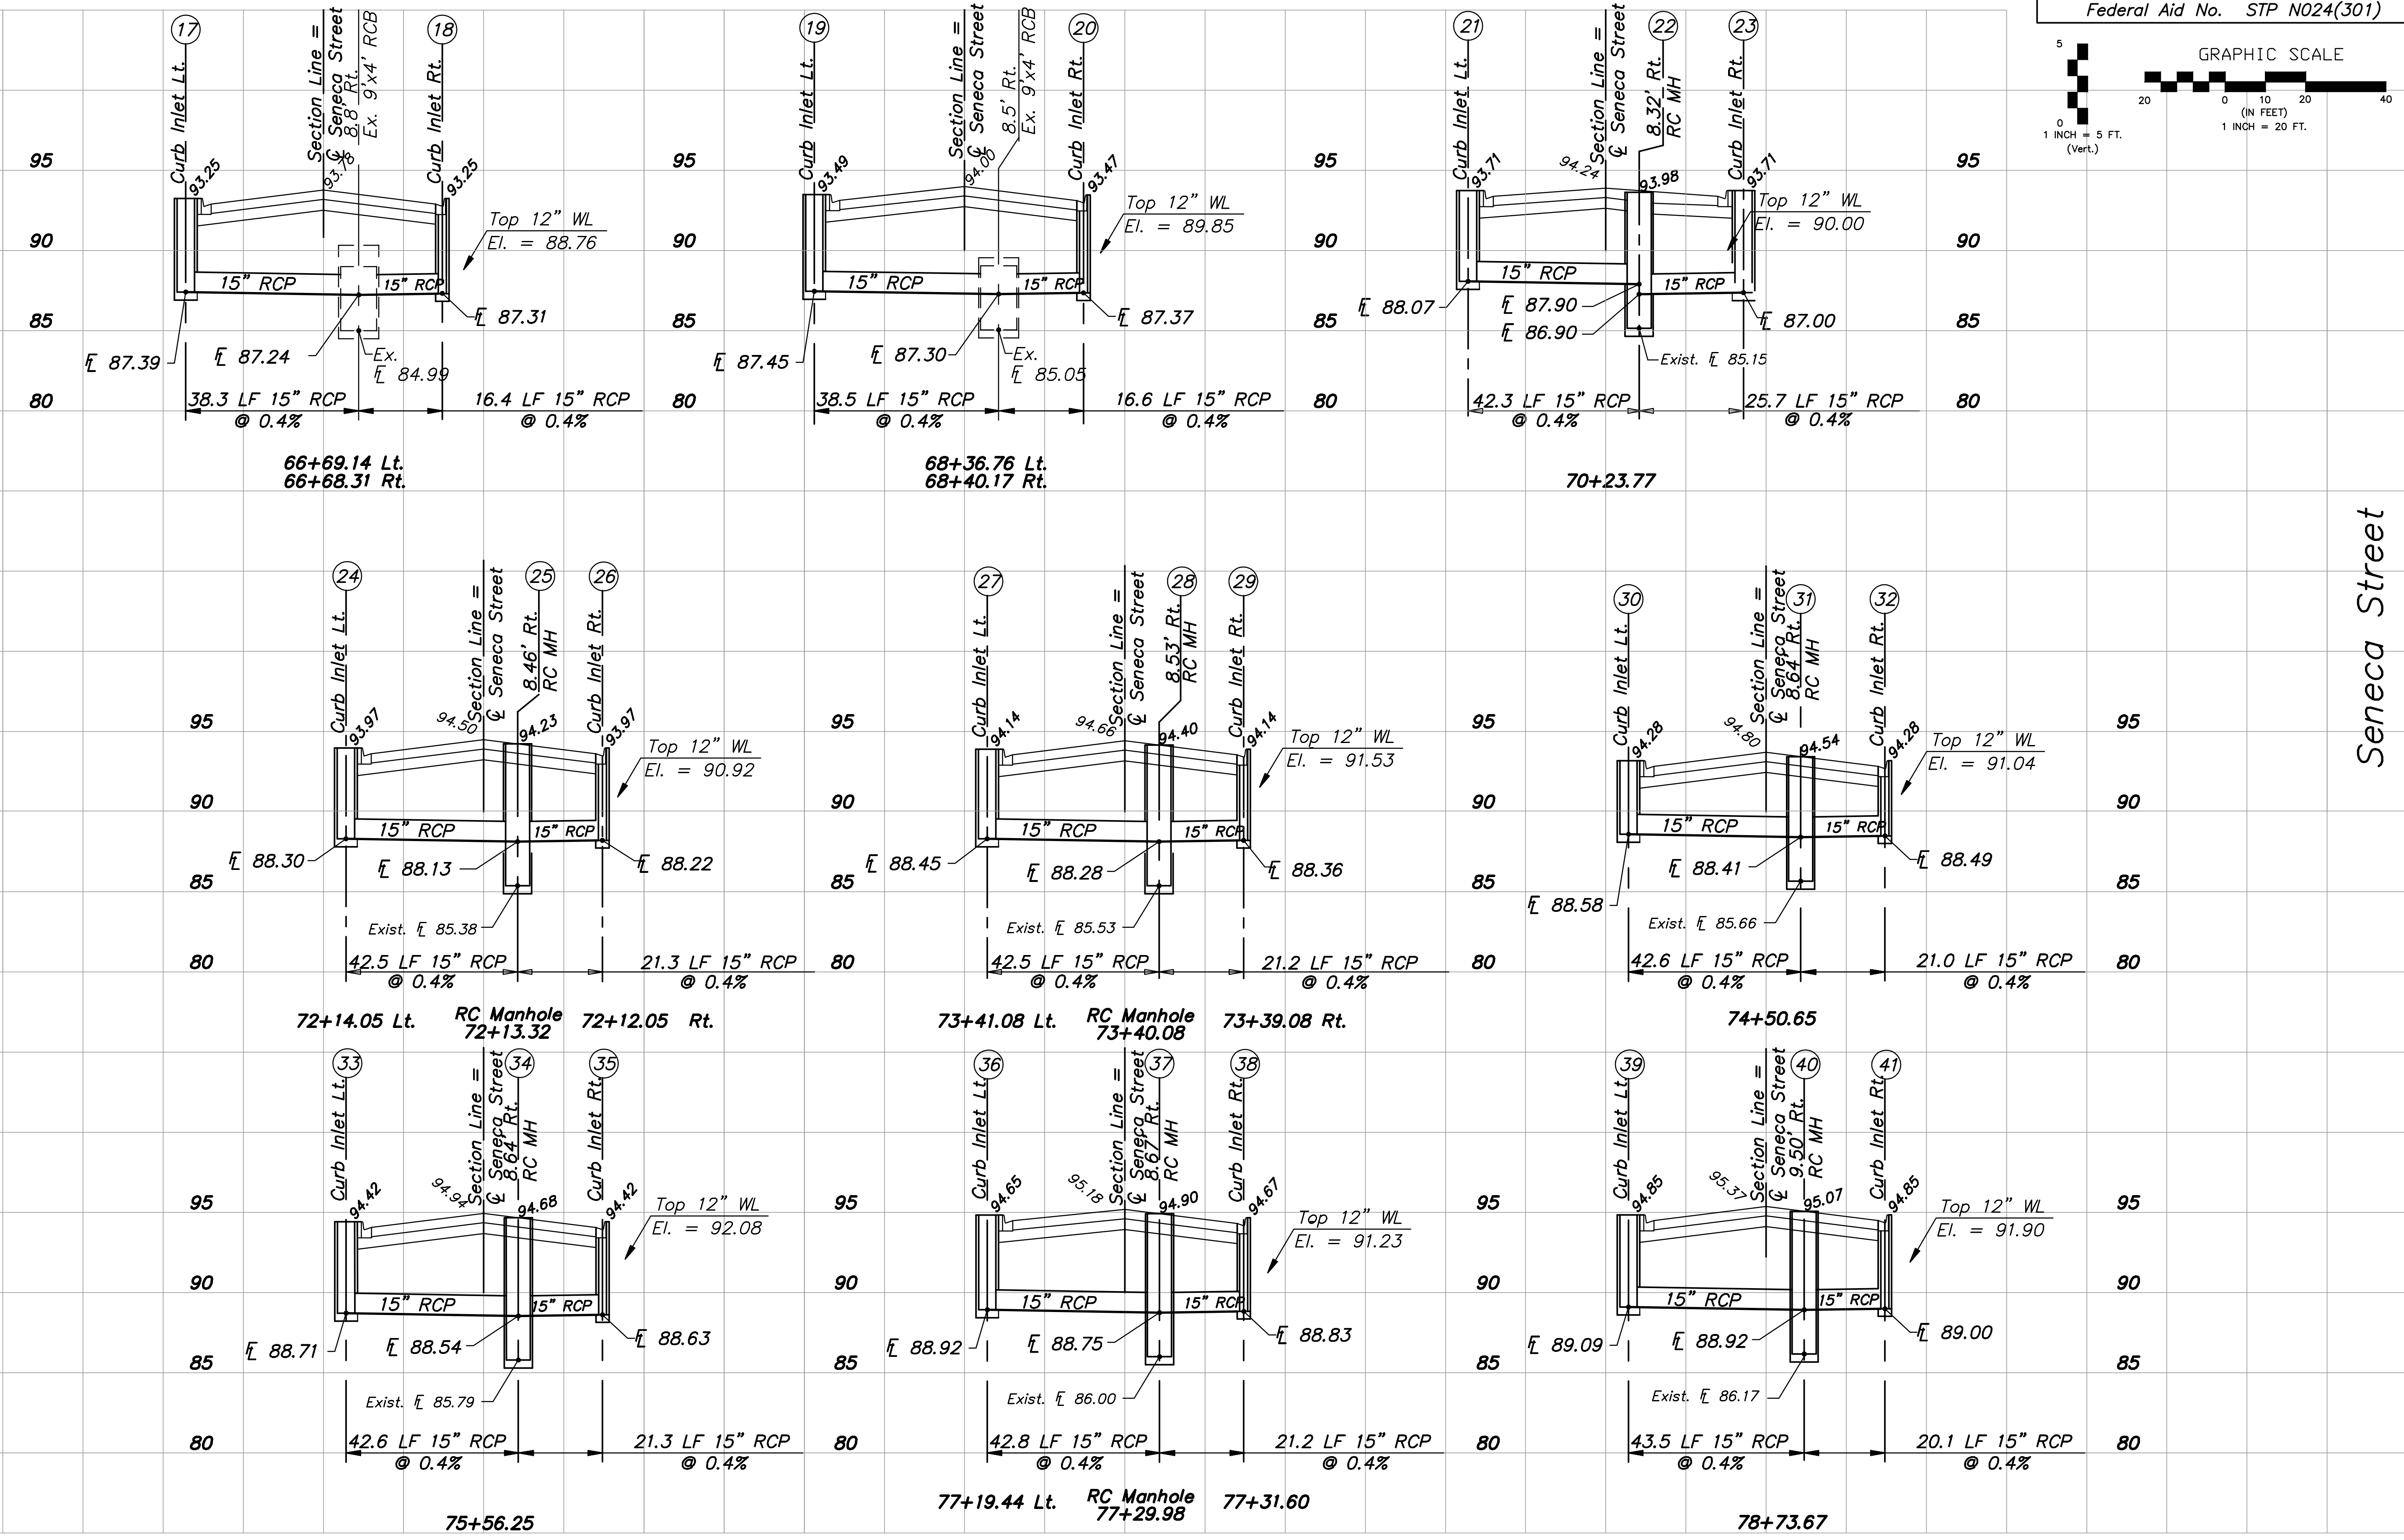


STATE	PROJECT NO.	YEAR	SHEET NO.	TOTAL SHEETS
KANSAS	87 N-0243-01	2005	60	169
Federal Aid No. STP N024(301)				

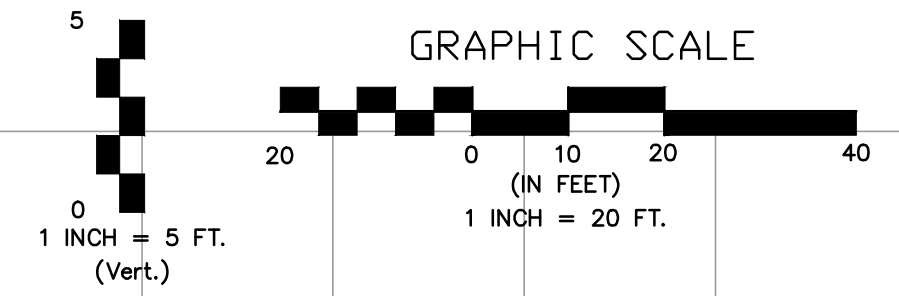

Seneca Street

No.	Date	By	Approved	Revision

SENECA STREET
 1-235 TO 31ST STREET
CITY OF WICHITA, KANSAS
 STORM SEWER PLAN AND PROFILE
 CROSS ROAD PROFILES

POE & ASSOCIATES, INC.
 CONSULTING ENGINEERS
 5940 E. Central, Suite 200 | Wichita, KS
 67208-4242
 Phone: 316/685-4114 | FAX: 316/685-4444

WINNAP
 P. FERGUSON
 Designer: J. UNRUH
 KDOT Job No.: 87 N-0243-01 Poe Job No.: 1794
 Date: JANUARY 2010

Sheet 60 of 169