

STORM WATER SEWER NO. 662
HAMPTON SQUARE SECOND

GRADING PLAN

SHEET TITLE
468-84773
PROJECT NUMBER


DFL / MLP / GJA
DESIGNED / DRAWN / CHECKED

ISSUED
November 2011

REVISED

SHEET NO.

9 of 30

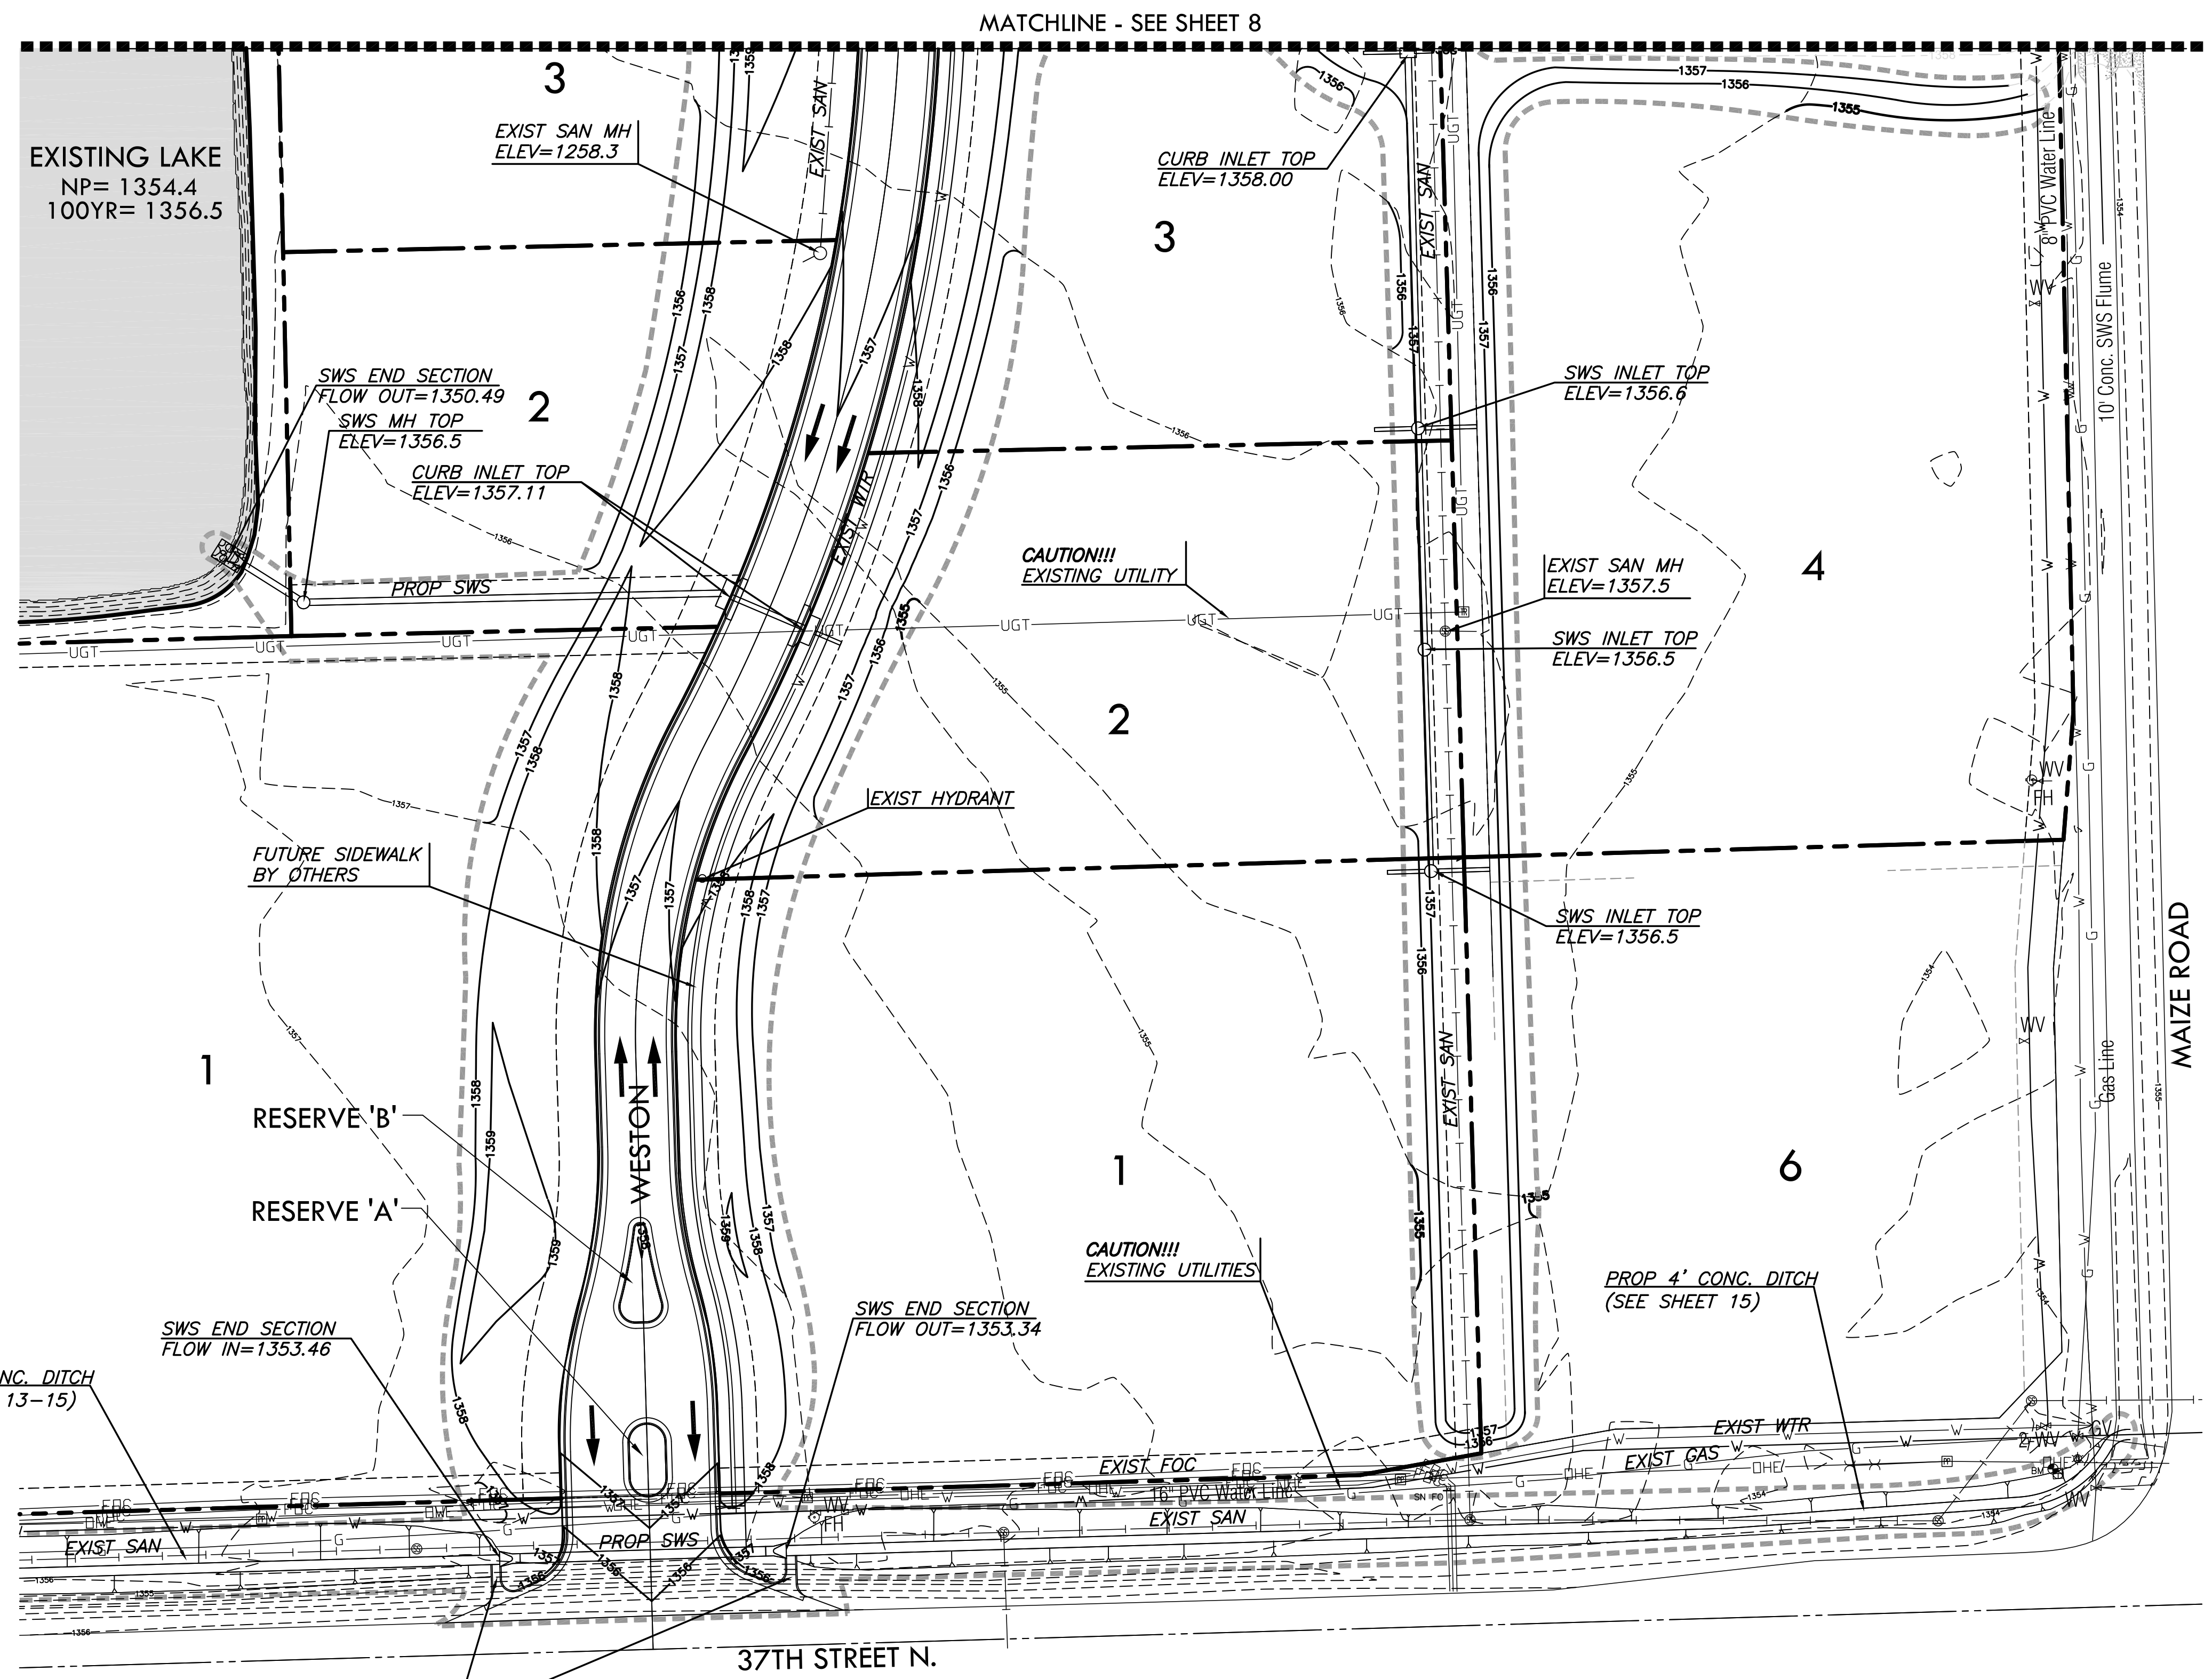

- LEGEND**
- PROPOSED STORM WATER SEWER
 - EXISTING WATER LINE
 - EXISTING SANITARY SEWER LINE
 - EXISTING CONTOURS
 - PROPOSED CONTOURS
 - LIMITS OF GRADING
 - NORMAL POOL
 - DRAINAGE ARROWS

PLOTTED: Tuesday, November 08, 2011 @ 05:22PM

J:\PROJECTS\2010\1001010592_PREMIER HAMPTON SQUARE 2ND\5-CIVIL\CAD\GRD\10592_GRA02.DWG