



**CITY OF WICHITA, KANSAS**  
**WASTEWATER TREATMENT PLANT #2**  
**HEADWORKS IMPROVEMENTS**

©2014  
MKEC Engineering  
All Rights Reserved  
www.mkec.com  
These drawings and their contents, including, but not limited to, all concepts, designs, & ideas are the exclusive property of MKEC Engineering (MKEC), and may not be used or reproduced in any way without the express consent of MKEC.


CV-22111 CONTROL VALVE ELECTRICAL PLANS	
PROJECT NO.	1401010275
DATE	07/31/14
SCALE	N.T.S.
DESIGNED	DAS
DRAWN	OS
CHECKED	MAS
ISSUED FOR CONSTRUCTION	09/18/14
NO.	REVISION
NO.	DATE
SHEET NO.	
18 OF 19	

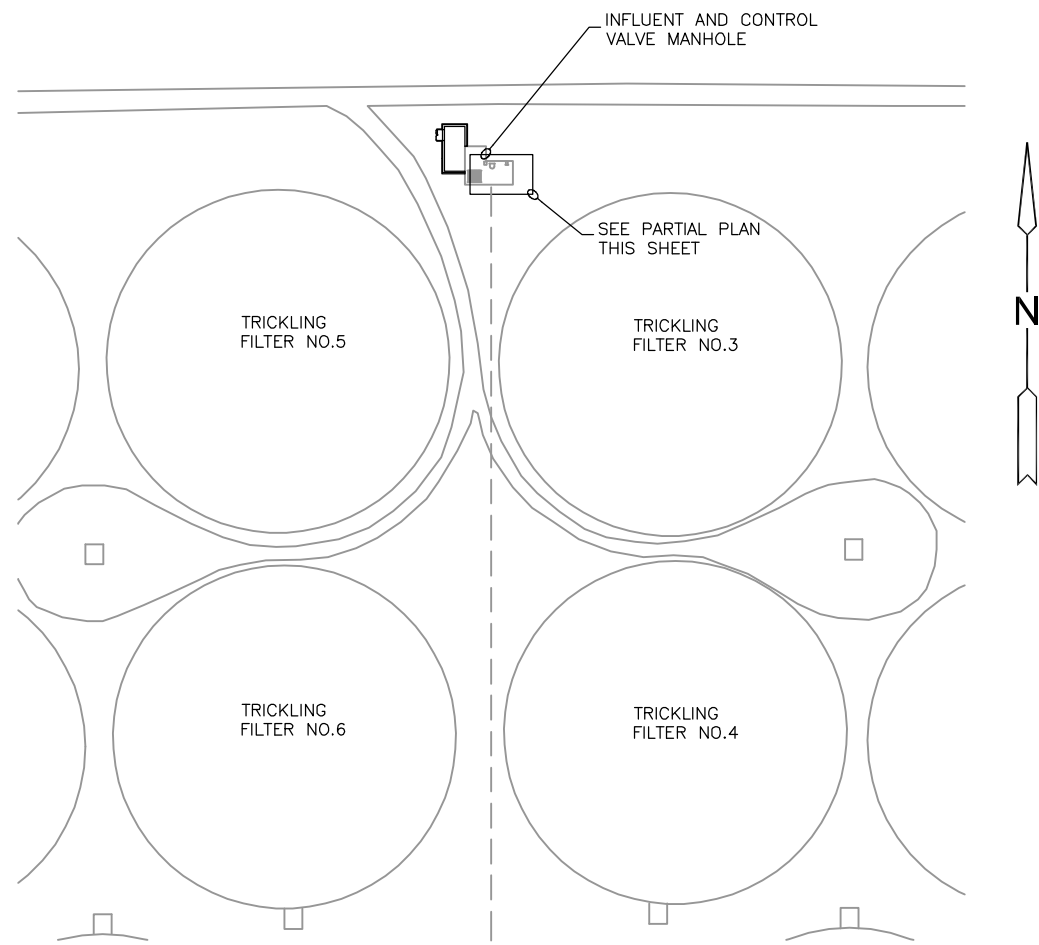

**A**  
**PARTIAL PLAN**  
SCALE: N.T.S

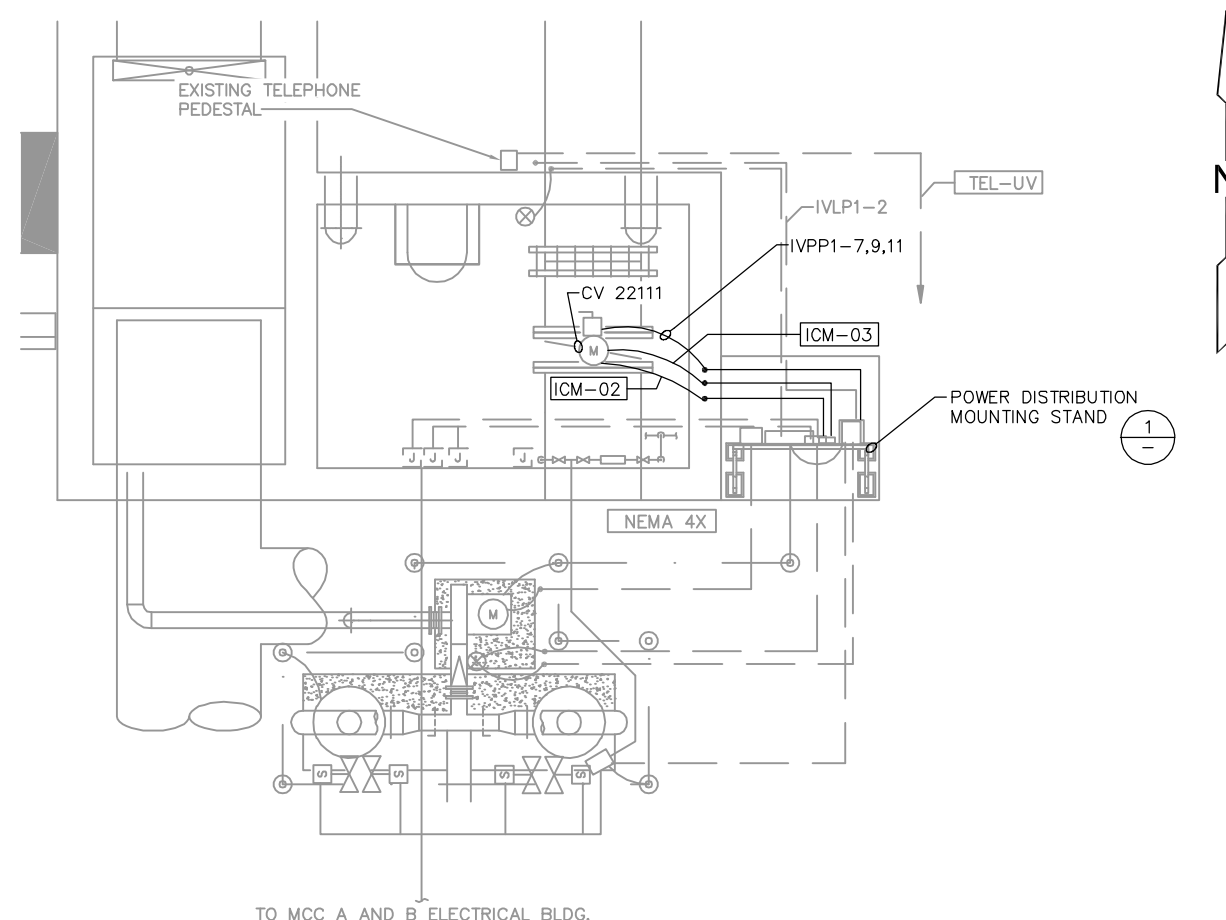

**B**  
**PARTIAL PLAN**  
SCALE: N.T.S

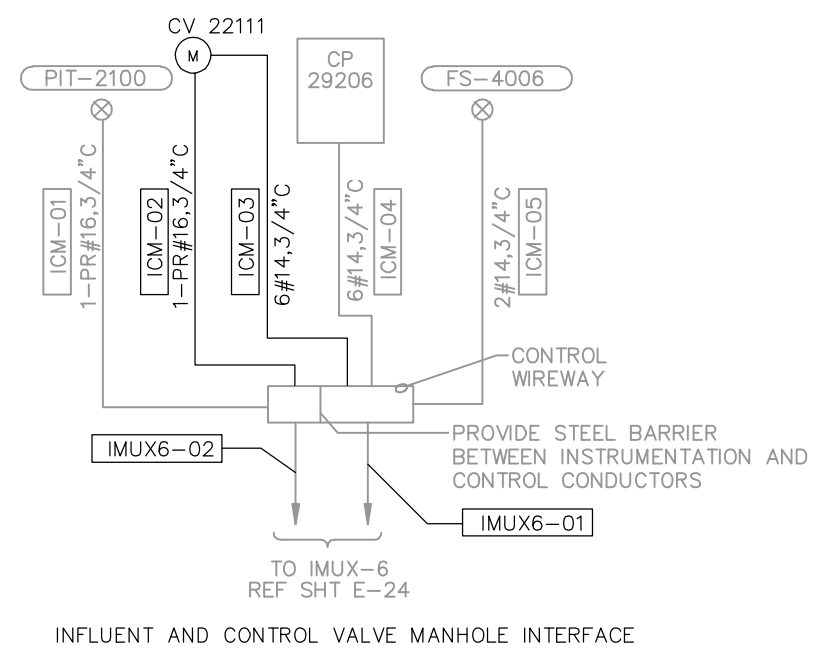

**1**  
**DIAGRAM**  
SCALE: N.T.S

**FROM CDM 2000 SEWAGE TREATMENT PLANT  
NO.2 IMPROVEMENTS CITY OF WICHITA**

**FOR REFERENCE ONLY**

**ALTERNATE #2**  
ENTIRE SHEET