
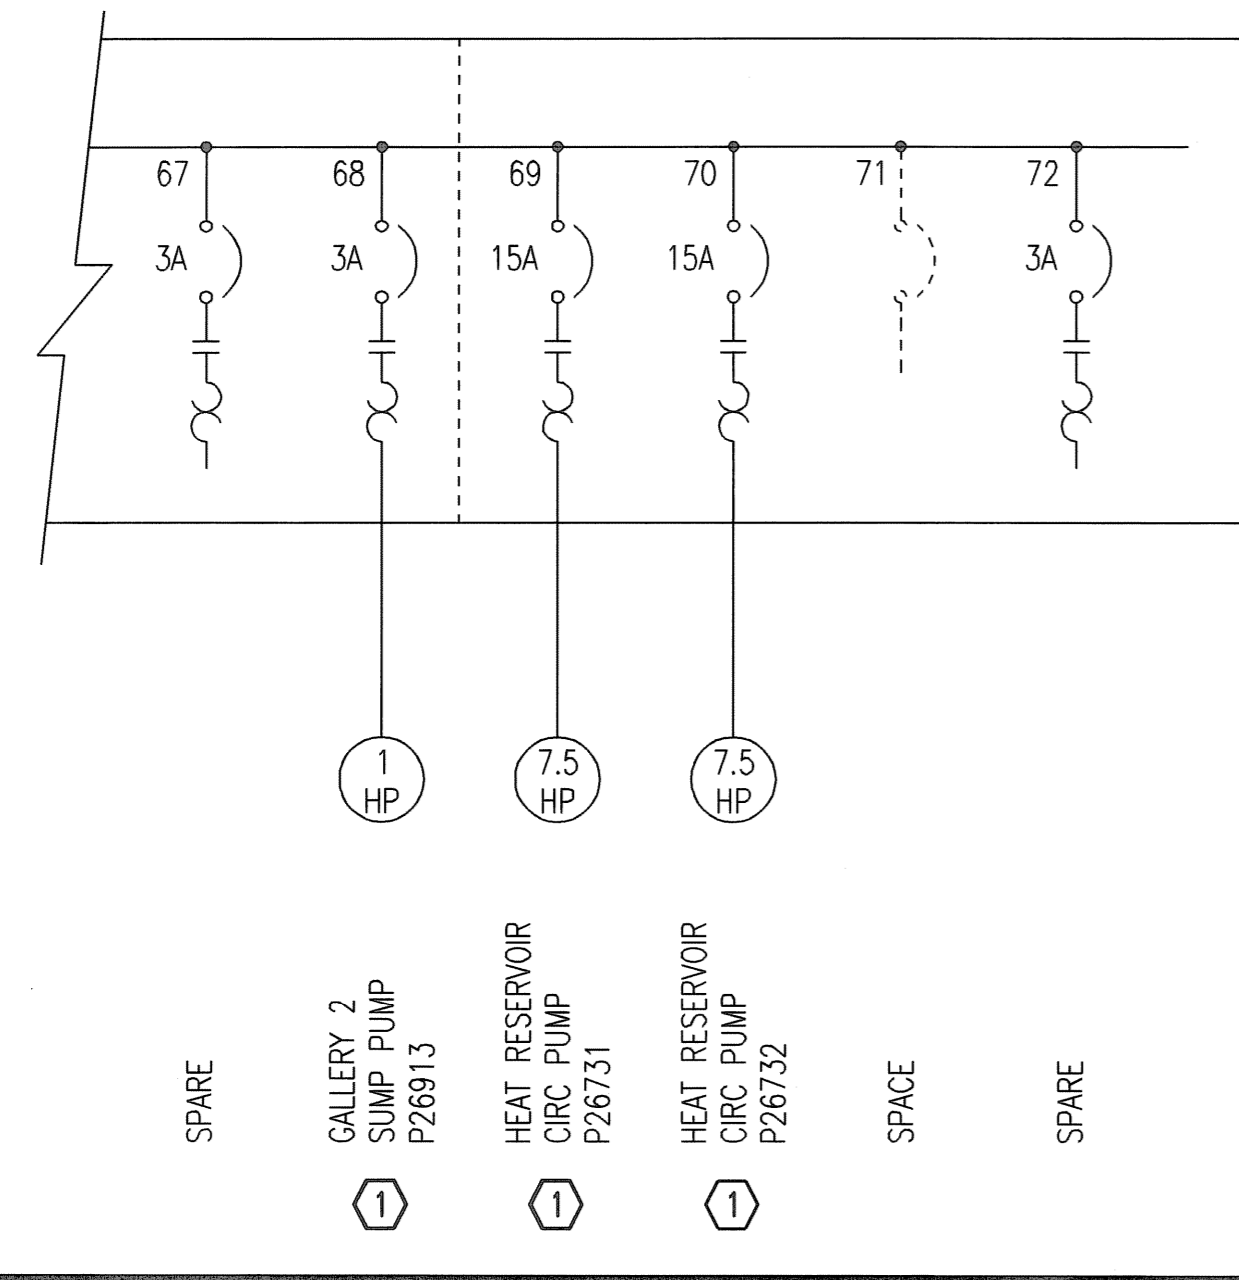


Save: 01-31-2015 12:32:53 PM by: CJV
 Plot Scale: 1:1 02-24-2015 10:45:00 AM by: CHRIS VAIL
 U:\Wichita-Facility\2014\14229\001\Elec\Drawings\EO.6 EXISTING ONE-LINE DIAGRAM

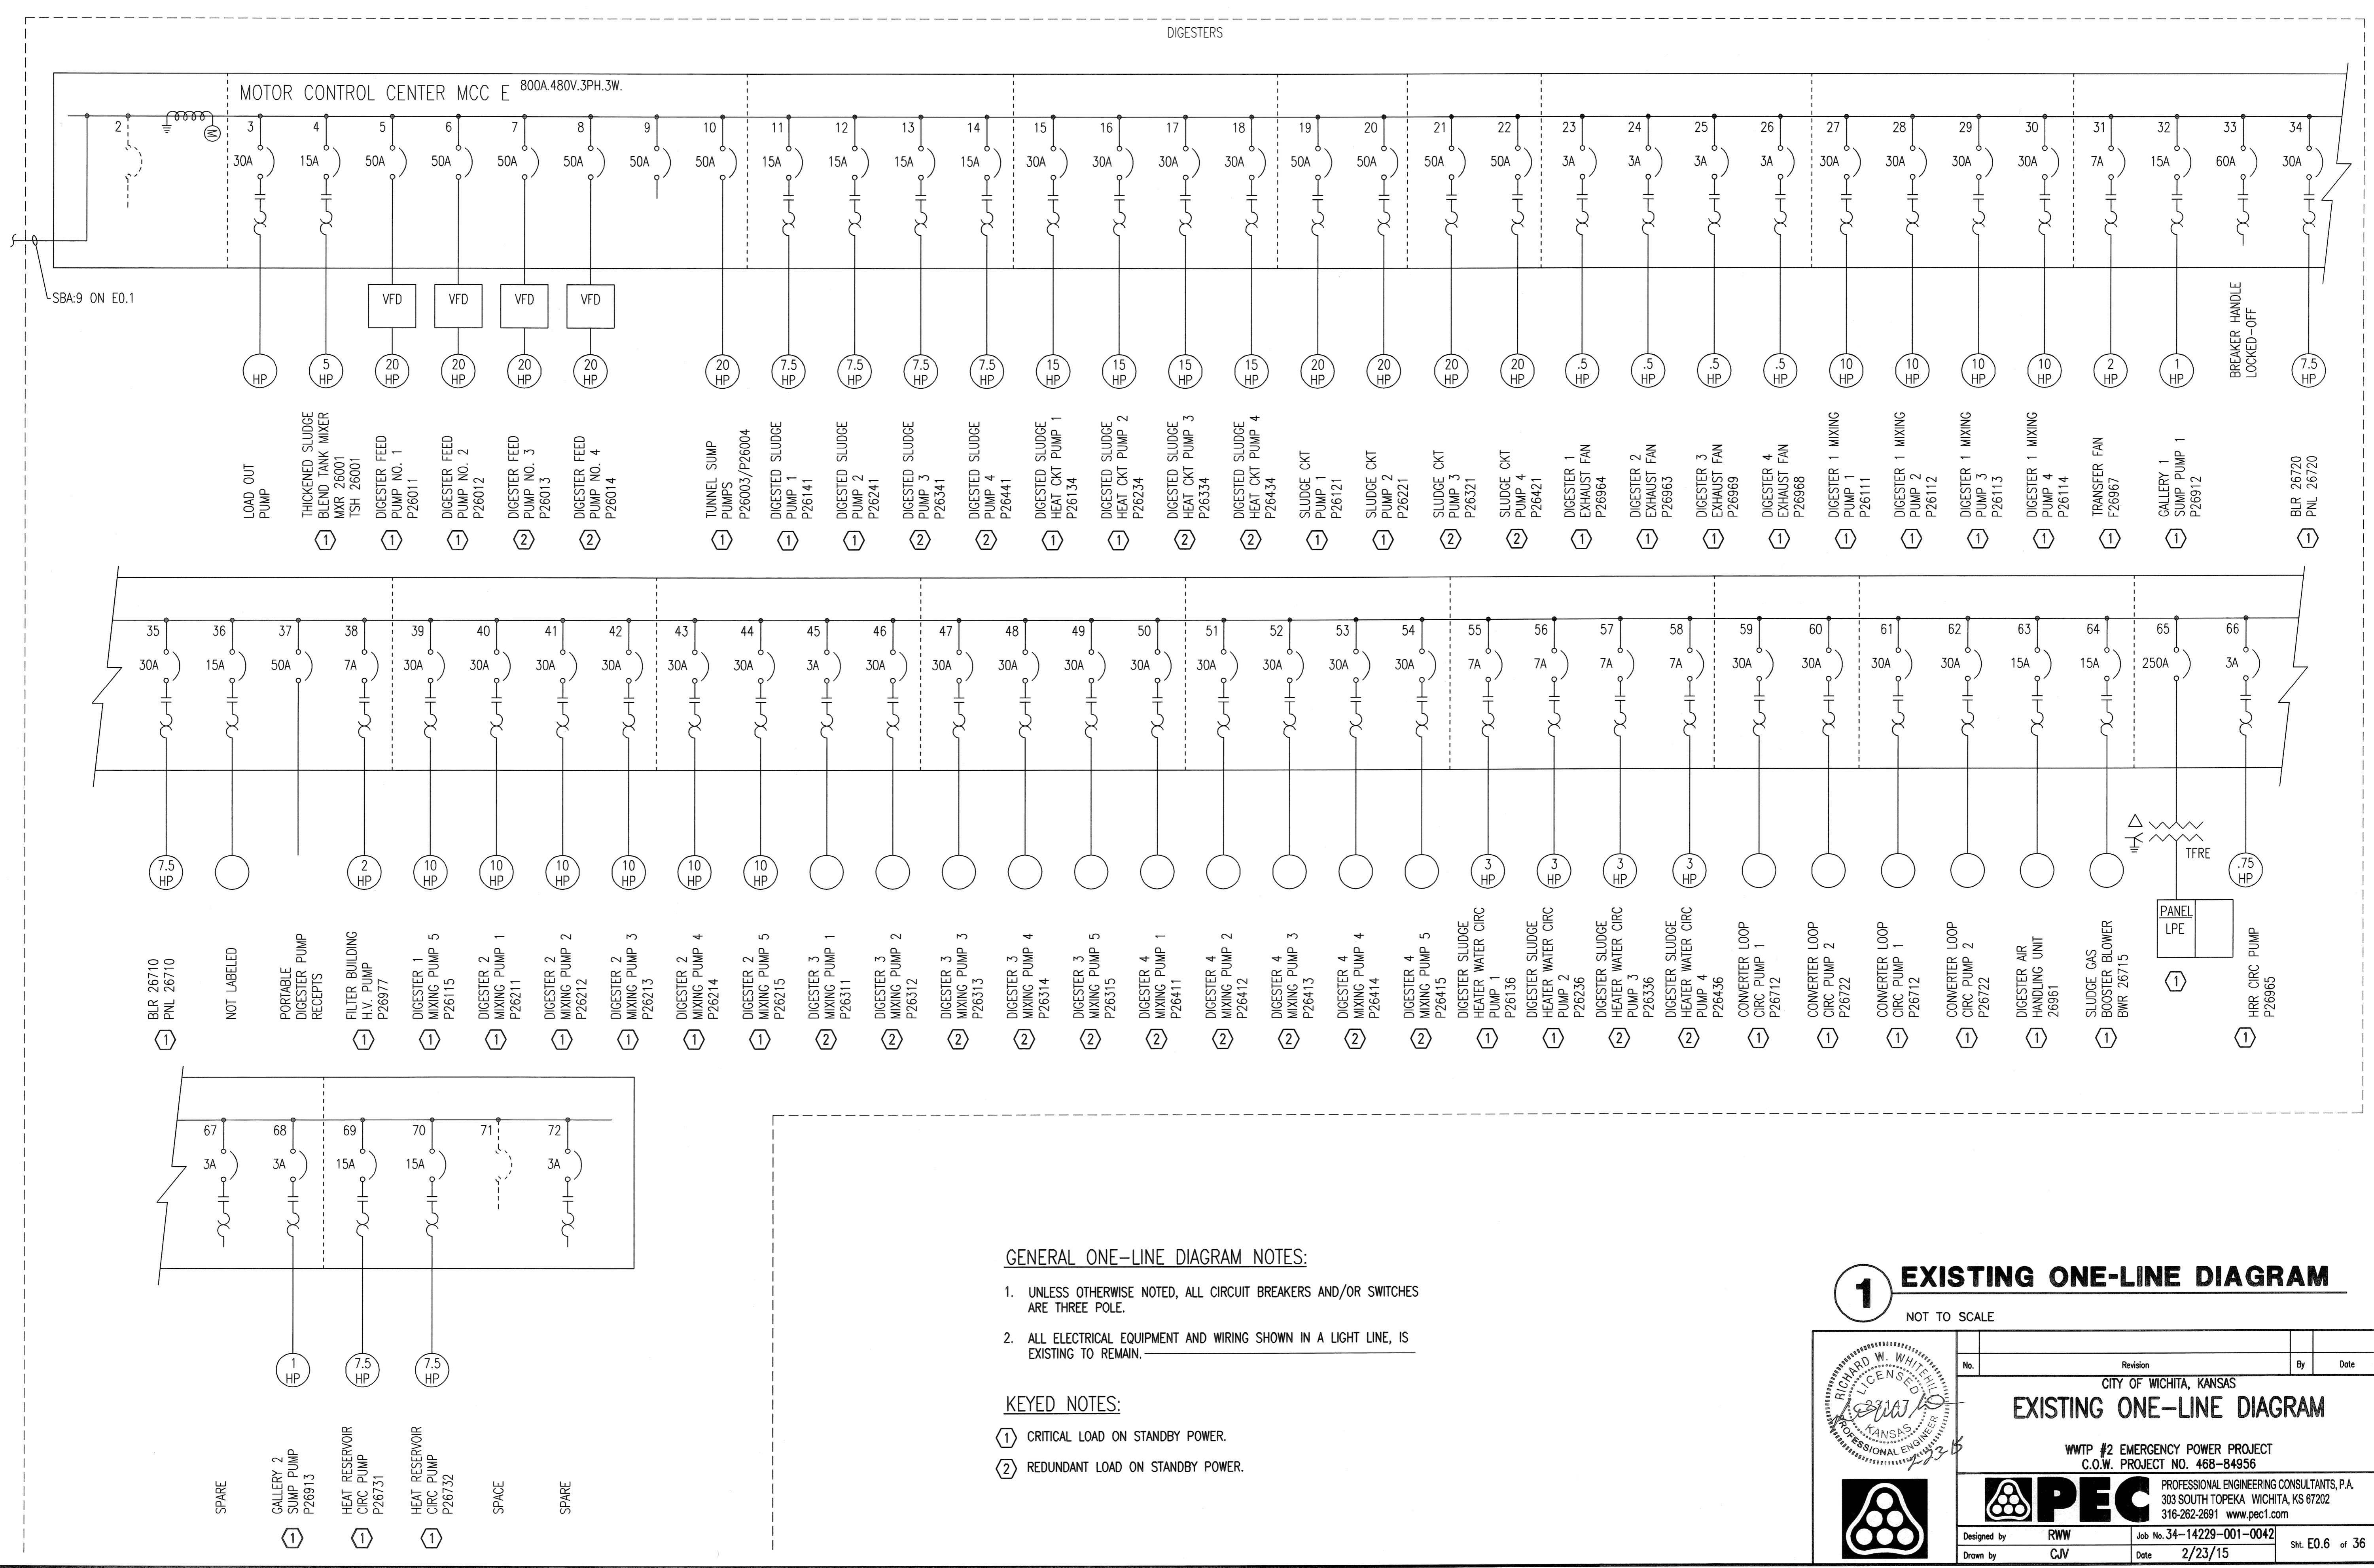

- GENERAL ONE-LINE DIAGRAM NOTES:**
- UNLESS OTHERWISE NOTED, ALL CIRCUIT BREAKERS AND/OR SWITCHES ARE THREE POLE.
 - ALL ELECTRICAL EQUIPMENT AND WIRING SHOWN IN A LIGHT LINE, IS EXISTING TO REMAIN.

- KEYED NOTES:**
- ① CRITICAL LOAD ON STANDBY POWER.
 - ② REDUNDANT LOAD ON STANDBY POWER.

1 EXISTING ONE-LINE DIAGRAM
 NOT TO SCALE

	Revision _____ By _____ Date _____ CITY OF WICHITA, KANSAS EXISTING ONE-LINE DIAGRAM WWTP #2 EMERGENCY POWER PROJECT C.O.W. PROJECT NO. 468-84956
	PEC PROFESSIONAL ENGINEERING CONSULTANTS, P.A. 303 SOUTH TOPEKA WICHITA, KS 67202 316-262-2691 www.pec1.com
Designed by RWW Drawn by CJV	Job No. 34-14229-001-0042 Date 2/23/15 Sht. EO.6 of 36