


SCALE= 1 : 2000

FHWA REG NO.	STATE	PROJECT NO.	YEAR	SHEET NO	TOTAL SHEETS
7	KANSAS	STP-N012(901)	1999	97	131

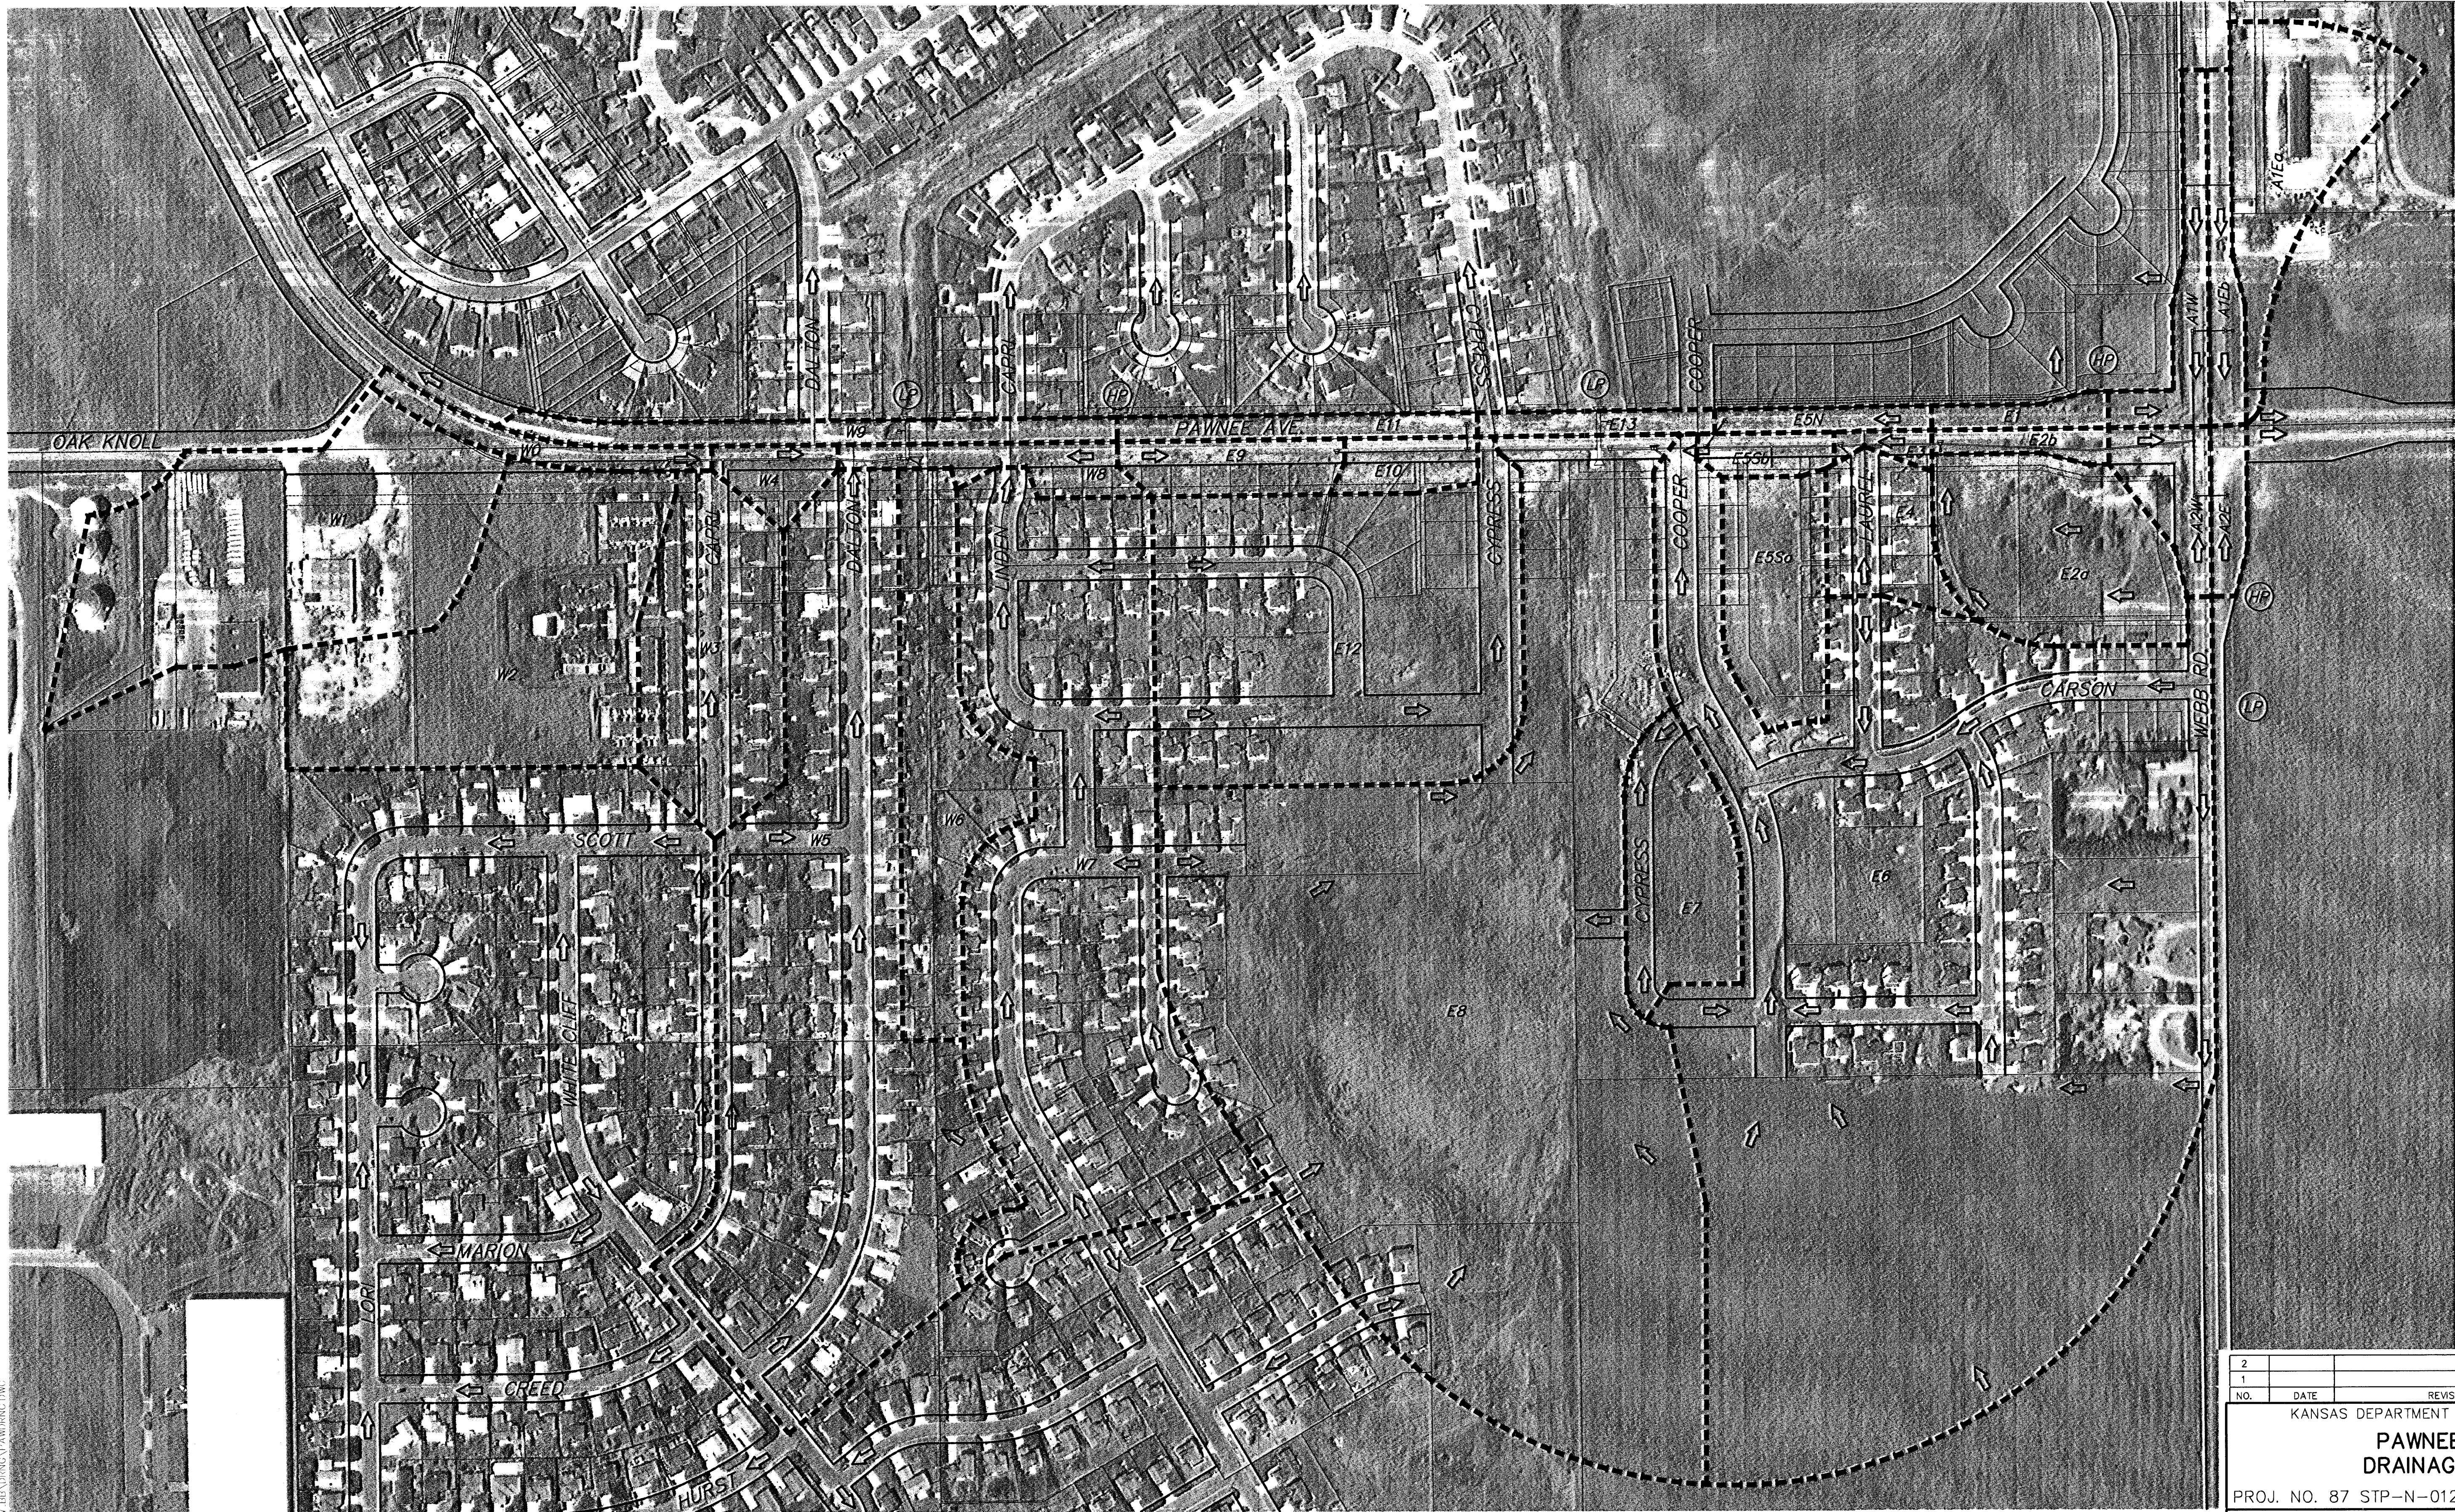

2					
1					
NO.	DATE	REVISIONS	BY	APP'D	
KANSAS DEPARTMENT OF TRANSPORTATION					
PAWNEE AVE. DRAINAGE PLAN					
PROJ. NO. 87 STP-N-0129-01 SEDGWICK COUNTY					
MID-KANSAS ENGINEERING CONSULTANTS, INC. WICHITA, KANSAS					
DESIGNED BY:	TKM	CHECKED BY:	JTC		
DRAWN BY:	GJR	DATE:	APRIL 1999	SHEET	97 OF 131