



CITY OF WICHITA, KS
STRYKER SPORTS
CONCEPT DESIGN

 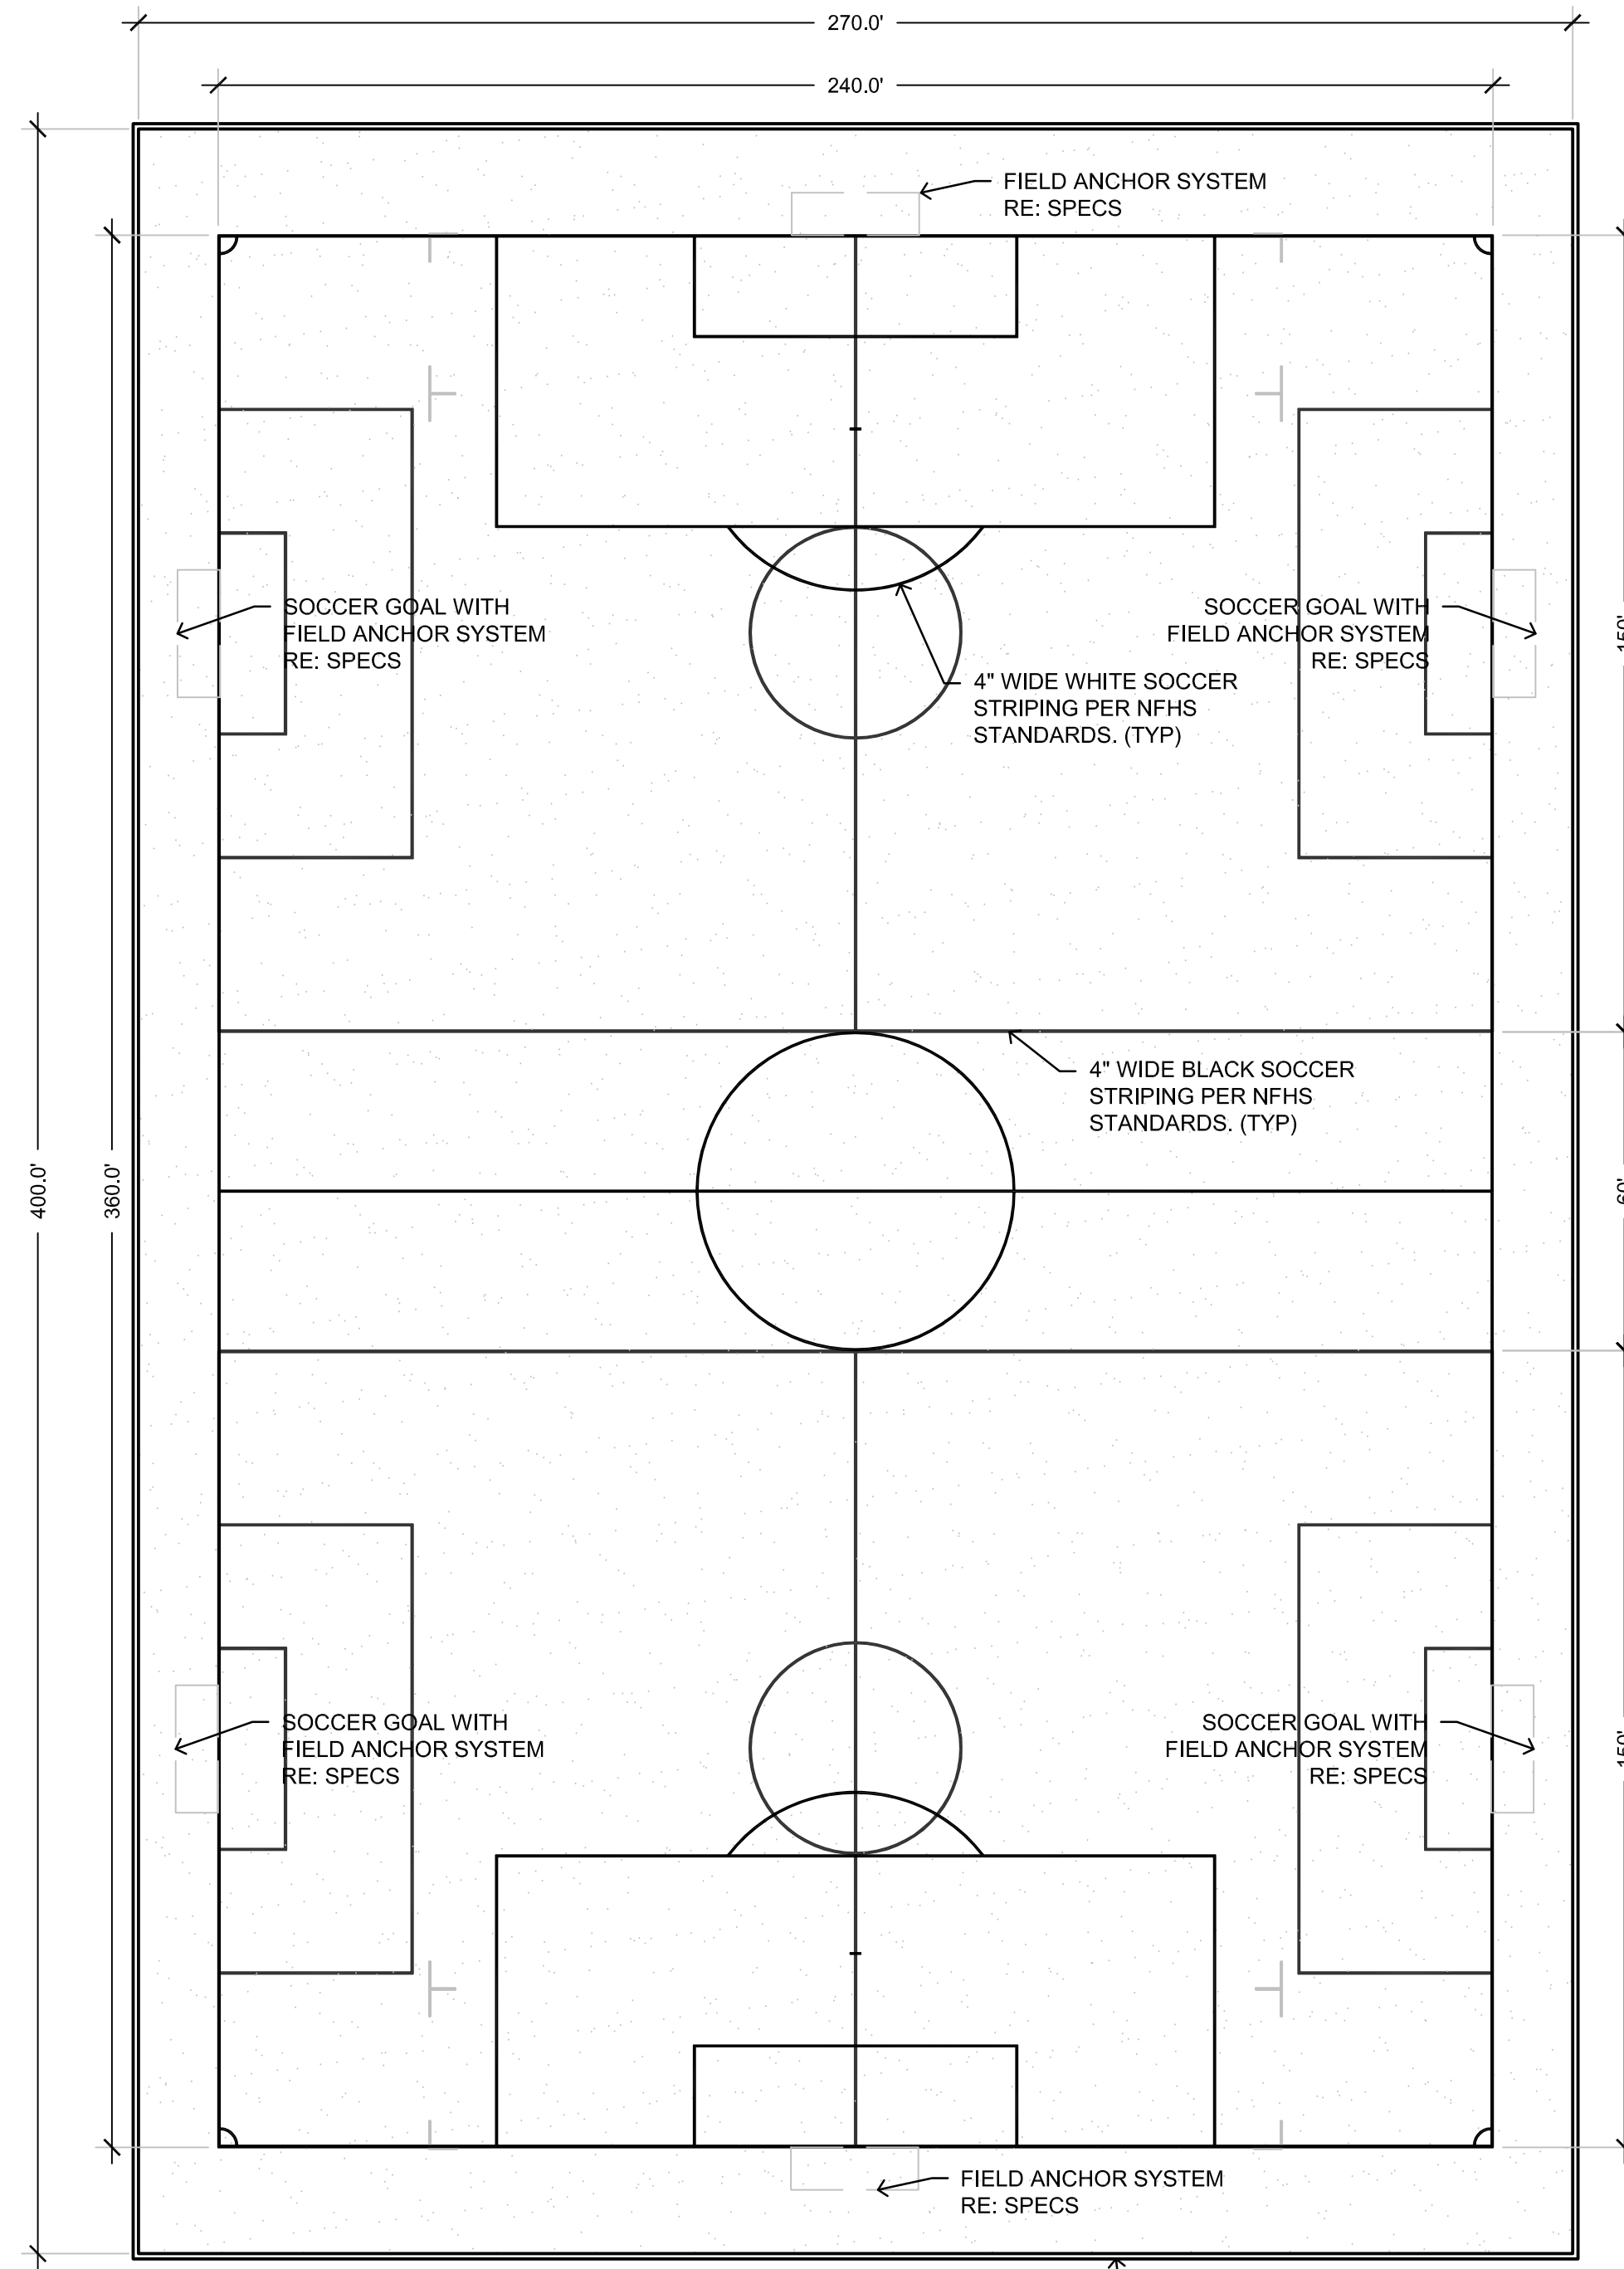


LAYOUT PLAN

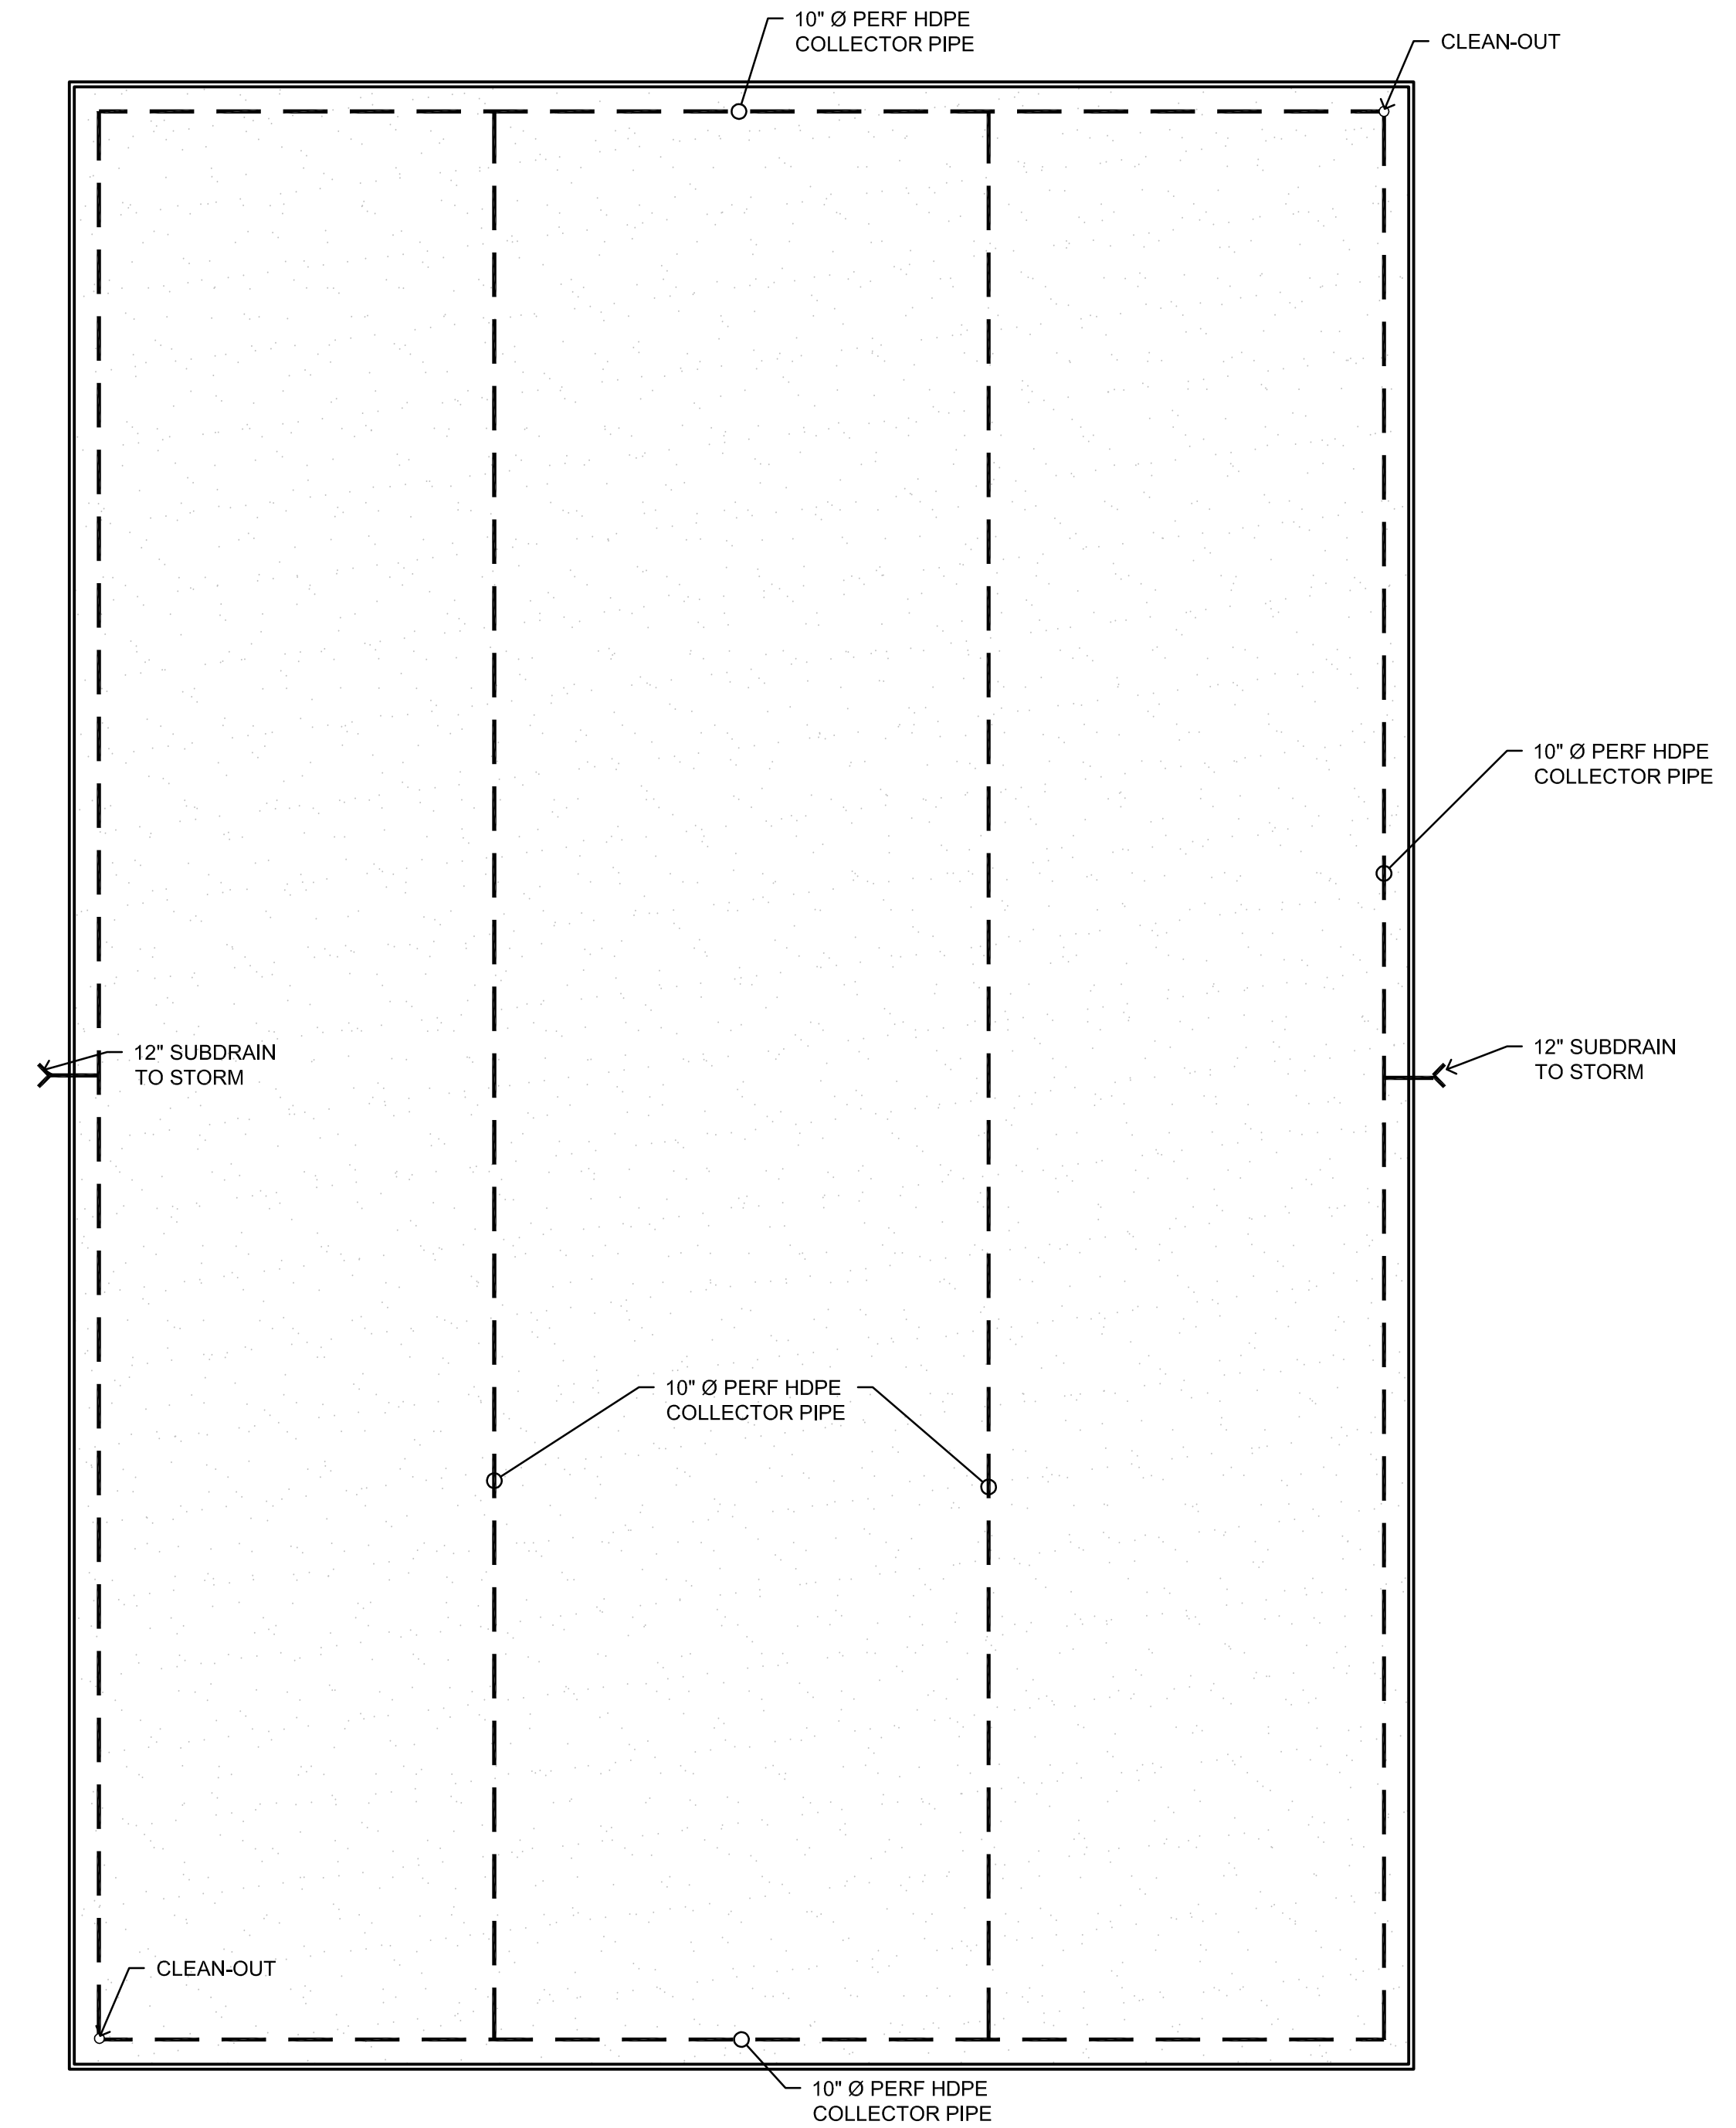

DRAINAGE PLAN

INDOOR FIELD LAYOUT



©2017
MKEC Engineering
All Rights Reserved
www.mkec.com
These drawings and their contents, including, but not limited to, all concepts, designs, & ideas are the exclusive property of MKEC Engineering (MKEC), and may not be used or reproduced in any way without the express consent of MKEC.

INDOOR
FIELD LAYOUT

PROJECT NO.	1701010567	
DATE	11-01-17	
SCALE	1"=30'	
DESIGNED	DRAWN	CHECKED
JLE	JLE	JLE
NO.	REVISION	DATE
0	TURF PROC. - IFC	11-01-17

SHEET NO.
LA1.003

PLOTTED: Wednesday, November 01, 2017 @ 08:18PM
M:\SPRINGS\PROJECTS\1701010567\CITY OF WICHITA\STRYKER SPORTS COMPLEX\GRAPHICS\CAD\TODAYS