





PLOTED: Wednesday, December 13, 2017 @ 09:30AM

J:\PROJECTS\2017\1601010317 - PERFECTION_COURTYARDS AT BROOKFIELD\16317-CAD\SHS\06-CIVIL\GRD\16317-GD-01-04.DWG

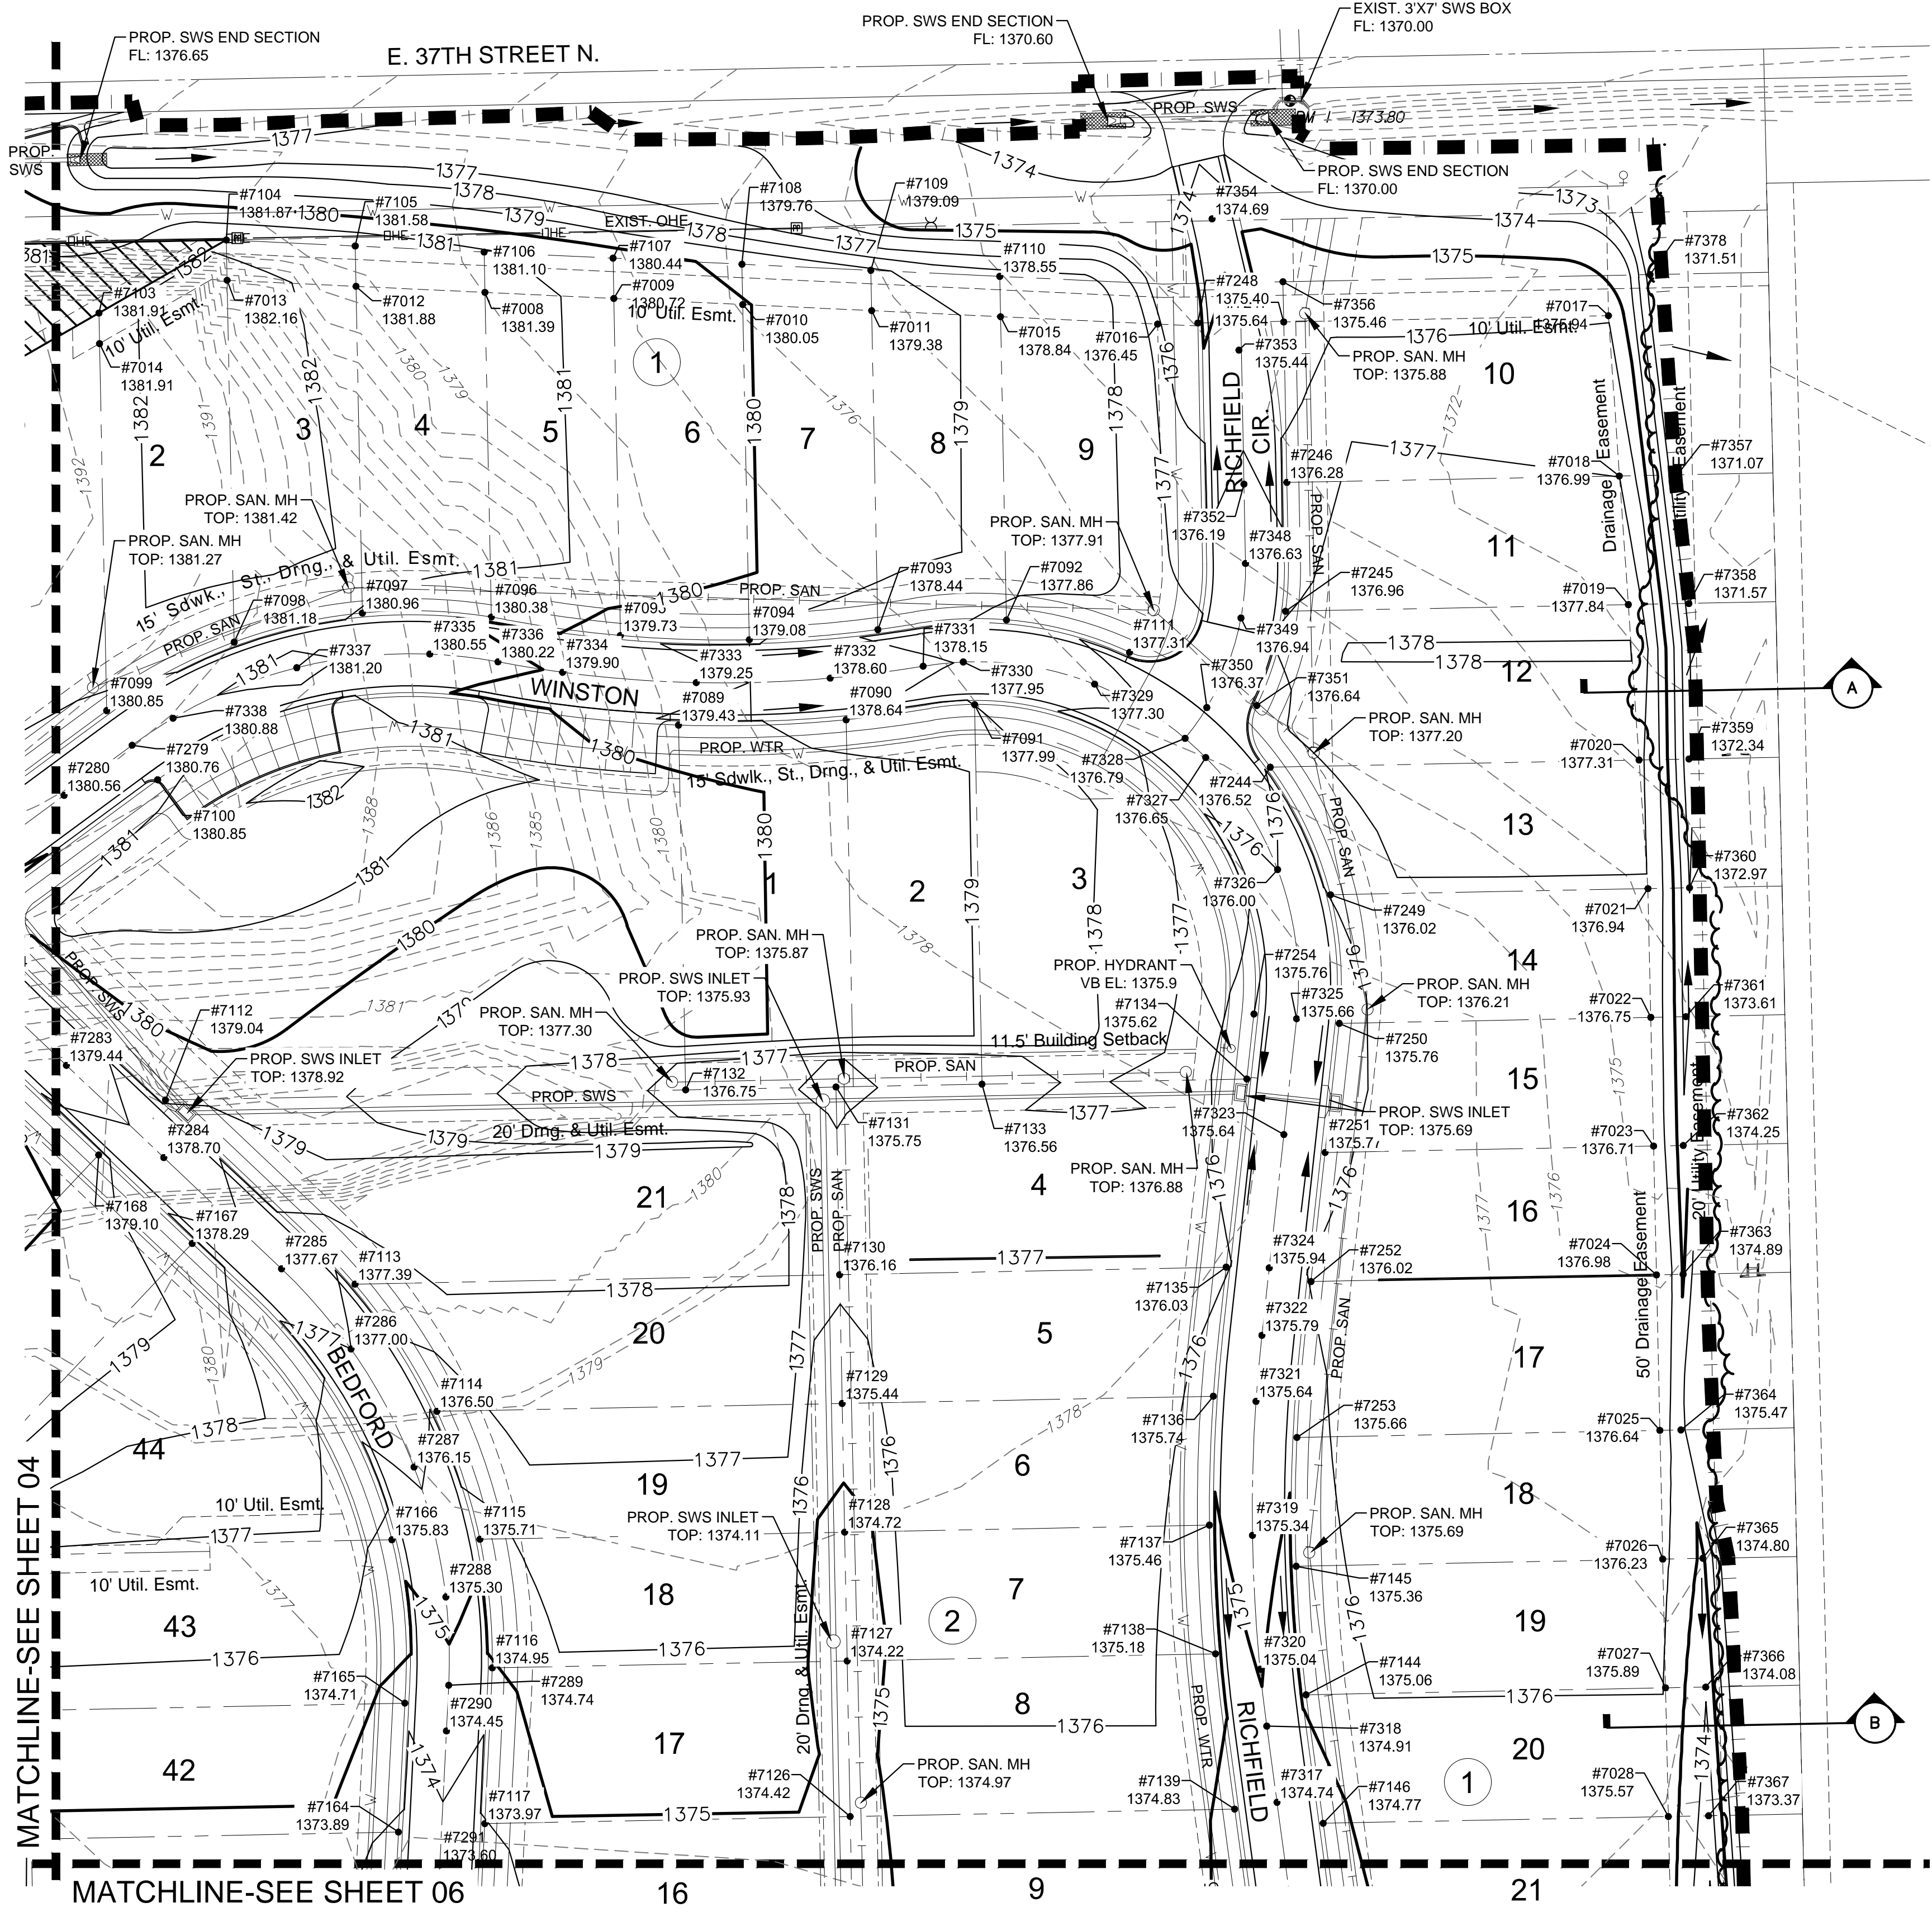


MATCHLINE-SEE SHEET 04

MATCHLINE-SEE SHEET 06

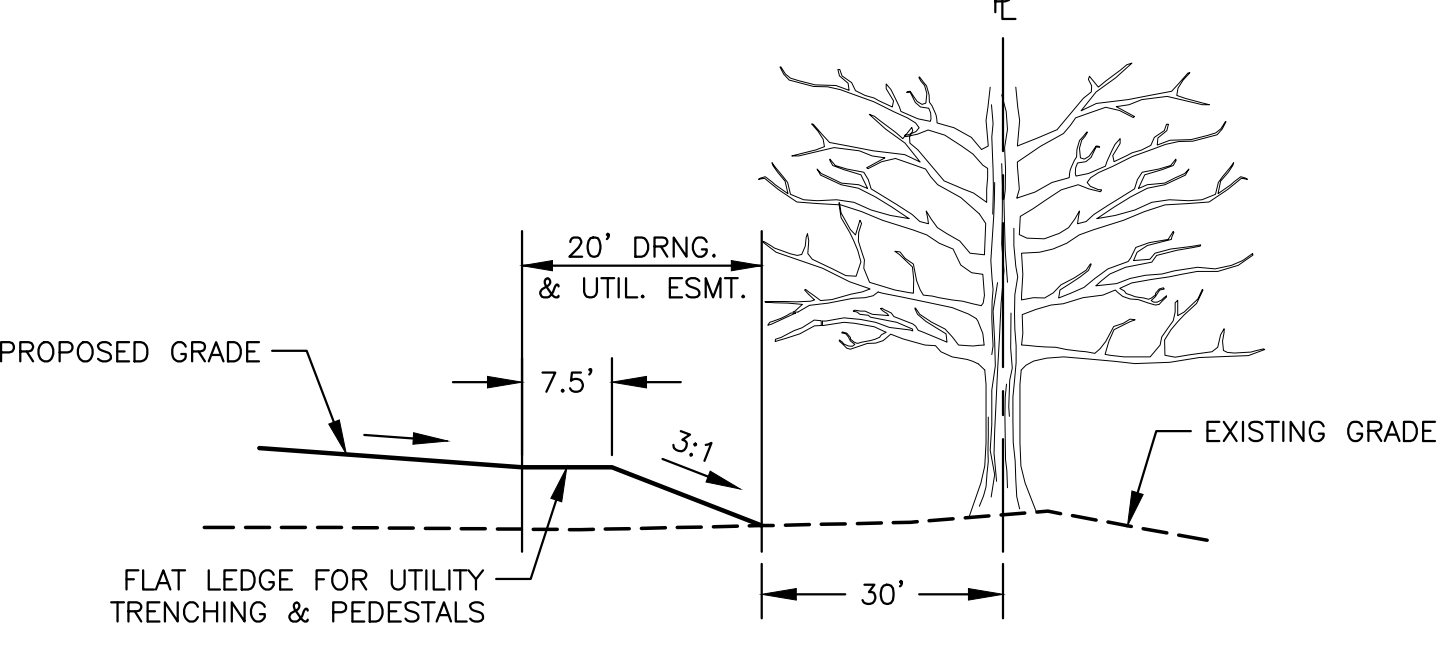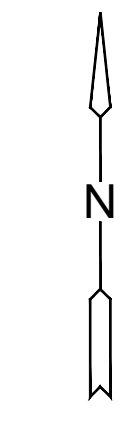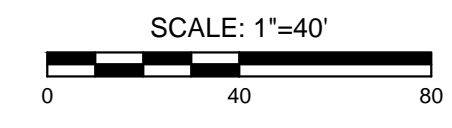

A NORTH SECTION
SCALE: NTS
BLOCK 1, LOTS 10 - 13

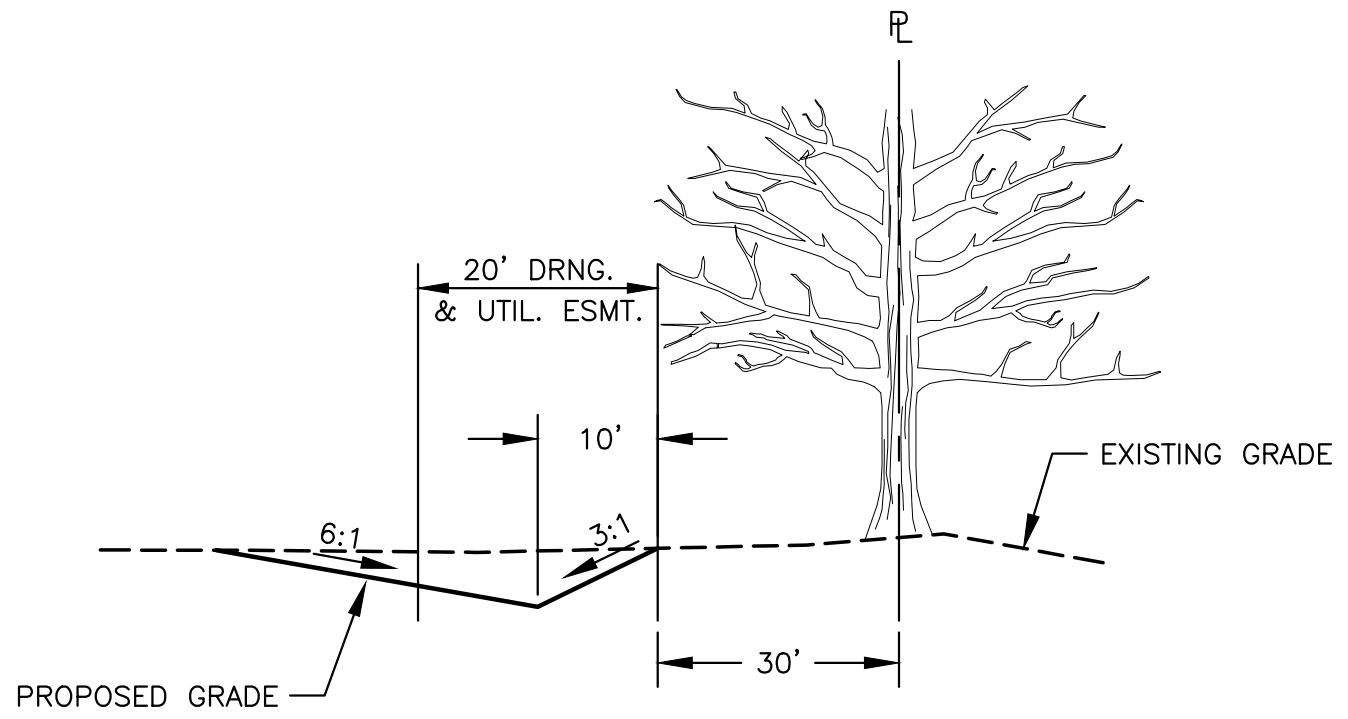

B SOUTH SECTION
SCALE: NTS
BLOCK 1, LOTS 14 - 30

LEGEND

- 1250 --- EXISTING CONTOUR
- 1250 — PROPOSED CONTOUR
- W WATER LINE
- STORM WATER SEWER
- SANITARY SEWER
- EXISTING STORMWATER SEWER
- UGT— EXISTING UNDERGROUND TELEPHONE
- UGE— EXISTING UNDERGROUND ELECTRICAL
- OHE— EXISTING OVERHEAD ELECTRICAL
- LIMITS OF GRADING
- #xxxx
1372.27 COORDINATE POINT & SPOT ELEVATION
(SEE SHEETS 11-## FOR COORDINATE TABLES)
- 12' TOPSOIL (SEE DETAIL 2, SHEET 02)
COST SUBSIDIARY TO PROJECT

NOTE: ONLY REMOVE TREES WHEN NECESSARY. REFER TO TREE TRIMMING DETAILS ON SHEET 02.



GRADING PLANS FOR
COURTYARDS AT BROOKFIELD ADD.

©2017 MKEC Engineering All Rights Reserved www.mkec.com
These drawings and their contents, including, but not limited to, all concepts, designs, & ideas are the exclusive property of MKEC Engineering (MKEC), and may not be used or reproduced in any way without the express consent of MKEC.

GRADING PLAN 02

PROJECT NO.	468-85265	
DATE	DEC. 2017	
SCALE	1"=40'	
DESIGNED	DRAWN	CHECKED
DFL	JWC	GJA
NO.	REVISION	DATE