

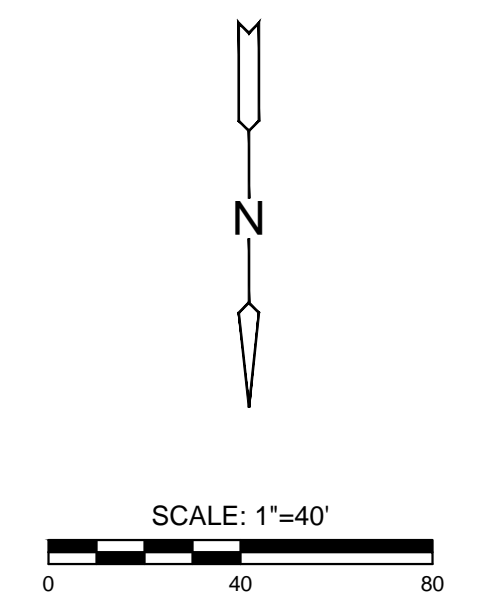


J:\PROJECTS\2017\1701010567_COW_STRYKER_170567_CAD\SHIT\505_CIVIL\SAN170567-05-2202.DWG
 J:\PROJECTS\2017\1701010567_COW_STRYKER_170567_CAD\SHIT\505_CIVIL\SAN170567-05-2202.DWG
 PLOTTED: Wednesday, January 10, 2018 @ 08:49AM

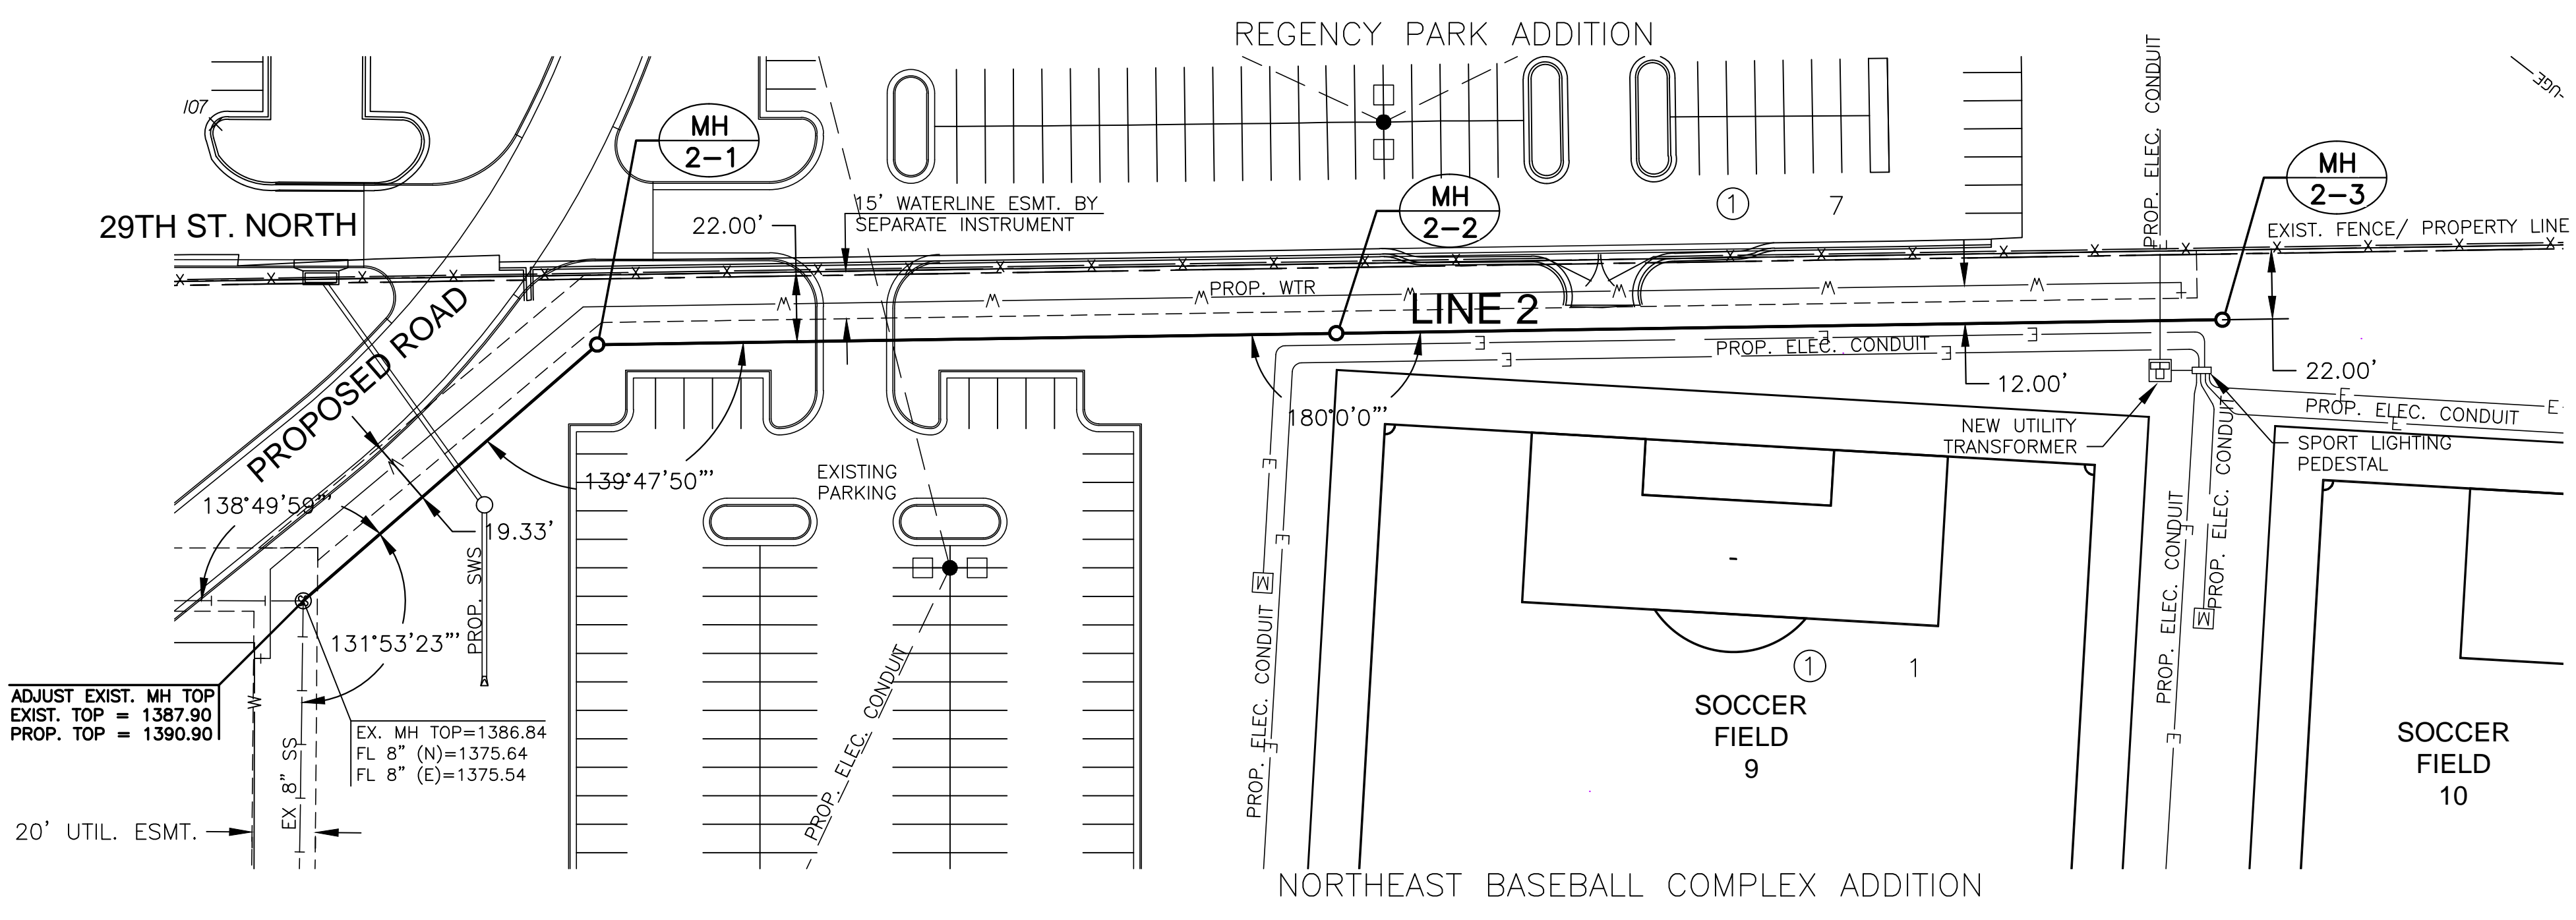

NOTES:
 CONTRACTOR TO VERIFY THE DEPTH AND LOCATION OF EXISTING UTILITIES PRIOR TO CONSTRUCTION.
 PROPOSED ELECTRICAL CONDUIT RUNS AS SHOWN ARE SCHEMATIC IN NATURE. REFERENCE ELECTRICAL SHEETS FOR INSTALLATION DETAILS
 SEE GRADING PLANS FOR BUILDING FINISHED FLOOR NOTES

PLAN SAN LINE 2
 PROFILE SAN LINE 2

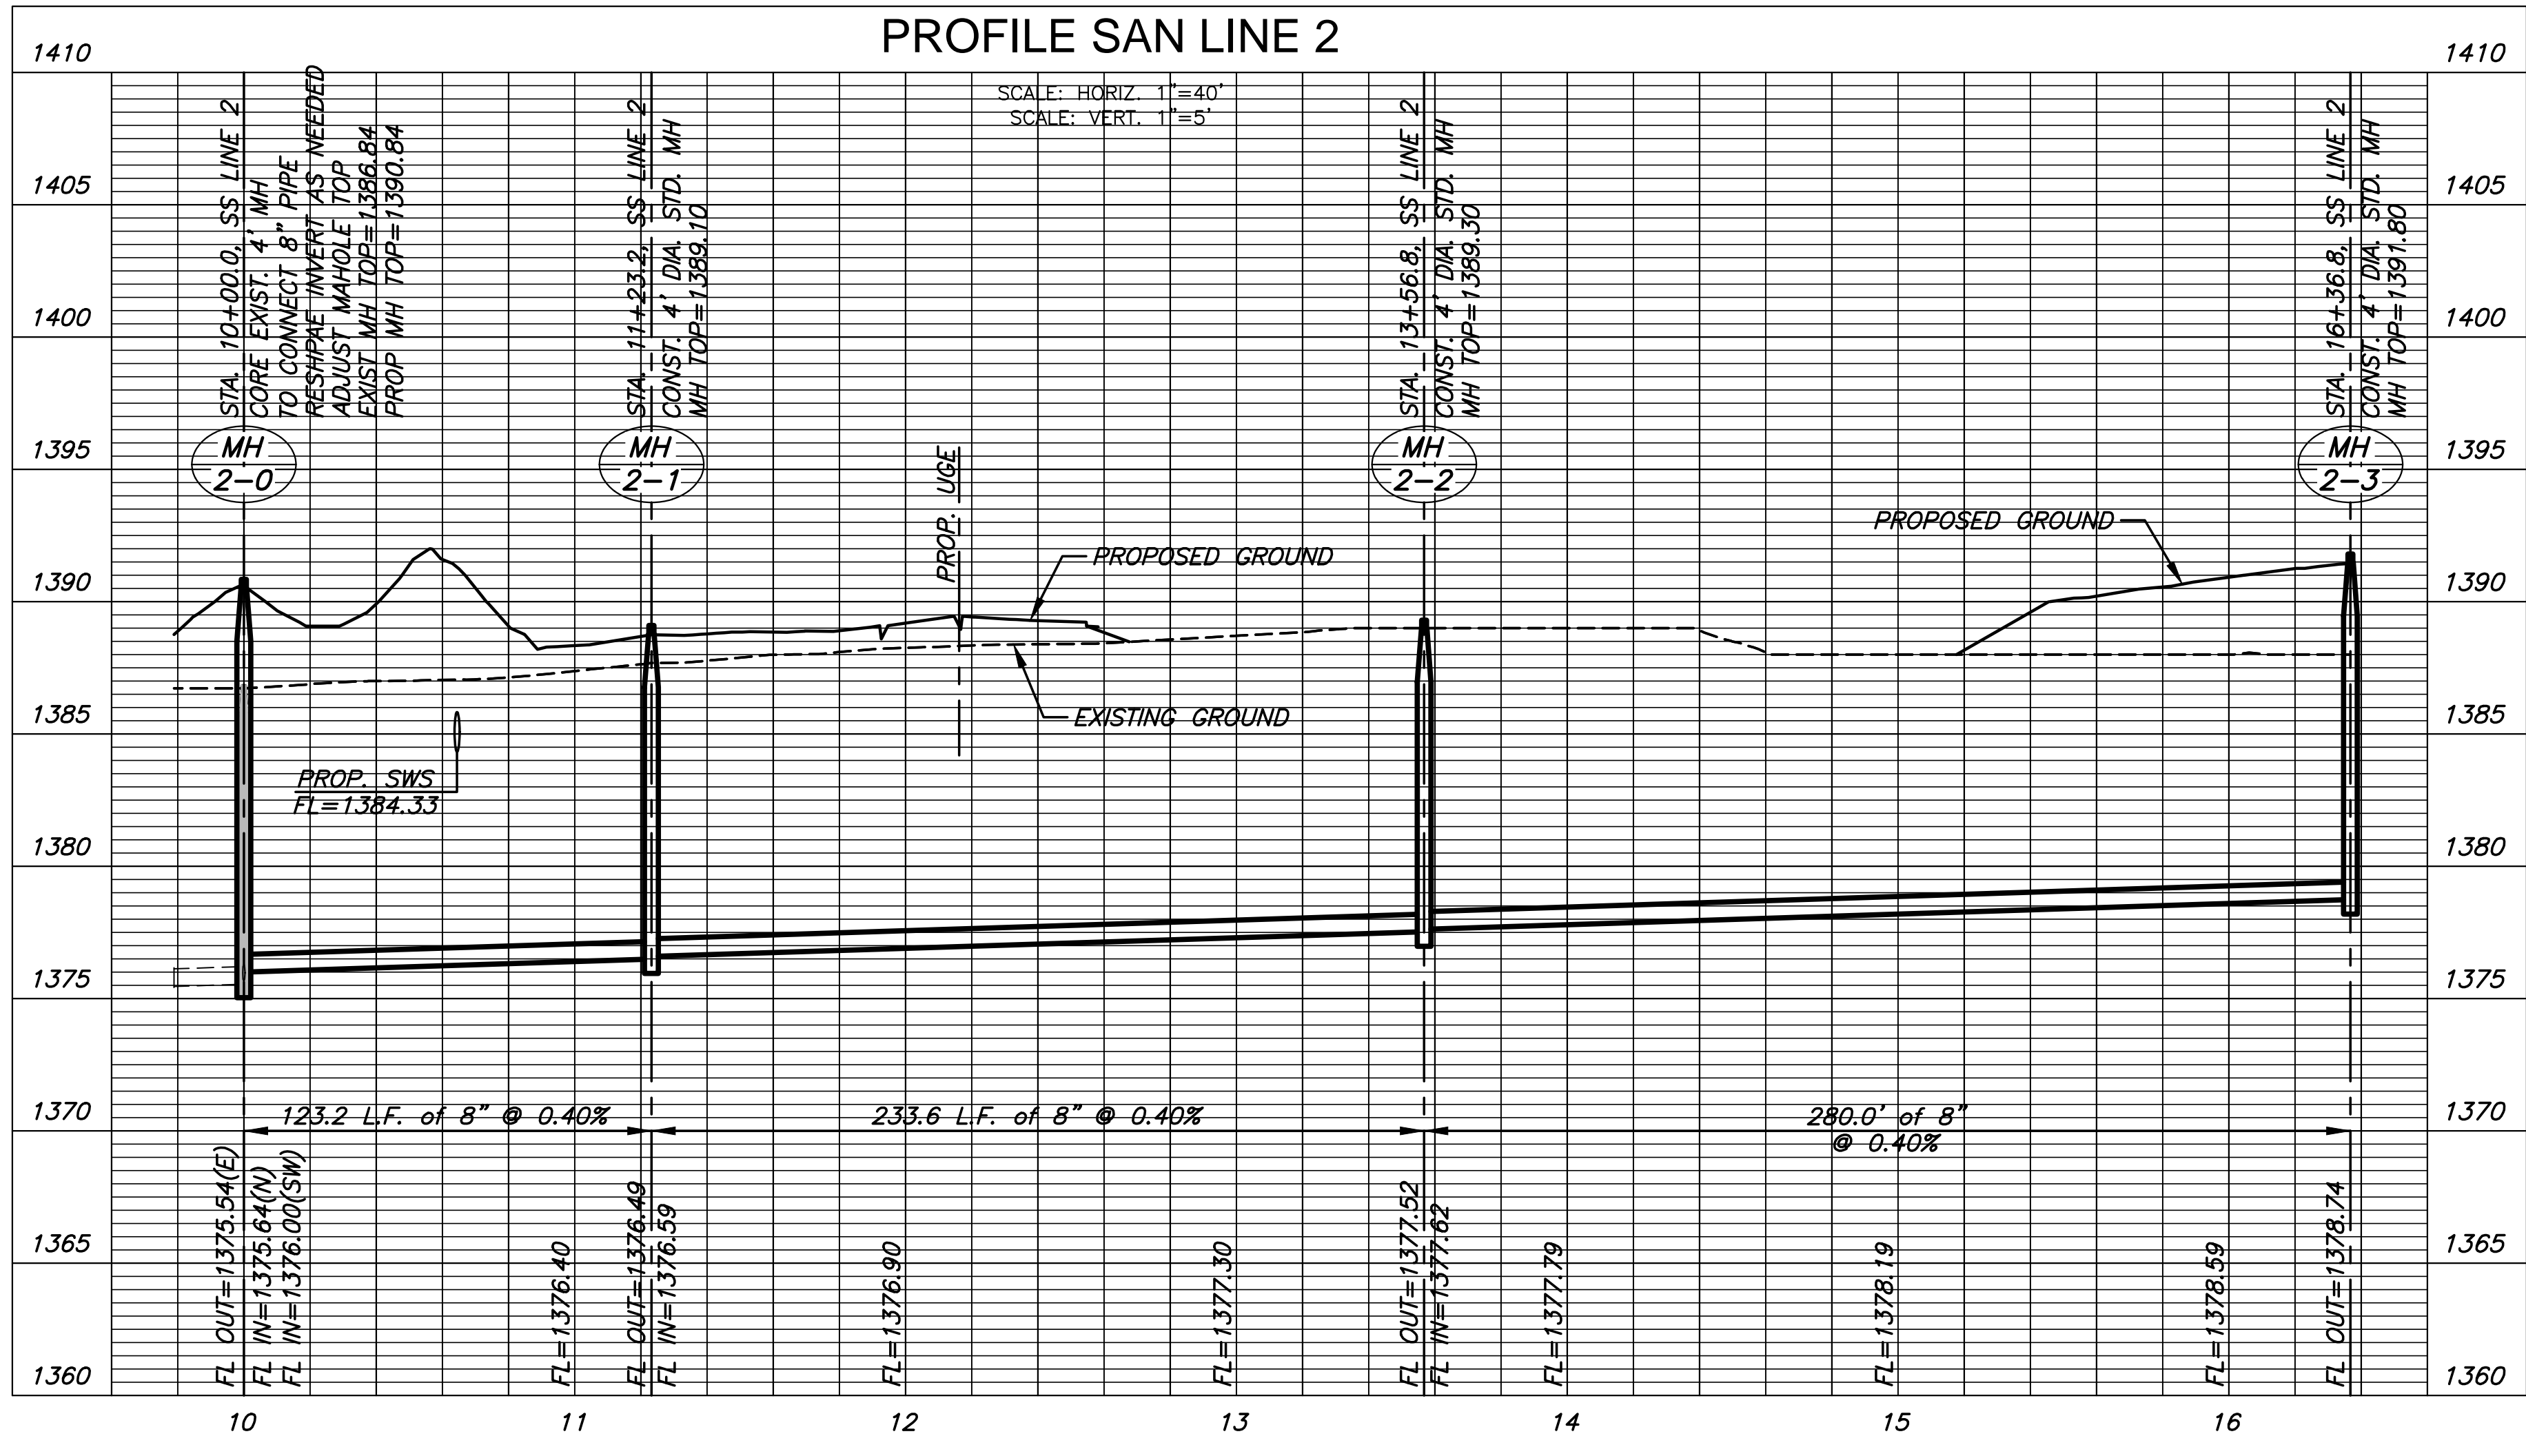

GRADING & UTILITY PLANS FOR
STRYKER SPORTS
 WICHITA, KANSAS



©2018
 MKEC Engineering
 All Rights Reserved
 www.mkec.com
 These drawings and their contents, including, but not limited to, all concepts, designs, & ideas are the exclusive property of MKEC Engineering (MKEC), and may not be used or reproduced in any way without the express consent of MKEC.

SANITARY LINE 2

PROJECT NO.	170567
DATE	01-10-18
SCALE	1"=40'
DESIGNED	MAB
DRAWN	CRM
CHECKED	MAB
ISSUED FOR CONST.	01-10-18
NO.	REVISION
	DATE