

INDEX TO DRAWINGS	
SHEET NO.	DESCRIPTION
G0.0	COVER SHEET
C1.0	EXISTING CONDITIONS
C1.1	SITE-PAVING PLAN
C2.0	GEOMETRY PLAN
C2.1	GRADING AND EROSION CONTROL PLAN
C3.0	PAVEMENT JOINTING PLAN
C3.1	PAVEMENT DETAILS
E0.1	ELECTRICAL LEAD SHEET
E0.2	ELECTRICAL ONE-LINE DIAGRAM - DEMOLITION
E0.3	ELECTRICAL ONE-LINE DIAGRAM - PROPOSED
E1.1	ELECTRICAL DETAILS
E3.1	ELECTRICAL SITE PLAN
E4.1	ELECTRICAL PLAN - DEMOLITION
E4.2	ELECTRICAL PLAN - PROPOSED


37TH STREET PUMP STATION STANDBY POWER GENERATION

C.O.W. PROJECT NO. 448-90903

O.C.A. NO. 633804

CITY OF WICHITA, KANSAS

GARY JANZEN, P.E. - CITY ENGINEER

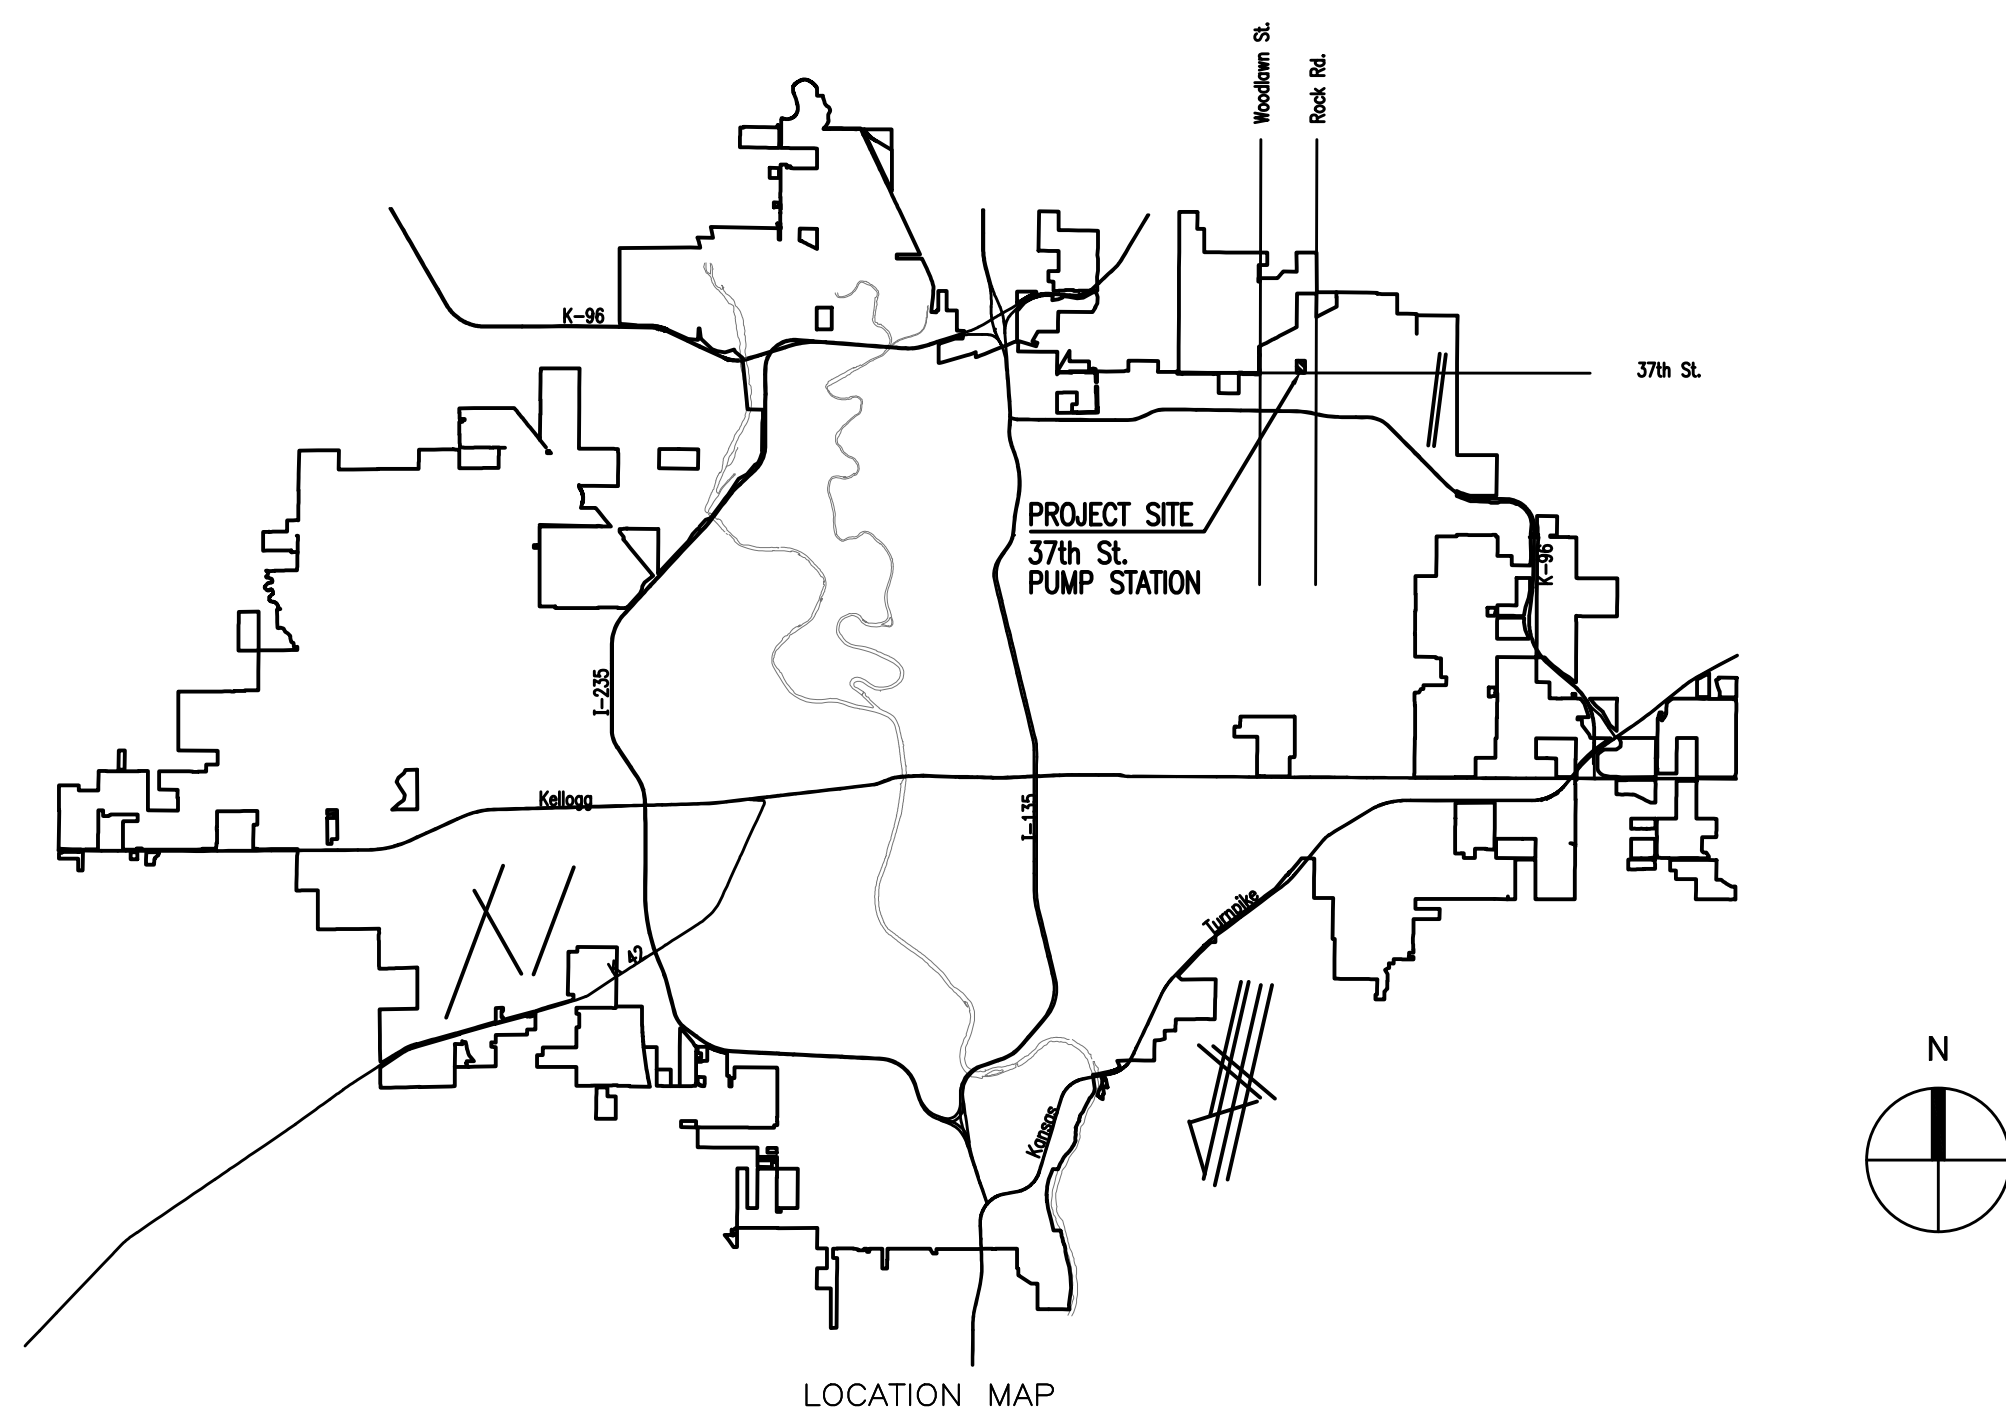

June 2018

PLANS PREPARED BY
PROFESSIONAL ENGINEERING CONSULTANTS, P.A.
ENGINEERS
WICHITA, KANSAS

Saved 06-19-2018 7:59:56 AM by: RWW
 Plot Scale 1:1 06-19-2018 8:00:00 AM by: RWW
 C:\Wichita-Forst\2018\06030\006\Elec\Drawings\06030-006-G0.0 COVER SHEET

	No.	Revision	By	Date	
	PUMP STATION 37TH ST GENERATOR COVER SHEET MIKE JACOBS - SUPERINTENDENT OF PRODUCTION AND PUMPING CITY OF WICHITA PROJECT NO. 448-90903				
		PROFESSIONAL ENGINEERING CONSULTANTS, P.A. 303 SOUTH TOPEKA WICHITA, KS 67202 316-262-2891 www.pec1.com			
Designed by	RWW	Job No.	06030-006	Sht.	G0.0
Drawn by	JBG	Date	June 2018		