


GENERAL ONE-LINE DIAGRAM NOTES:

1. UNLESS OTHERWISE NOTED, ALL CIRCUIT BREAKERS AND/OR SWITCHES ARE THREE POLE.
2. ALL ELECTRICAL EQUIPMENT AND WIRING SHOWN IN A LIGHT LINE, IS EXISTING TO REMAIN.
3. ALL ELECTRICAL EQUIPMENT AND WIRING SHOWN IN A DARK DASHED LINE, IS TO BE REMOVED UNDER THIS CONTRACT.


FEEDER SCHEDULE


DESIG.	EQUIPMENT SERVED	CONDUCTORS			GROUND SIZE PER SET	ISOLATED GROUND SIZE	CONDUIT SIZE PER SET	SPARE CONDUIT
		SETS	NO.	SIZE				
D	EXISTING TO BE REMOVED							
E	EXISTING TO REMAIN							

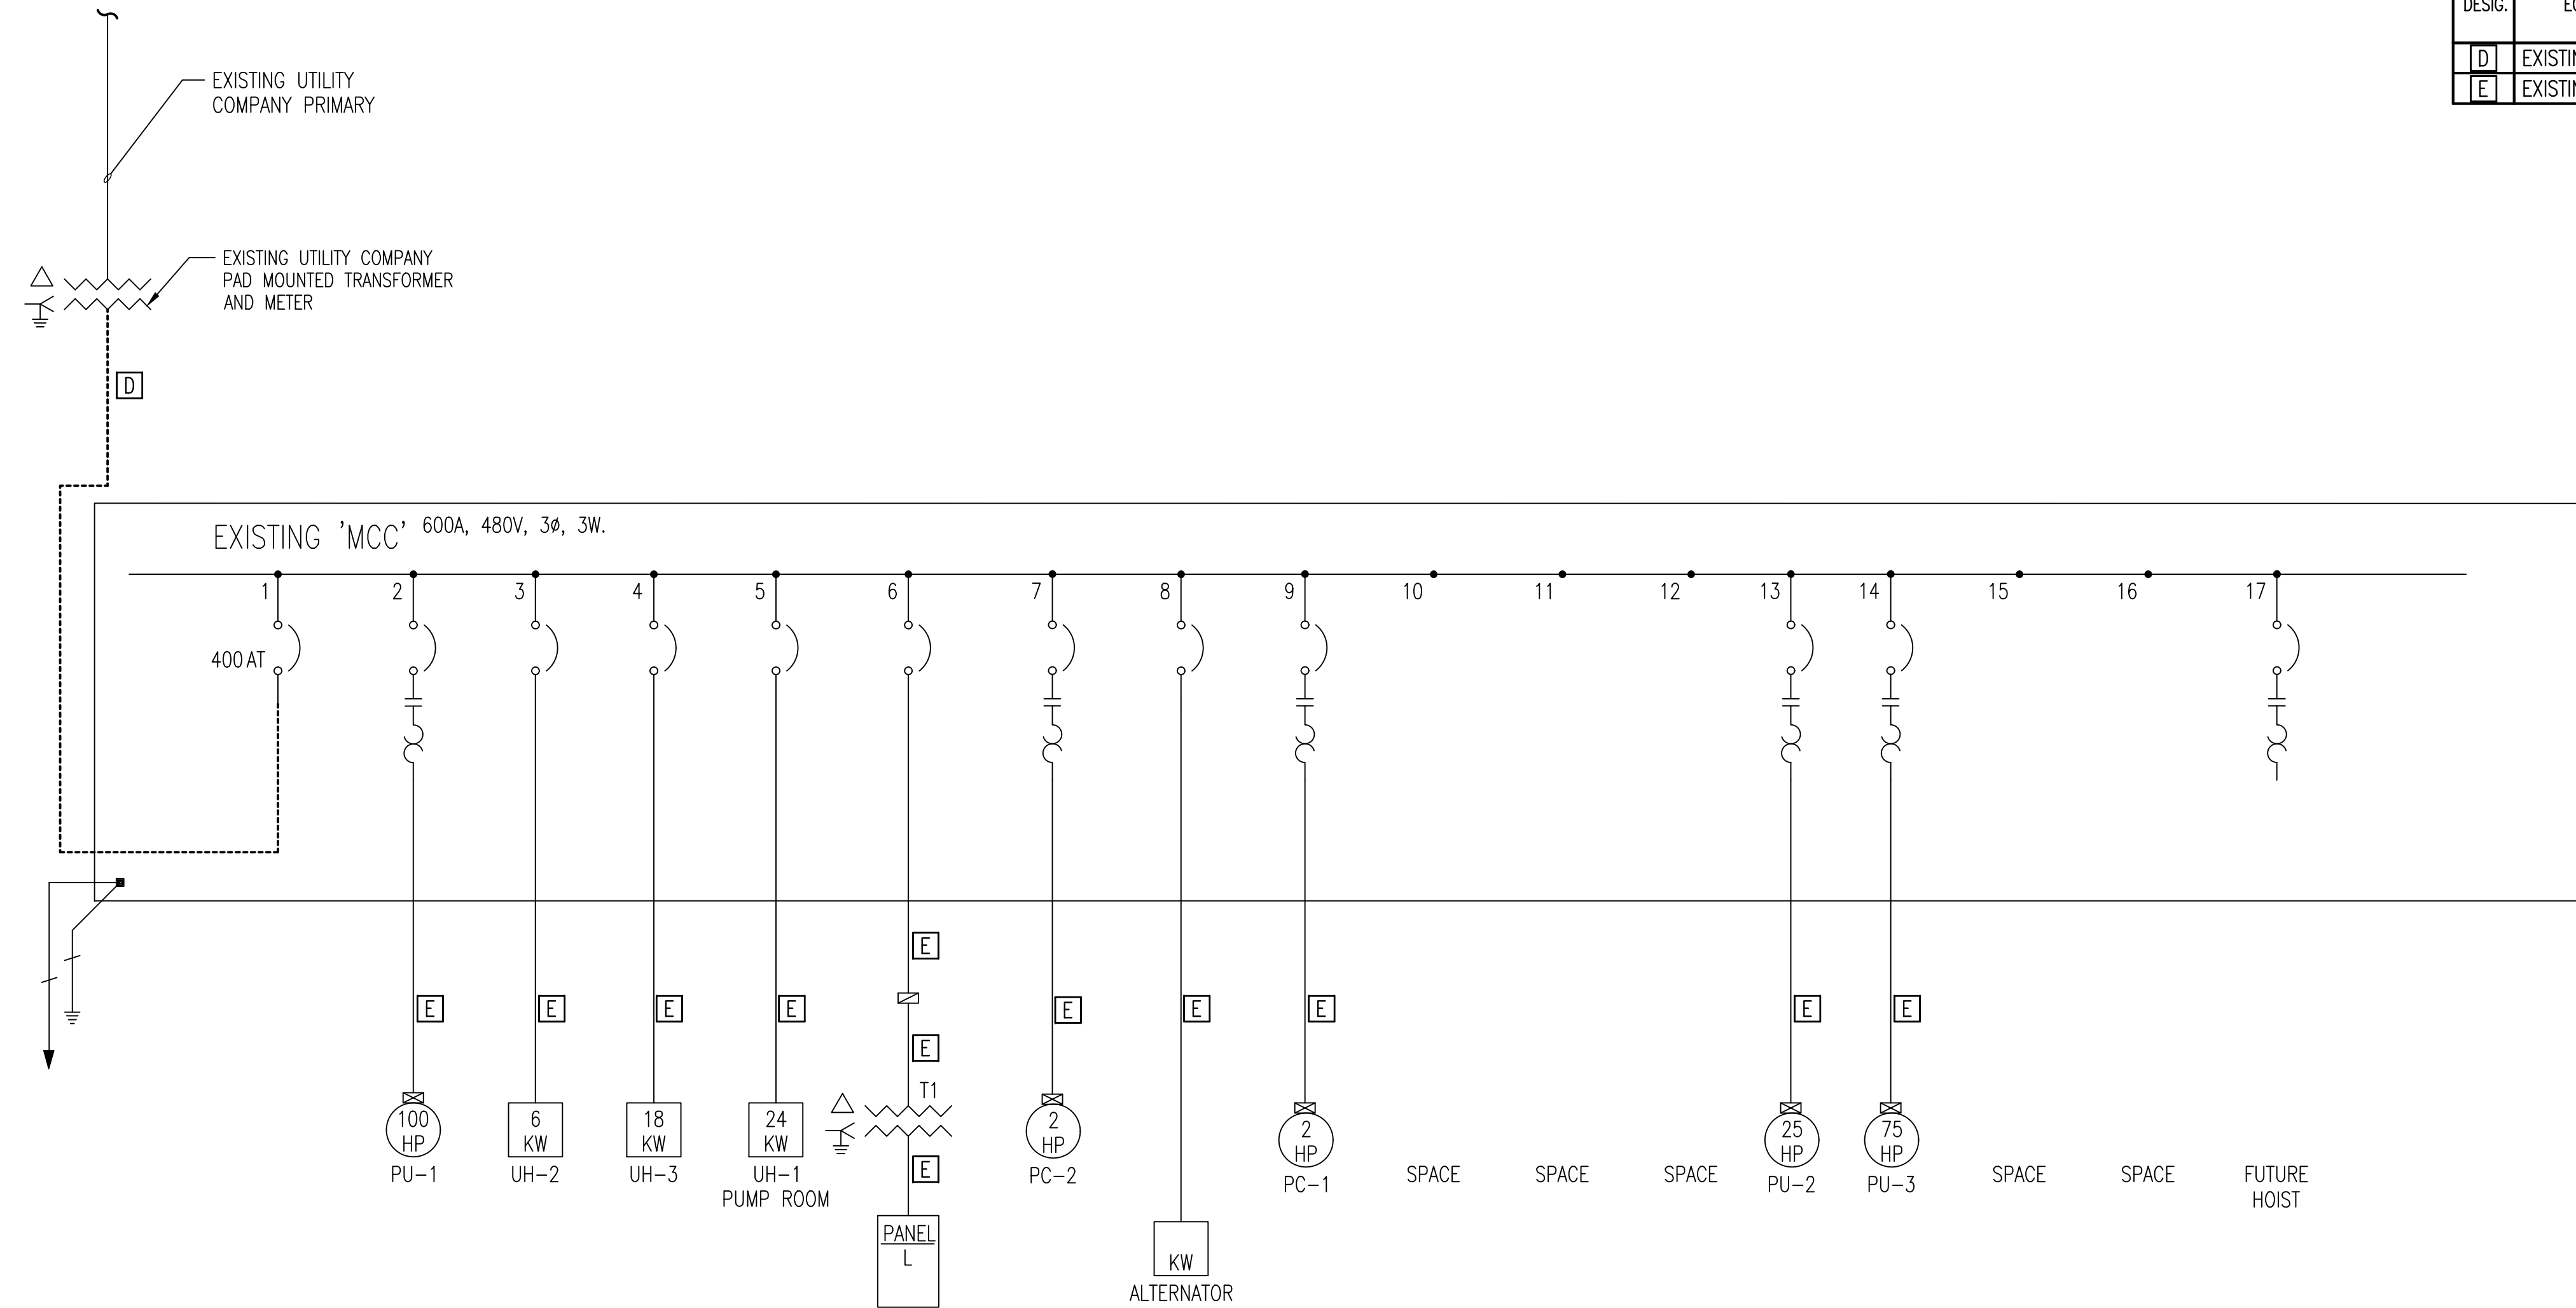

1 ELECTRICAL ONE-LINE DIAGRAM - DEMOLITION
NO SCALE

Saved: 06-14-2018 11:46:39 AM by MICHAEL LEE
 Plot Scale: 1:1 06-19-2018 8:00:45 AM by JMW
 C:\Wichita-Forest\2008\06030\006\Drawings\06030-006-ED.2 ELECTRICAL ONE-LINE DIAGRAM - DEMOLITION

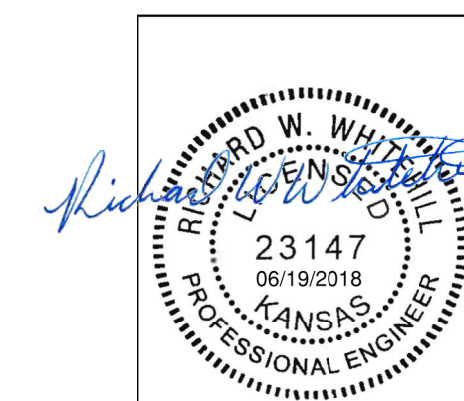

No.	Revision	By	Date
PUMP STATION 37TH ST GENERATOR ELECTRICAL ONE-LINE DIAGRAM - DEMOLITION MIKE JACOBS - SUPERINTENDENT OF PRODUCTION AND PUMPING CITY OF WICHITA PROJECT NO. 448-90903			
 PEC PROFESSIONAL ENGINEERING CONSULTANTS, P.A. 303 SOUTH TOPEKA WICHITA, KS 67202 316-262-2691 www.pec1.com			
Designed by RWW	Job No. 06030-006	Sht. E0.2	
Drawn by JBG	Date June 2018		