 

 
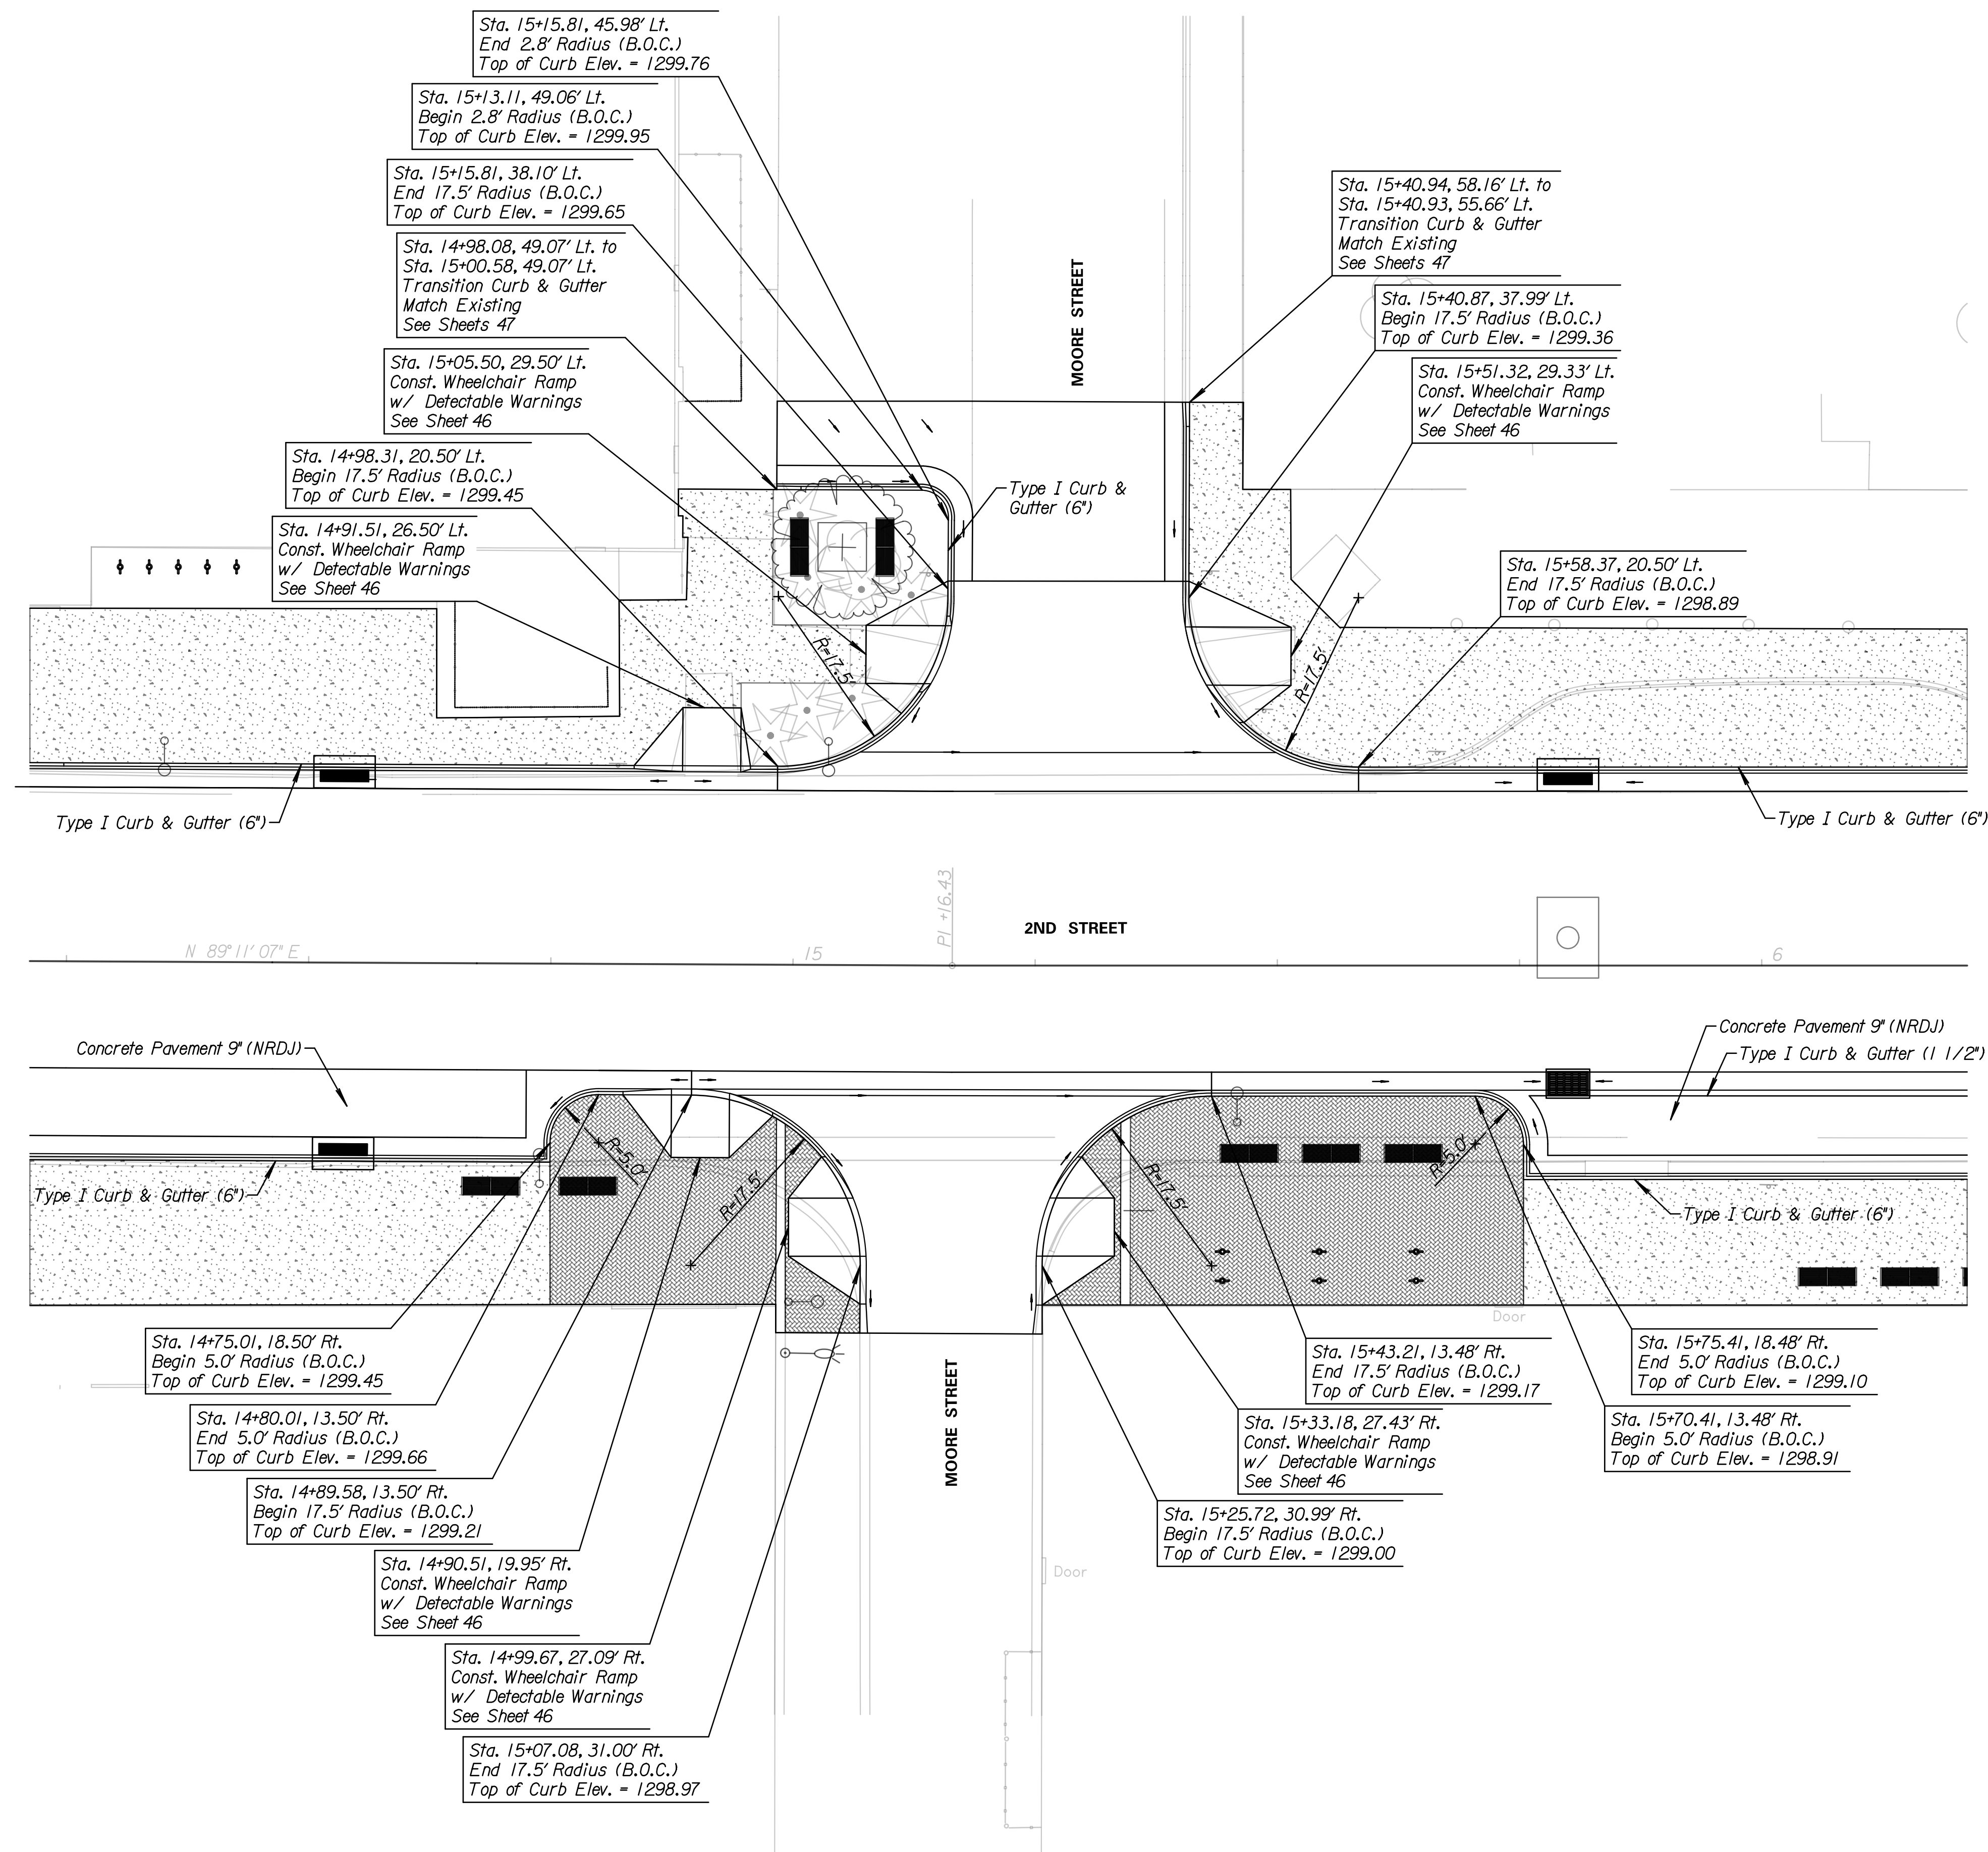
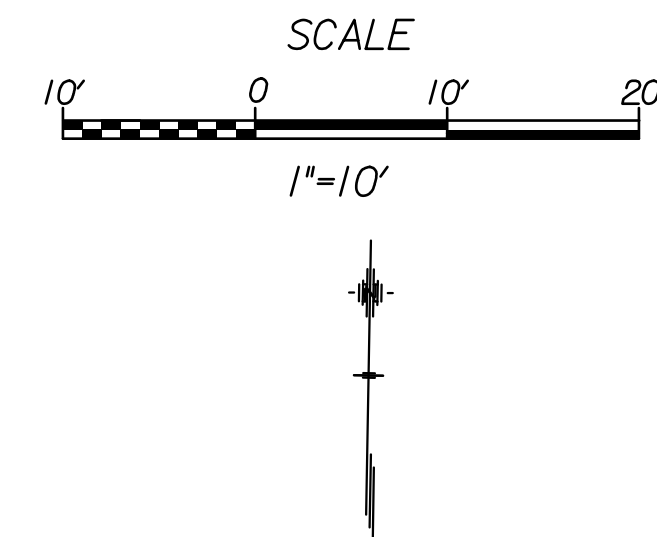


LEGEND

-  4" Concrete Sidewalk
-  Brick Pavers
-  Proposed Water Flow



For more detailed information on landscaping, See Sheets 9-15

For Electrical & Lighting Plans, See Sheets 76-80

**Tran Systems**

245 NORTH WACO  
SUITE 222  
WICHITA, KANSAS 67202  
PHONE: 316-303-3000  
FAX: 316-303-0166

CONSULTANTS:

**LK ARCHITECTURE, INC.**

345 RIVERVIEW  
SUITE 200  
WICHITA, KANSAS 67208  
PHONE: 316-268-0230

2ND STREET IMPROVEMENTS  
SANTA FE TO WASHINGTON IN OLD TOWN  
WICHITA, KANSAS  
**CITY OF WICHITA**

REVISIONS:	MARK	DATE	DESCRIPTION

PROJ NO: 472-85284  
SCALE: 1"=10'  
DATE: 7/11/2018  
DESIGNED BY: TAU  
DRAWN BY: TAU  
CHECKED BY: MDB

SHEET TITLE:  
**2ND STREET & MOORE STREET INTERSECTION LAYOUT DETAILS**

SHEET NO.  
**37**

SHEET 37 OF 103

7/11/2018 11:23:33 PM - c:\tran\systems\new\_local\tran\systems\paw\taummet\0484377\CLAY\M02-107.dgn