


# B SITE ELECTRICAL PLAN

1"=10'-0"

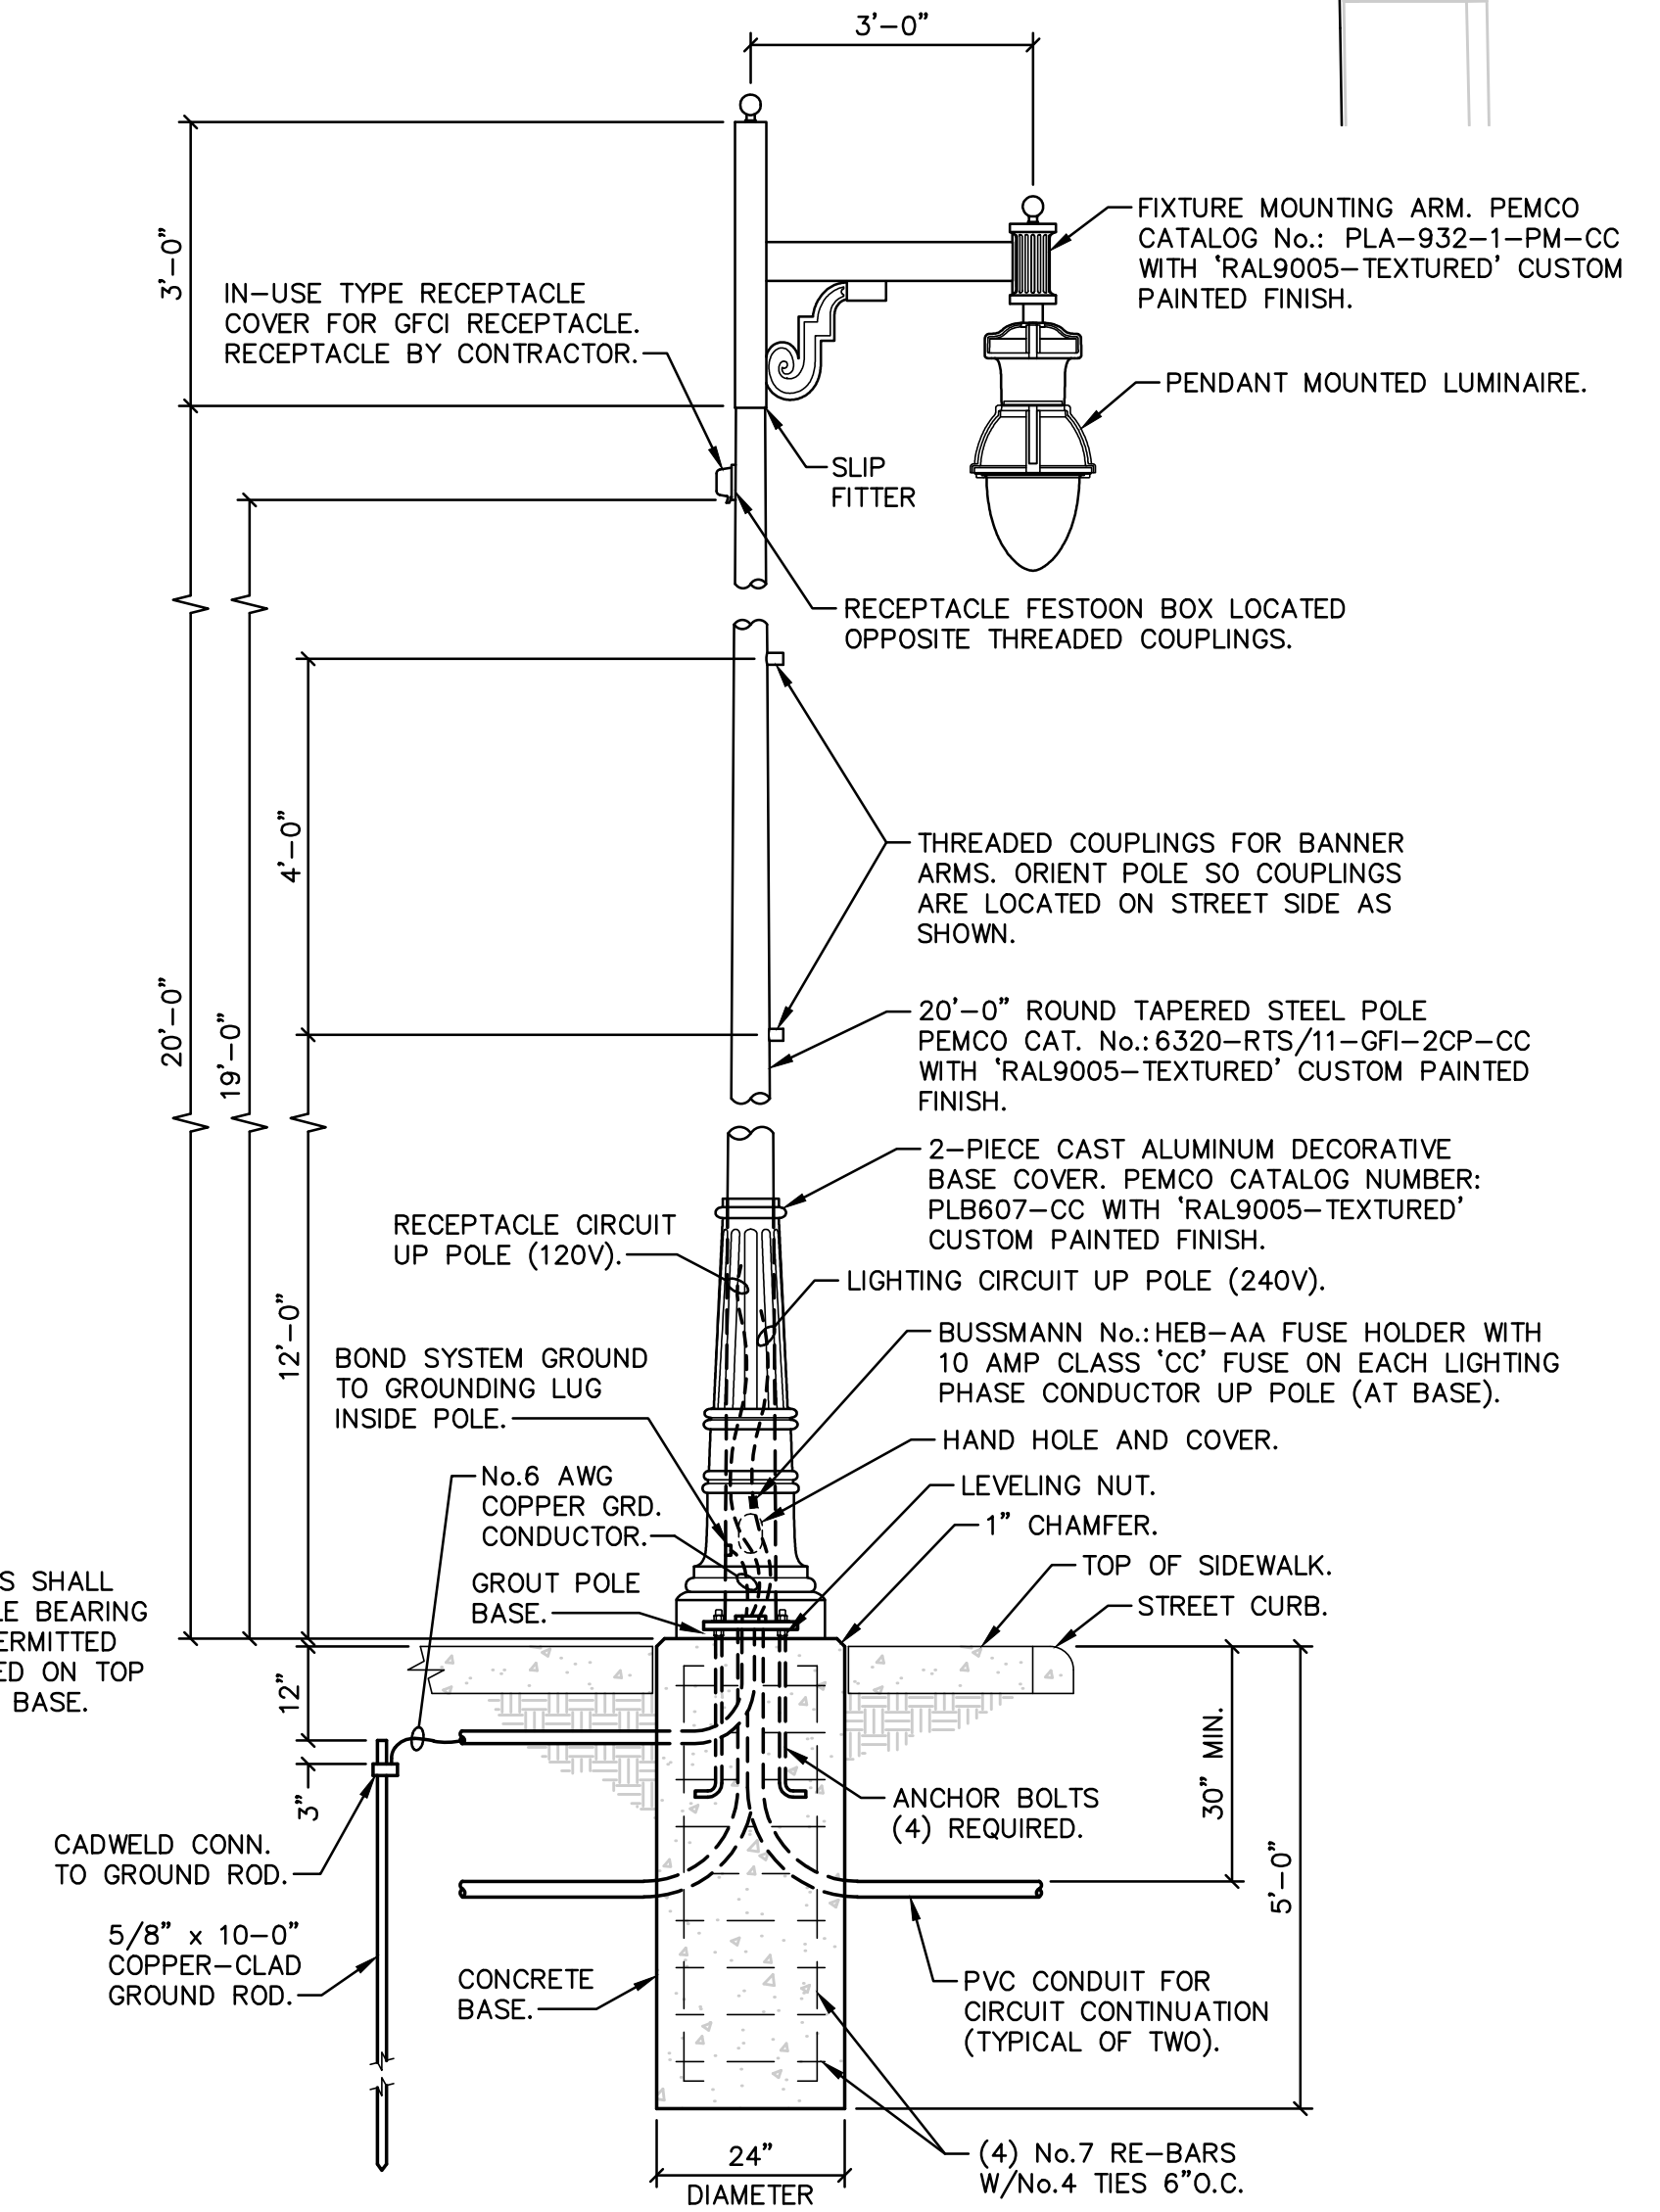

NOTE:  
LEVELING NUTS SHALL  
BE USED. POLE BEARING  
PLATE NOT PERMITTED  
TO BE SHIMMED ON TOP  
OF CONCRETE BASE.

# E LIGHTING POLE "A"

1/2" = 1'-0"

**Tran Systems**  
245 NORTH WACO  
SUITE 222  
WICHITA, KANSAS 67202  
PHONE: 316-303-3000  
FAX: 316-303-0156

CONSULTANTS:  
**LK Architecture, Inc. ©**  
345 NORTH RIVERVIEW ST.  
SUITE 200  
WICHITA, KANSAS 67203  
PHONE: 316-268-0230

2ND STREET IMPROVEMENTS  
SANTA FE TO WASHINGTON IN OLD TOWN  
WICHITA, KANSAS  
CITY OF WICHITA

REVISIONS:	MARK	DATE	DESCRIPTION

PROJ NO: 472-85284  
SCALE: 1" = 10'-0"  
DATE: 07/13/2018  
DESIGNED BY: ST  
DRAWN BY: ST  
CHECKED BY: TL

SHEET TITLE:  
**SITE ELECTRICAL PLAN**

SHEET NO.  
**77**  
SHEET 77 OF 103