


D SITE ELECTRICAL PLAN
 1"=10'-0"

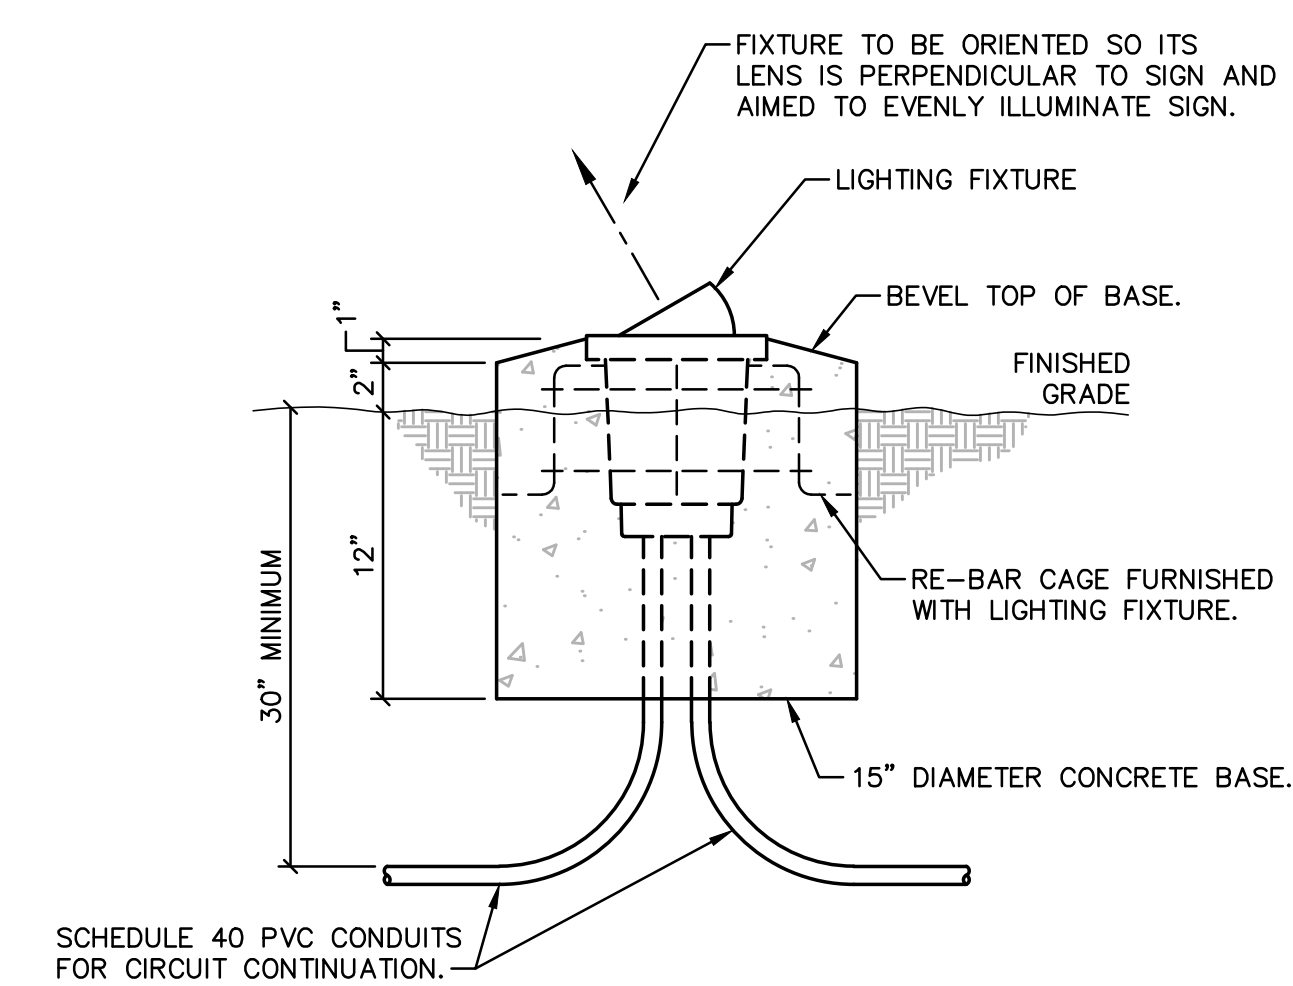

F BASE DETAIL - LIGHTING FIXTURE TYPE "C"
 1-1/2" = 1'-0"

Tran Systems
 245 NORTH WACO
 SUITE 222
 WICHITA, KANSAS 67202
 PHONE: 316-303-3000
 FAX: 316-303-0156

CONSULTANTS:

LK Architecture, Inc. ©
 345 NORTH RIVERVIEW ST.
 SUITE 200
 WICHITA, KANSAS 67203
 PHONE: 316-268-0230

2ND STREET IMPROVEMENTS
 SANTA FE TO WASHINGTON IN OLD TOWN
 WICHITA, KANSAS

REVISIONS:	MARK	DATE	DESCRIPTION

PROJ NO: 472-85284
 SCALE: 1" = 10'-0"
 DATE: 07/13/2018
 DESIGNED BY: ST
 DRAWN BY: ST
 CHECKED BY: TL

SHEET TITLE:
SITE ELECTRICAL PLAN

SHEET NO.
79
 SHEET 79 OF 103