


MABCD REVIEWER:

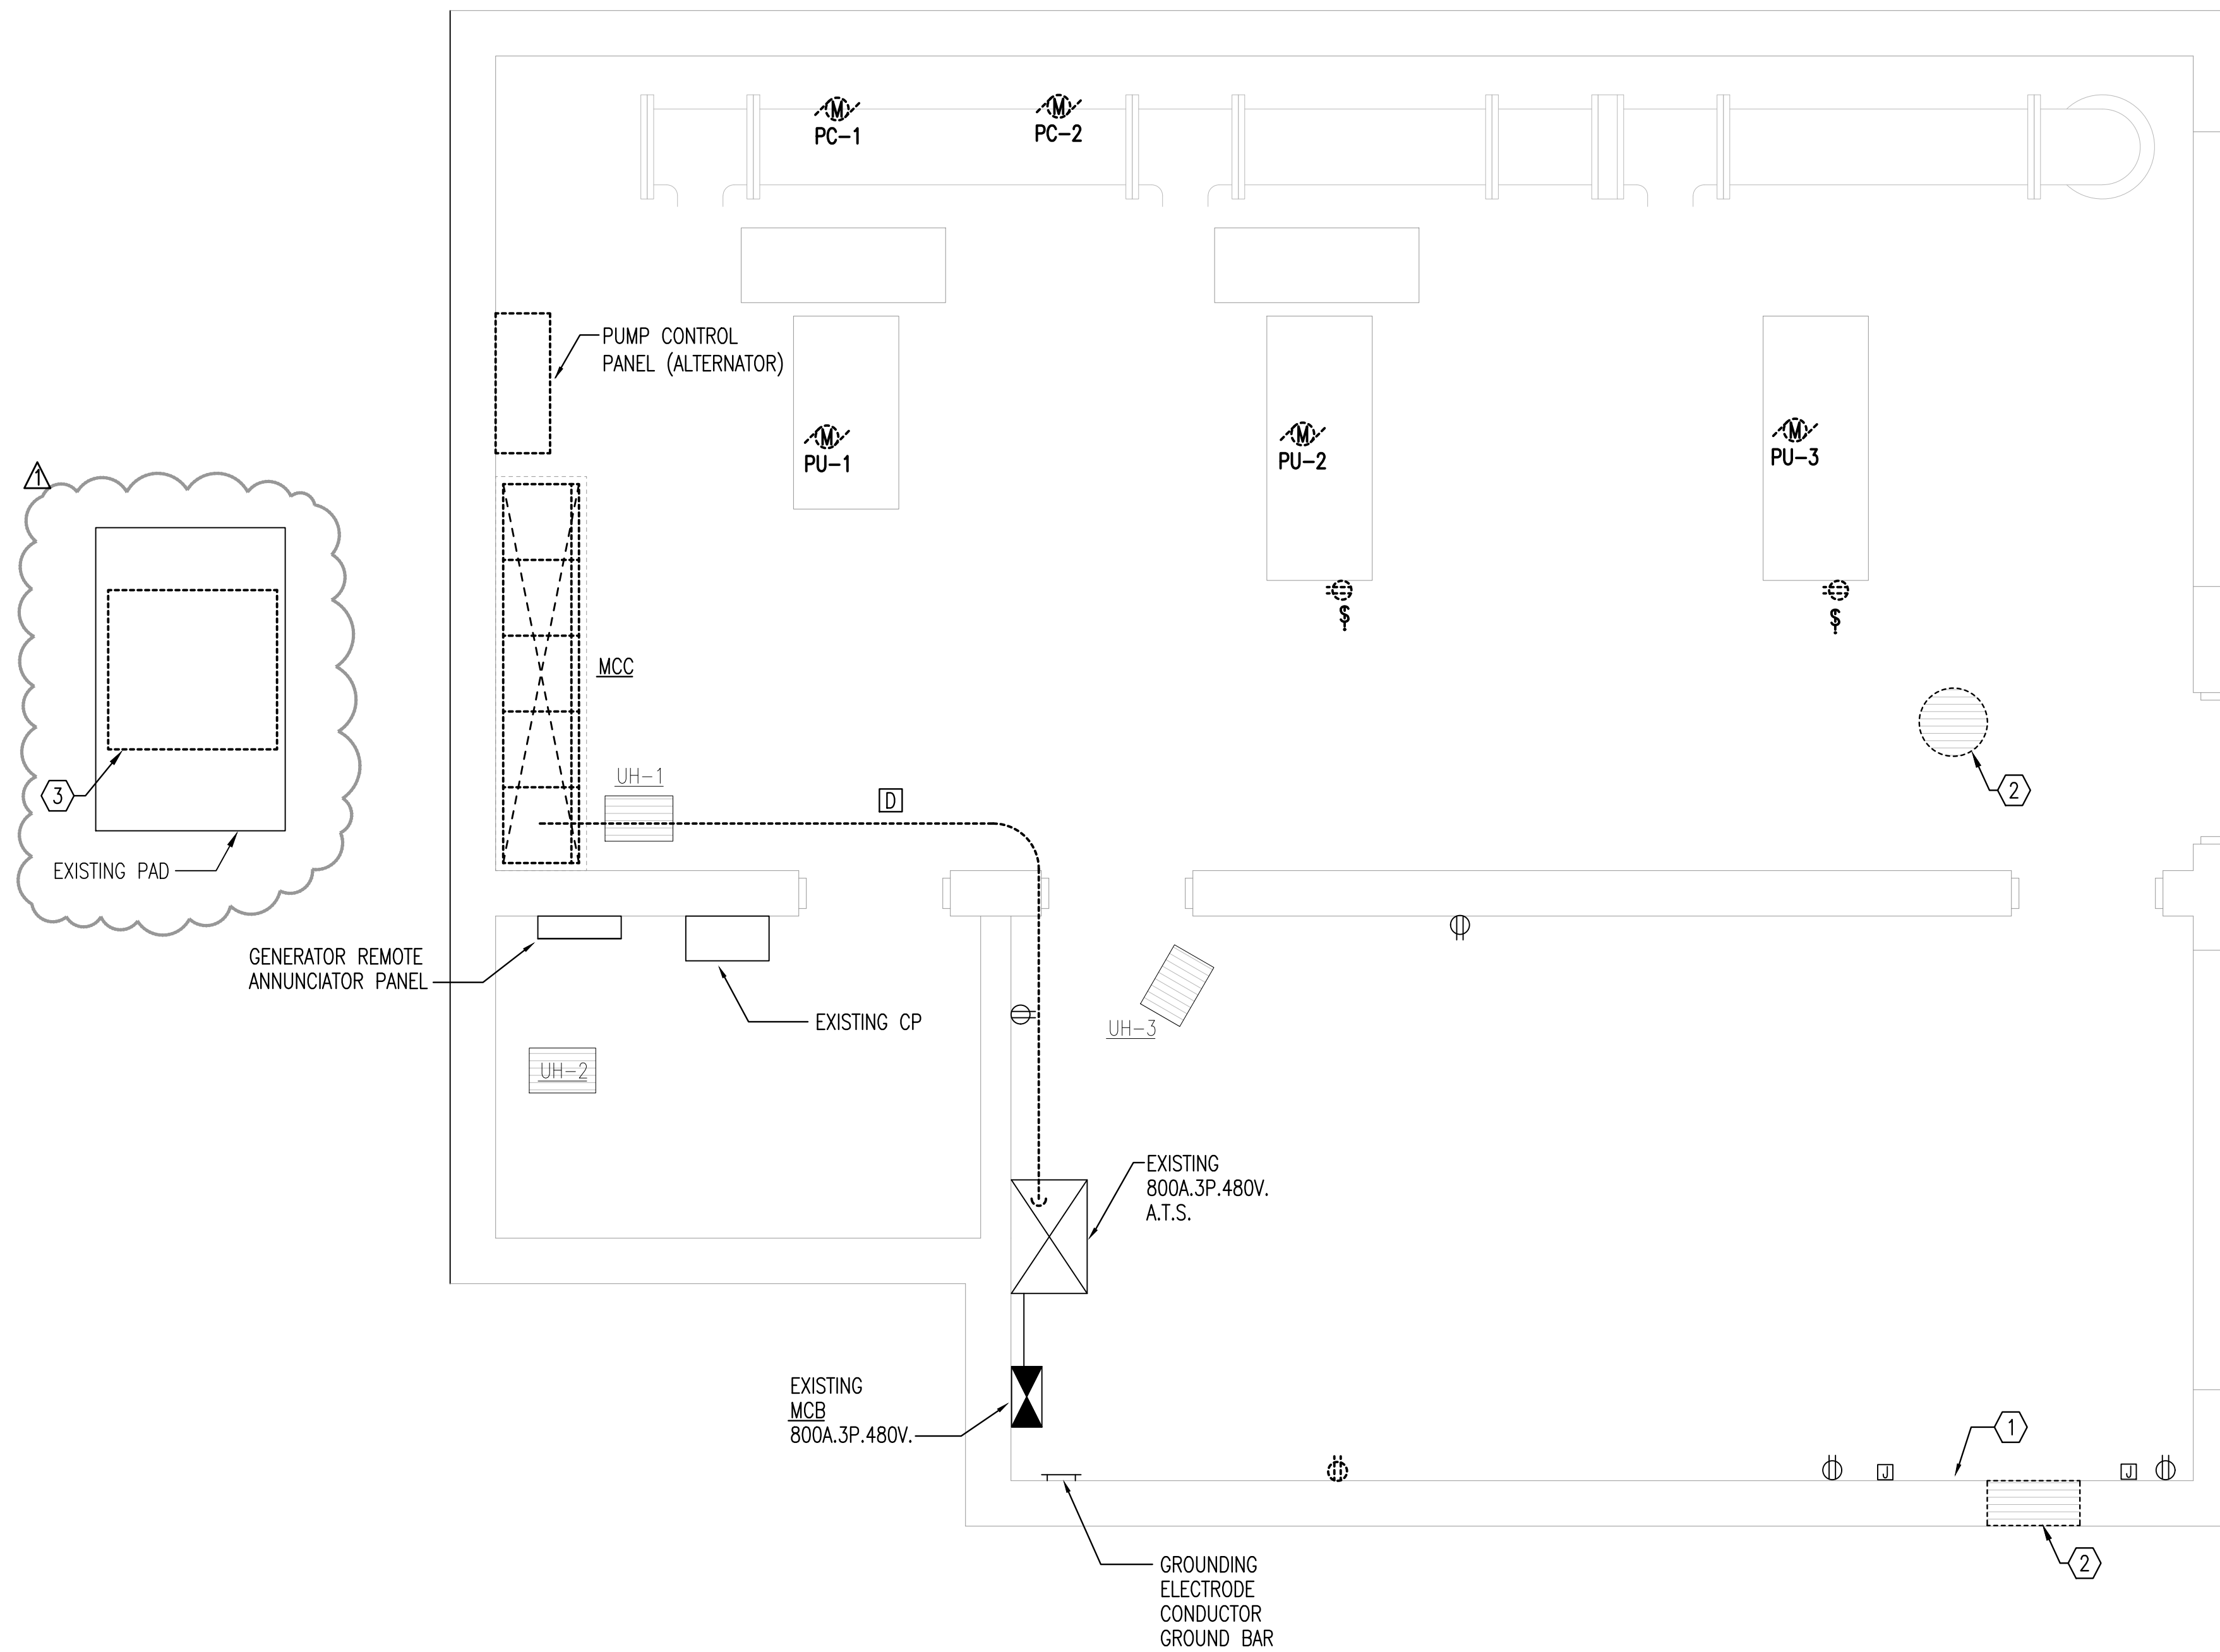

DEMOLITION NOTES:


1. DEMOLITION PLANS SHOW THE GENERAL EXTENT OF THE ELECTRICAL DEMOLITION WORK. THE ELECTRICAL CONTRACTOR SHALL DISCONNECT ELECTRICAL SERVICES TO ALL EQUIPMENT BEING REMOVED, SEE MECHANICAL PLANS. OWNER SHALL HAVE THE OPTION TO RETAIN REUSABLE ITEMS, SUCH AS COVERPLATES, RECEPTACLES, LIGHTS, PANELS, ETC. NOT BEING USED IN THE FINISHED WORK. COORDINATE WITH OWNER PRIOR TO STARTING DEMOLITION. PROPERLY AND LEGALLY DISPOSE OF ALL EQUIPMENT AND MATERIALS BEING REMOVED.
2. GENERAL CONTRACTOR SHALL BE RESPONSIBLE FOR PATCHING ALL OPENINGS IN EXISTING CONSTRUCTION AFTER REMOVAL OF EQUIPMENT AND ELECTRICAL DEVICES, ETC.
3. WHERE EQUIPMENT AND OTHER DEVICES ARE BEING REMOVED, THE CIRCUITING SHALL BE REMOVED, IF POSSIBLE, BACK TO POINT OF SUPPLY. WHERE REQUIRED, CIRCUITING SHALL BE EXTENDED TO MAINTAIN CONTINUITY OF THE CIRCUIT OR OPERATION OF THE SYSTEM.
4. ALL DEVICES SHOWN DASHED ON THE DEMOLITION PLAN(S) SHALL BE REMOVED, UNLESS NOTED OTHERWISE.
5. PROVIDE MATCHING BLANK COVERPLATES WHERE DEVICES ARE BEING REMOVED FROM EXISTING WALLS TO REMAIN.
6. FIELD VERIFY ALL EXISTING CONDITIONS AND DIMENSIONS PRIOR TO BEGINNING WORK.

KEYED NOTES:

- ① EXISTING CHLORINE ANALYZER TO BE RELOCATED. REWORK POWER AND CONTROLS AS REQUIRED.
- ② EXISTING EXHAUST FAN TO BE REMOVED. REMOVE ASSOCIATED POWER AND CONTROLS CONDUIT AND WIRING BACK TO SOURCE.
- ③ EXISTING UTILITY COMPANY PAD MOUNTED TRANSFORMER AND METER TO BE REMOVED. EXISTING PAD AND CONDUCTORS TO REMAIN FOR REUSE.

A ELECTRICAL DEMOLITION PLAN

0' 1' 2' 4' 3/8"=1'-0"

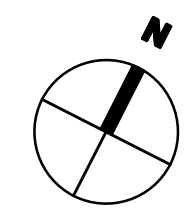

Saved: 04-29-2019 10:47:07 AM by SMS
 Plot Scale: 1:1 05-03-2019 12:53:40 PM by CAD
 U:\Wichita-Civil\2017\170920\000\Elec\Drawings\170920-000 - E2.1 ELECTRICAL DEMOLITION PLAN

| | | | | |
|--|-----------------------|---------------|----|--------------|
| | Issued for Bid | | CL | 4/30/2019 |
| | No. | Revision | By | Date |
| CITY OF WICHITA, KANSAS | | | | |
| ELECTRICAL DEMOLITION PLAN | | | | |
| 37TH STREET BOOSTER PUMP STATION IMPROVEMENTS | | | | |
| PEC PROFESSIONAL ENGINEERING CONSULTANTS, P.A. 303 SOUTH TOPEKA WICHITA, KS 67202 316-262-2891 www.pec1.com | | | | |
| Designed by RWW | Job No. 34-170920-000 | Date | | Sht. E2.1 of |
| Drawn by MAL | Date | DECEMBER 2018 | | |