



J:\PROJECTS\2016\1601010151_MT_VERNON AND HILLSIDE_160151_CADD\SHOTS\05_CIVIL\TRAFFIC\16151-TRP3.DWG
 PLOTTED: Tuesday, April 16, 2018 @ 04:05PM

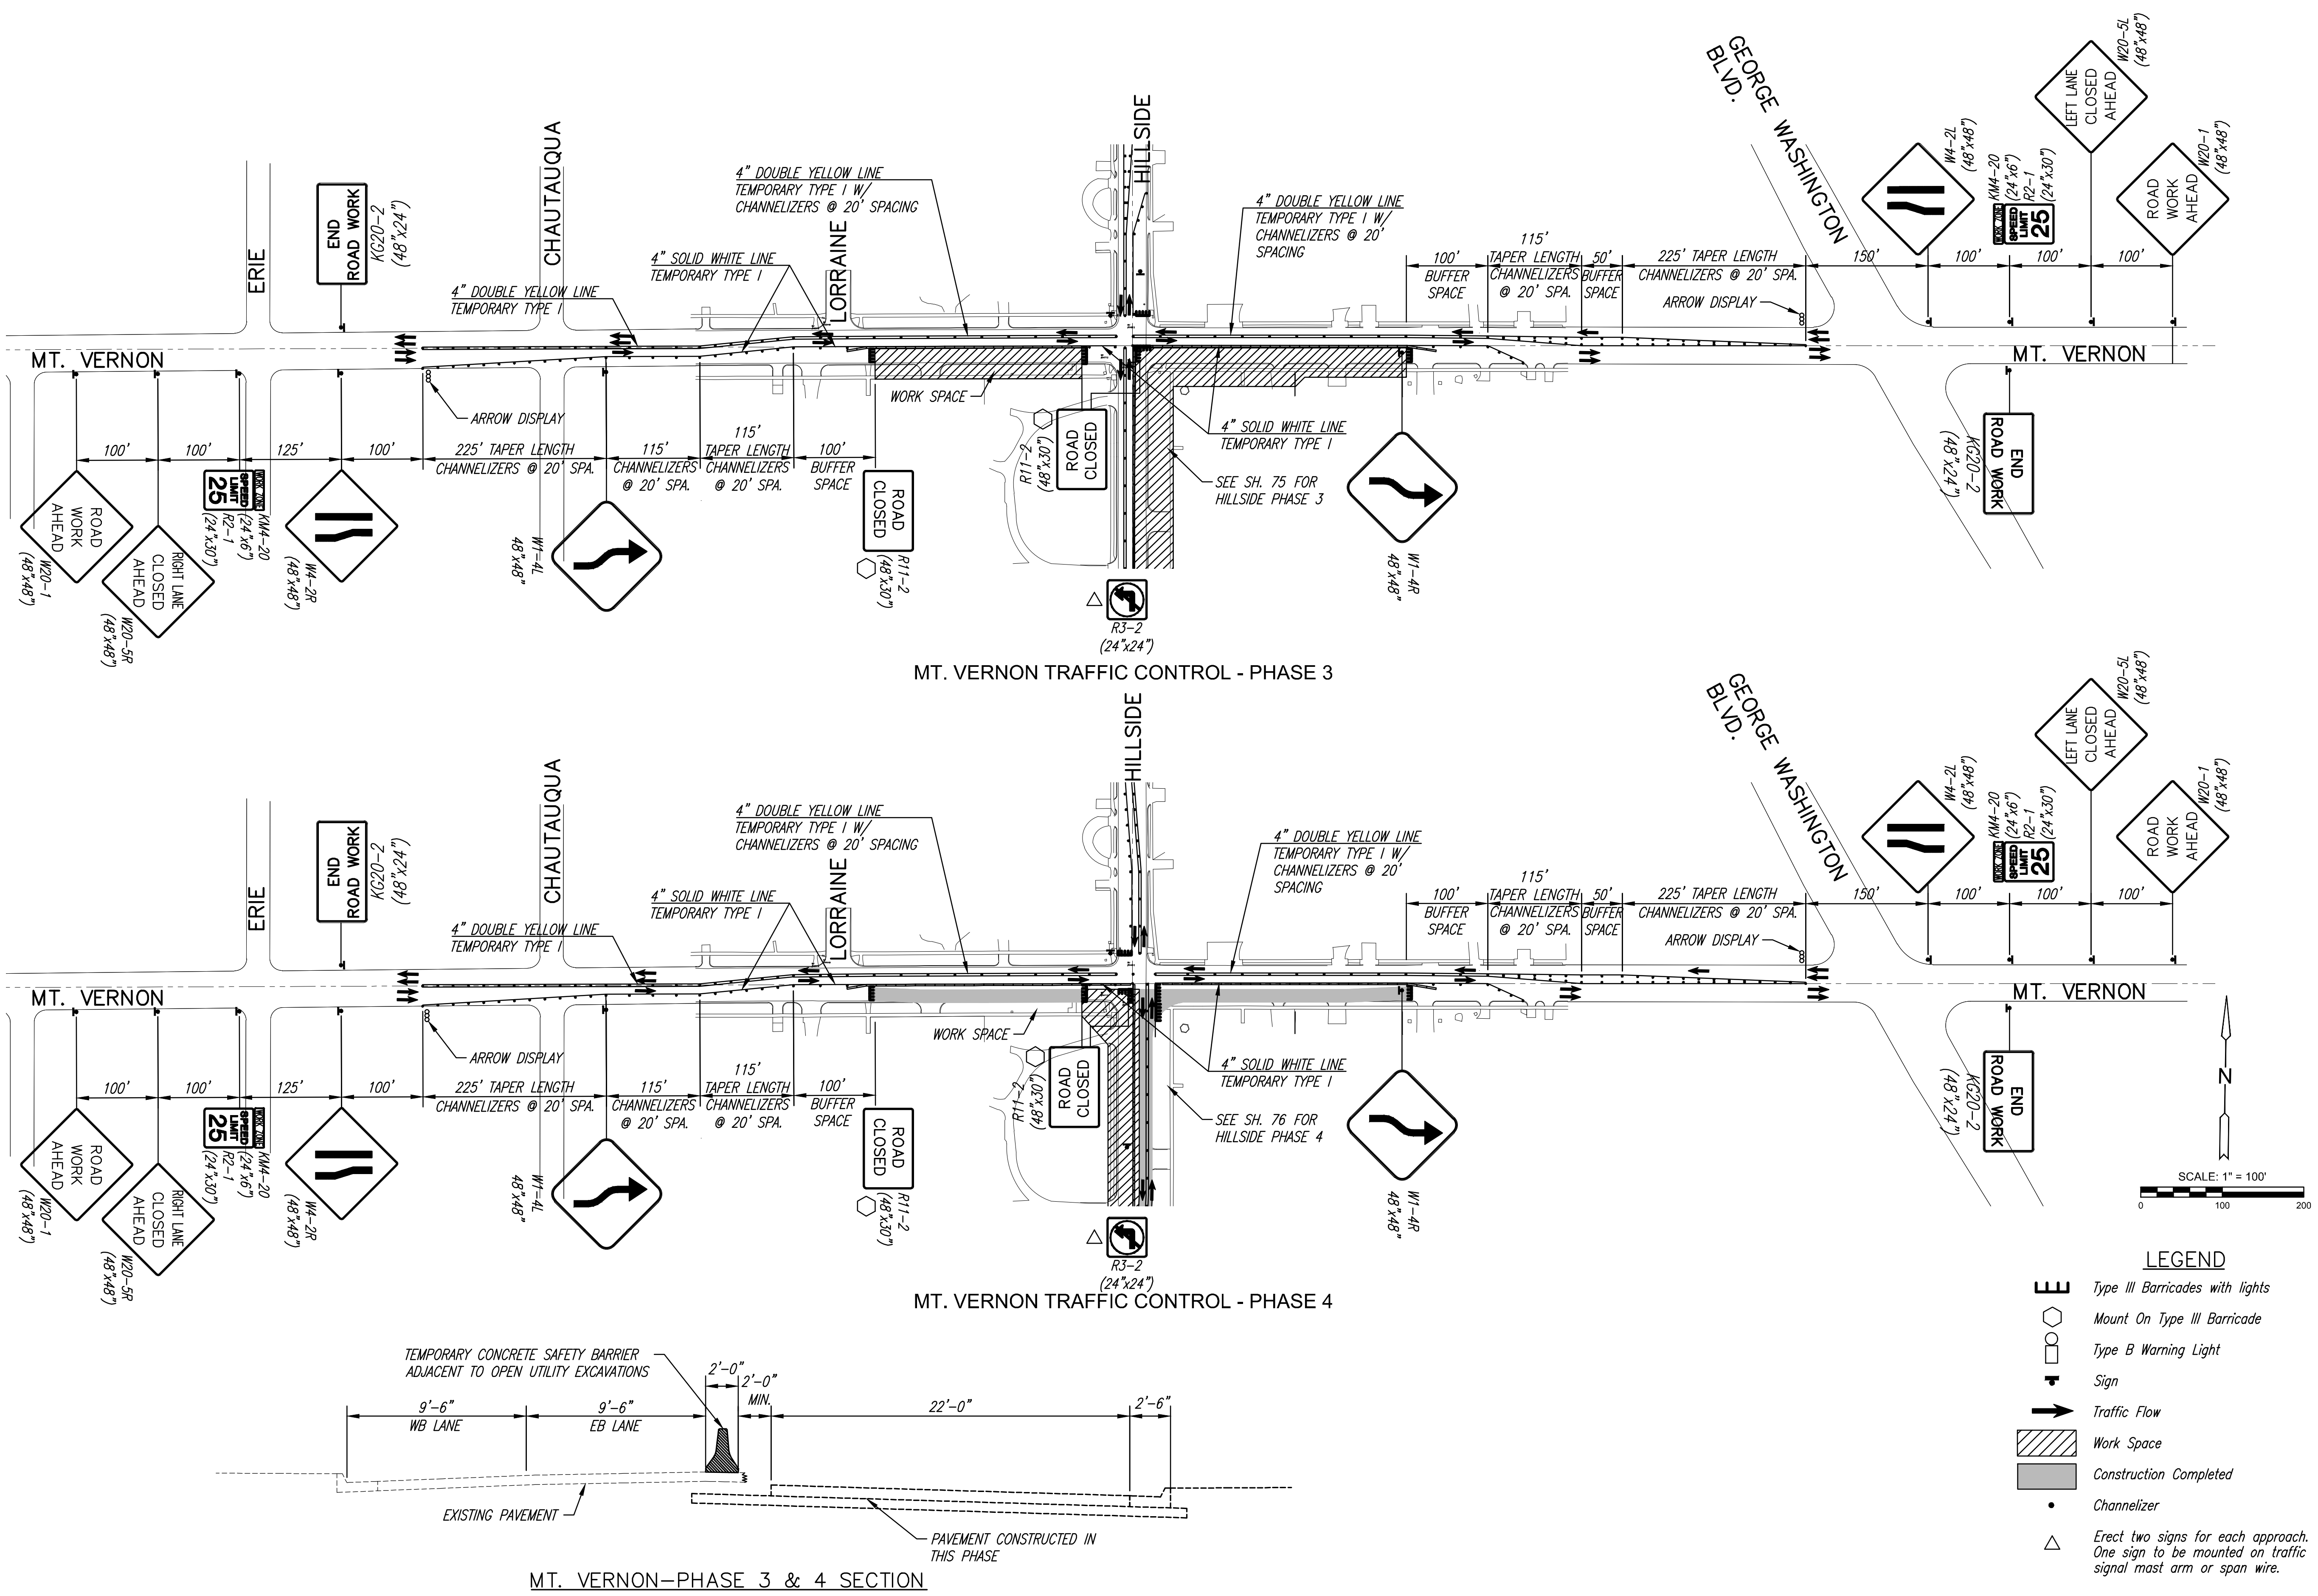

- LEGEND**
- Type III Barricades with lights
 - Mount On Type III Barricade
 - Type B Warning Light
 - Sign
 - Traffic Flow
 - Work Space
 - Construction Completed
 - Channelizer
 - Erect two signs for each approach. One sign to be mounted on traffic signal mast arm or span wire.

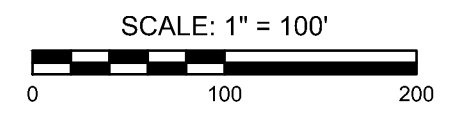

STREET IMPROVEMENTS FOR
MT. VERNON & HILLSIDE INTERSECTION
 PAVING PLANS

©2019 MKEC Engineering All Rights Reserved
 These drawings and their contents, including, but not limited to, all concepts, designs, & ideas are the exclusive property of MKEC Engineering (MKEC), and may not be used or reproduced in any way without the express consent of MKEC.

TRAFFIC CONTROL PLAN, PHASE 3 & 4 MT. VERNON

PROJECT NO.	472-85286	
DATE	DATE	
SCALE	1"=100'	
DESIGNED	DRAWN	CHECKED
JRA	WNJ	JRA
NO.	REVISION	DATE