
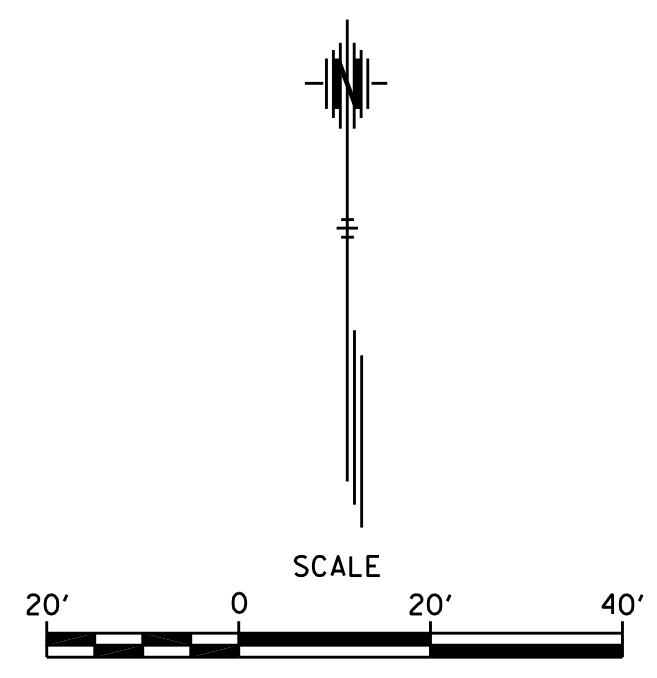


Plotted : 10/3/2019 2:16:21 PM File : T:\35838A-COW_HarryStBridge\Cadd\Sheets\Traffic\838LICHT01.dgn

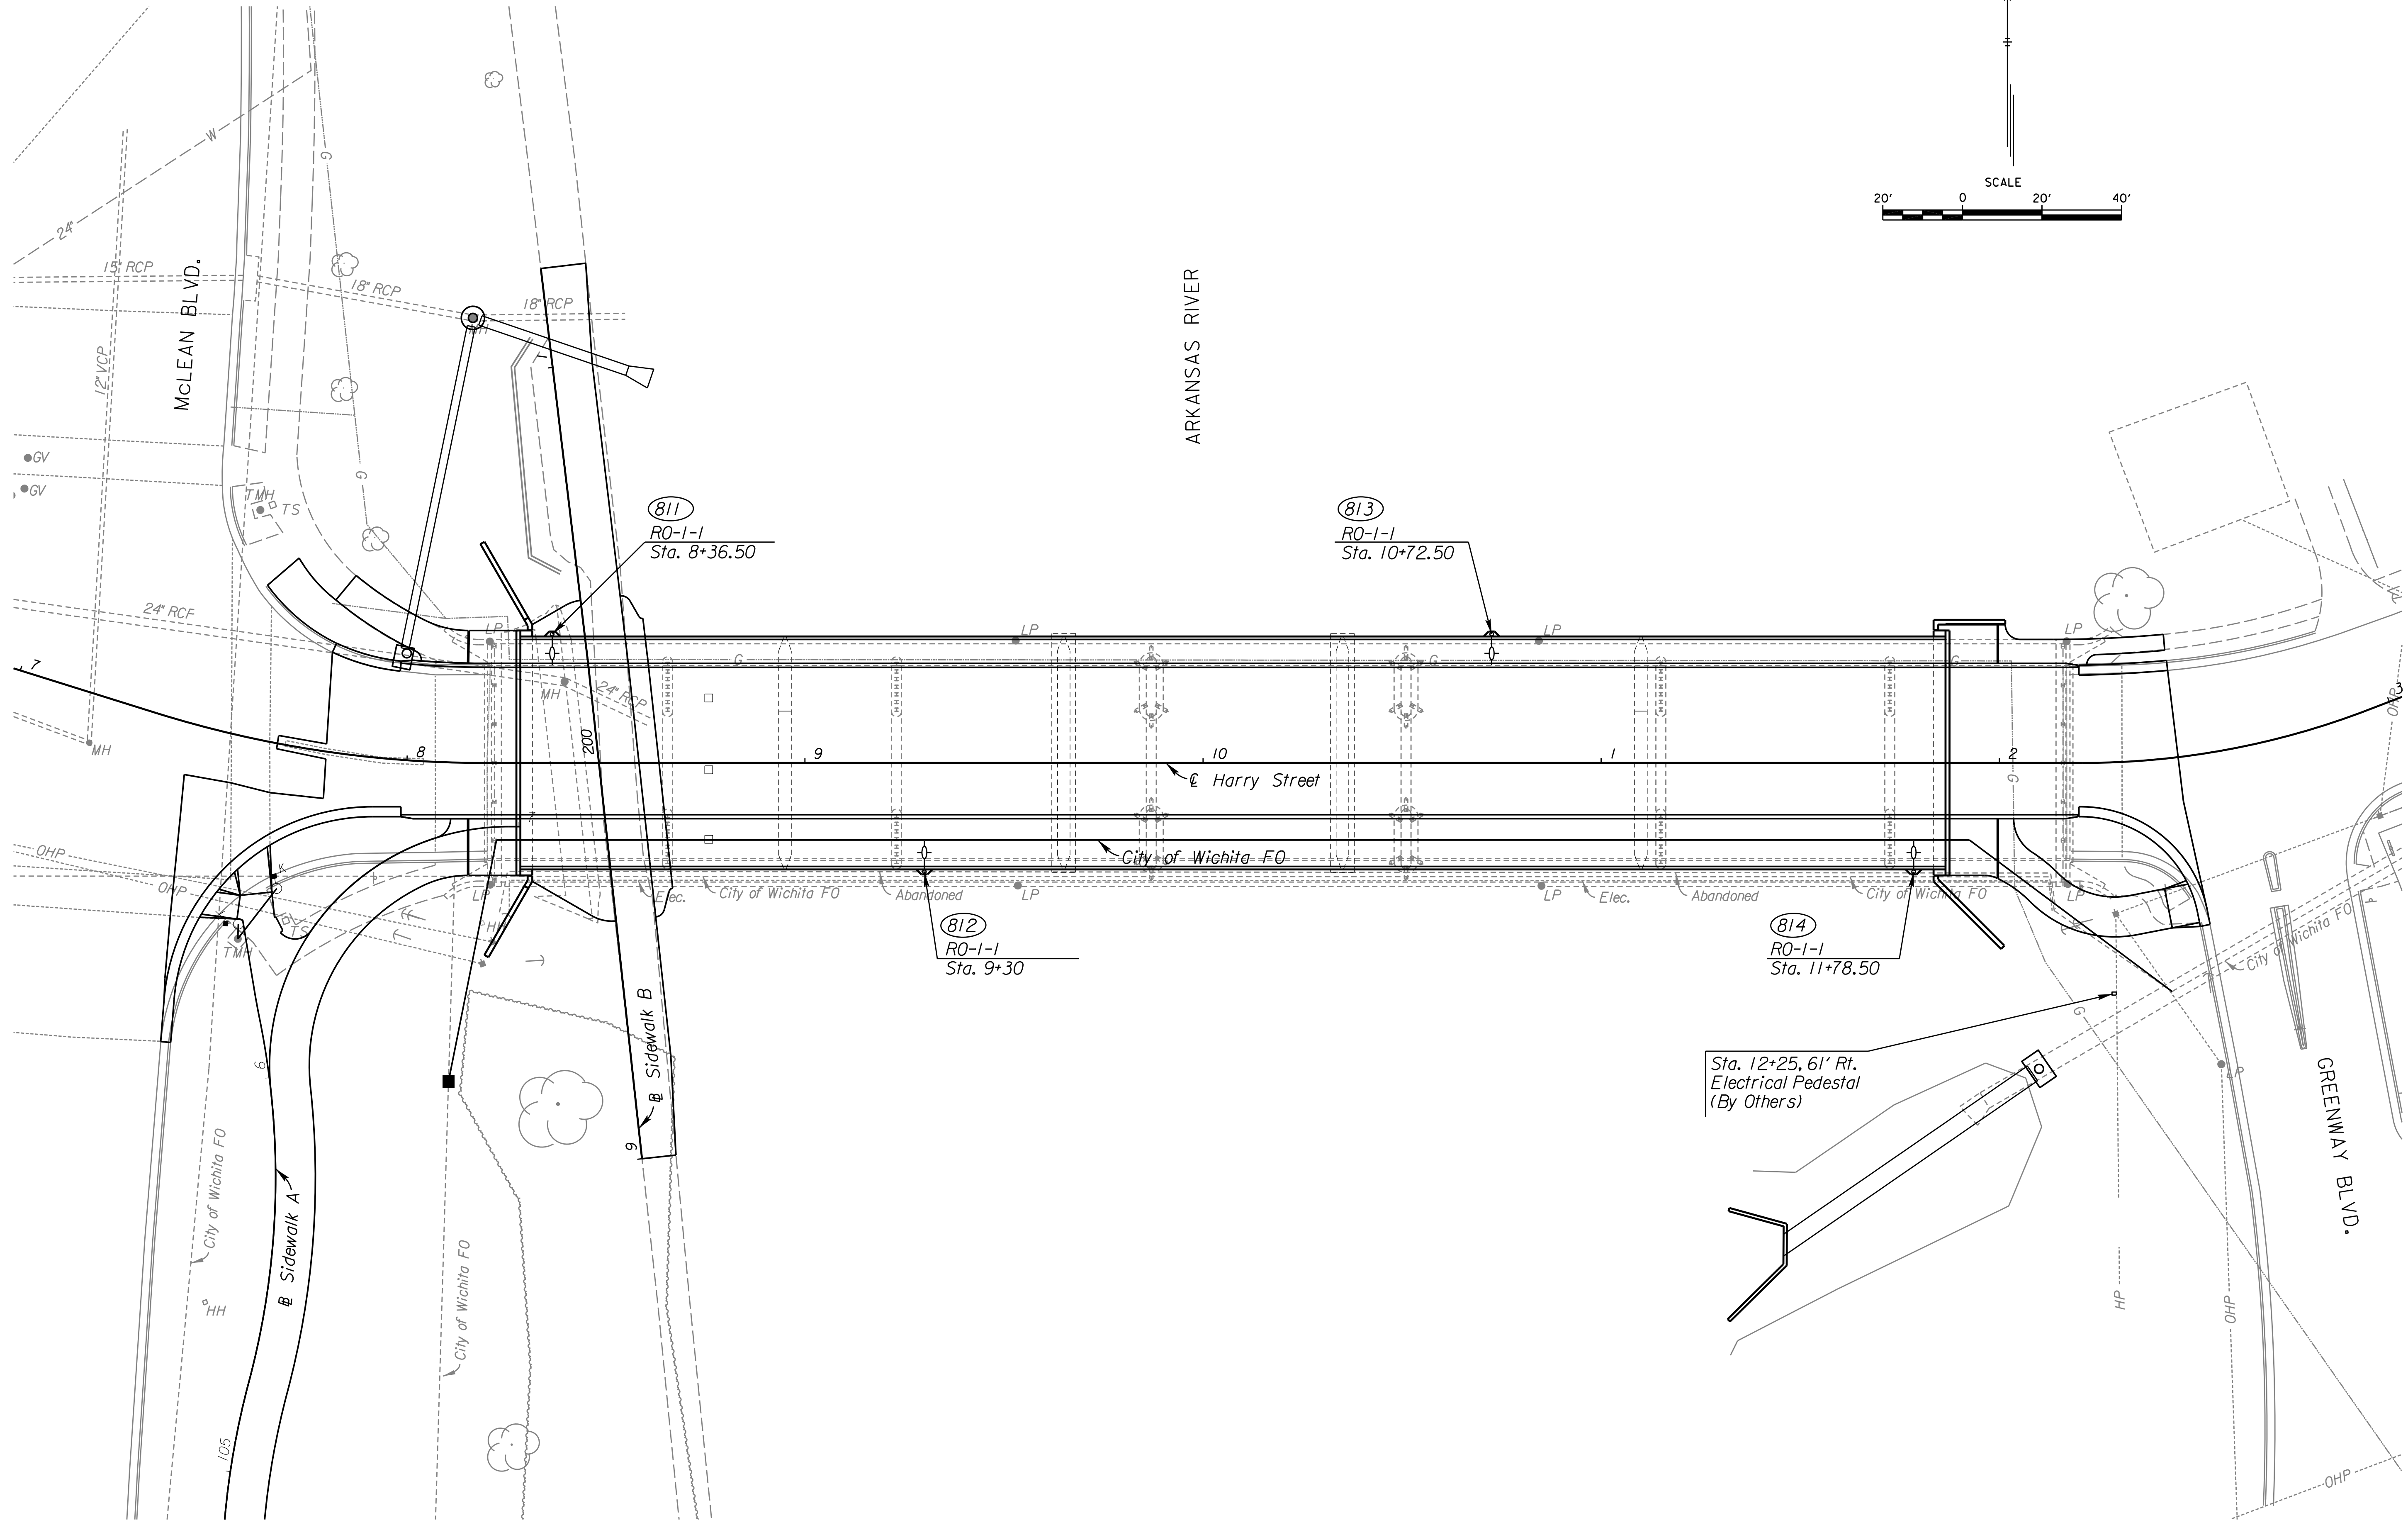

**HARRY STREET BRIDGE
OVER ARKANSAS RIVER
LIGHTING PLAN**

NO.	DATE	DESCRIPTION

PROJ NO: 35838B
 SCALE: AS NOTED
 DATE: . . .
 DESIGNED BY: . . .
 DRAWN BY: . . .
 CHECKED BY: . . .
 YEAR: 2019
 SHEET NO
95
 SHEET 95 OF 135