


# CONSTRUCTION PLANS FOR 2020 HESS PUMP STATION DEHUMIDIFIER REPLACEMENT CITY OF WICHITA, KANSAS

SEDGWICK COUNTY, KANSAS  
CITY OF WICHITA PROJECT NO. 448-2019-015906  
OCA NO. 639015  
GARY JANZEN, P.E., CITY ENGINEER

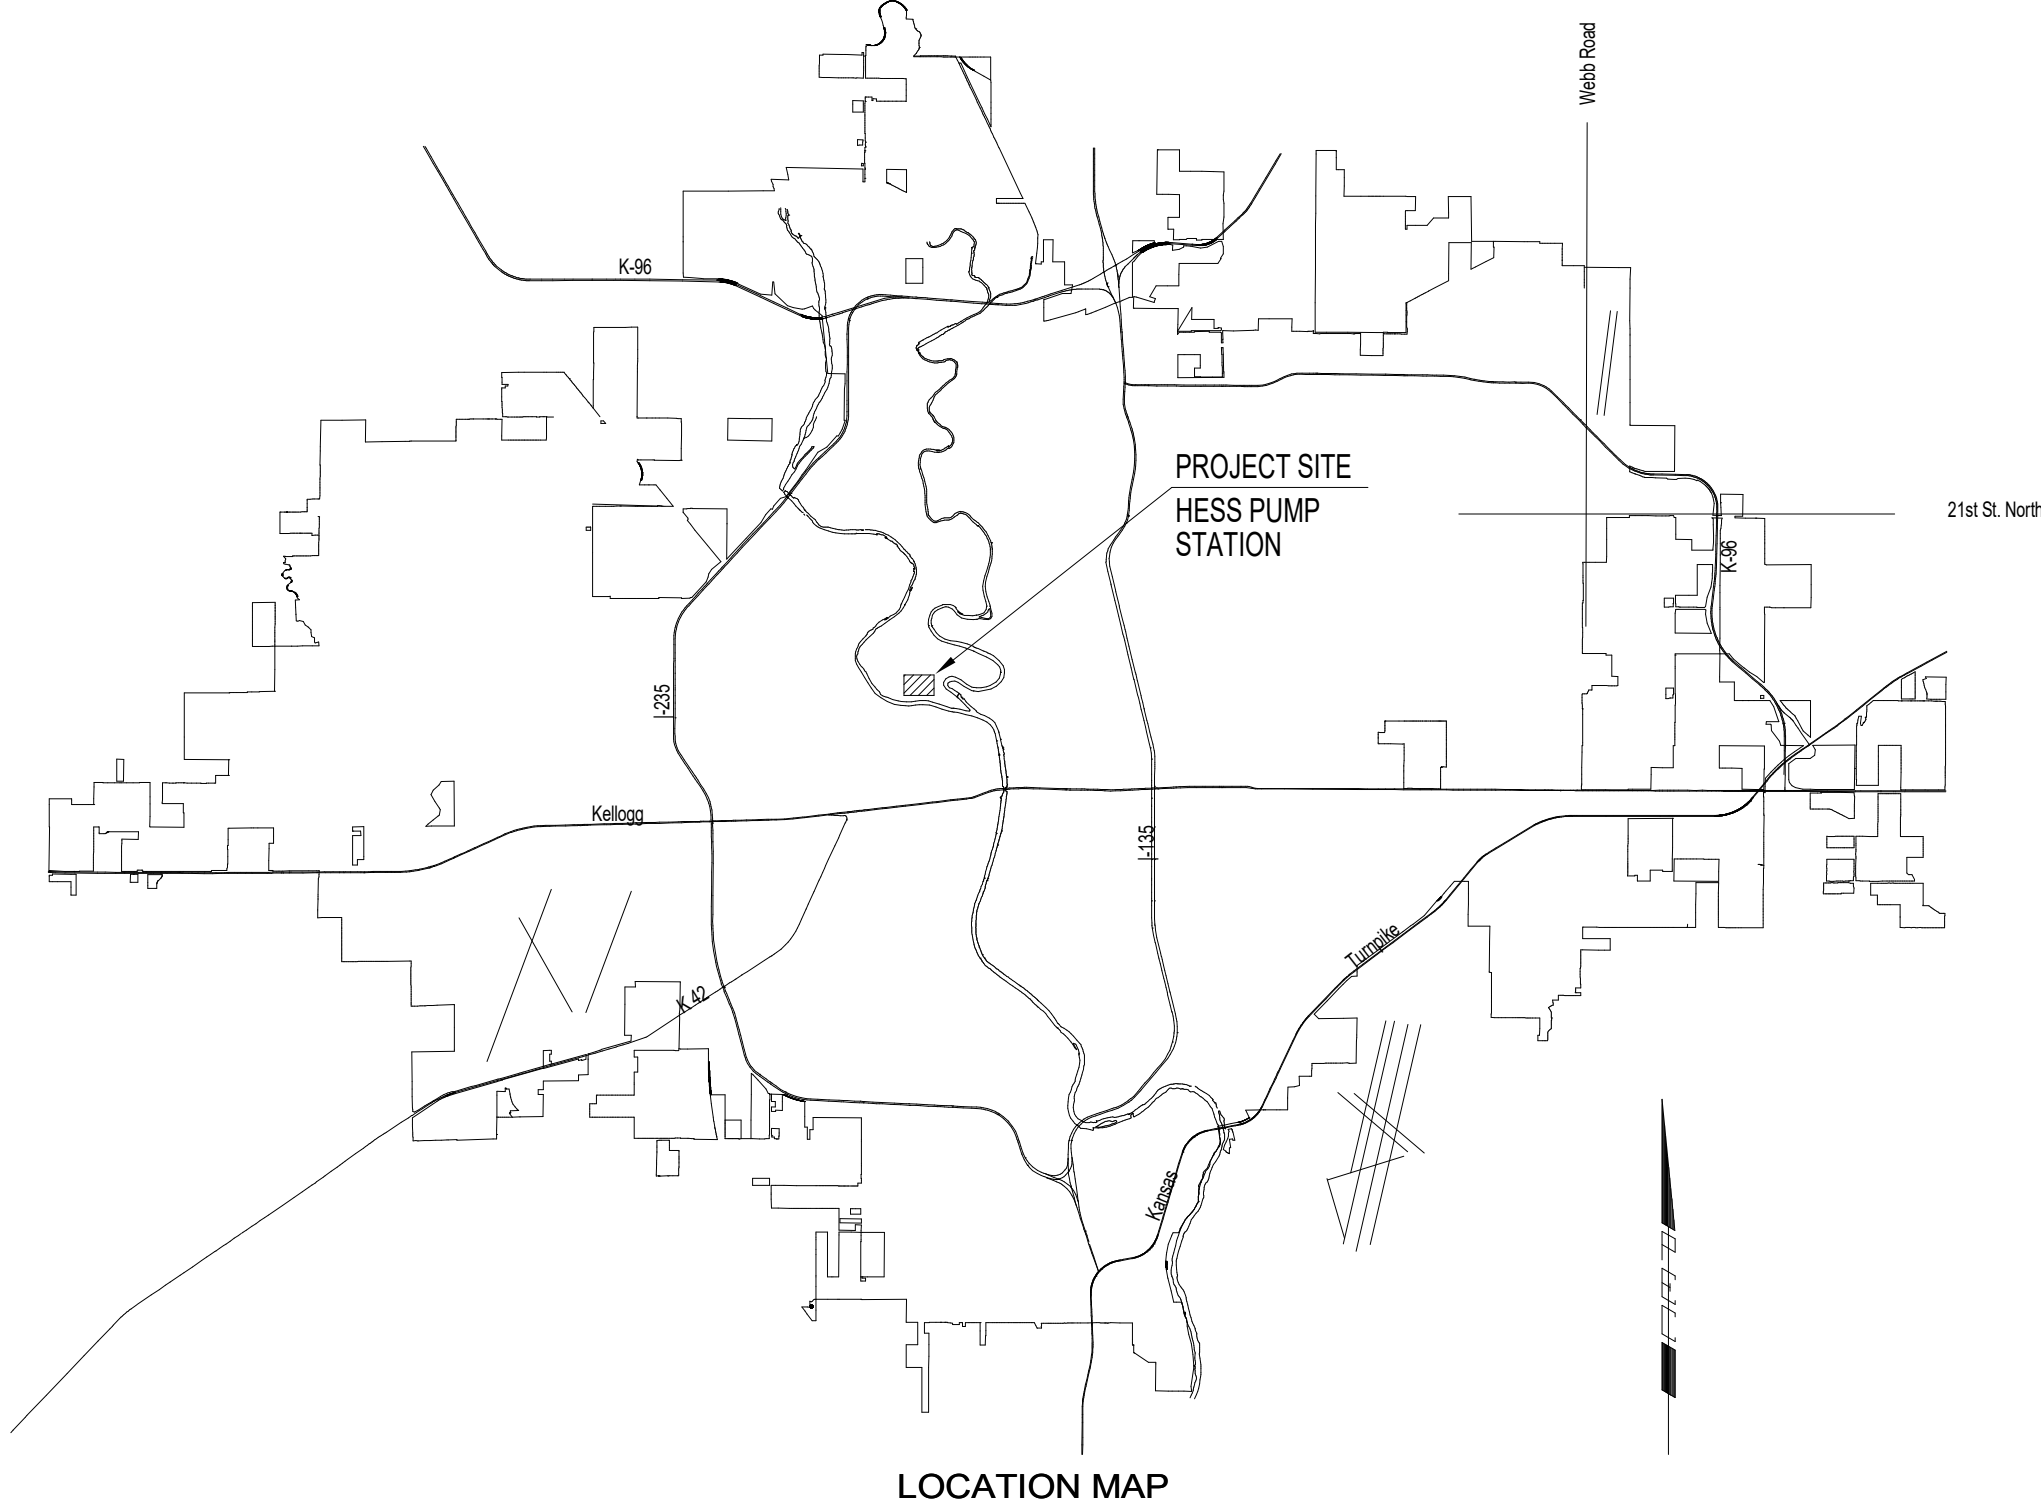

**INDEX OF SHEETS**

**MECHANICAL**


- G0.0 COVER SHEET
- M0.1 MECHANICAL COVER SHEET
- M1.1 MECHANICAL COMPOSITE PLAN
- M2.1 ENLARGED MECHANICAL DEMOLITION PLANS
- M3.1 ENLARGED MECHANICAL PLANS
- M4.1 MECHANICAL SPECIFICATIONS

**ELECTRICAL**

- E0.1 ELECTRICAL LEAD SHEET
- E0.2 ELECTRICAL ONE-LINE DIAGRAM
- E4.1 ELECTRICAL POWER PLANS


**NOVEMBER 2019**  
PEC PROJECT NO. 197043-008  
PLANS PREPARED BY  
**PROFESSIONAL ENGINEERING CONSULTANTS, P.A.**  
ENGINEERS  
WICHITA, KANSAS

MABCD REVIEWER:

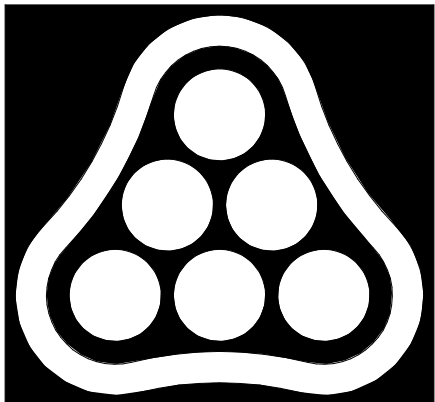

**PEC**

PROFESSIONAL ENGINEERING CONSULTANTS  
303 SOUTH TOPEKA  
WICHITA, KS 67202  
316-262-2691 www.pec1.com

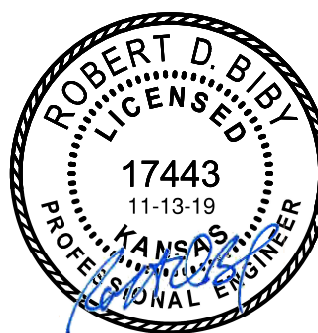

2020 HESS PUMP STATION  
DEHUMIDIFIER REPLACEMENT  
WICHITA, KS

COVER SHEET

JOB NO. 197043-008  
DATE 11/13/19  
DRAWN BY ABP  
CHECKED BY RDB

**G0.0**