

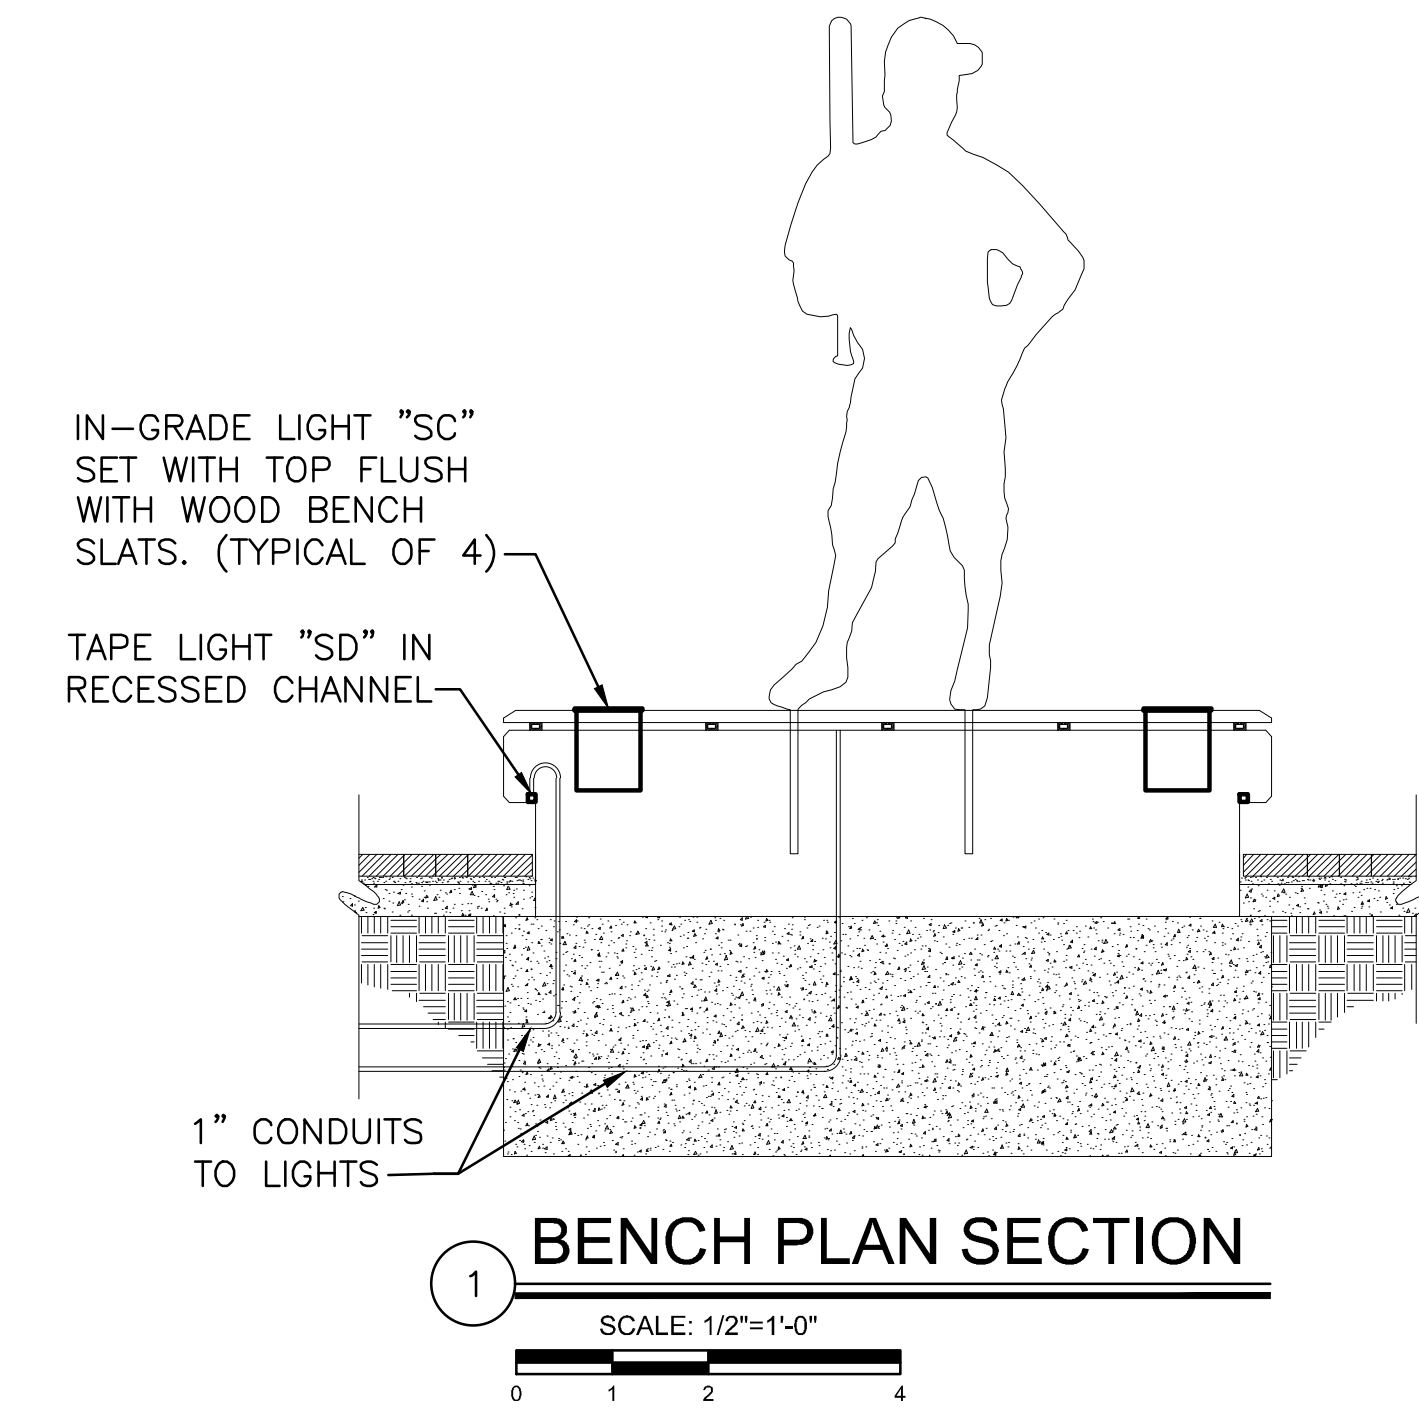


PLOTTED: Tuesday, September 03, 2019 @ 04:13PM

STATE	PROJECT NO.	YEAR	SHEET NO.	TOTAL SHEETS
KANSAS	87 N-0662-01	2019	132	194

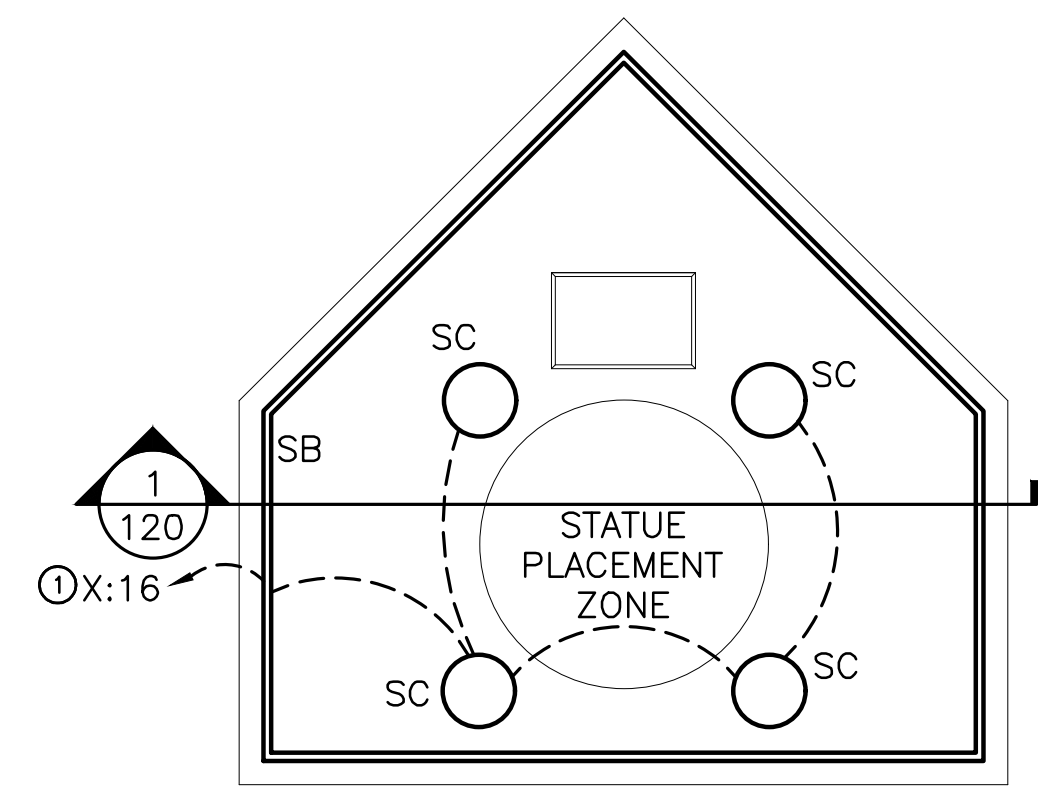

- KEYED NOTES**
- ROUTE CIRCUIT THROUGH LIGHTING CONTACTOR 'LC-1'.
  - INSTALL PHOTOCELL ON NORTH SIDE OF BUILDING.
  - MOUNT FIXTURE TO HORIZONTAL STEEL MEMBER. ROUTE CIRCUIT CONCEALED FROM UNDERGROUND, UP THROUGH STRUCTURE, TO FIXTURE.
  - PROVIDE RECEPTACLE WITH LOCKABLE, CAST METAL, WEATHERPROOF-IN-USE COVER.

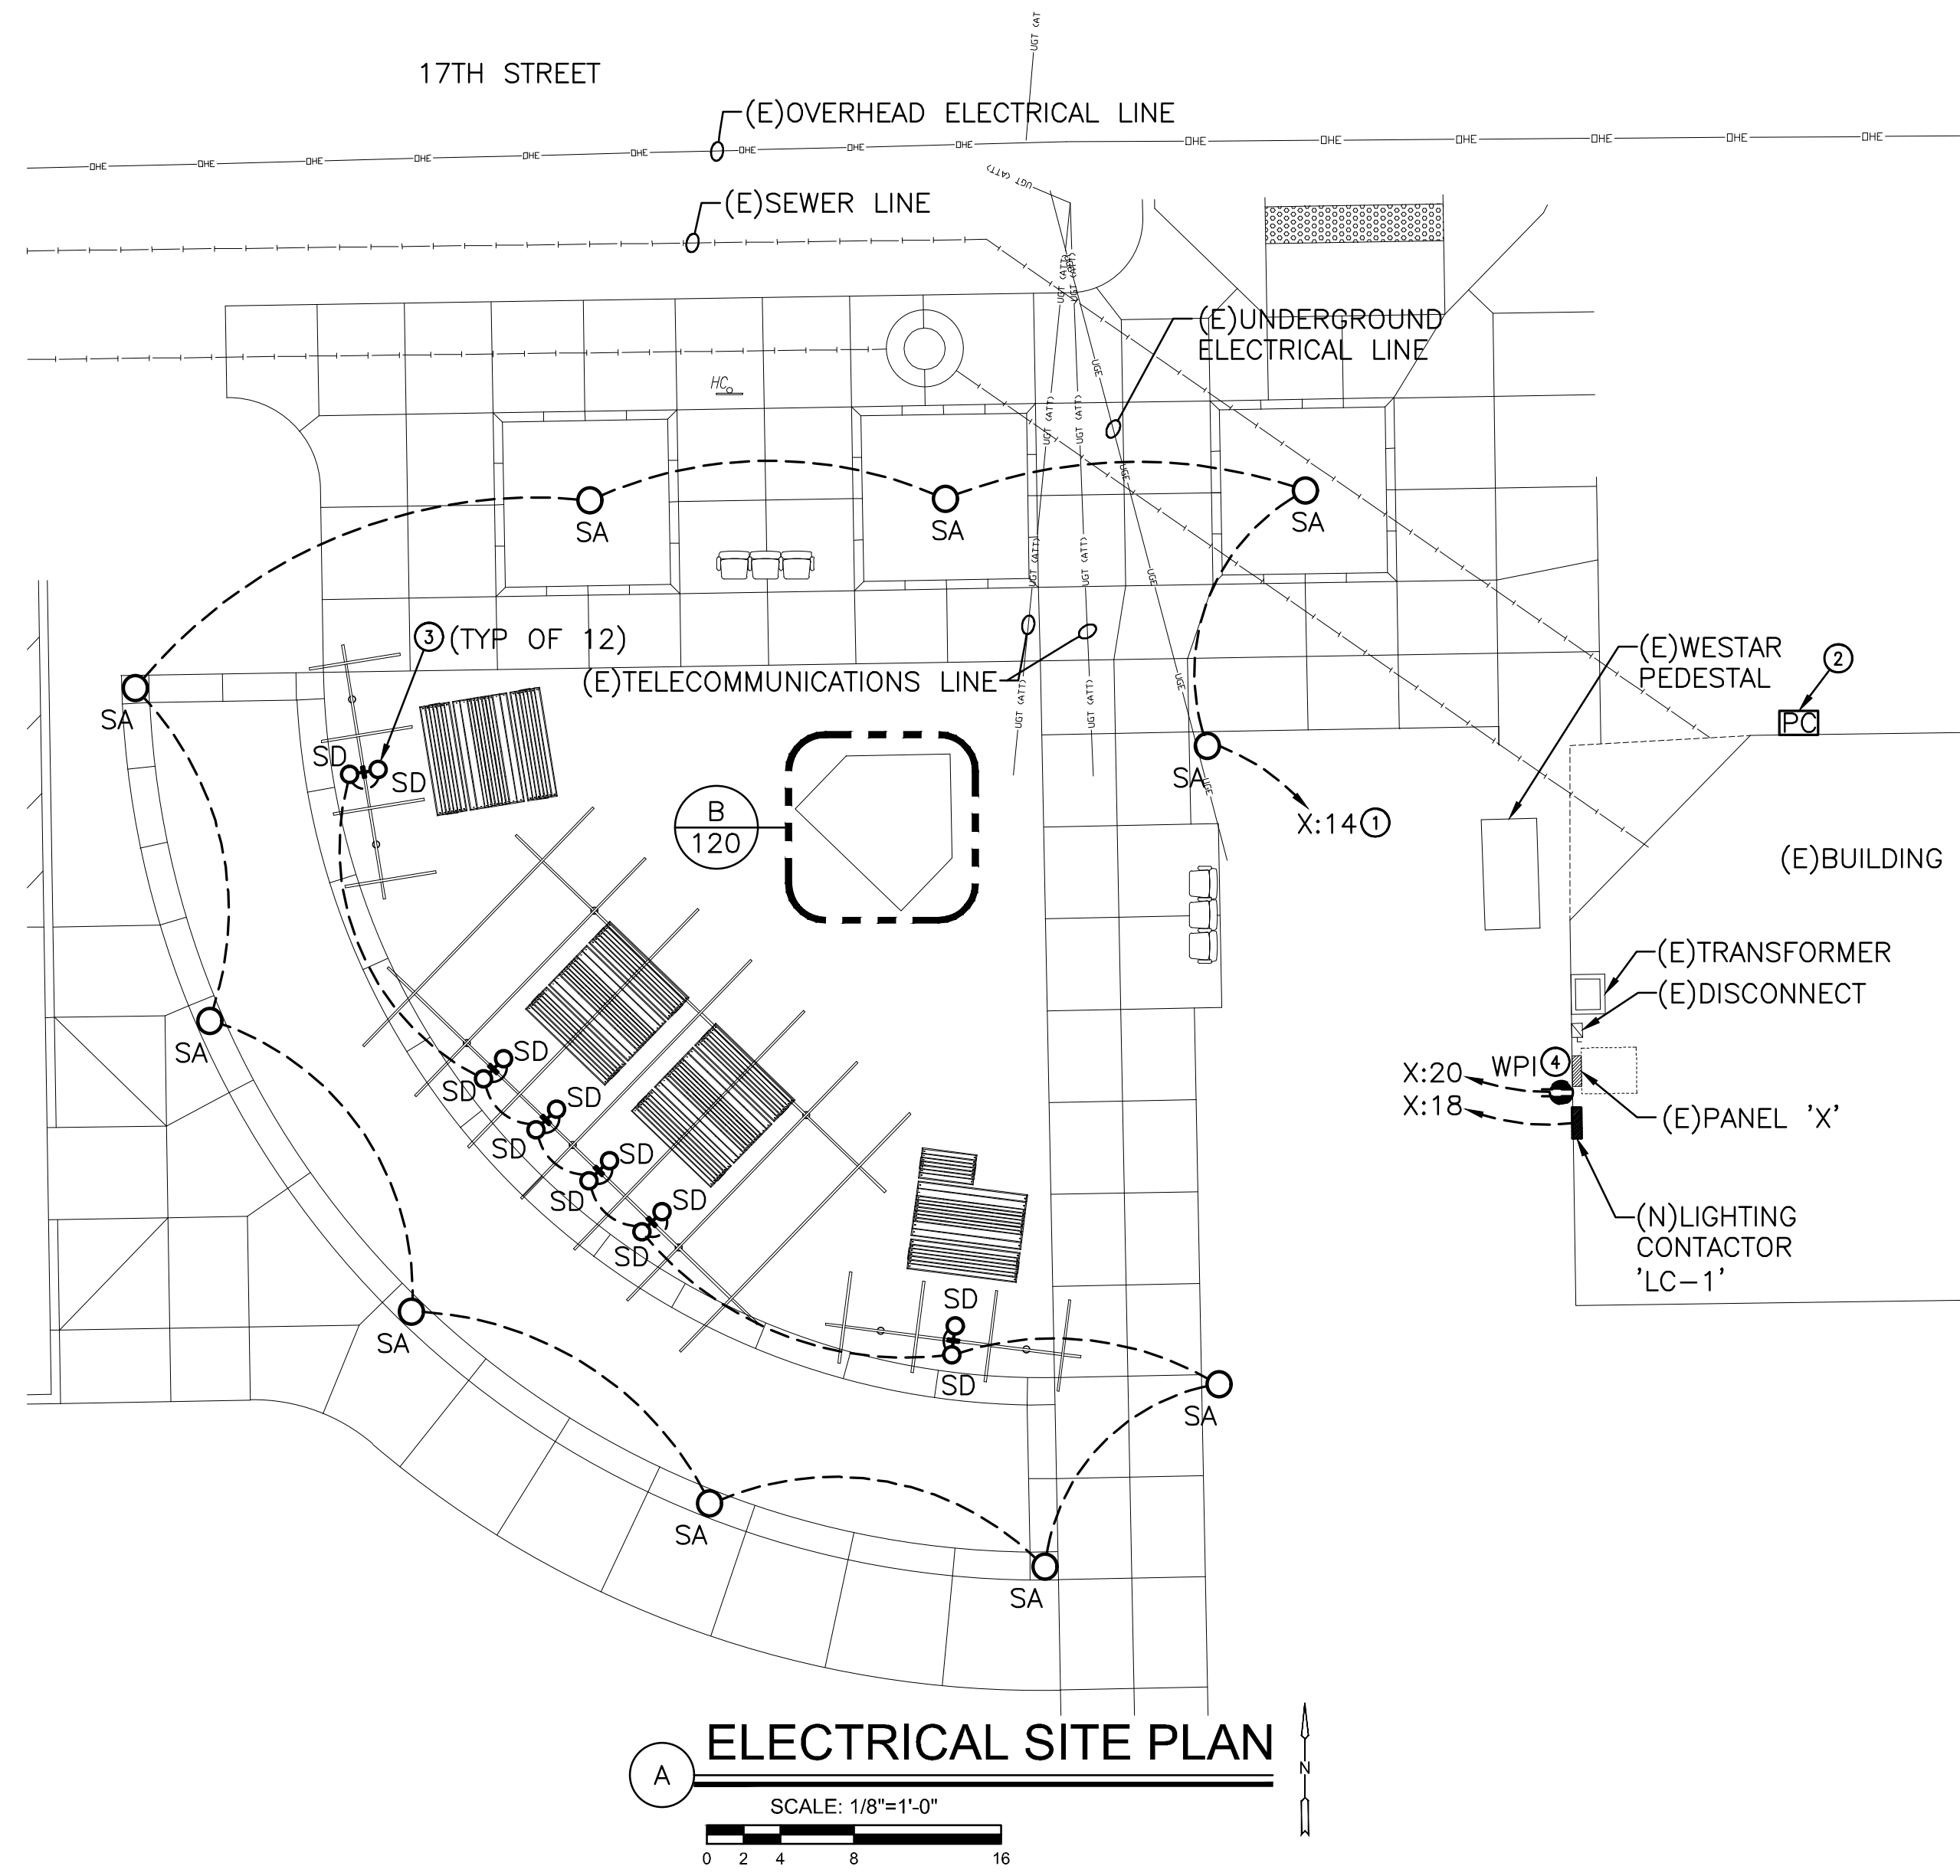

STREET IMPROVEMENTS FOR  
**17TH ST - BROADWAY TO I-135**  
FROM BROADWAY TO I-135

©2019 MKEC Engineering All Rights Reserved  
www.mkec.com  
These drawings and their contents, including, but not limited to, all concepts, designs, & ideas are the exclusive property of MKEC Engineering (MKEC), and may not be used or reproduced in any way without the express consent of MKEC.

**ELECTRICAL SITE PLAN**

PROJECT NO.	87 N-0662-01	
DATE	8/30/2019	
SCALE	#"-#"	
DESIGNED	DRAWN	CHECKED
XXX	XXX	XXX

NO.	REVISION	DATE

SHEET NO.  
**132 OF 194**



J:\CIVIL\177\DWG\ASSETS\THE TICSS\SHEET\ELECTRICAL\120 - ELECTRICAL SITE PLAN.DWG