


NOTES:

1. EXTEND PVC CONDUIT TO TOP OF BASE, OR PEDESTAL FOR BASE, FOR PEDESTAL MOUNTED EQUIPMENT. SUPPORT AT (2) PLACES(MIN).
2. SEAL ALL SLEEVES TO PREVENT WATER PENETRATION.


1
E5 **GROUNDING CONDUIT SLEEVE DETAIL**
SCALE: NONE

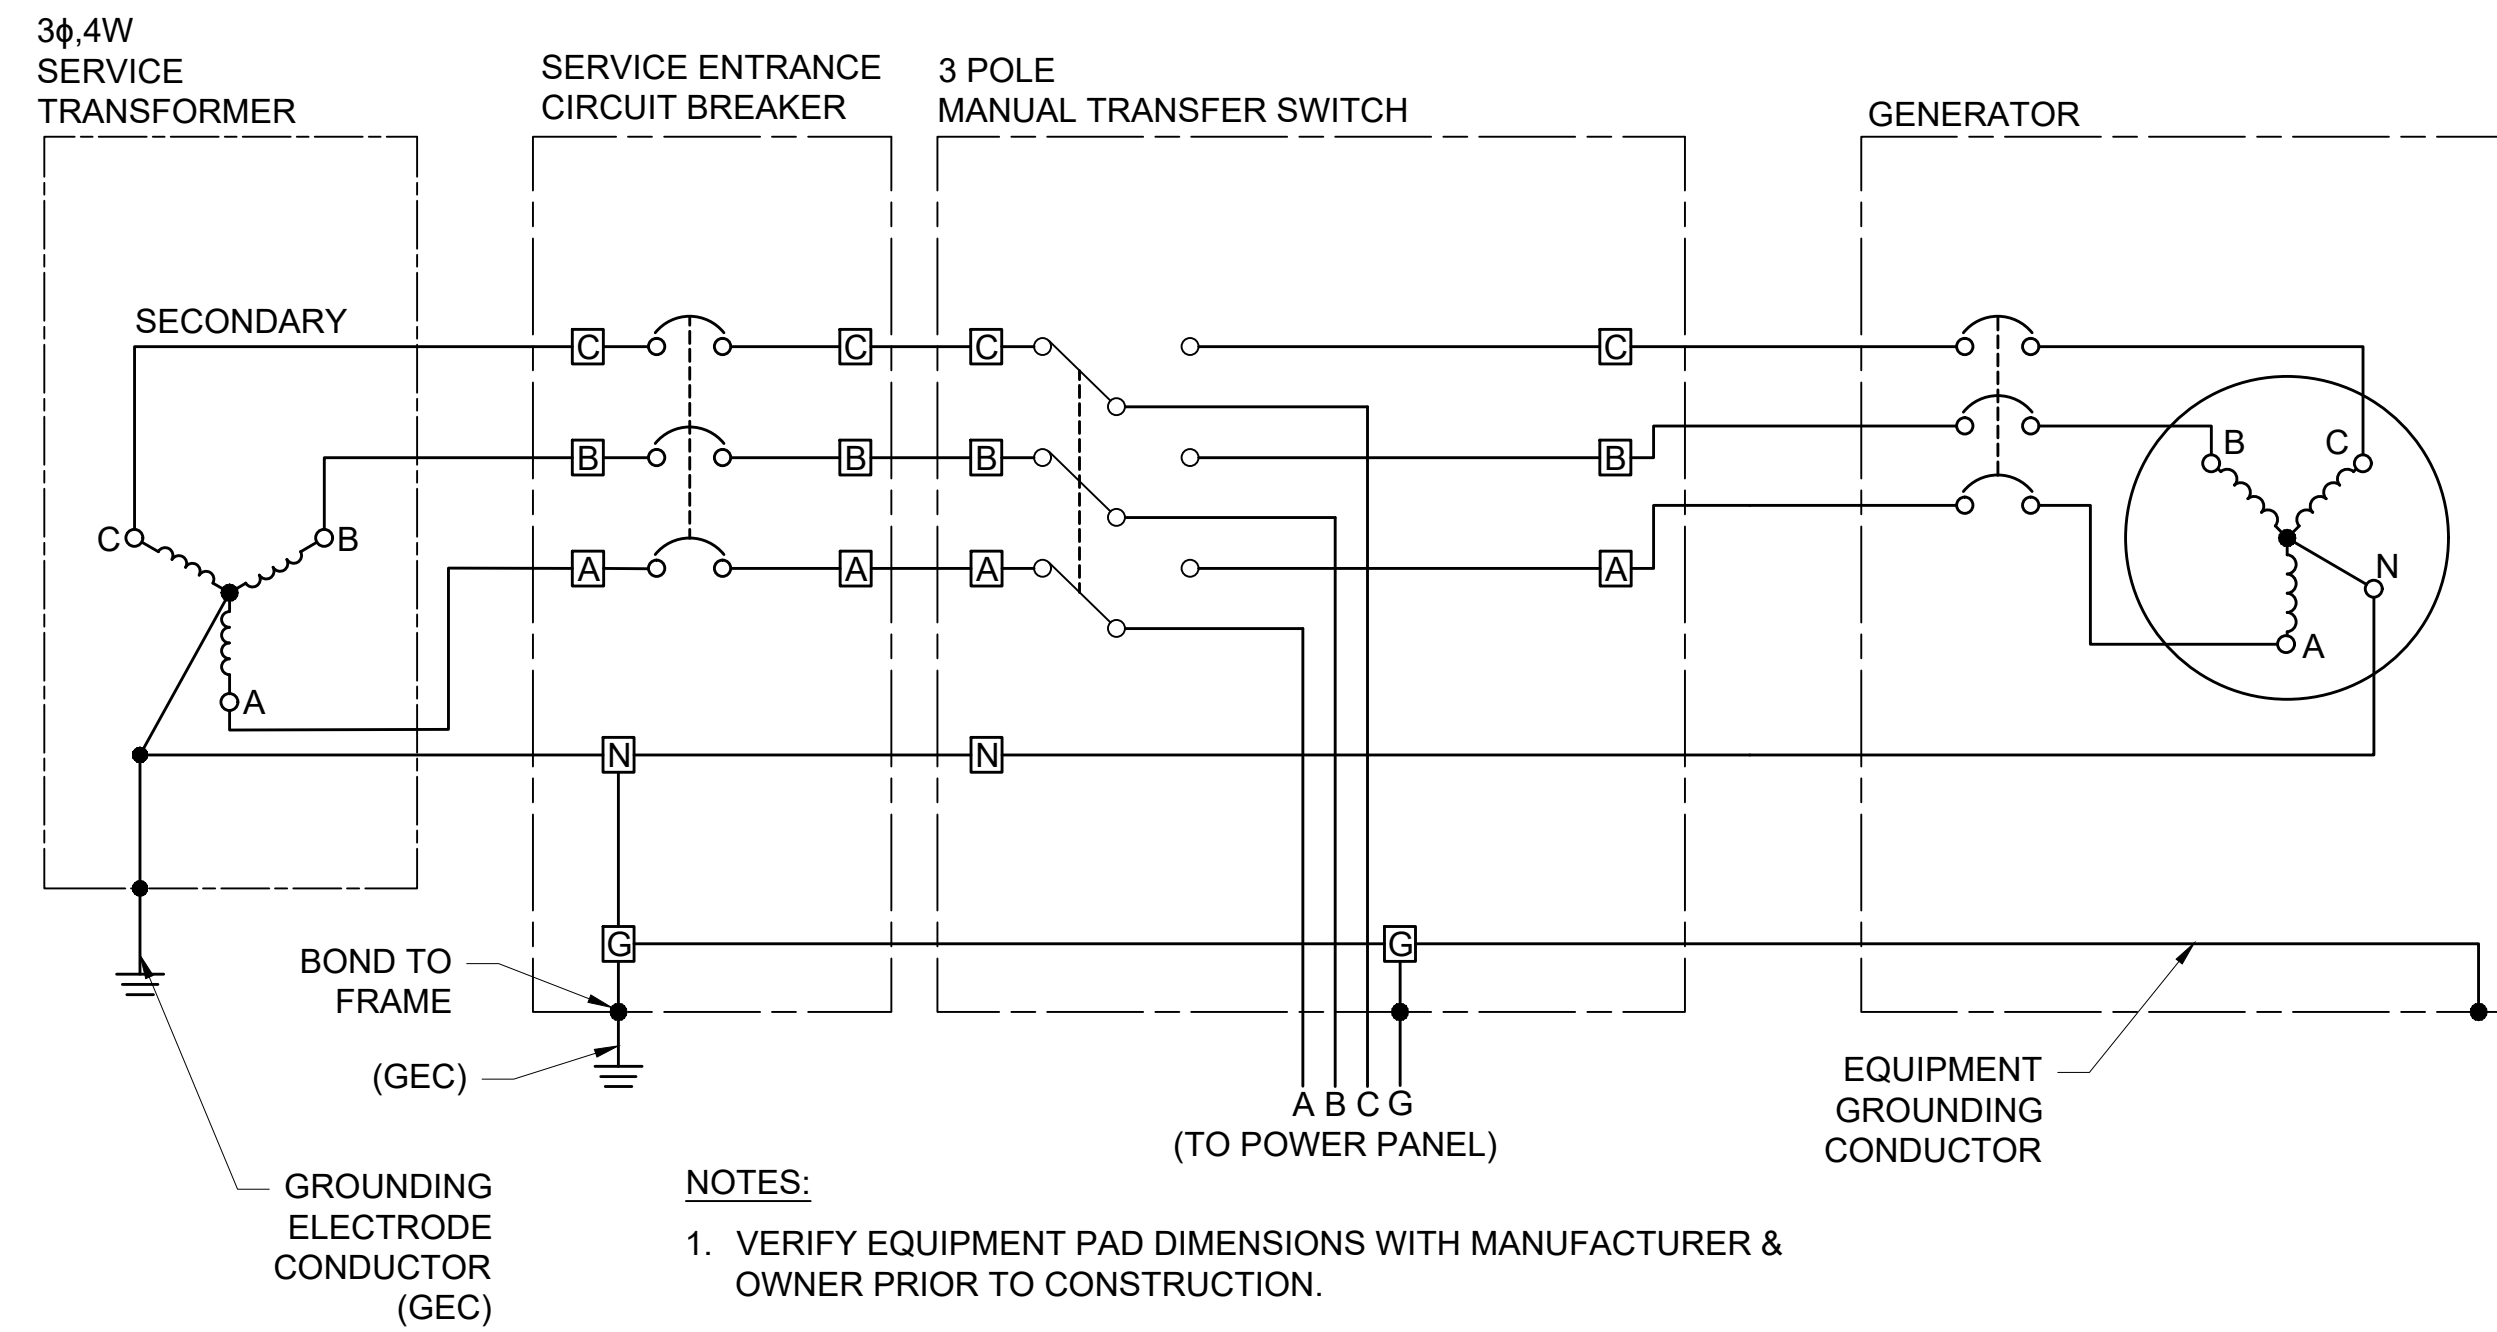


NOTES:

1. VERIFY EQUIPMENT PAD DIMENSIONS WITH MANUFACTURER & OWNER PRIOR TO CONSTRUCTION.
2. PROVIDE FRONT, BACK & SIDE CLEARANCES AS REQUIRED

3
E5 **3 POLE TRANSFER SWITCH CONNECTION DETAIL**
SCALE: NONE

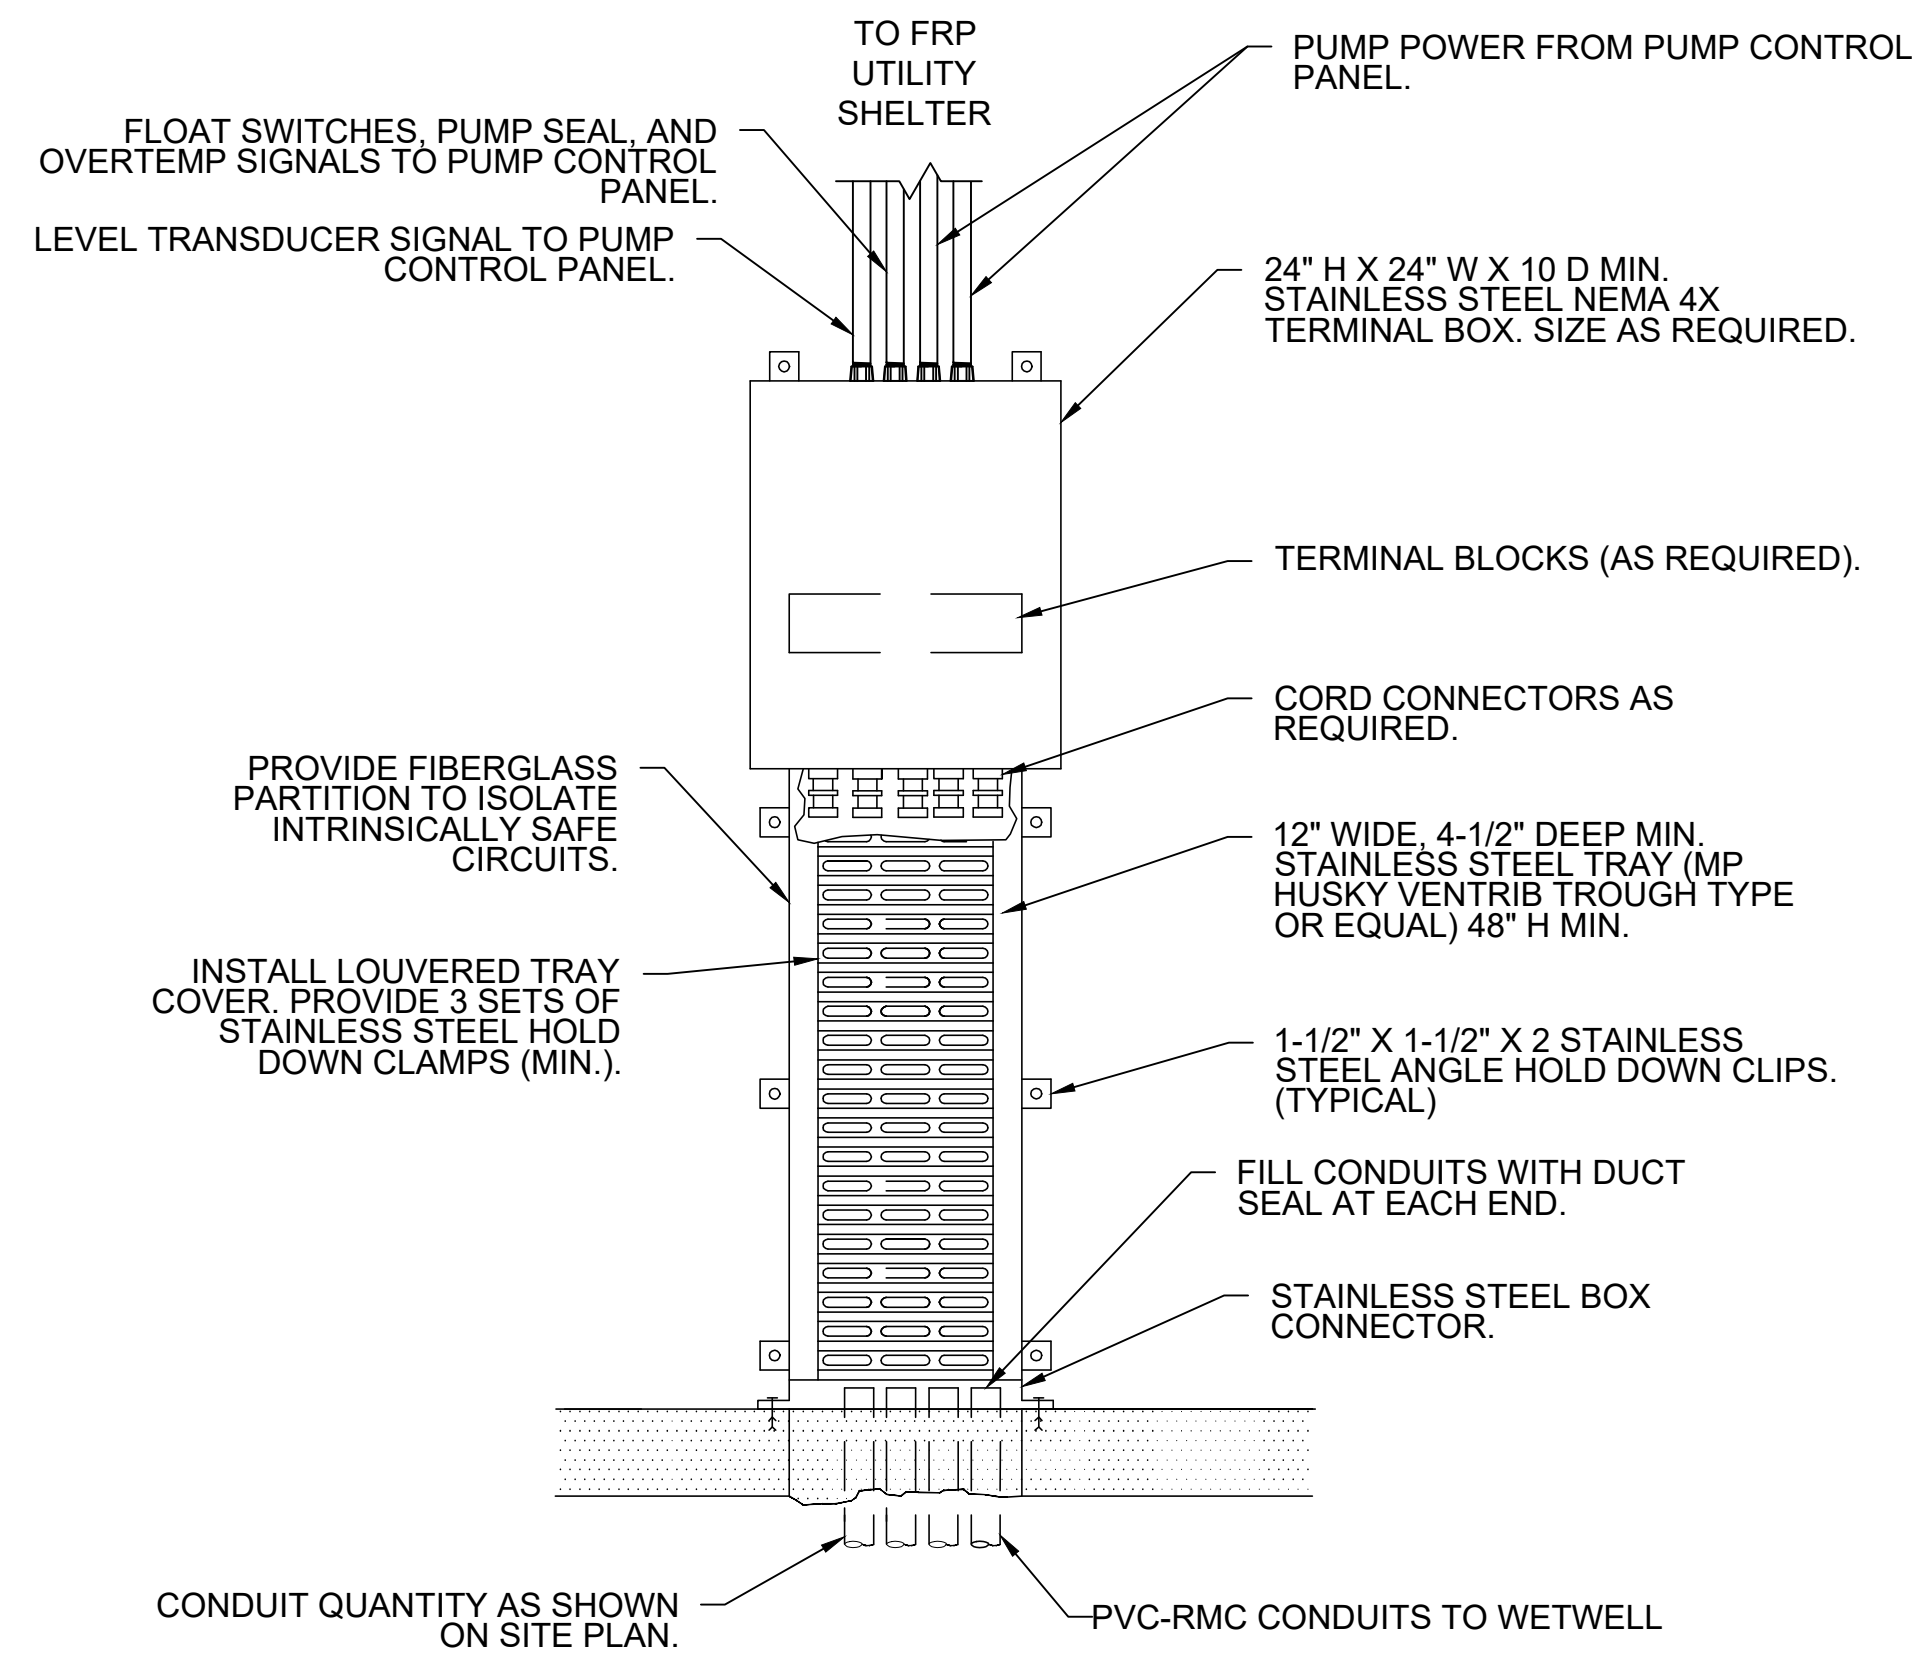

2
E5 **TERMINAL BOX CABLE ENTRY DETAIL**
SCALE: NONE

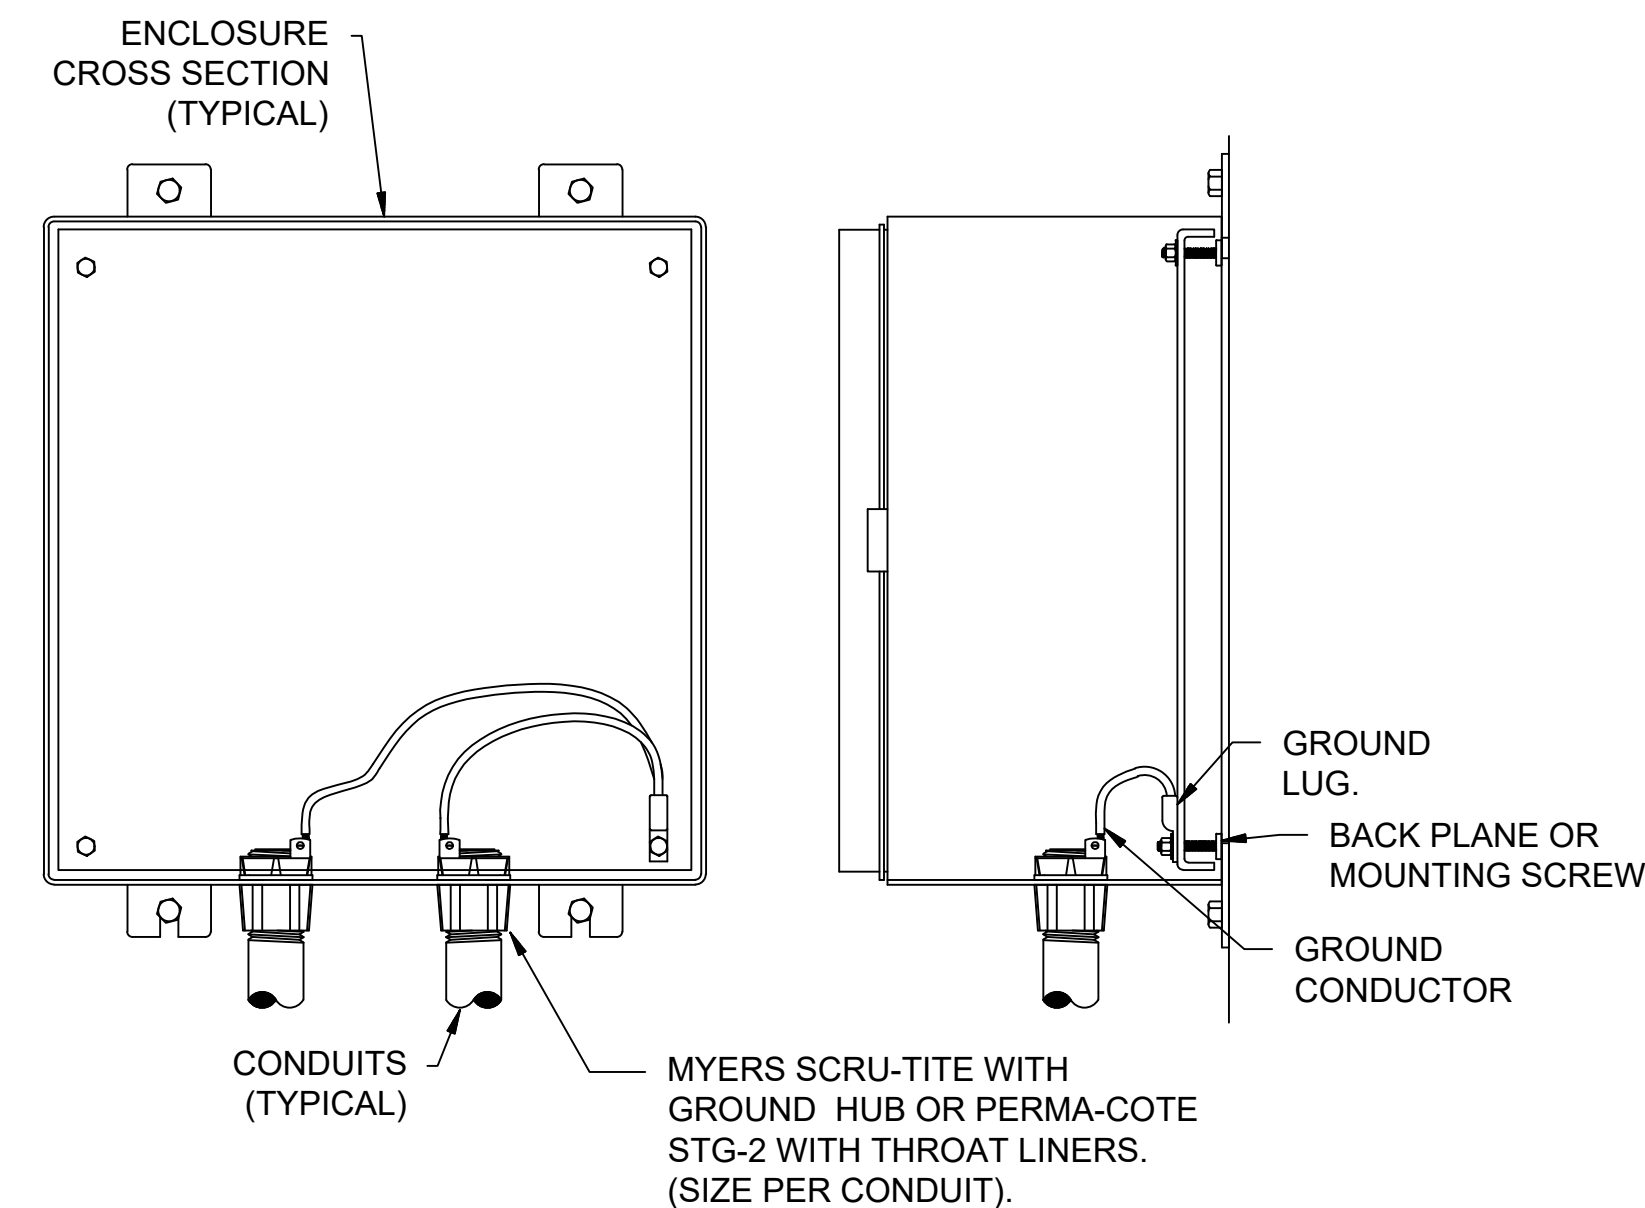

NOTES:

1. ALL SERVICE, FEEDER AND CONTROL CONDUITS SHALL BE GROUNDED ON BOTH ENDS.

4
E5 **CONDUIT GROUNDING DETAIL**
SCALE: NONE



© 2018 GARVER, LLC
THIS DOCUMENT, ALONG WITH THE IDEAS AND DESIGNS CONVEYED HEREIN, SHALL BE CONSIDERED INSTRUMENTS OF PROFESSIONAL SERVICE AND ARE PROPERTY OF GARVER, LLC. ANY USE, REPRODUCTION, OR DISTRIBUTION OF THIS DOCUMENT, ALONG WITH THE IDEAS AND DESIGN CONTAINED HEREIN, IS PROHIBITED UNLESS AUTHORIZED IN WRITING BY GARVER, LLC OR EXPLICITLY ALLOWED IN THE GOVERNING PROFESSIONAL SERVICES AGREEMENT FOR THIS WORK.



Digitally Signed 11/18/2019

REV.	DATE	DESCRIPTION	BY



CITY OF WICHITA
WICHITA, KANSAS
Consolidation of Lift Stations
Near 151st St. & W. Kellogg

ELECTRICAL DETAILS I

JOB NO.: 17264967
DATE: NOV. 2019
DESIGNED BY: MTD
DRAWN BY: MTD

BAR IS ONE INCH ON ORIGINAL DRAWING
IF NOT ONE INCH ON THIS SHEET, ADJUST SCALES ACCORDINGLY.
DRAWING NUMBER
E5
SHEET NUMBER **18 OF 36**