





L/K DWG. NAME: 18193-66-70 SYCAMORE LIGHTING.dwg; Apr. 3 2020 — 12:01pm; LAST EDITED BY: swiebe

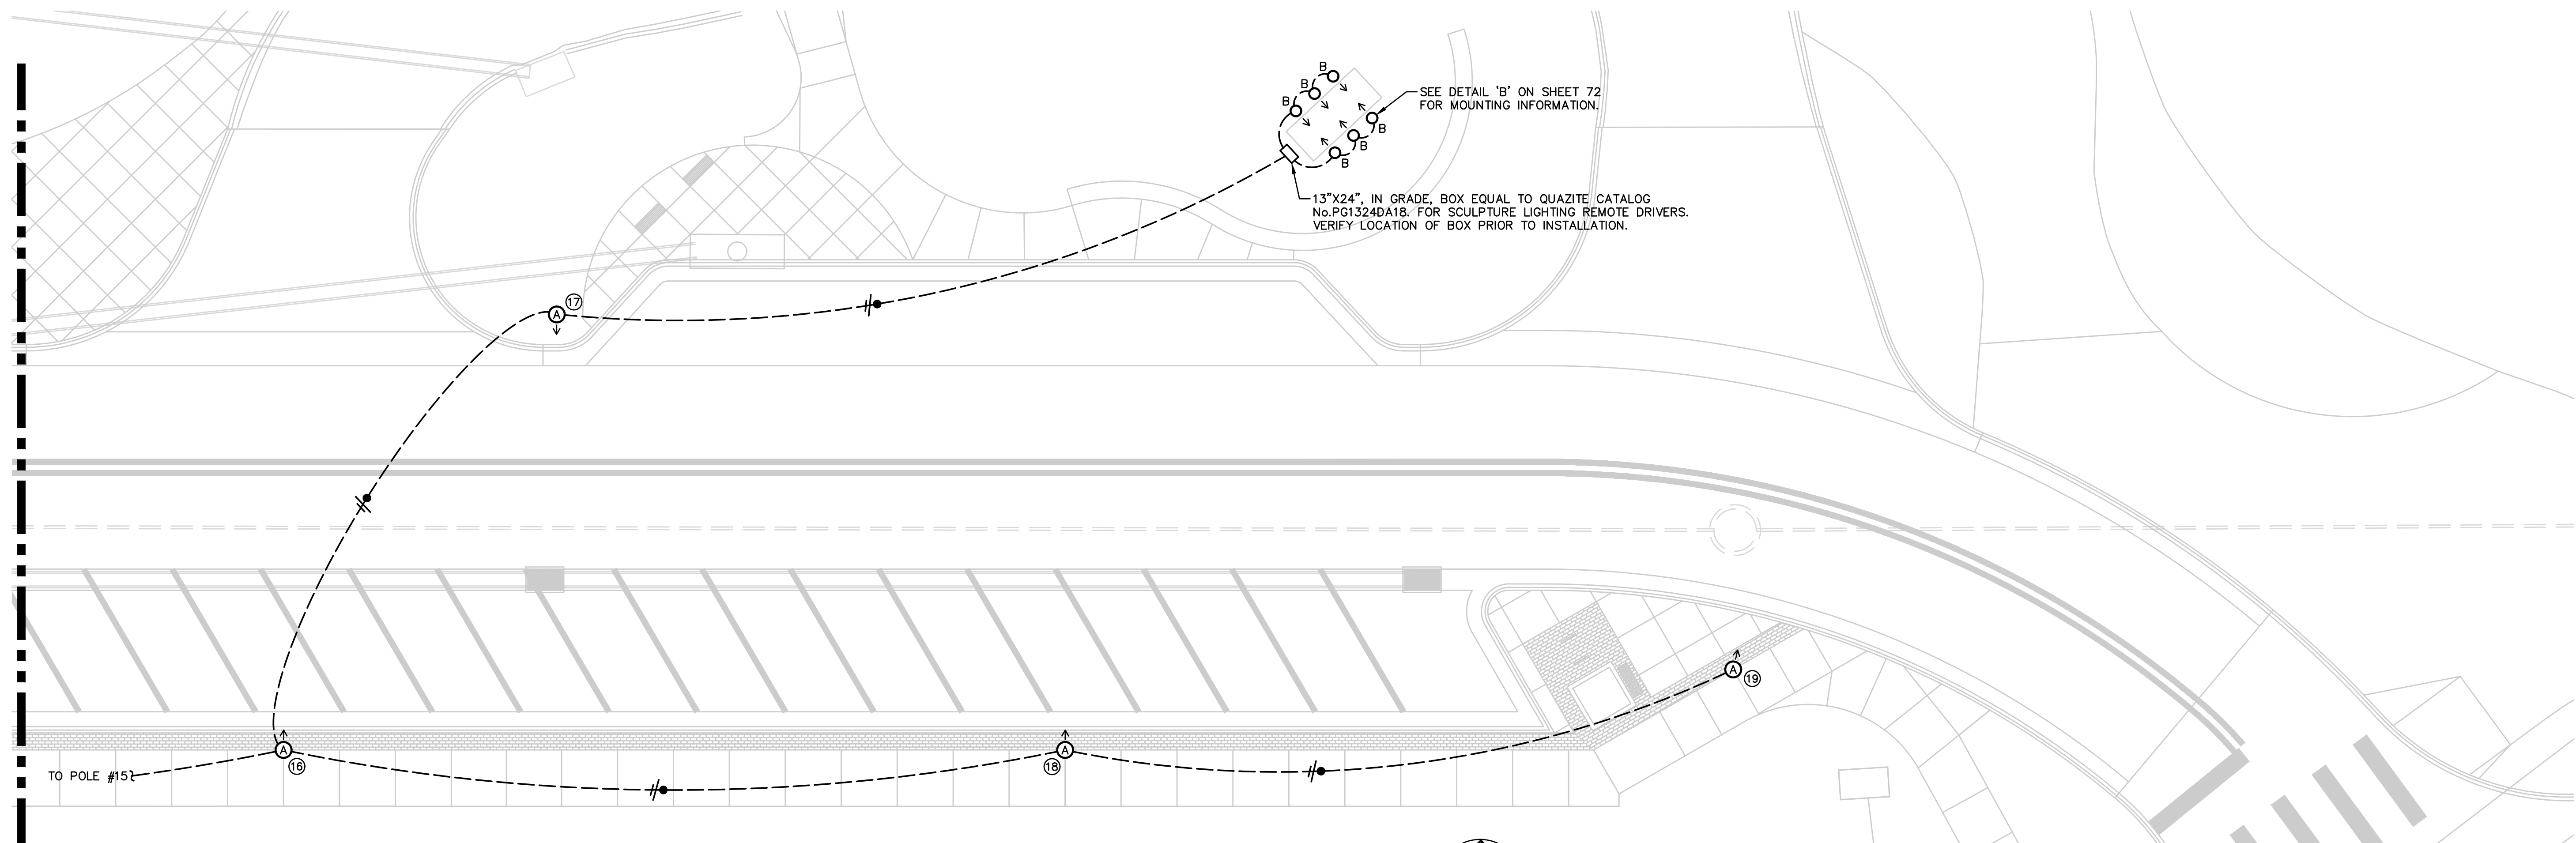



SEE DETAIL 'B' ON SHEET 72 FOR MOUNTING INFORMATION.

13"x24", IN GRADE, BOX EQUAL TO QUAZITE, CATALOG No.PG1324DA18. FOR SCULPTURE LIGHTING REMOTE DRIVERS. VERIFY LOCATION OF BOX PRIOR TO INSTALLATION.

 A LIGHTING PLAN - D

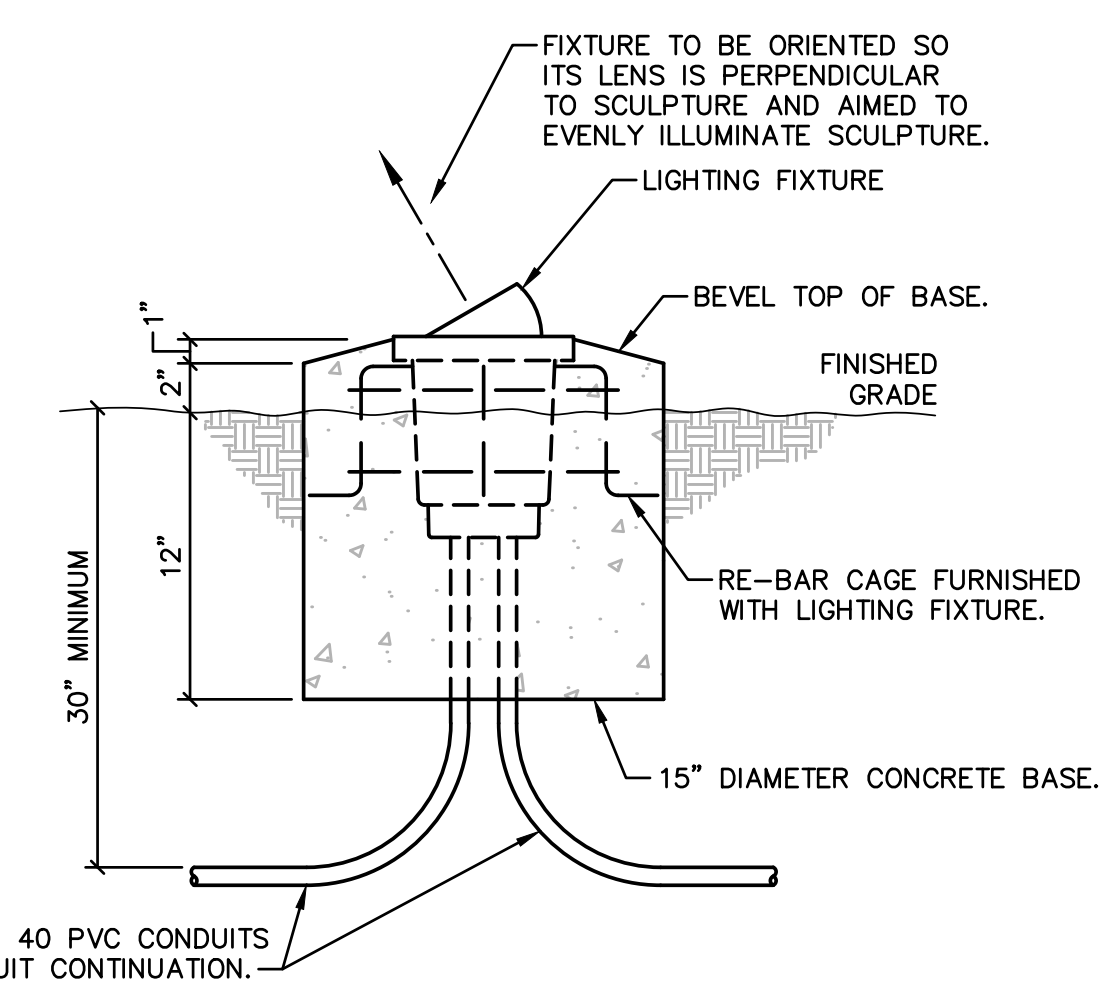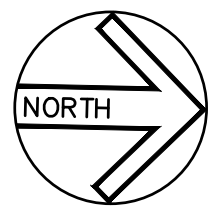


 B BASE DETAIL - LIGHTING FIXTURE TYPE 'B'

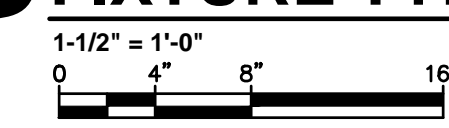

KEY PLAN

N.T.S.

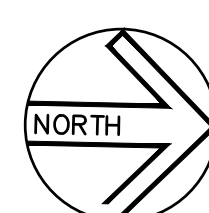

Tran Systems

245 NORTH WACO
SUITE 222
WICHITA, KANSAS 67202
PHONE: 316-303-3000
FAX: 316-462-5629

CONSULTANTS:

LK ARCHITECTURE, INC.
345 RIVERVIEW
SUITE 200
WICHITA, KANSAS 67208
PHONE: 316-268-0230

SYCAMORE STREET IMPROVEMENTS

WICHITA, KANSAS

CITY OF WICHITA

REVISIONS:	MARK	DATE	DESCRIPTION

PROJ NO: 472-85284
SCALE: 1" = 10'-0"
DATE: 5/21/2020
DESIGNED BY: S. WIEBE
DRAWN BY: S. WIEBE
CHECKED BY: T. LEWIS

SHEET TITLE:

SITE ELECTRICAL PLAN - D

SHEET NO. 72

SHEET 72 OF 92