




**1 VFD Control Schematic (VFD-FP1, VFD-FP2)**  
Scale: None

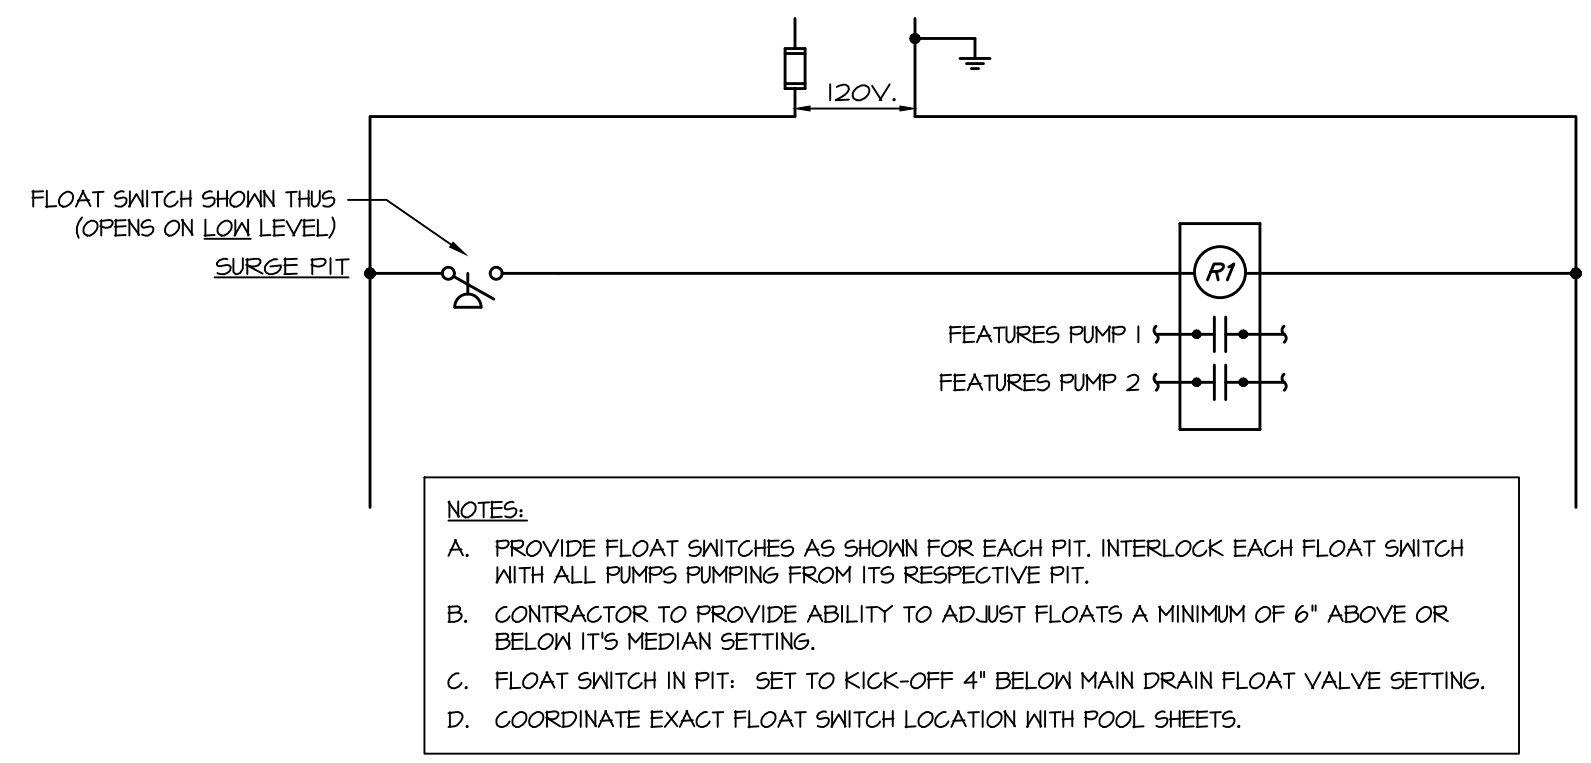

**3 Motor Control Schematic**  
Scale: None


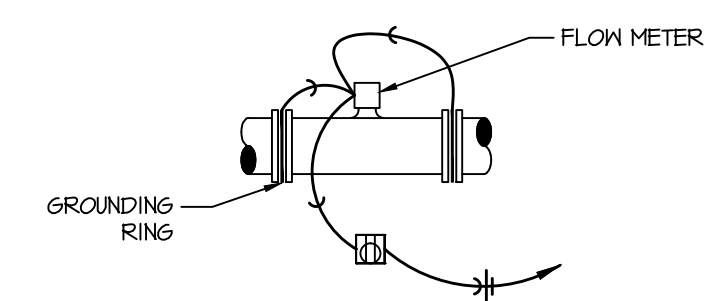


**2 Flow Meter Grounding Detail**  
Scale: None

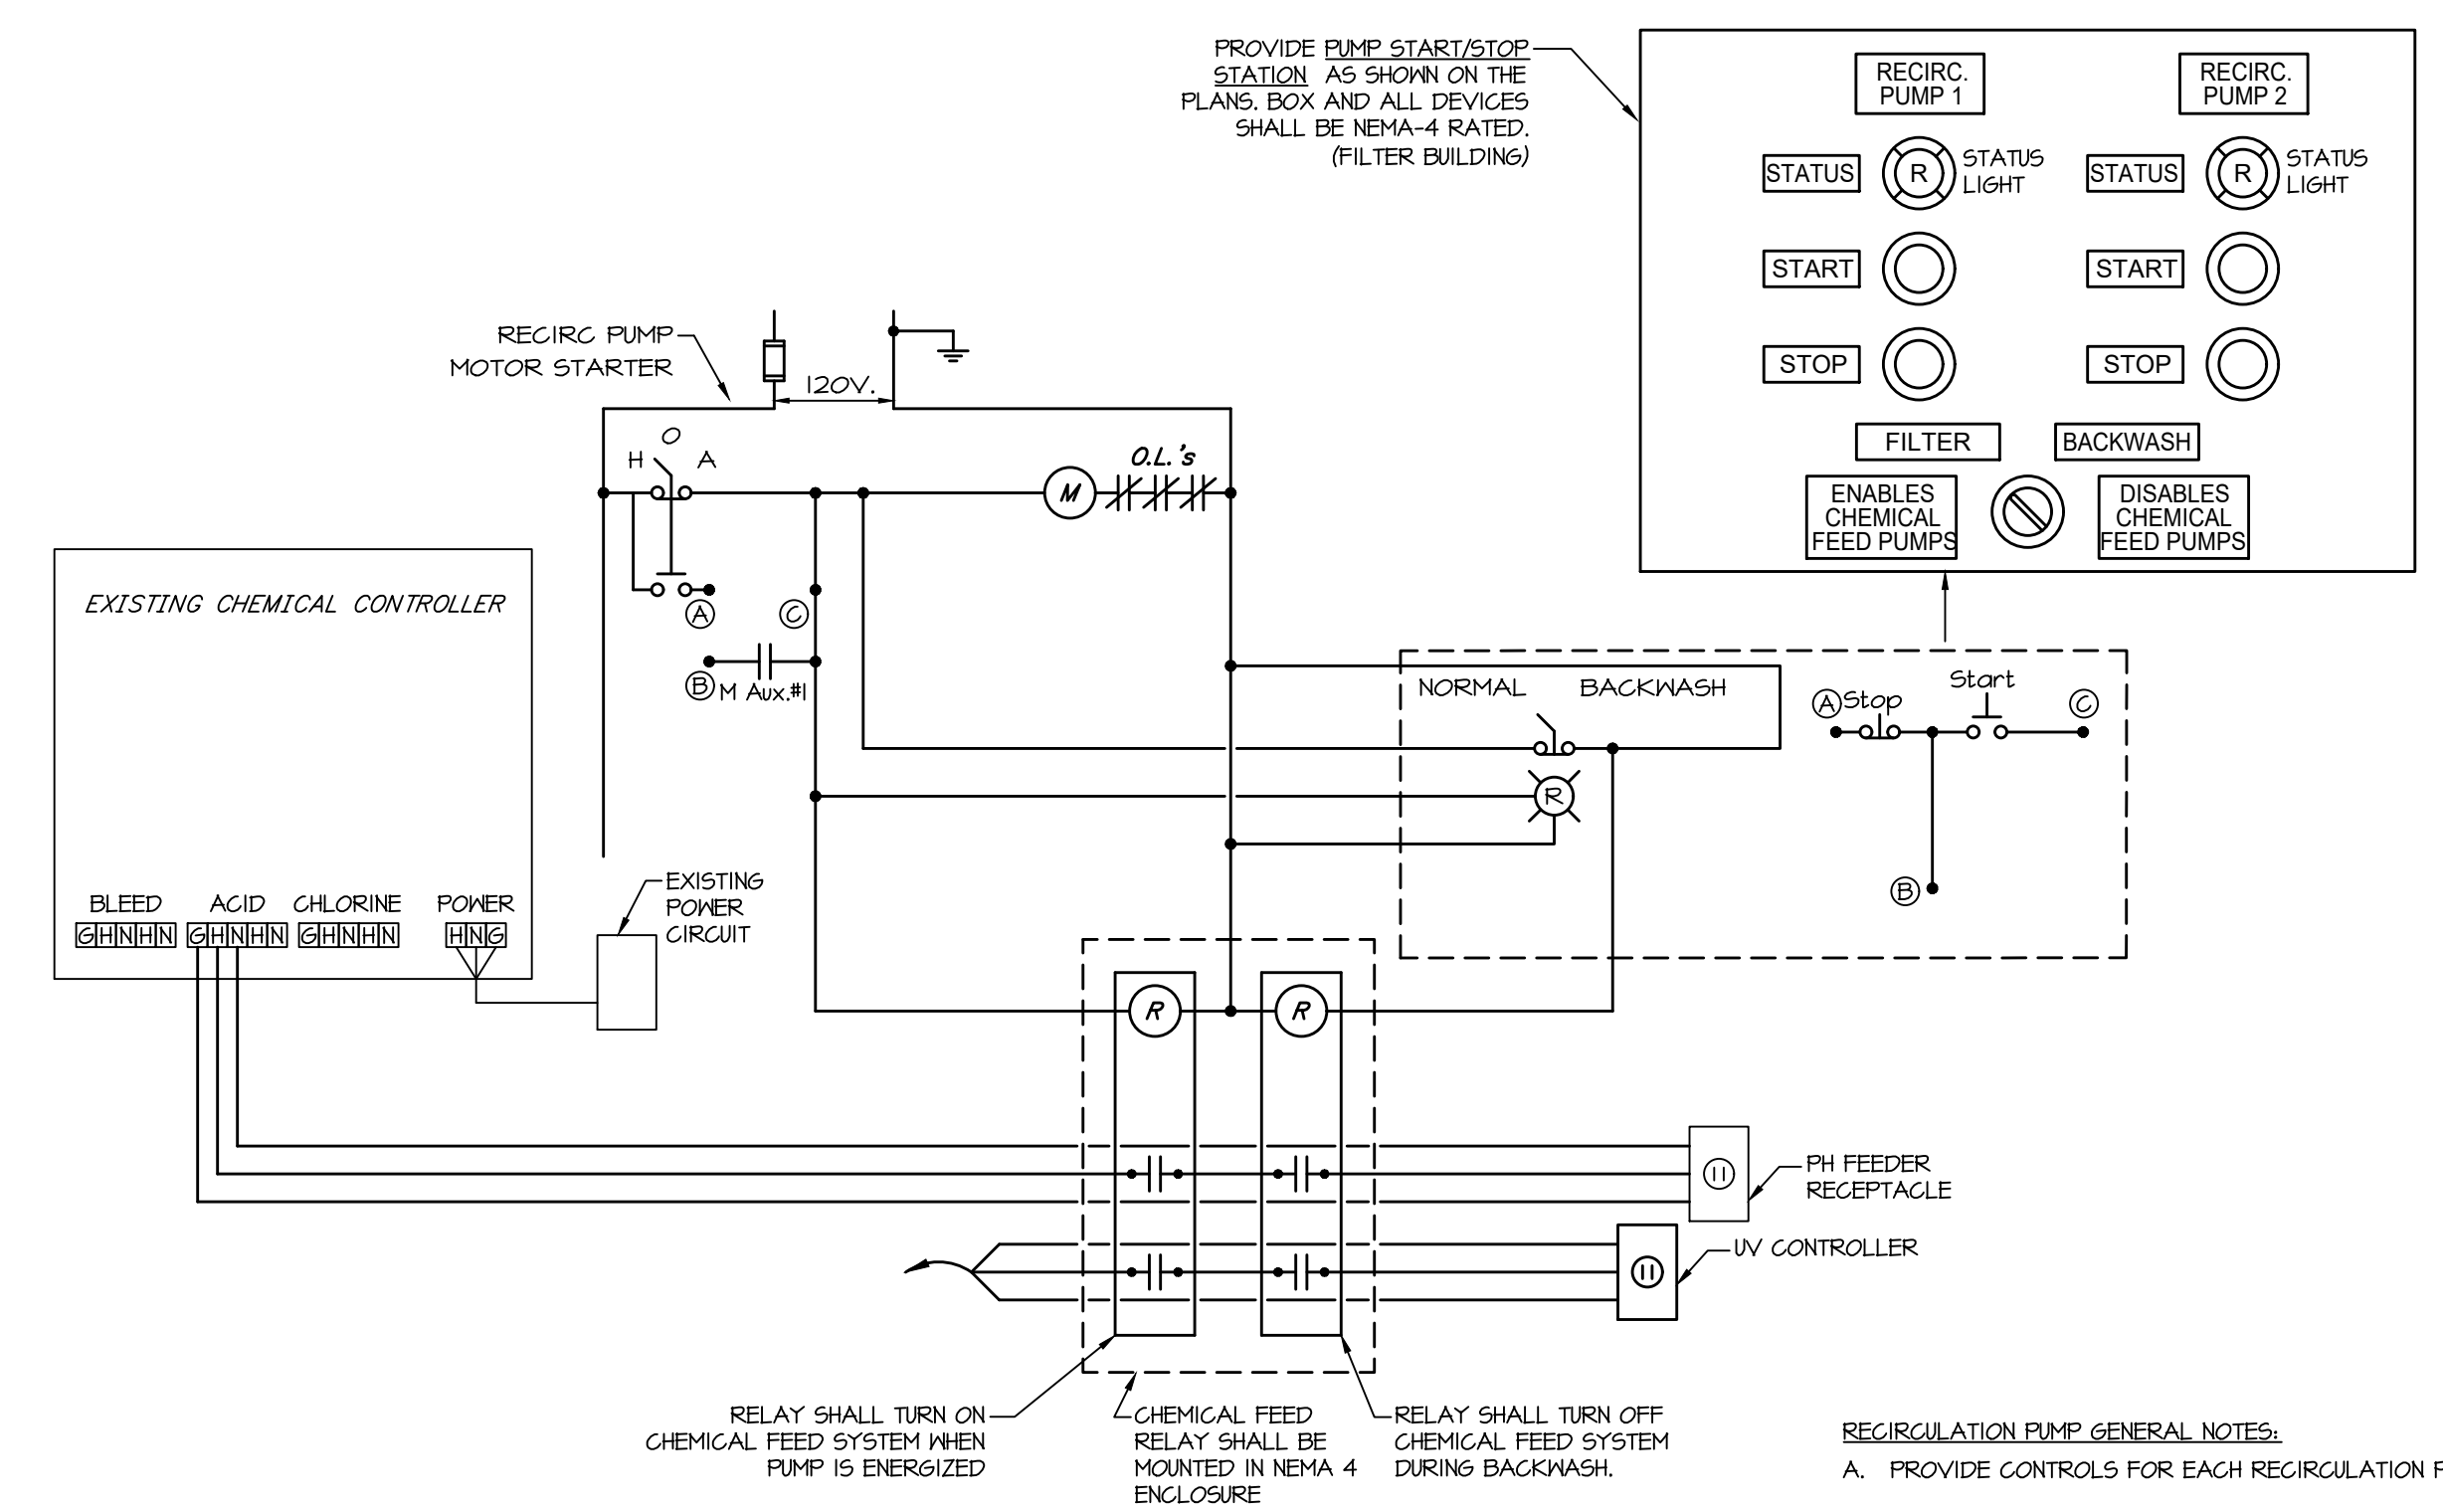

**4 Recirculation Pump Control Schematic (CMS-RP1, CMS-RP2)**  
Scale: None

ELECTRICAL CONTRACTOR IS TO PROVIDE POOL PUMP CONTROLS, POOL PUMP CONTROLS, FLOAT SWITCHES, STARTERS, VFDS AND SWITCHES ARE NOT PROVIDED BY THE POOL CONTRACTOR.

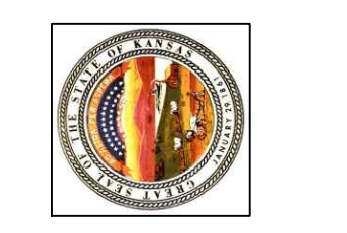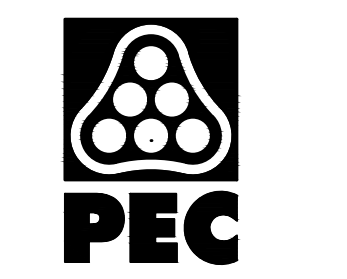

WICHITA, KANSAS  
Spray Ground  
LINWOOD PARK



Casey John Steiner  
LICENSE #19423  
Date: 8-14-20 Job #: 1820529  
Drawn: CDW Checked: MST  
Issue: CONSTRUCTION DOCUMENTS

ELECTRICAL DETAILS

SP-E2