


- LEGEND**
- G = GAS MAIN
 - W = WATER MAIN
 - SS = SANITARY SEWER
 - SWS = STORM WATER SEWER
 - UGT = UNDER GROUND TELEPHONE
 - UGT = UNDER GROUND TELEPHONE
 - B.M. = BENCH MARK
 - TELE. PED. = TELEPHONE PEDESTAL
 - F.H. = FIRE HYDRANT
 - C.A. = CUY ANCHOR
 - G.P. = GUARD POST
 - H.L.P. = HIGH LINE POLE
 - L.P. = LIGHT POLE
 - M.B. = MAIL BOX
 - P.P. = POWER POLE
 - S.H. = SPRINKLER HEAD
 - S. = SIGN
 - WELL. = WATER WELL
 - W.V. = WATER VALVE
 - SS M.H. = SANITARY SEWER MANHOLE

UTILITIES SHOWN REPRESENT THE BEST INFORMATION AVAILABLE FOR DESIGN. ADDITIONAL UTILITIES MAY BE PRESENT ON THIS PROJECT. THE CONTRACTOR SHALL BE RESPONSIBLE FOR DETERMINING THE EXACT LOCATION, DEPTH AND SIZE OF ALL UNDERGROUND UTILITIES PRIOR TO CONSTRUCTION. THE CONTRACTOR SHALL BE LIABLE FOR ANY DAMAGE CAUSED BY THE FAILURE TO DO SO.

SURVEY DISCLAIMER
 TOPOGRAPHIC SURVEY AND CONTOUR MAP USED IN PREPARING PLANS WAS PROVIDED BY VOY COMPANY, P.A., 535 S. EMPORIA, SUITE 104, WICHITA, KS. ENGINEER DOES NOT GUARANTEE SURVEY ELEVATIONS FOR ACCURACY. CONTRACTOR SHALL VERIFY ELEVATIONS AND NOTIFY ENGINEER OF ANY DISCREPANCIES.

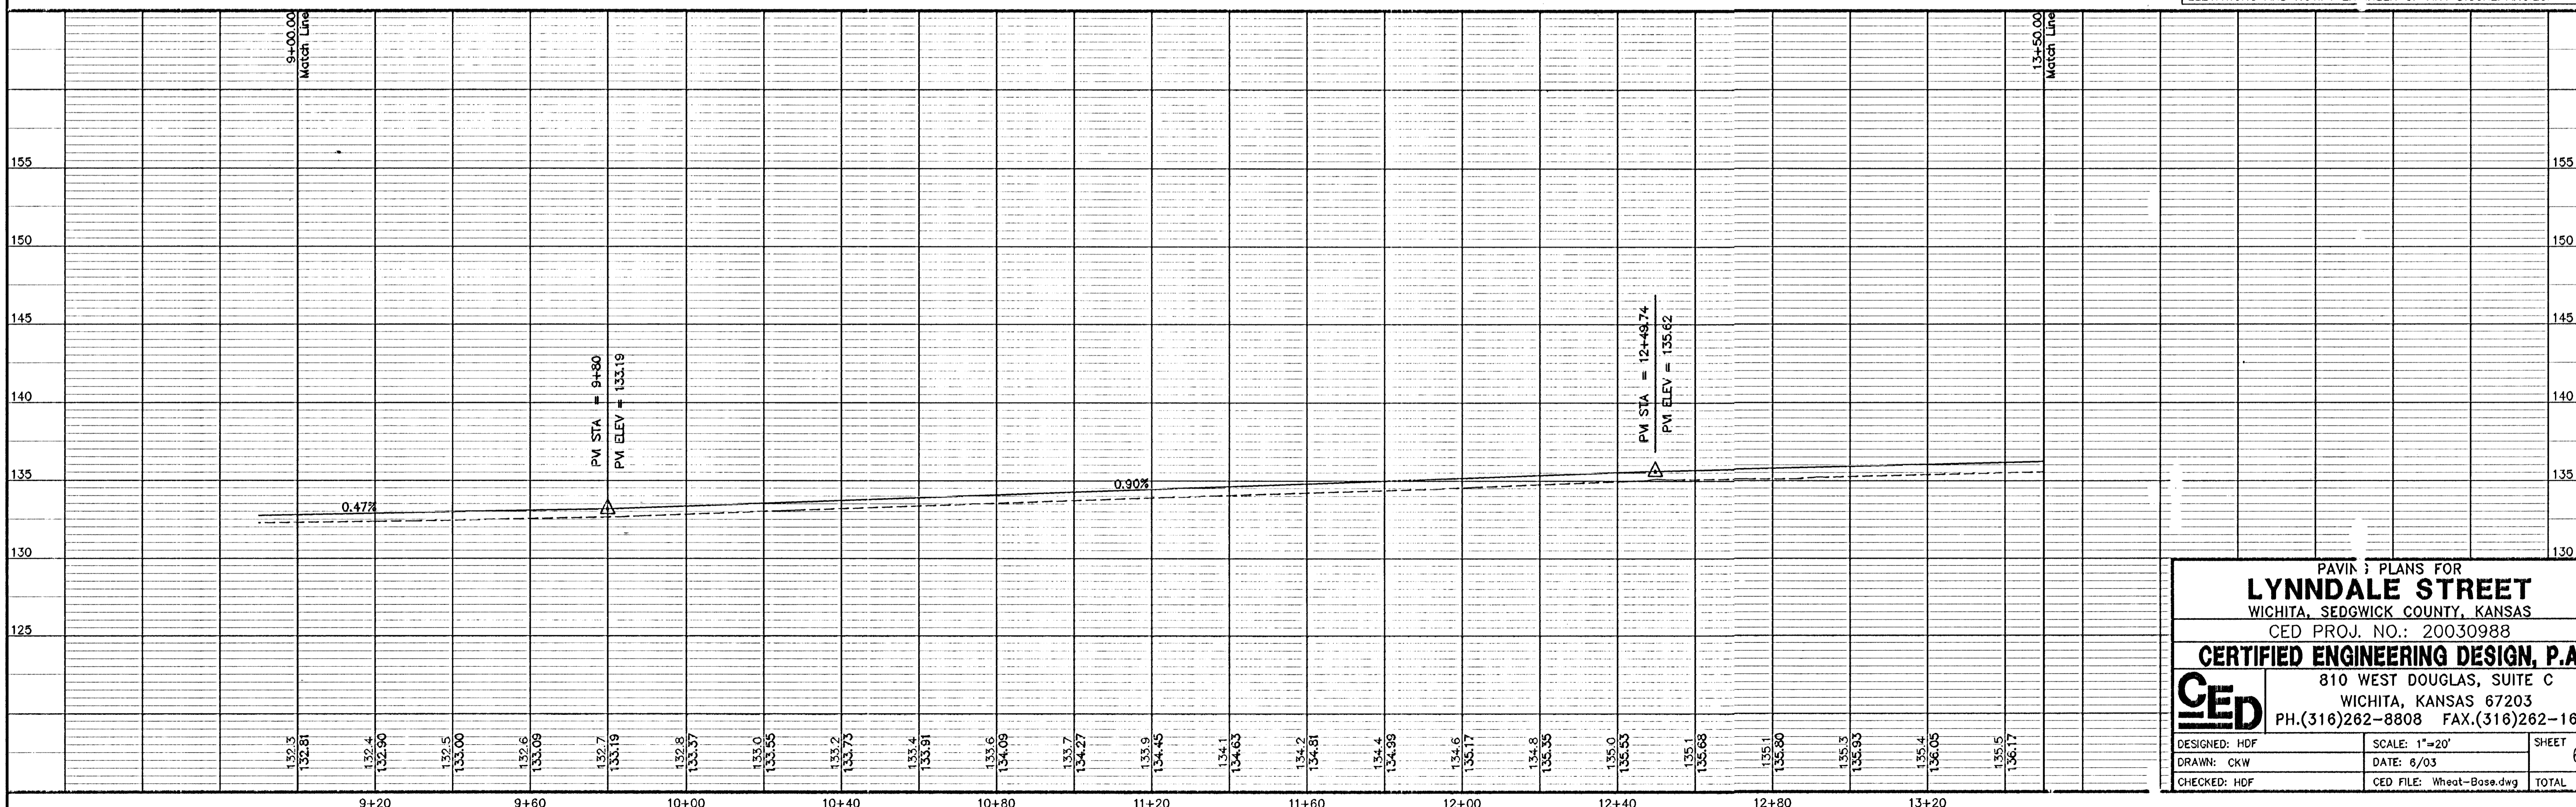

PAVING PLANS FOR
LYNDALE STREET
 WICHITA, SEDGWICK COUNTY, KANSAS
 CED PROJ. NO.: 20030988
CERTIFIED ENGINEERING DESIGN, P.A.
 810 WEST DOUGLAS, SUITE C
 WICHITA, KANSAS 67203
 PH.(316)262-8808 FAX.(316)262-1669

DESIGNED: HDF SCALE: 1"=20' SHEET: 6
 DRAWN: CKW DATE: 6/03 TOTAL: 43
 CHECKED: HDF CED FILE: Wheat-Bose.dwg