
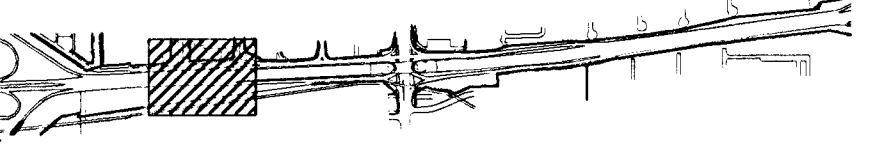
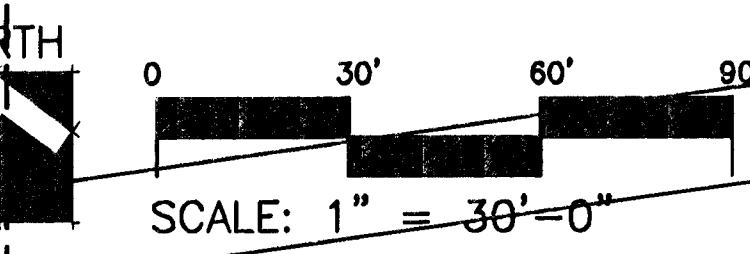


UTILITY OWNERS:
CITY OF WICHITA WATER AND SEWER DEPARTMENT (316) 268-4908
MULTIMEDIA CABLEVISION (316) 262-0661
SOUTHWEST BELL TELEPHONE 800-734-7630
WILLIAMS NATURAL GAS PIPELINE (918) 588-4200
KANSAS GAS AND ELECTRIC (316) 832-3169 OR 832-3180
CONTRACTOR TO VERIFY LOCATIONS OF ALL UTILITIES PRIOR TO DIGGING.

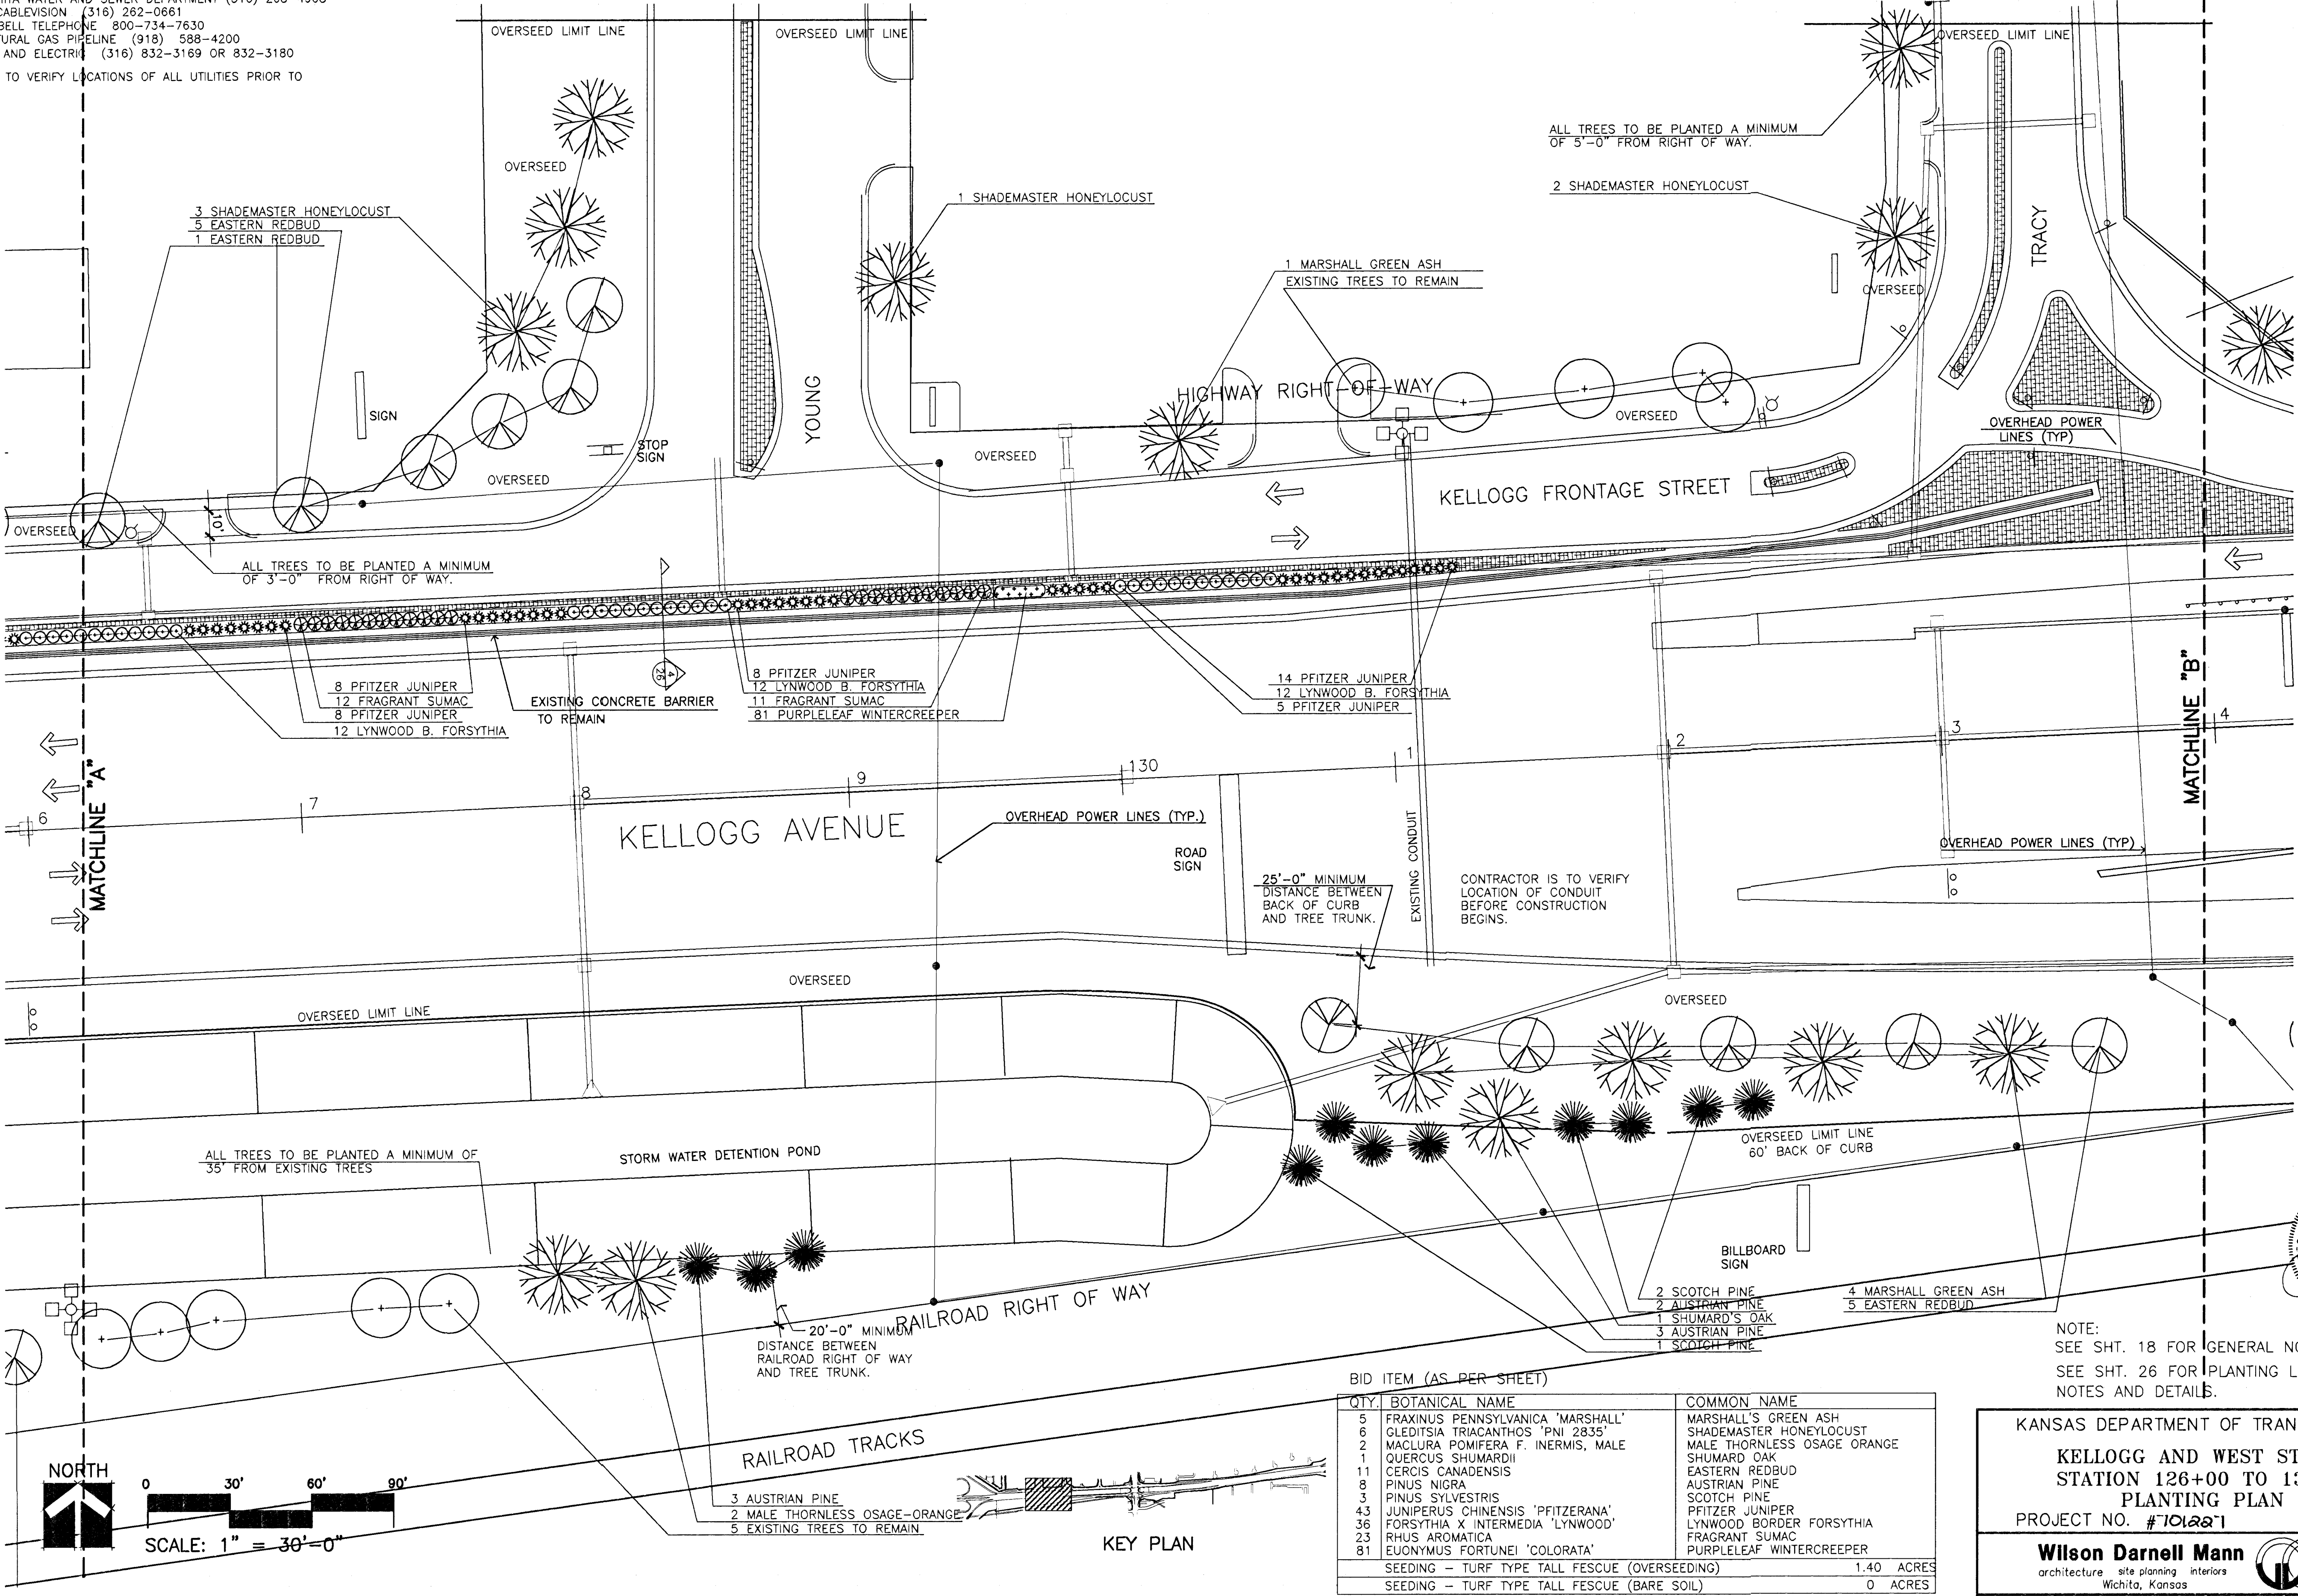

BID ITEM (AS PER SHEET)		
QTY.	BOTANICAL NAME	COMMON NAME
5	FRAXINUS PENNSYLVANICA 'MARSHALL'	MARSHALL'S GREEN ASH
6	GLEDITSIA TRIACANTHOS 'PNI 2835'	SHADEMASTER HONEYLOCUST
2	MACLURA POMIFERA F. INERMIS, MALE	MALE THORNLESS OSAGE ORANGE
1	QUERCUS SHUMARDII	SHUMARD OAK
11	CERCIS CANADENSIS	EASTERN REDBUD
8	PINUS NIGRA	AUSTRIAN PINE
3	PINUS SYLVESTRIS	SCOTCH PINE
43	JUNIPERUS CHINENSIS 'PFITZERANA'	PFITZER JUNIPER
36	FORSYTHIA X INTERMEDIA 'LYNWOOD'	LYNWOOD BORDER FORSYTHIA
23	RHUS AROMATICA	FRAGRANT SUMAC
81	EUONYMUS FORTUNEI 'COLORATA'	PURPLELEAF WINTERCREEPER
SEEDING - TURF TYPE TALL FESCUE (OVERSEEDING)		1.40 ACRES
SEEDING - TURF TYPE TALL FESCUE (BARE SOIL)		0 ACRES

NOTE:
SEE SHT. 18 FOR GENERAL NOTES.
SEE SHT. 26 FOR PLANTING LEGEND,
NOTES AND DETAILS.

KANSAS DEPARTMENT OF TRANSPORTATION

KELLOGG AND WEST STREET
STATION 126+00 TO 134+00
PLANTING PLAN

PROJECT NO. #101221

Wilson Darnell Mann
architecture site planning interiors
Wichita, Kansas

DESIGNED BY: WDM, PA

CHECKED BY: LME

DRAWN BY: SKW

DATE: 7/31/97

SHEET 19 OF 43

