



UTILITY OWNERS:
CITY OF WICHITA WATER AND SEWER DEPARTMENT (316) 268-4908
MULTIMEDIA CABLEVISION (316) 262-0661
SOUTHWEST BELL TELEPHONE 800-734-7630
WILLIAMS NATURAL GAS PIPELINE (918) 588-4200
KANSAS GAS AND ELECTRIC (316) 832-3169 OR 832-3180

CONTRACTOR TO VERIFY LOCATIONS OF ALL UTILITIES PRIOR TO DIGGING.

FHWA REG NO.	STATE	PROJECT NO.	YEAR	SHEET NO.	SHEETS
7	KANSAS	54-87-TE-0039-01	1997	24	43

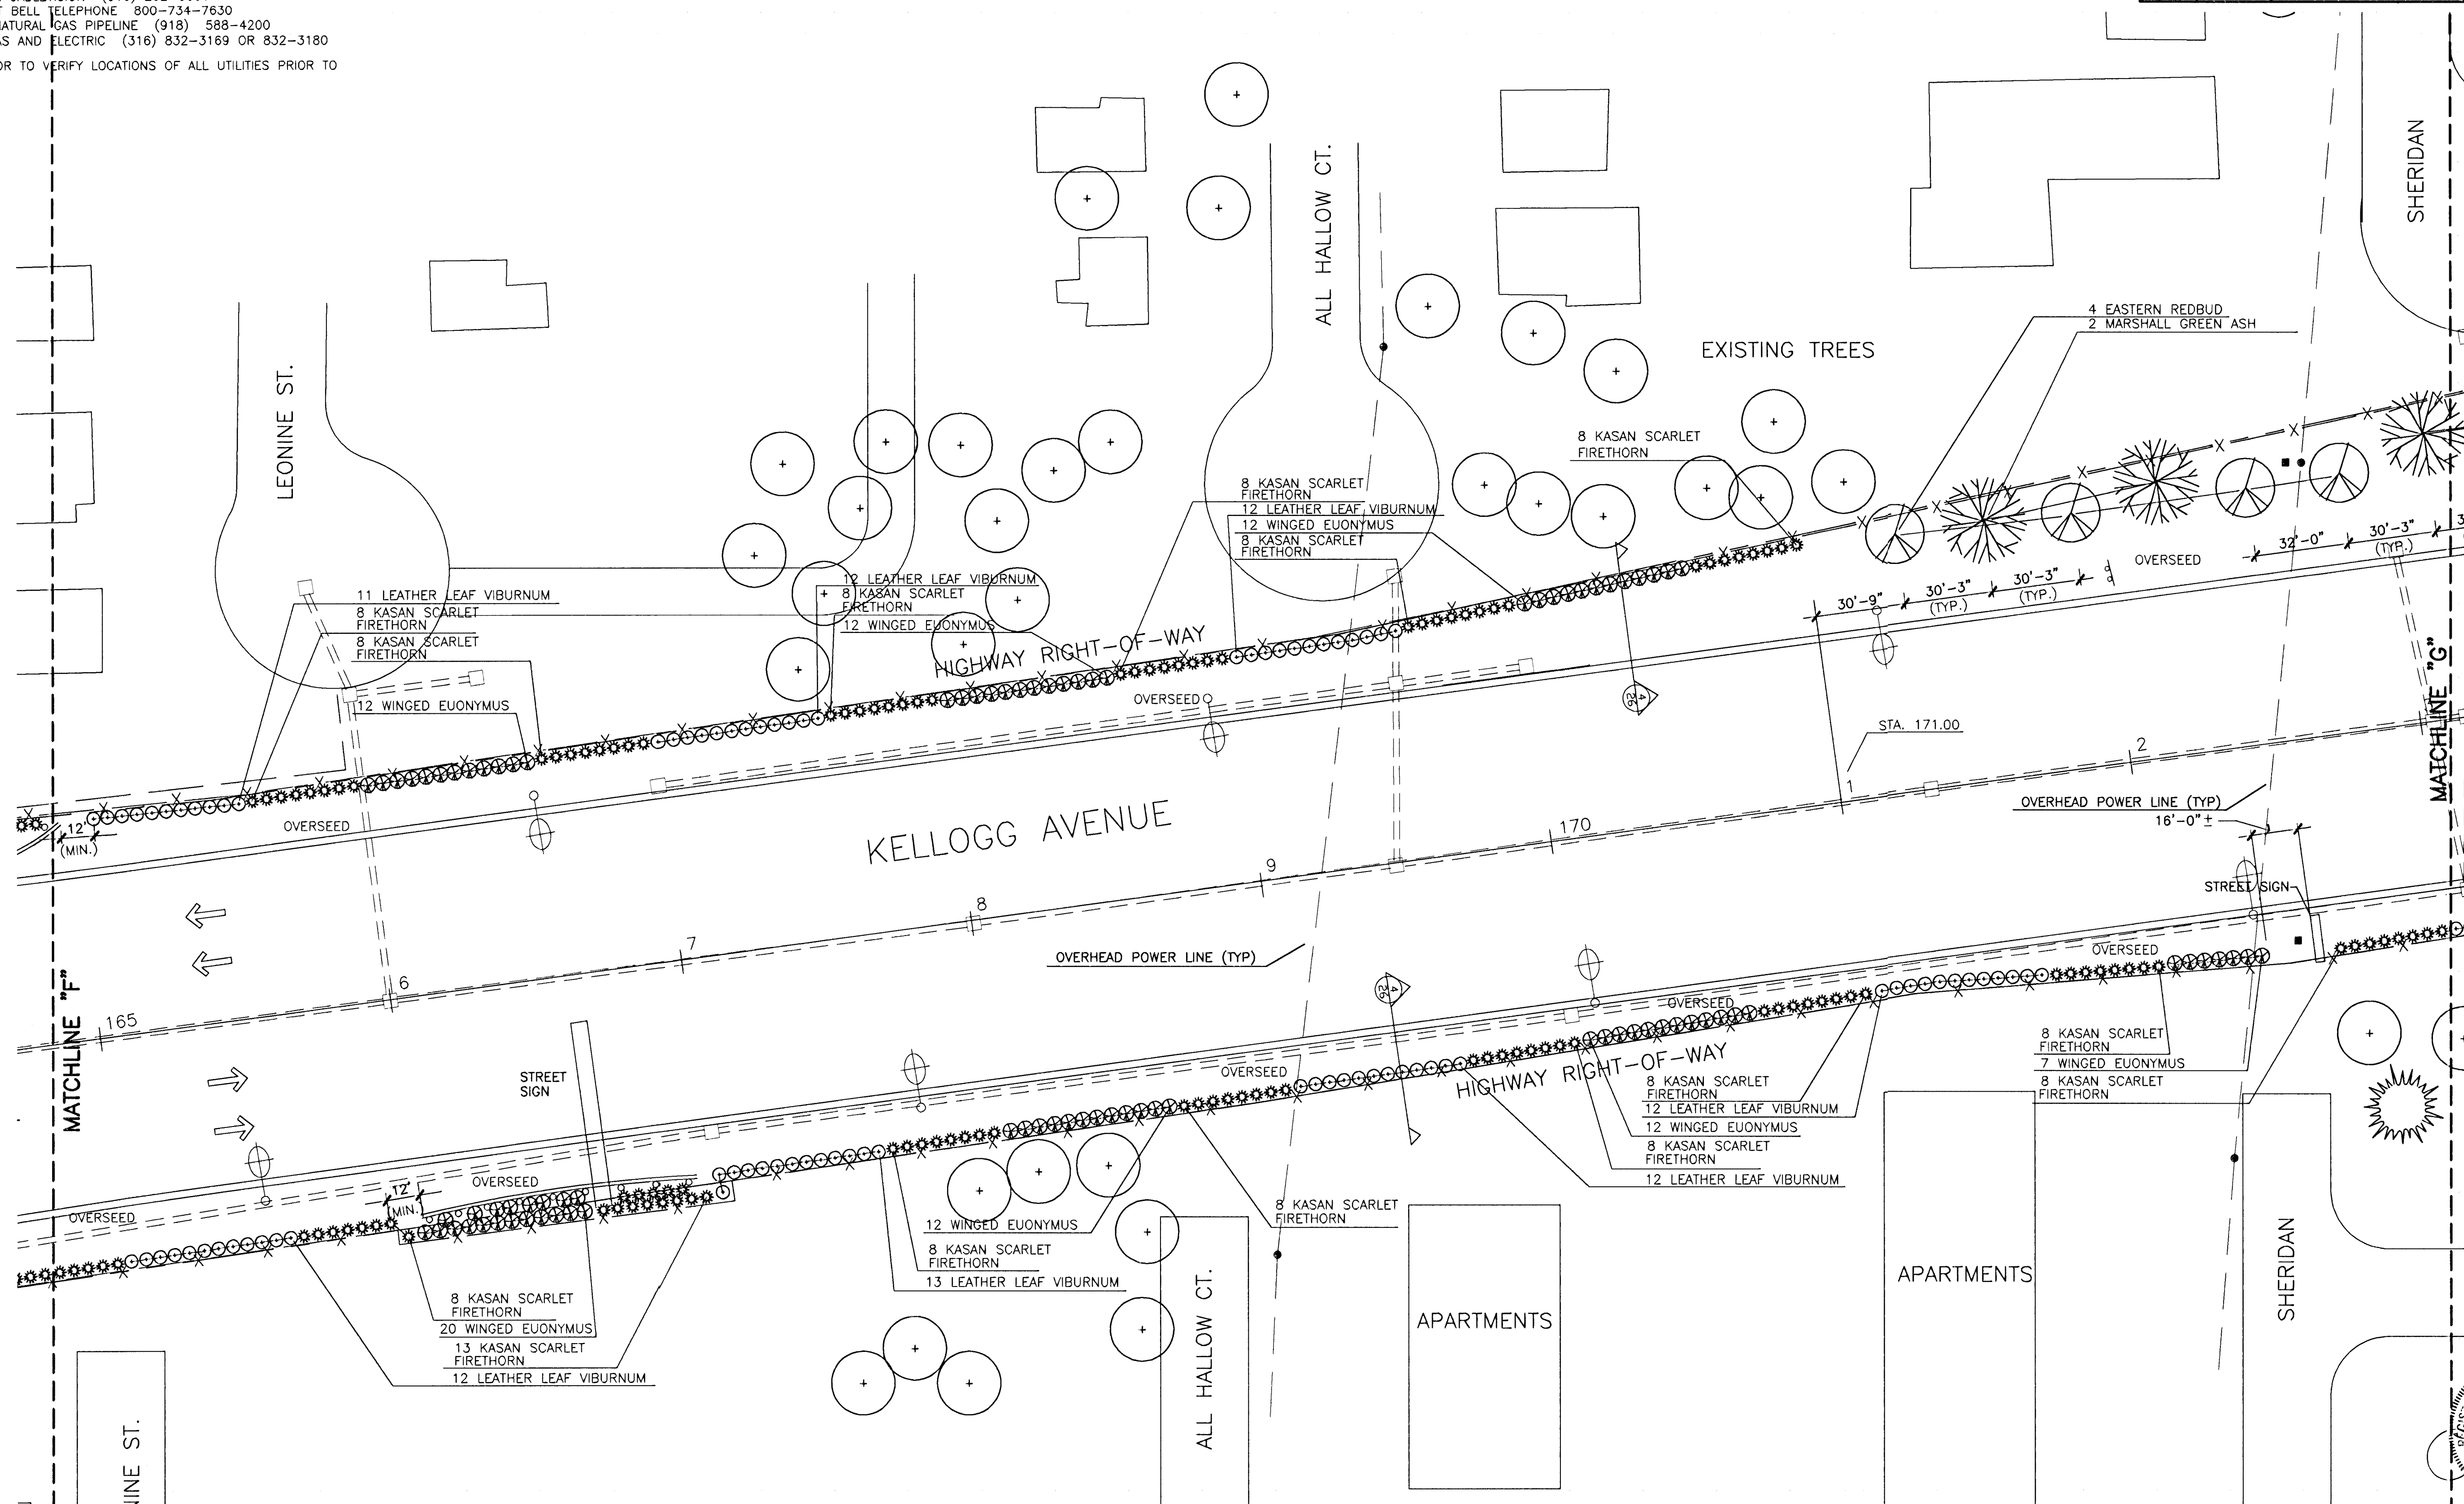

SCALE: 1" = 30'-0"

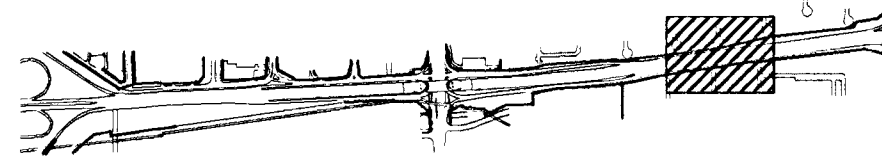

KEY PLAN

NOTE:
SEE SHT. 18 FOR GENERAL NOTES.
SEE SHT. 26 FOR PLANTING LEGEND,
NOTES AND DETAILS.

BID ITEM (AS PER SHEET)		
QTY.	BOTANICAL NAME	COMMON NAME
2	FRAXINUS PENNSYLVANICA "MARSHALL"	MARSHALL GREEN ASH
4	CERCIS CANADENSIS	EASTERN REDBUD
117	PYRACANTHA COCCINEA "KASAN"	KASAN SCARLET FIRETHORN
87	EUONYMUS ALATA	WINGED EUONYMUS
84	VIBURNUM RHYTIDOPHYLLUM	LEATHER LEAF VIBURNUM
SEEDING - TURF TYPE TALL FESCUE (OVERSEEDING)		.67 ACRES
SEEDING - TURF TYPE TALL FESCUE (BARE SOIL)		0 ACRES

KANSAS DEPARTMENT OF TRANSPORTATION

KELLOGG AND WEST STREET
STATION 165+00 TO 173+00
PLANTING PLAN
PROJECT NO. #701221

Wilson Darnell Mann
architecture site planning interiors
Wichita, Kansas



DESIGNED BY: WDM, PA	CHECKED BY: LME
DRAWN BY: SKW	DATE: 7/31/97 SHEET 24 OF 43