
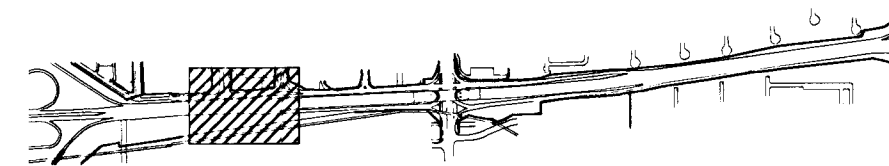
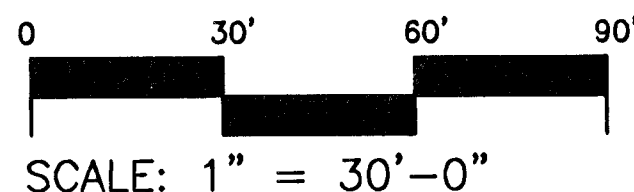
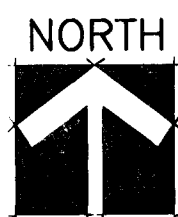
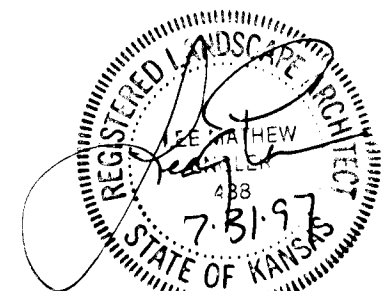


FHWA REG NO.	STATE	PROJECT NO.	YEAR	SHEET NO.	SHEETS
7	KANSAS	54-87-TE-0039-01	1997	28	43

UTILITY OWNERS:
CITY OF WICHITA WATER AND SEWER DEPARTMENT (316) 268-4908
MULTIMEDIA CABLEVISION (316) 262-0661
SOUTHWEST BELL TELEPHONE 800-734-7630
WILLIAMS NATURAL GAS PIPELINE (918) 588-4200
KANSAS GAS AND ELECTRIC (316) 832-3169 OR 832-3180
CONTRACTOR TO VERIFY LOCATIONS OF ALL UTILITIES PRIOR TO DIGGING.

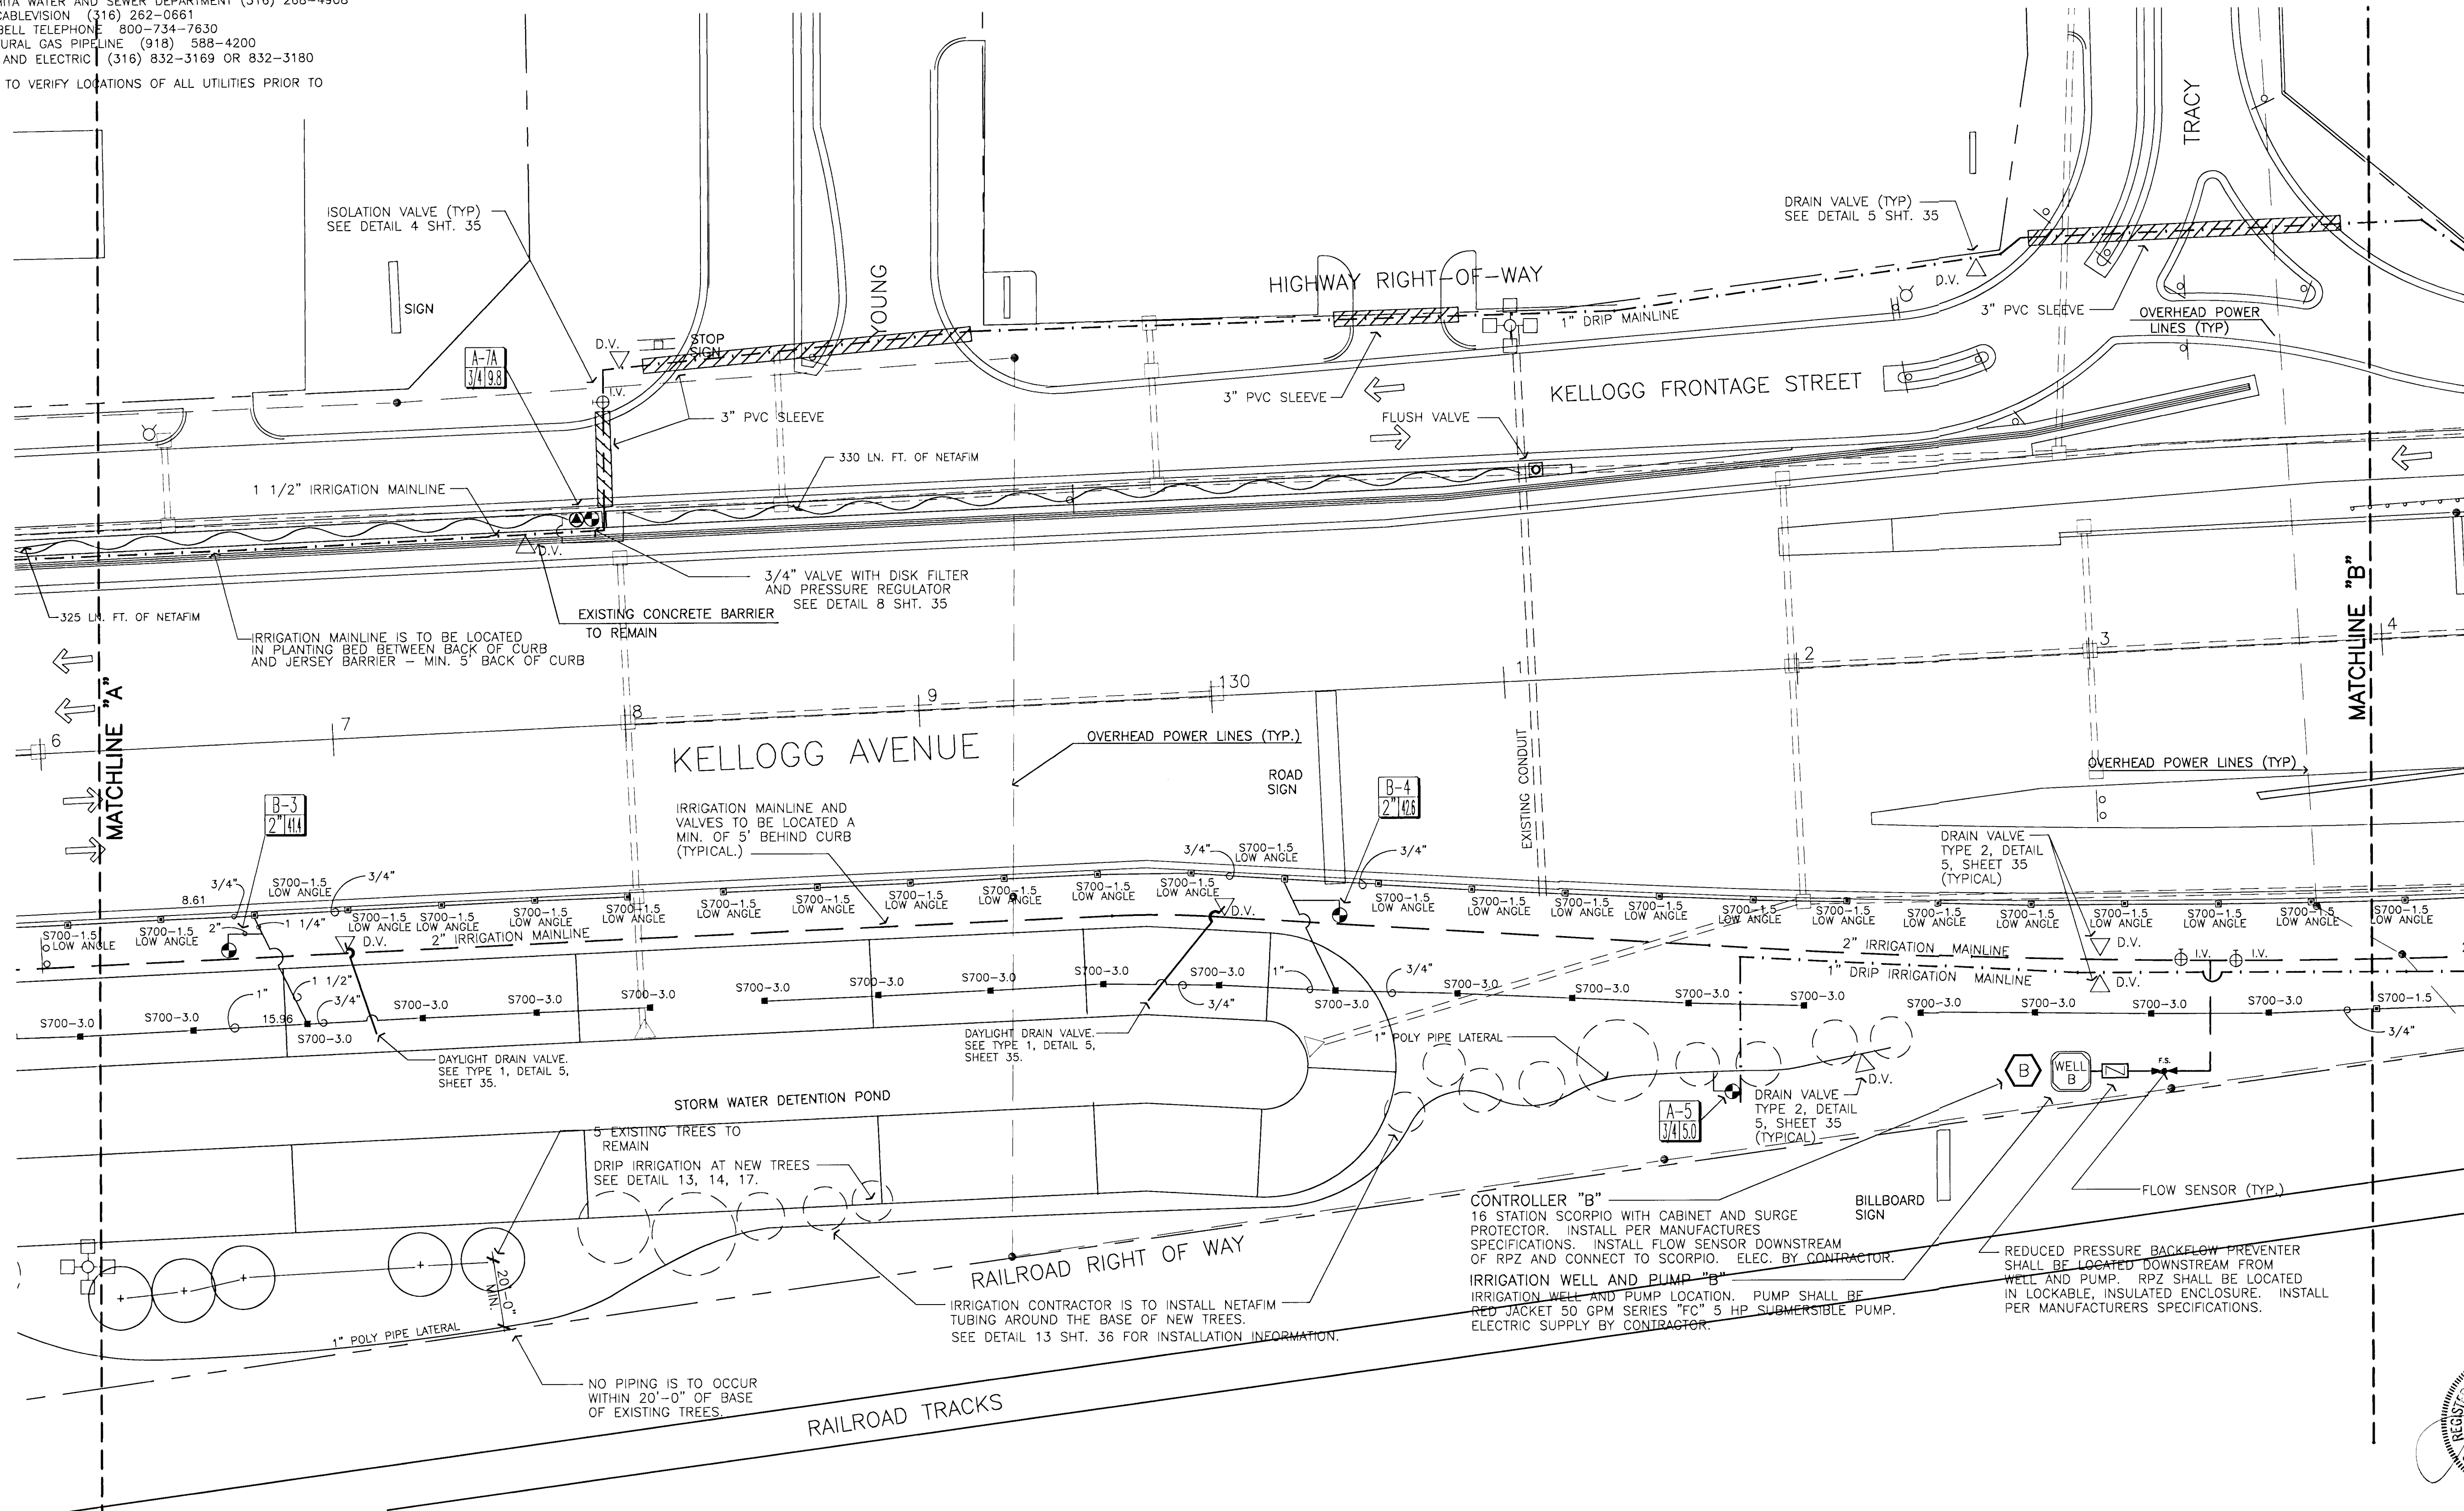

KEY PLAN

NOTE:
SEE SHEETS 35 AND 36 FOR IRRIGATION DETAILS
SEE SHEET 37 FOR IRRIGATION NOTES AND LEGEND

KANSAS DEPARTMENT OF TRANSPORTATION

KELLOGG AND WEST STREET
STATION 126+00 TO 134+00
IRRIGATION PLANS
PROJECT NO. #701227

Wilson Darnell Mann
architecture site planning interiors
Wichita, Kansas



DESIGNED BY: WDM, PA	CHECKED BY: LME
DRAWN BY: SKW	DATE: 7/31/97 SHEET 28 OF 43

2-17-97
E:\94082\ALL-2
E:\94082\MAINBASE E:\94082\IRIG