



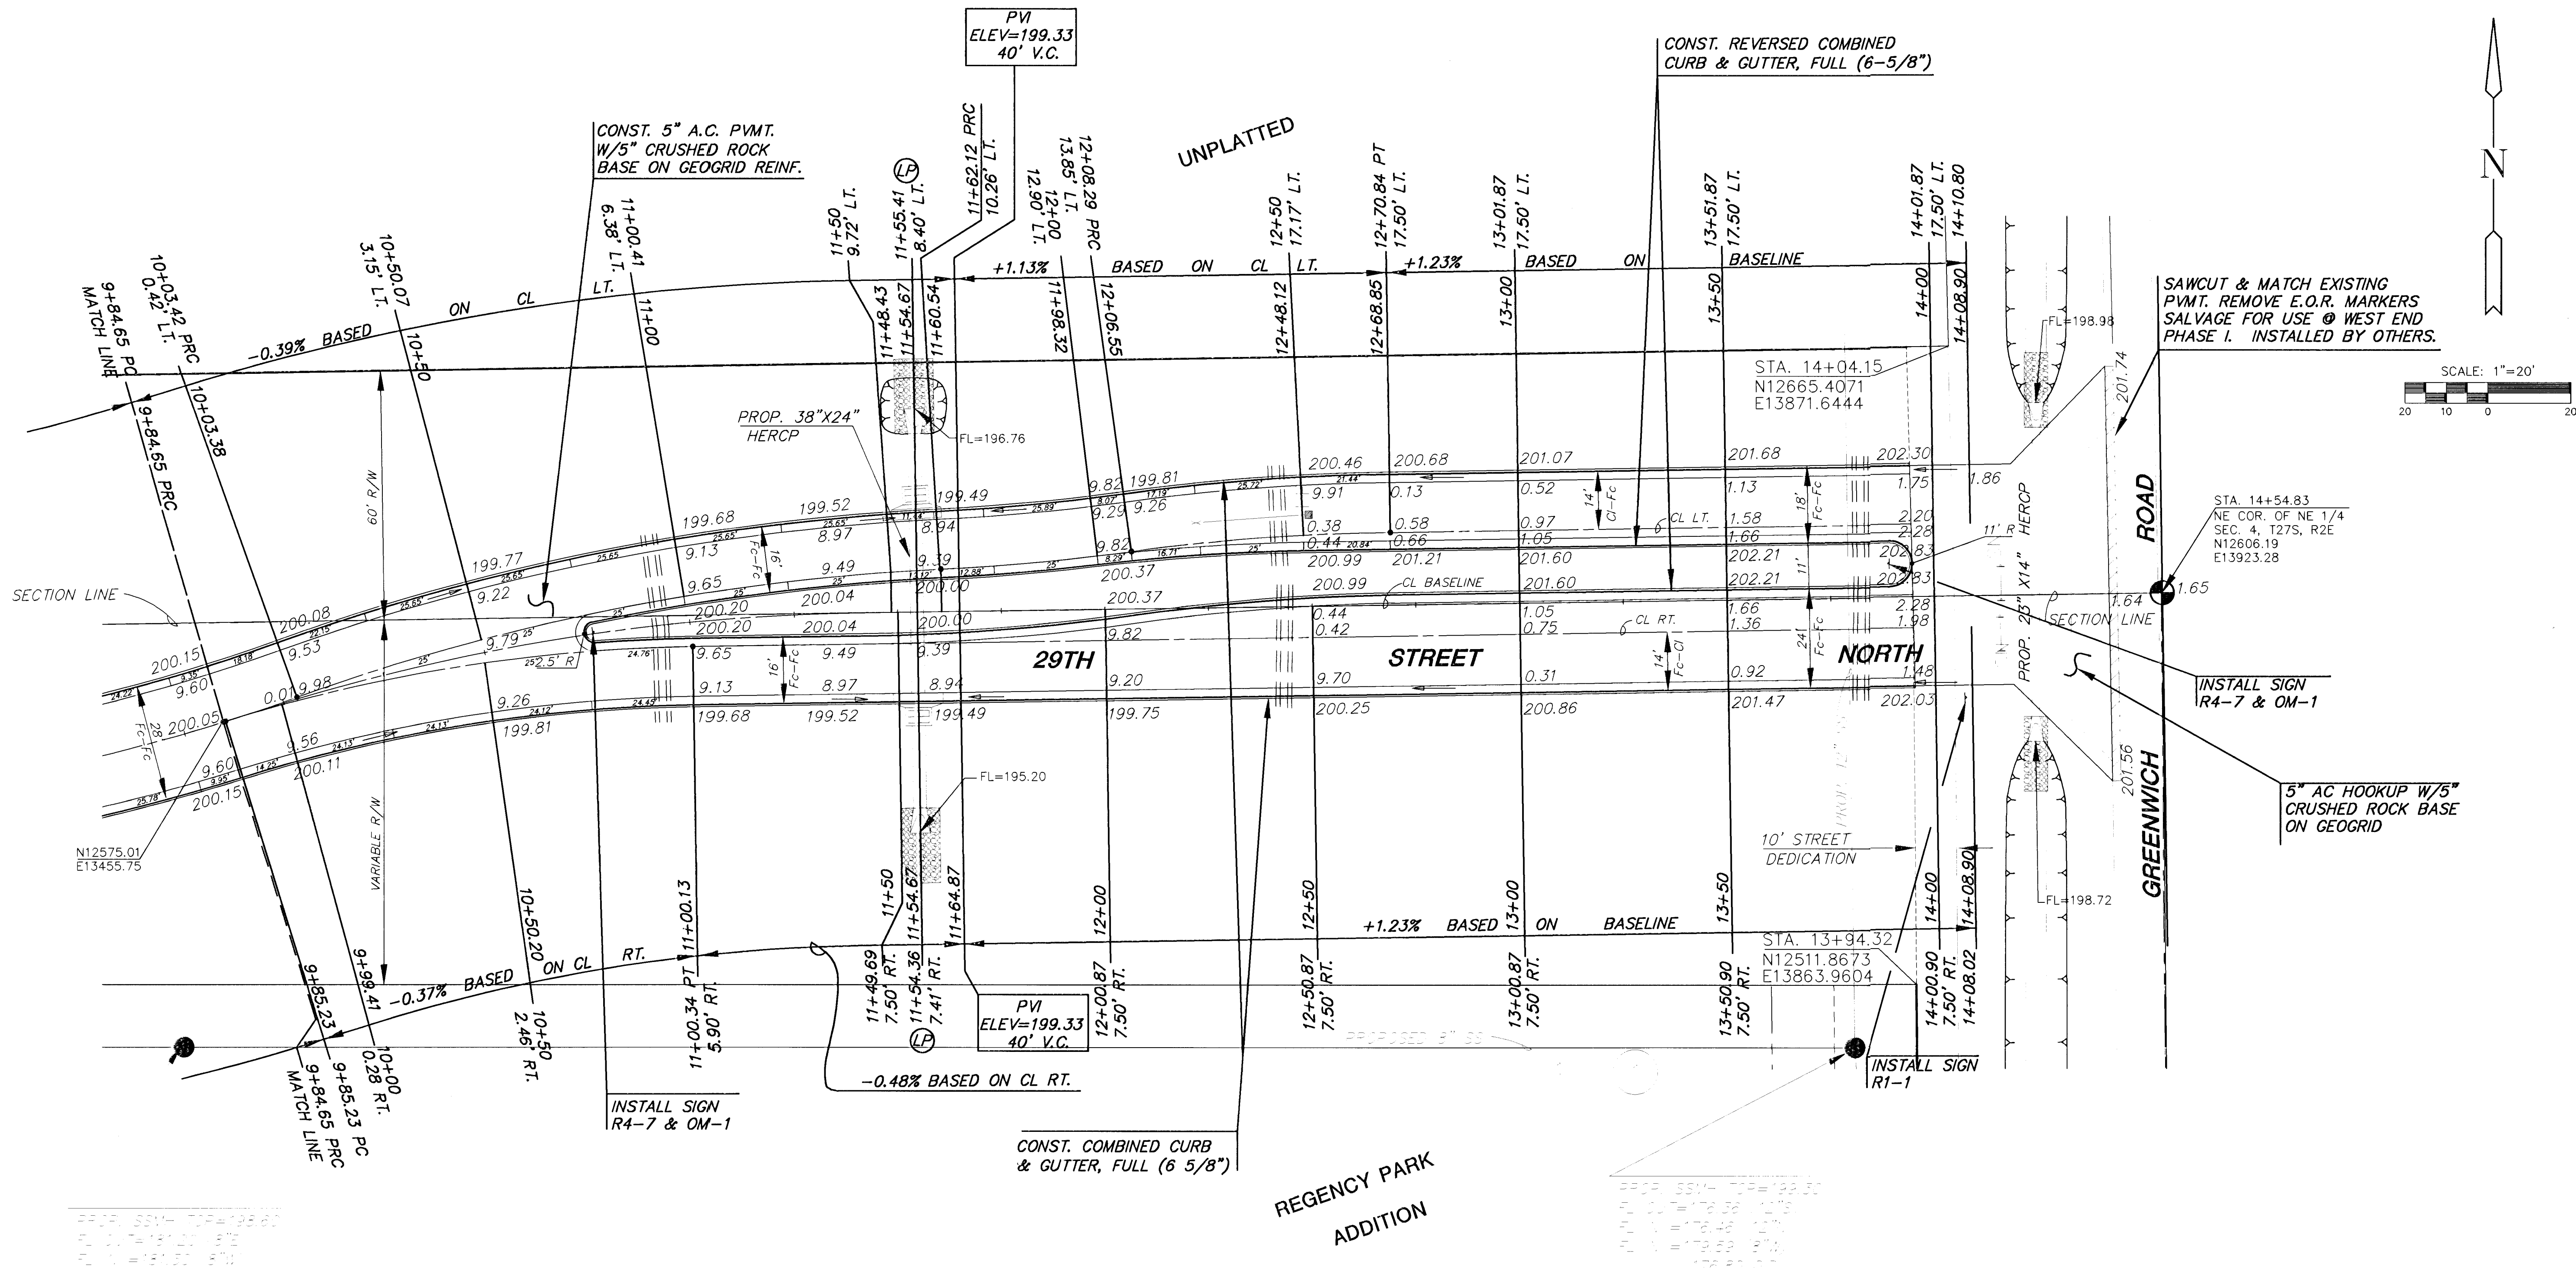

LEGEND

==== (2) 6" PVC PIPE SLEEVES

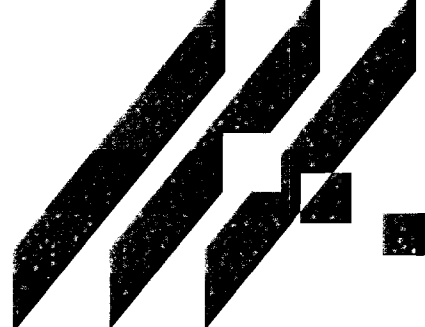

MID-KANSAS ENGINEERING
CONSULTANTS, INC.
411 N. WEBB ROAD
WICHITA, KS. 67206
316-684-9600

**NORTHEAST BASEBALL/SOCCER
COMPLEX - PHASE 2**
PROJECT NAME

PAVING PLANS
SHEET TITLE

JTC DESIGN BY:	DAC DRAWN BY:	JTC CHECKED BY:
AUGUST 1999 DATE	98026 JOB NO.	6 / 15 SHEET/OF