


PLOTTED: Thursday, July 15, 2021 @ 11:28AM

J:\PROJECTS\2019\1901010483_COW_BOTANICA PARKING EXPANSION_L 190483 CAD\SH10 BLDG MEPELECT\190483 - POWER PLANS.DWG

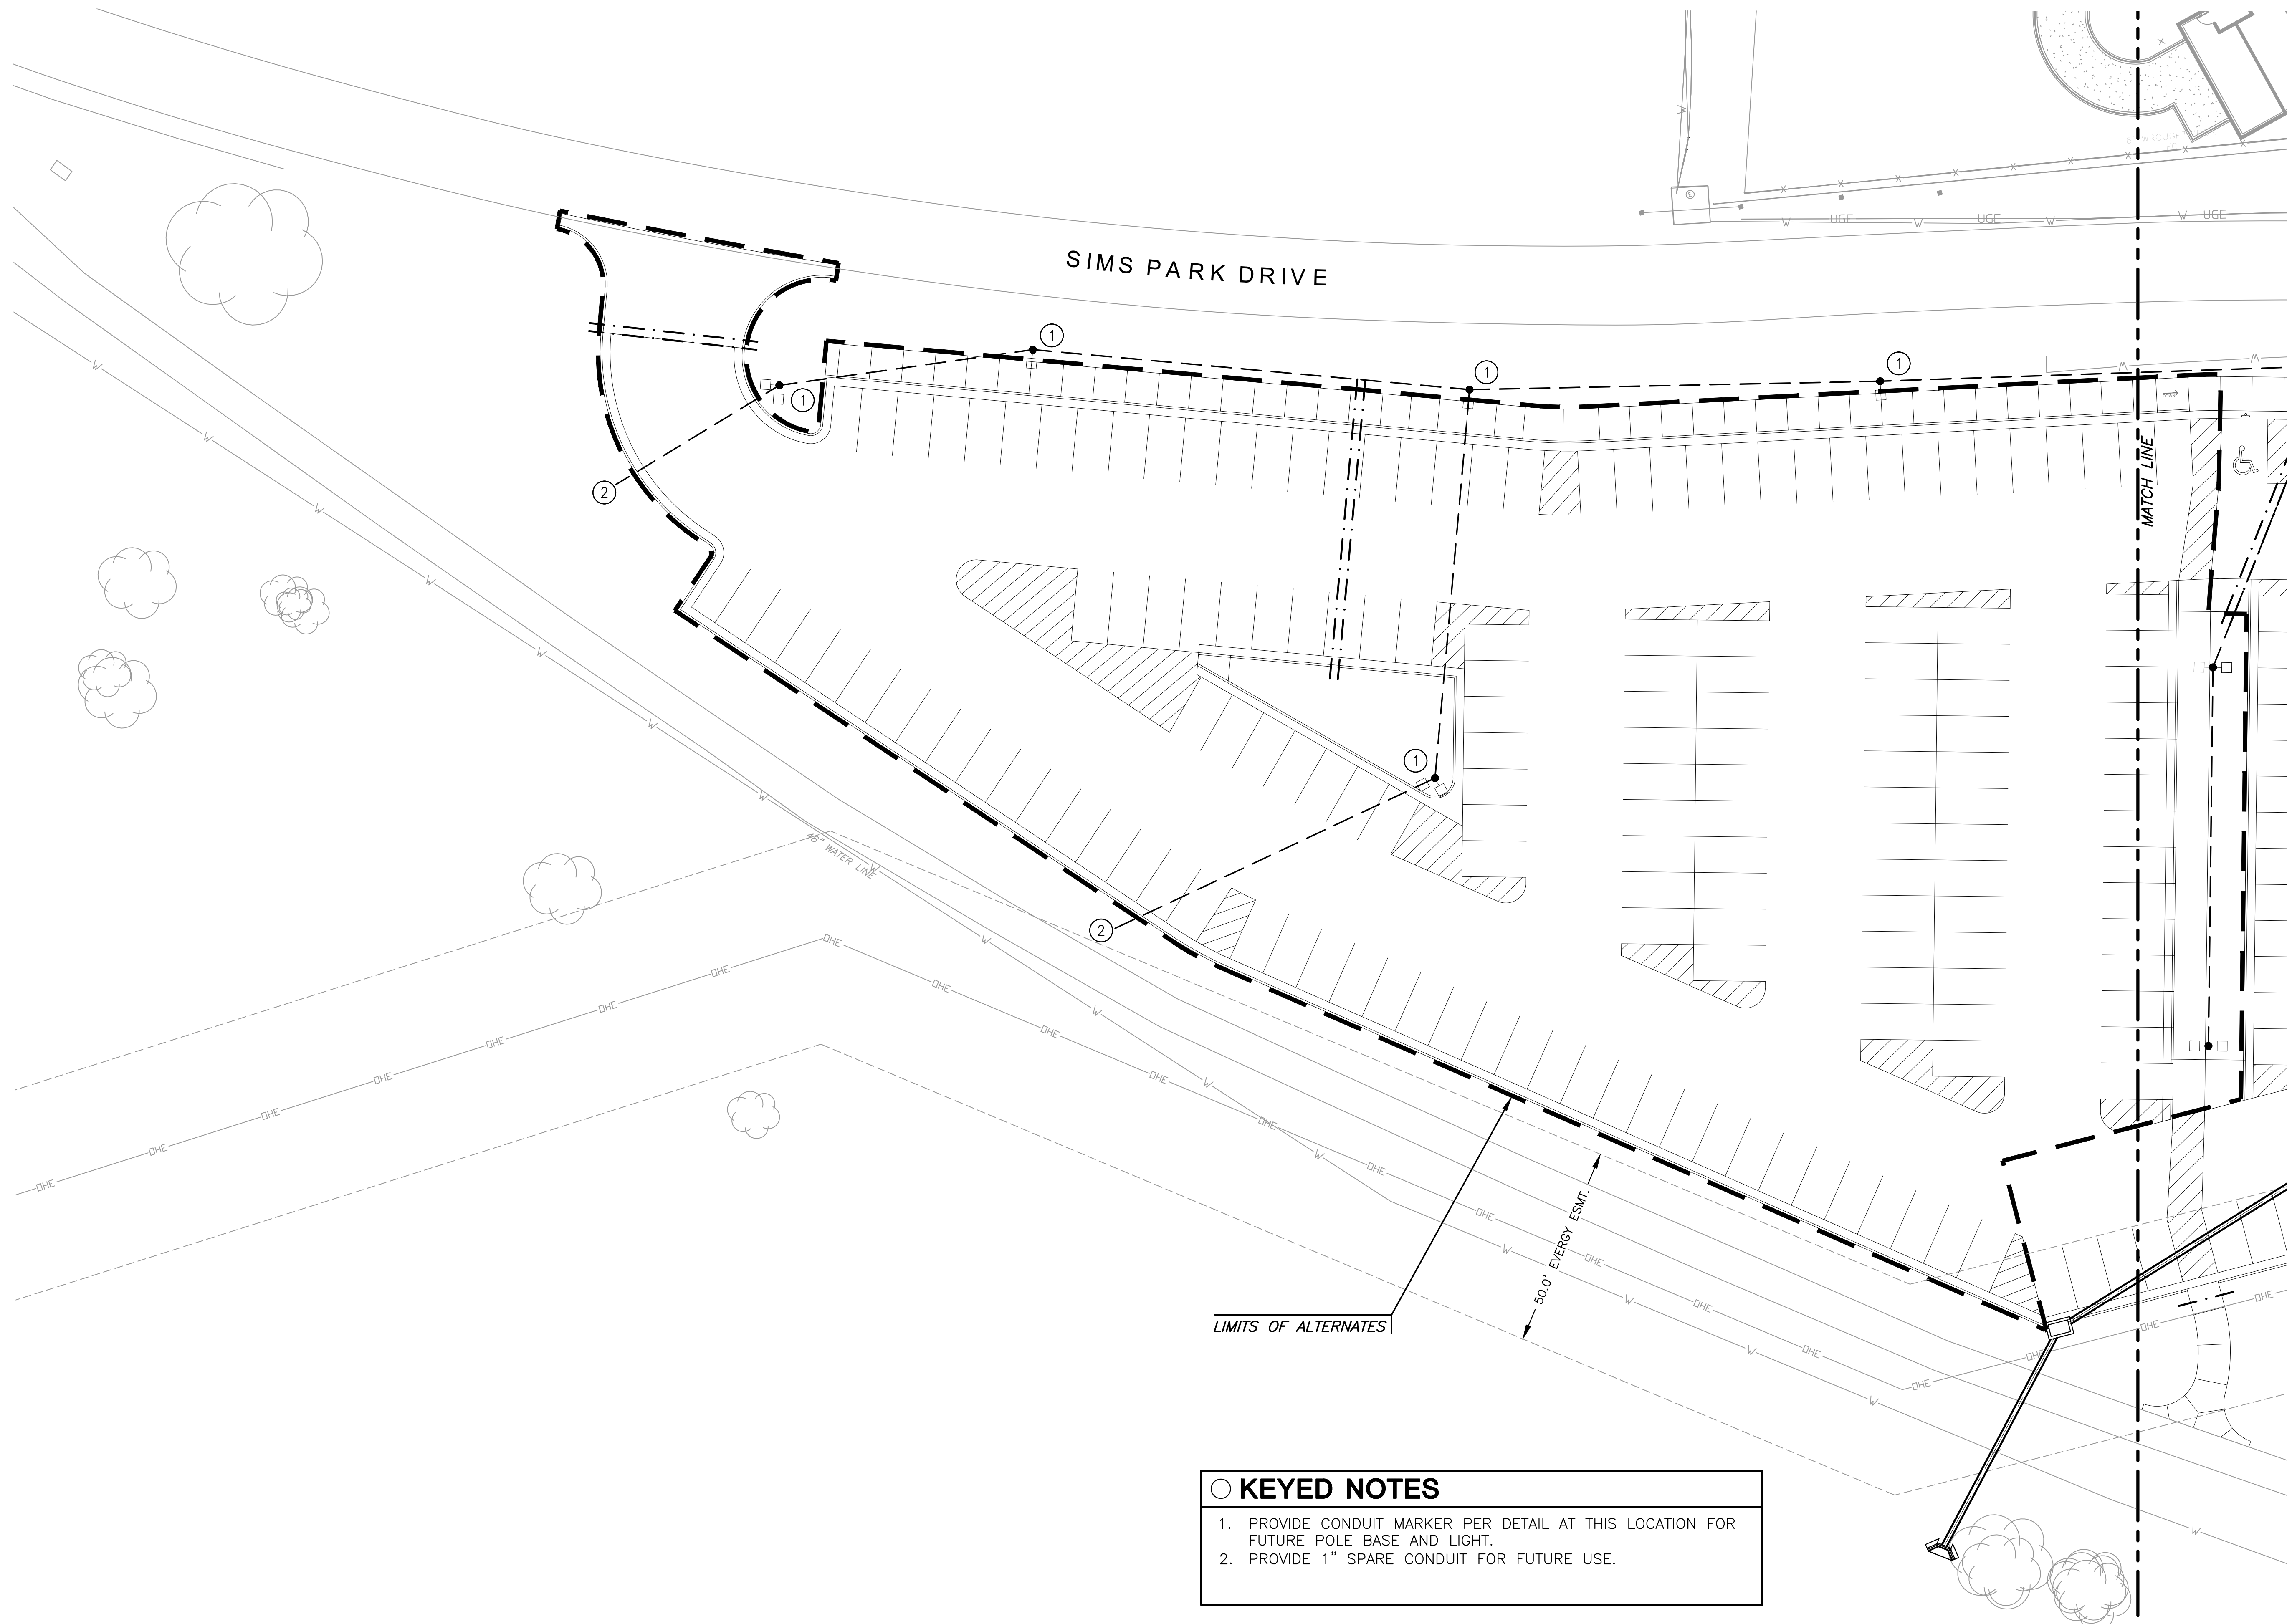

- KEYED NOTES**
1. PROVIDE CONDUIT MARKER PER DETAIL AT THIS LOCATION FOR FUTURE POLE BASE AND LIGHT.
 2. PROVIDE 1" SPARE CONDUIT FOR FUTURE USE.

PAVING & DRAINAGE FOR
BOTANICA GARDENS PARKING LOT
WICHITA, KANSAS

©2021
MKEC Engineering
All Rights Reserved
www.mkec.com
These drawings and their contents, including, but not limited to, all concepts, designs, & ideas are the exclusive property of MKEC Engineering (MKEC), and may not be used or reproduced in any way without the express consent of MKEC.

**ELECTRICAL
CONDUIT PLAN 1**

PROJECT NO.	482-11034
DATE	JULY 2021
SCALE	1"=20'
DESIGNED	JRBW
DRAWN	KKL
CHECKED	JRBW

NO.	REVISION	DATE