


©2022 MKEC Engineering All Rights Reserved www.mkec.com
These drawings and their contents, including, but not limited to, all concepts, designs, & ideas are the exclusive property of MKEC Engineering (MKEC), and may not be used or reproduced in any way without the express consent of MKEC.

**POND D & E,
POND F & G
SITE PLAN**


PROJECT NO.		
DATE	01/20/2022	
SCALE	1"=10'	
DESIGNED	DRAWN	CHECKED
JRA	RAM	JRA
NO.	REVISION	DATE

SHEET NO.
5 OF 24

NOTE:
BRIDGE WORK SHALL BE COMPLETED AND THE CART PATH REOPENED PRIOR TO COMPLETING RISER AND PIPE IMPROVEMENTS.

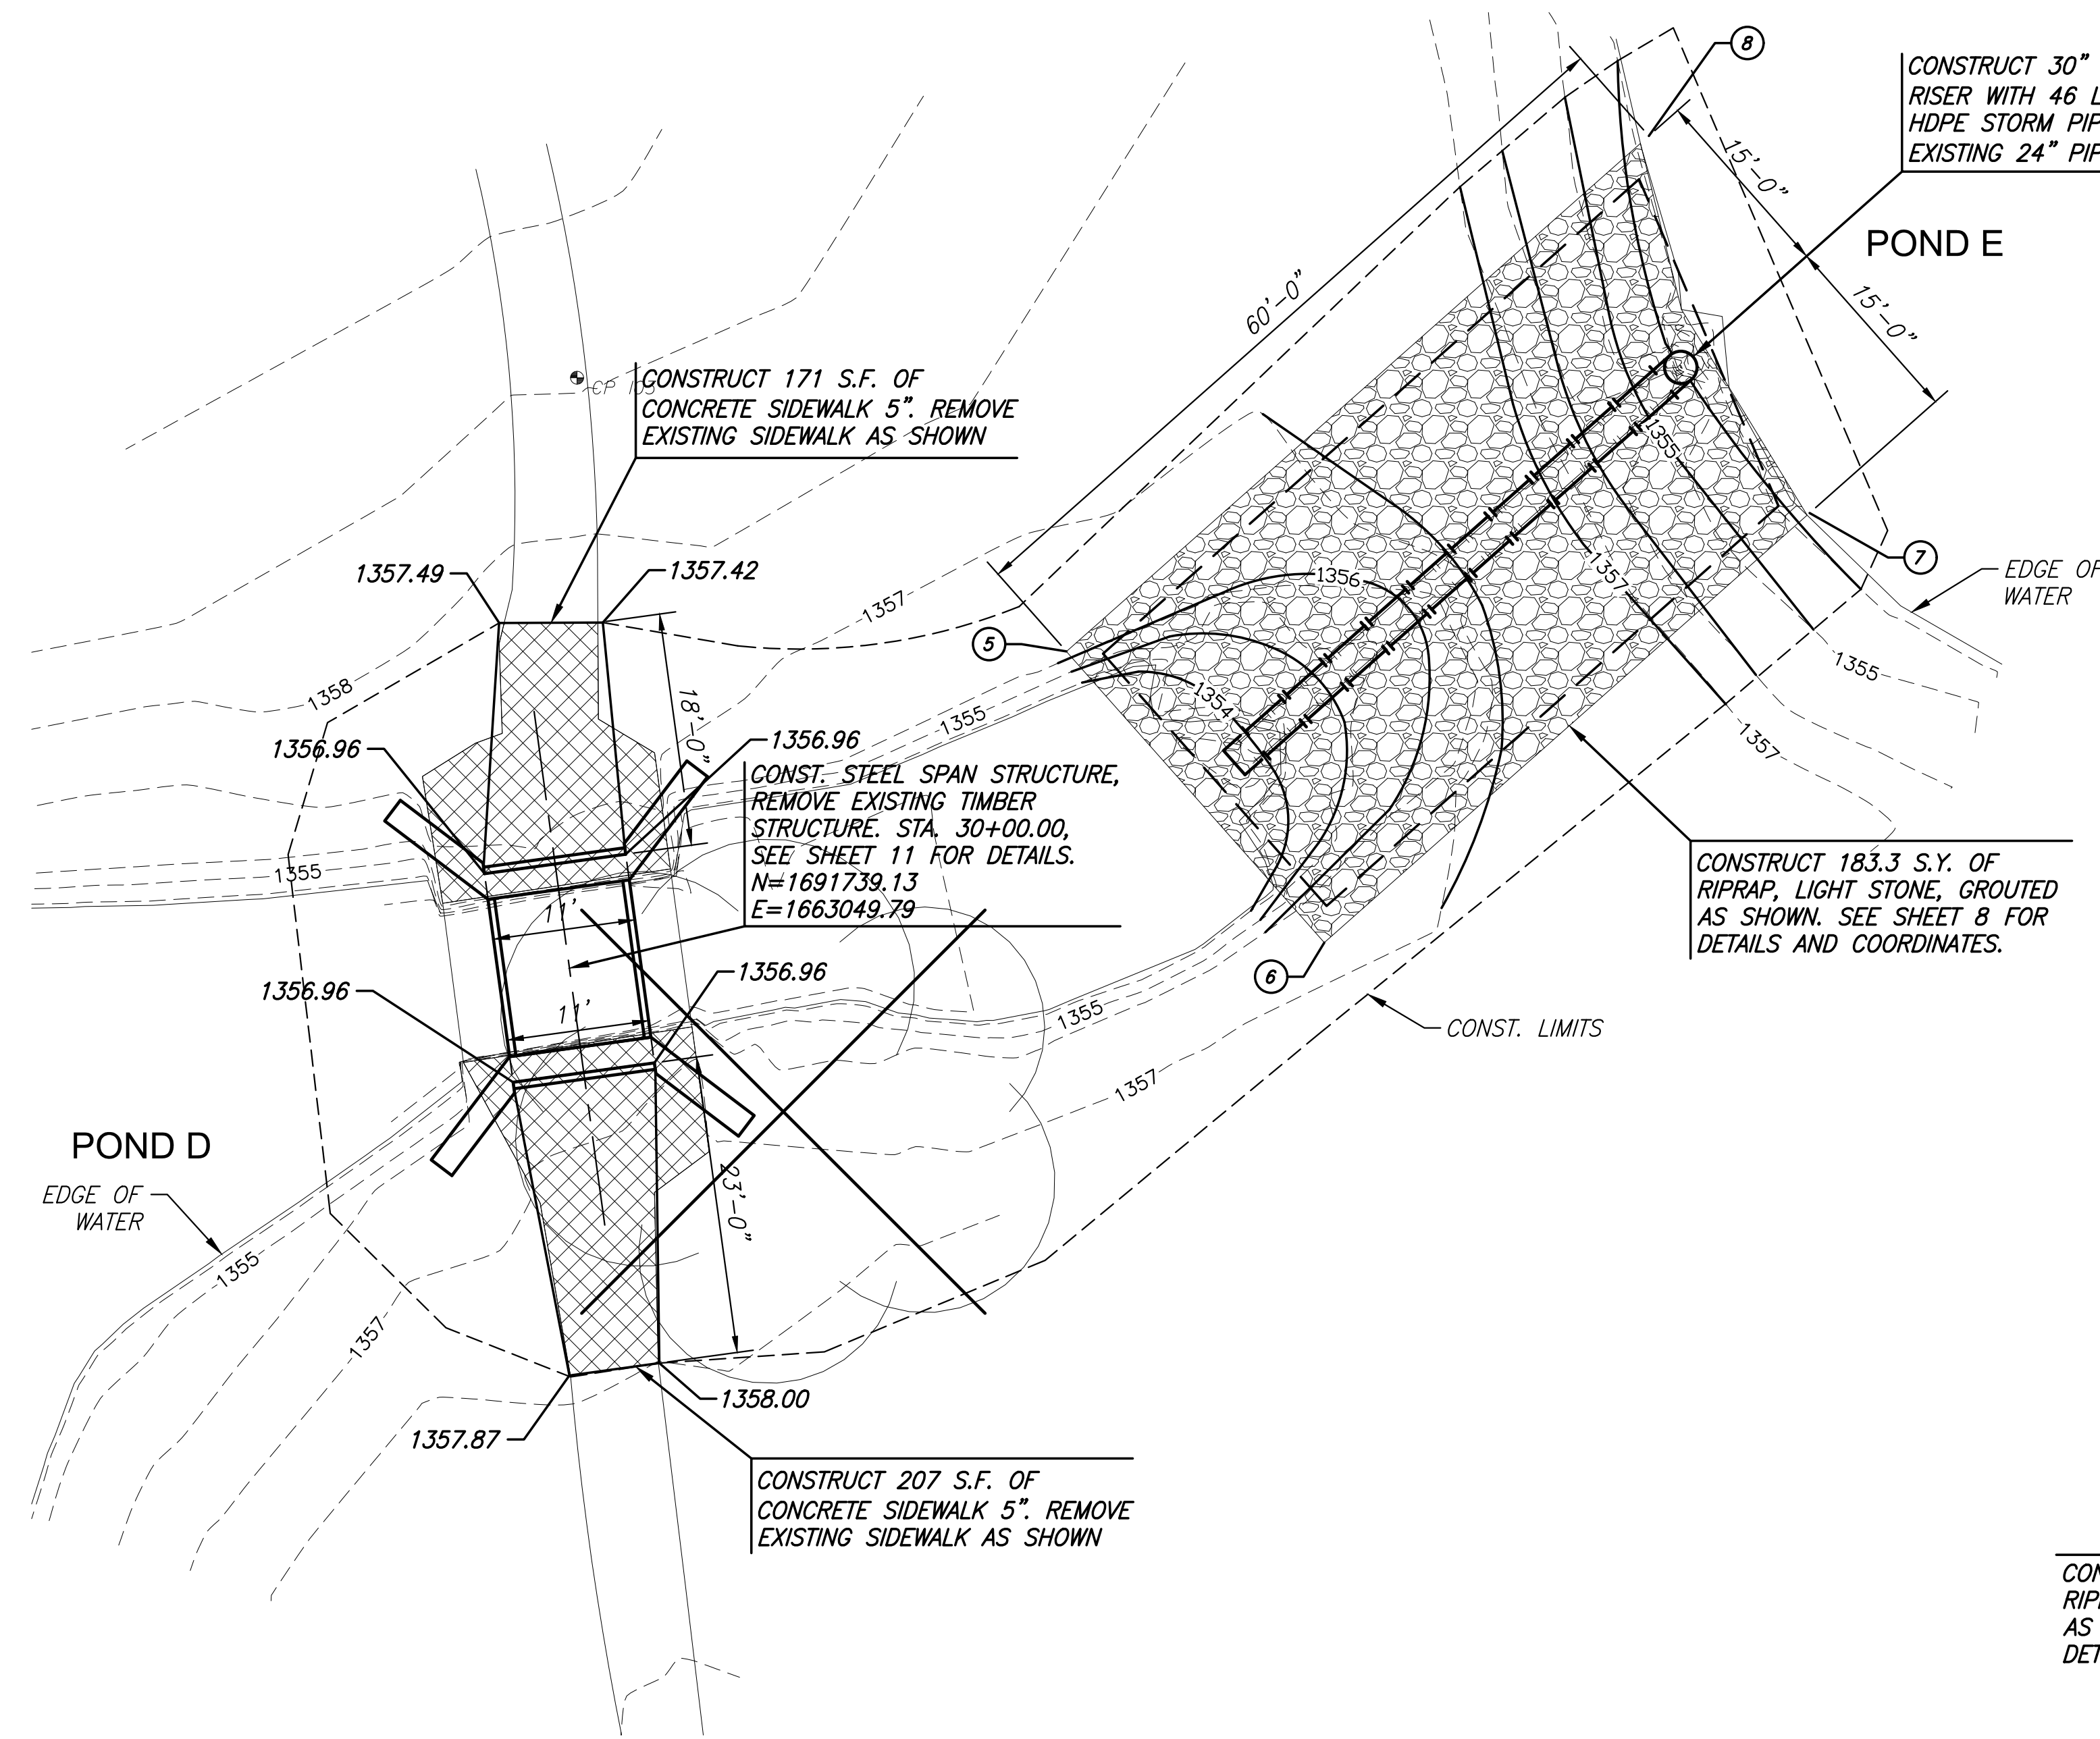


POND D & E SITE PLAN

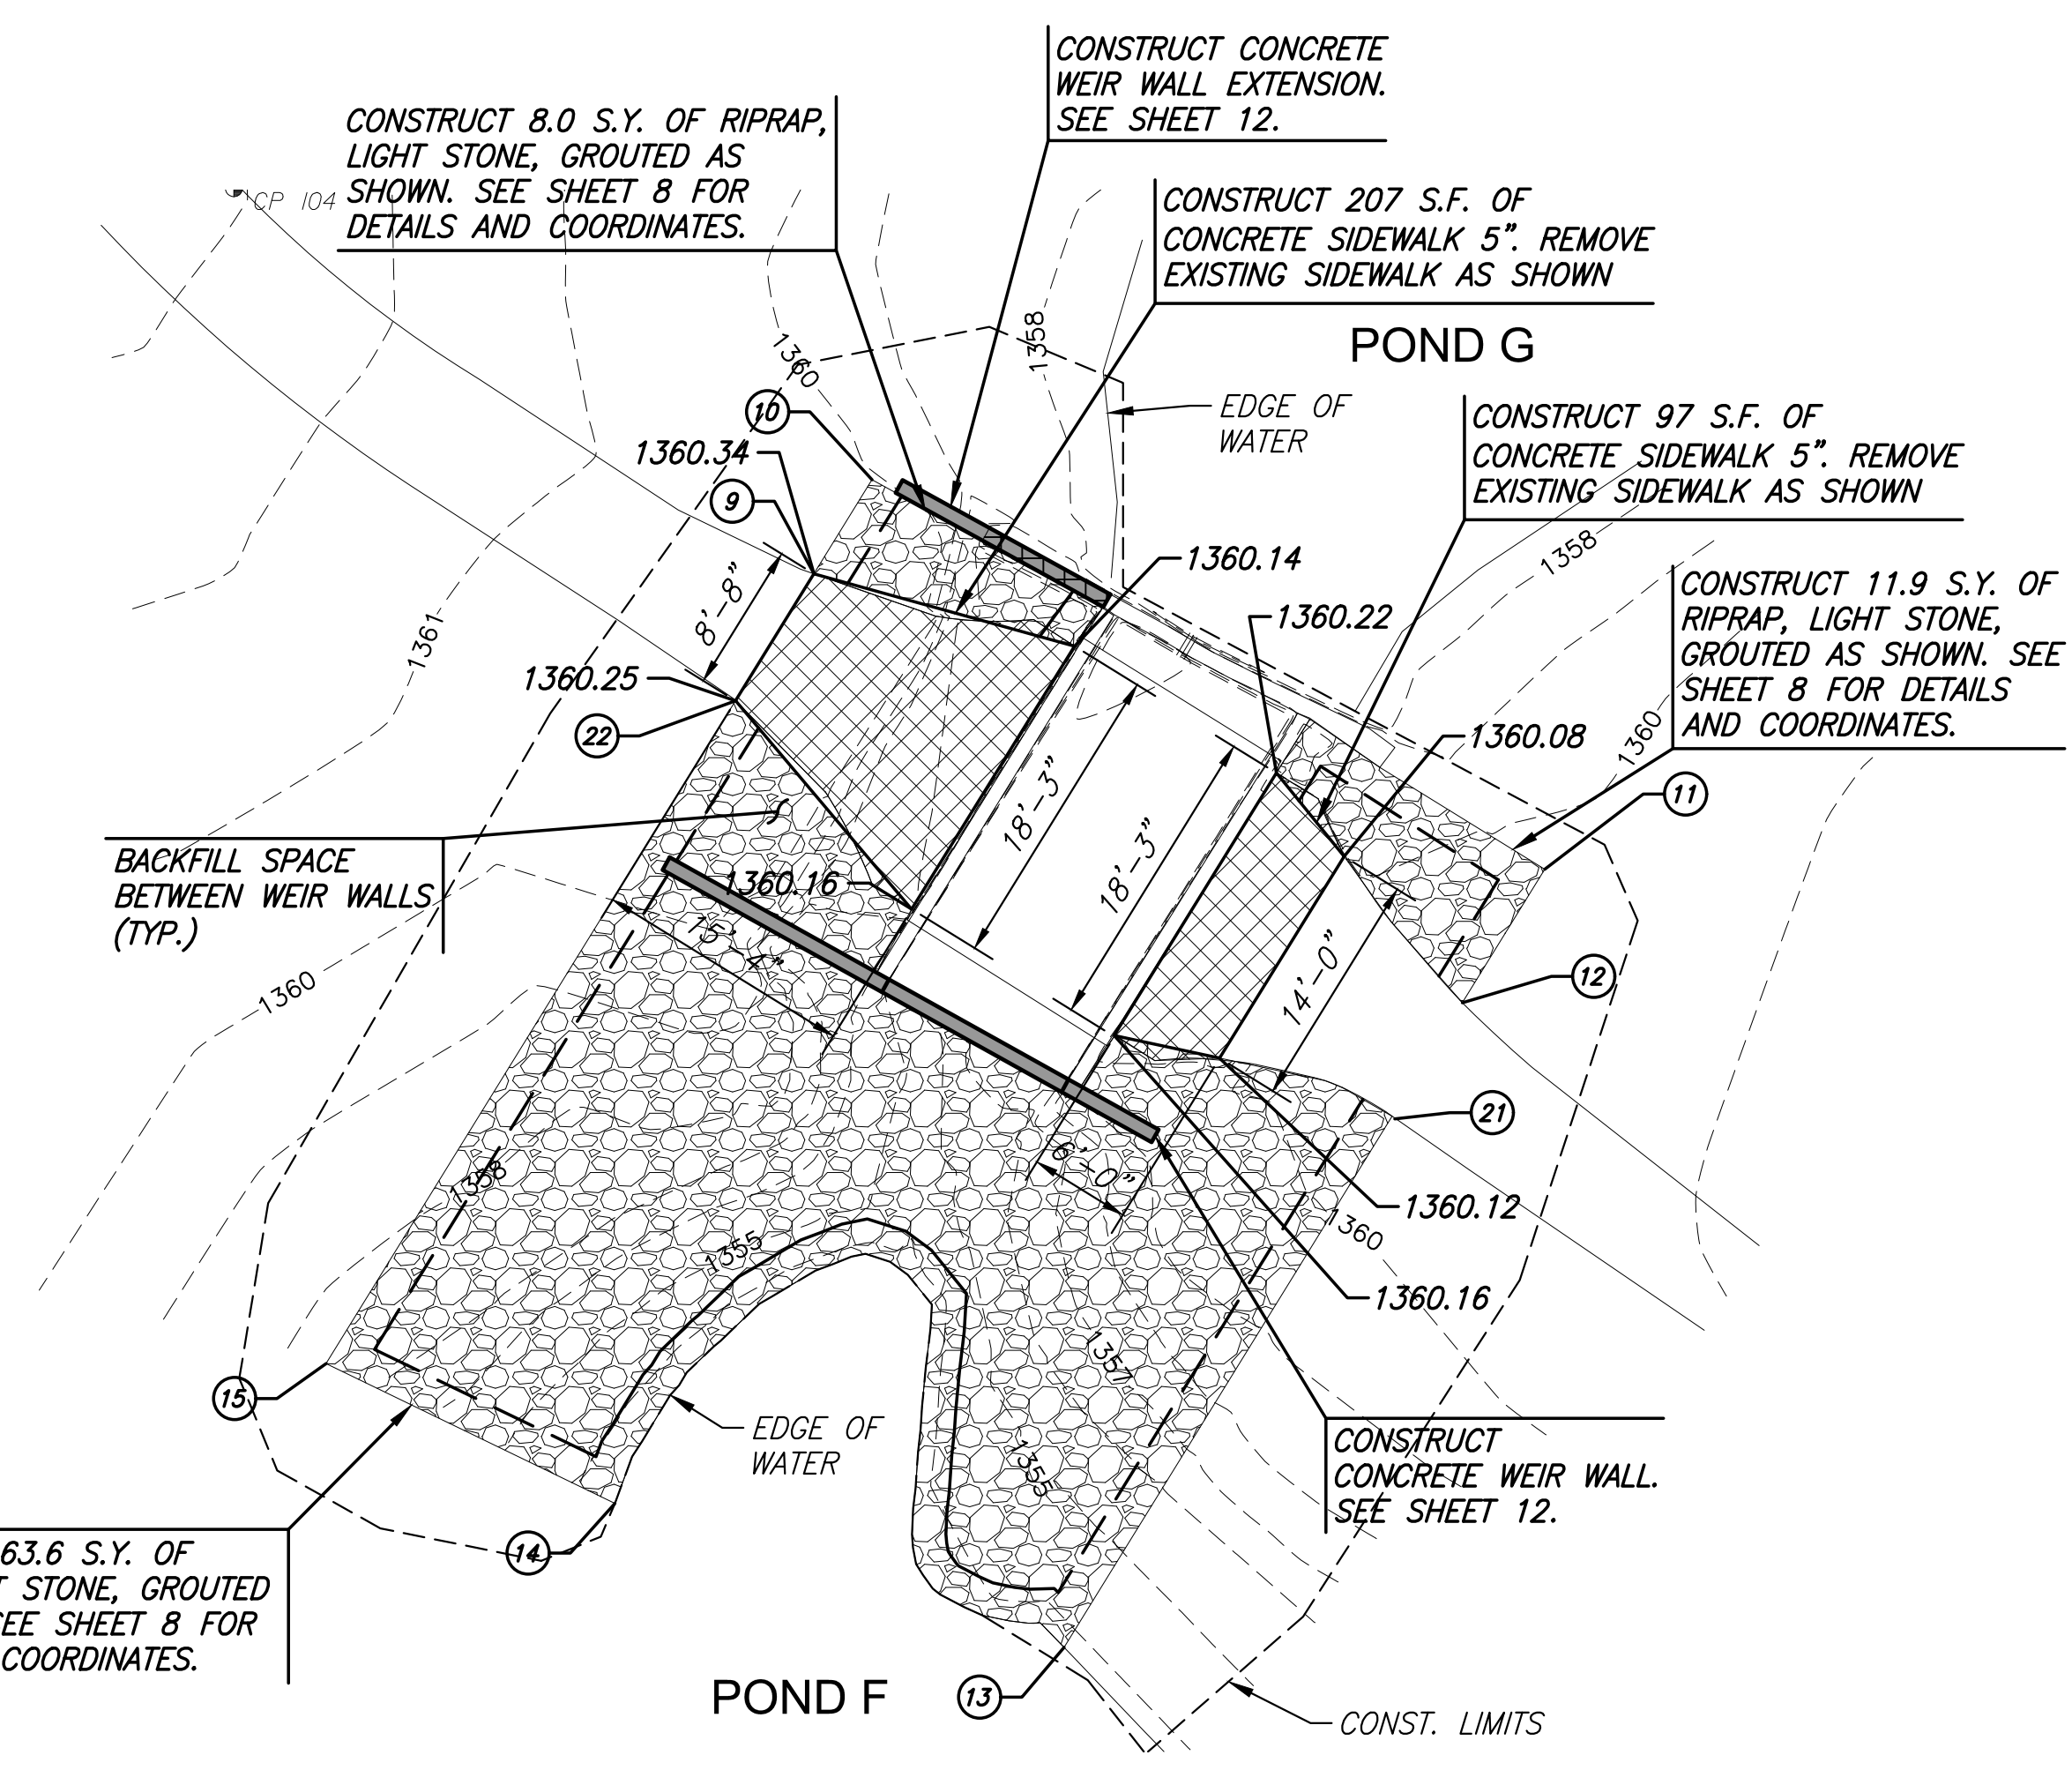

POND F & G SITE PLAN

NOTE:
MAINTAIN EXISTING CONTOURS OUTSIDE OF THE CONCRETE WEIR WALLS

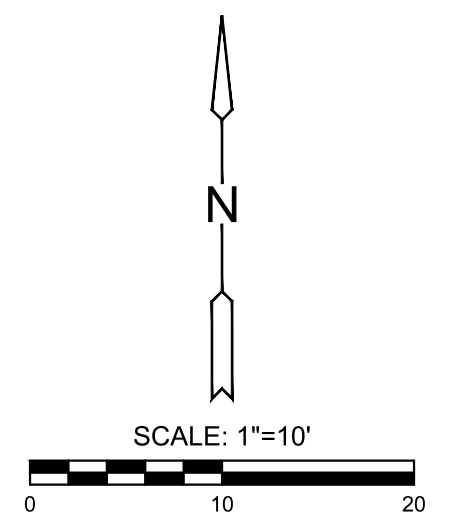

Note:
A 6" PVC line is located parallel to the existing discharge pipe being replaced. The PVC pipe will conflict with the new pipe and shall be removed and replaced by the contractor. The gate valve on the PVC pipe shall be replaced. The new valve will be supplied by the golf course. The PVC line shall be installed at original grades. Work shall be subsidiary to "Pipe, SWS, HDPE 30"

J:\PROJECTS\2019\1010483_COW_MACDONALD GOLF COURSE\190483 CAD\SHOTS\06 CIVILISTE\190483-05-5011.DWG PLOTTED: Thursday, January 20, 2022 @ 05:58PM