


FHWA REG NO.	STATE	PROJECT NO.	YEAR	SHEET NO.	SHEETS
7	KANSAS	87N 0064-01	1997	106	130

1"=100'

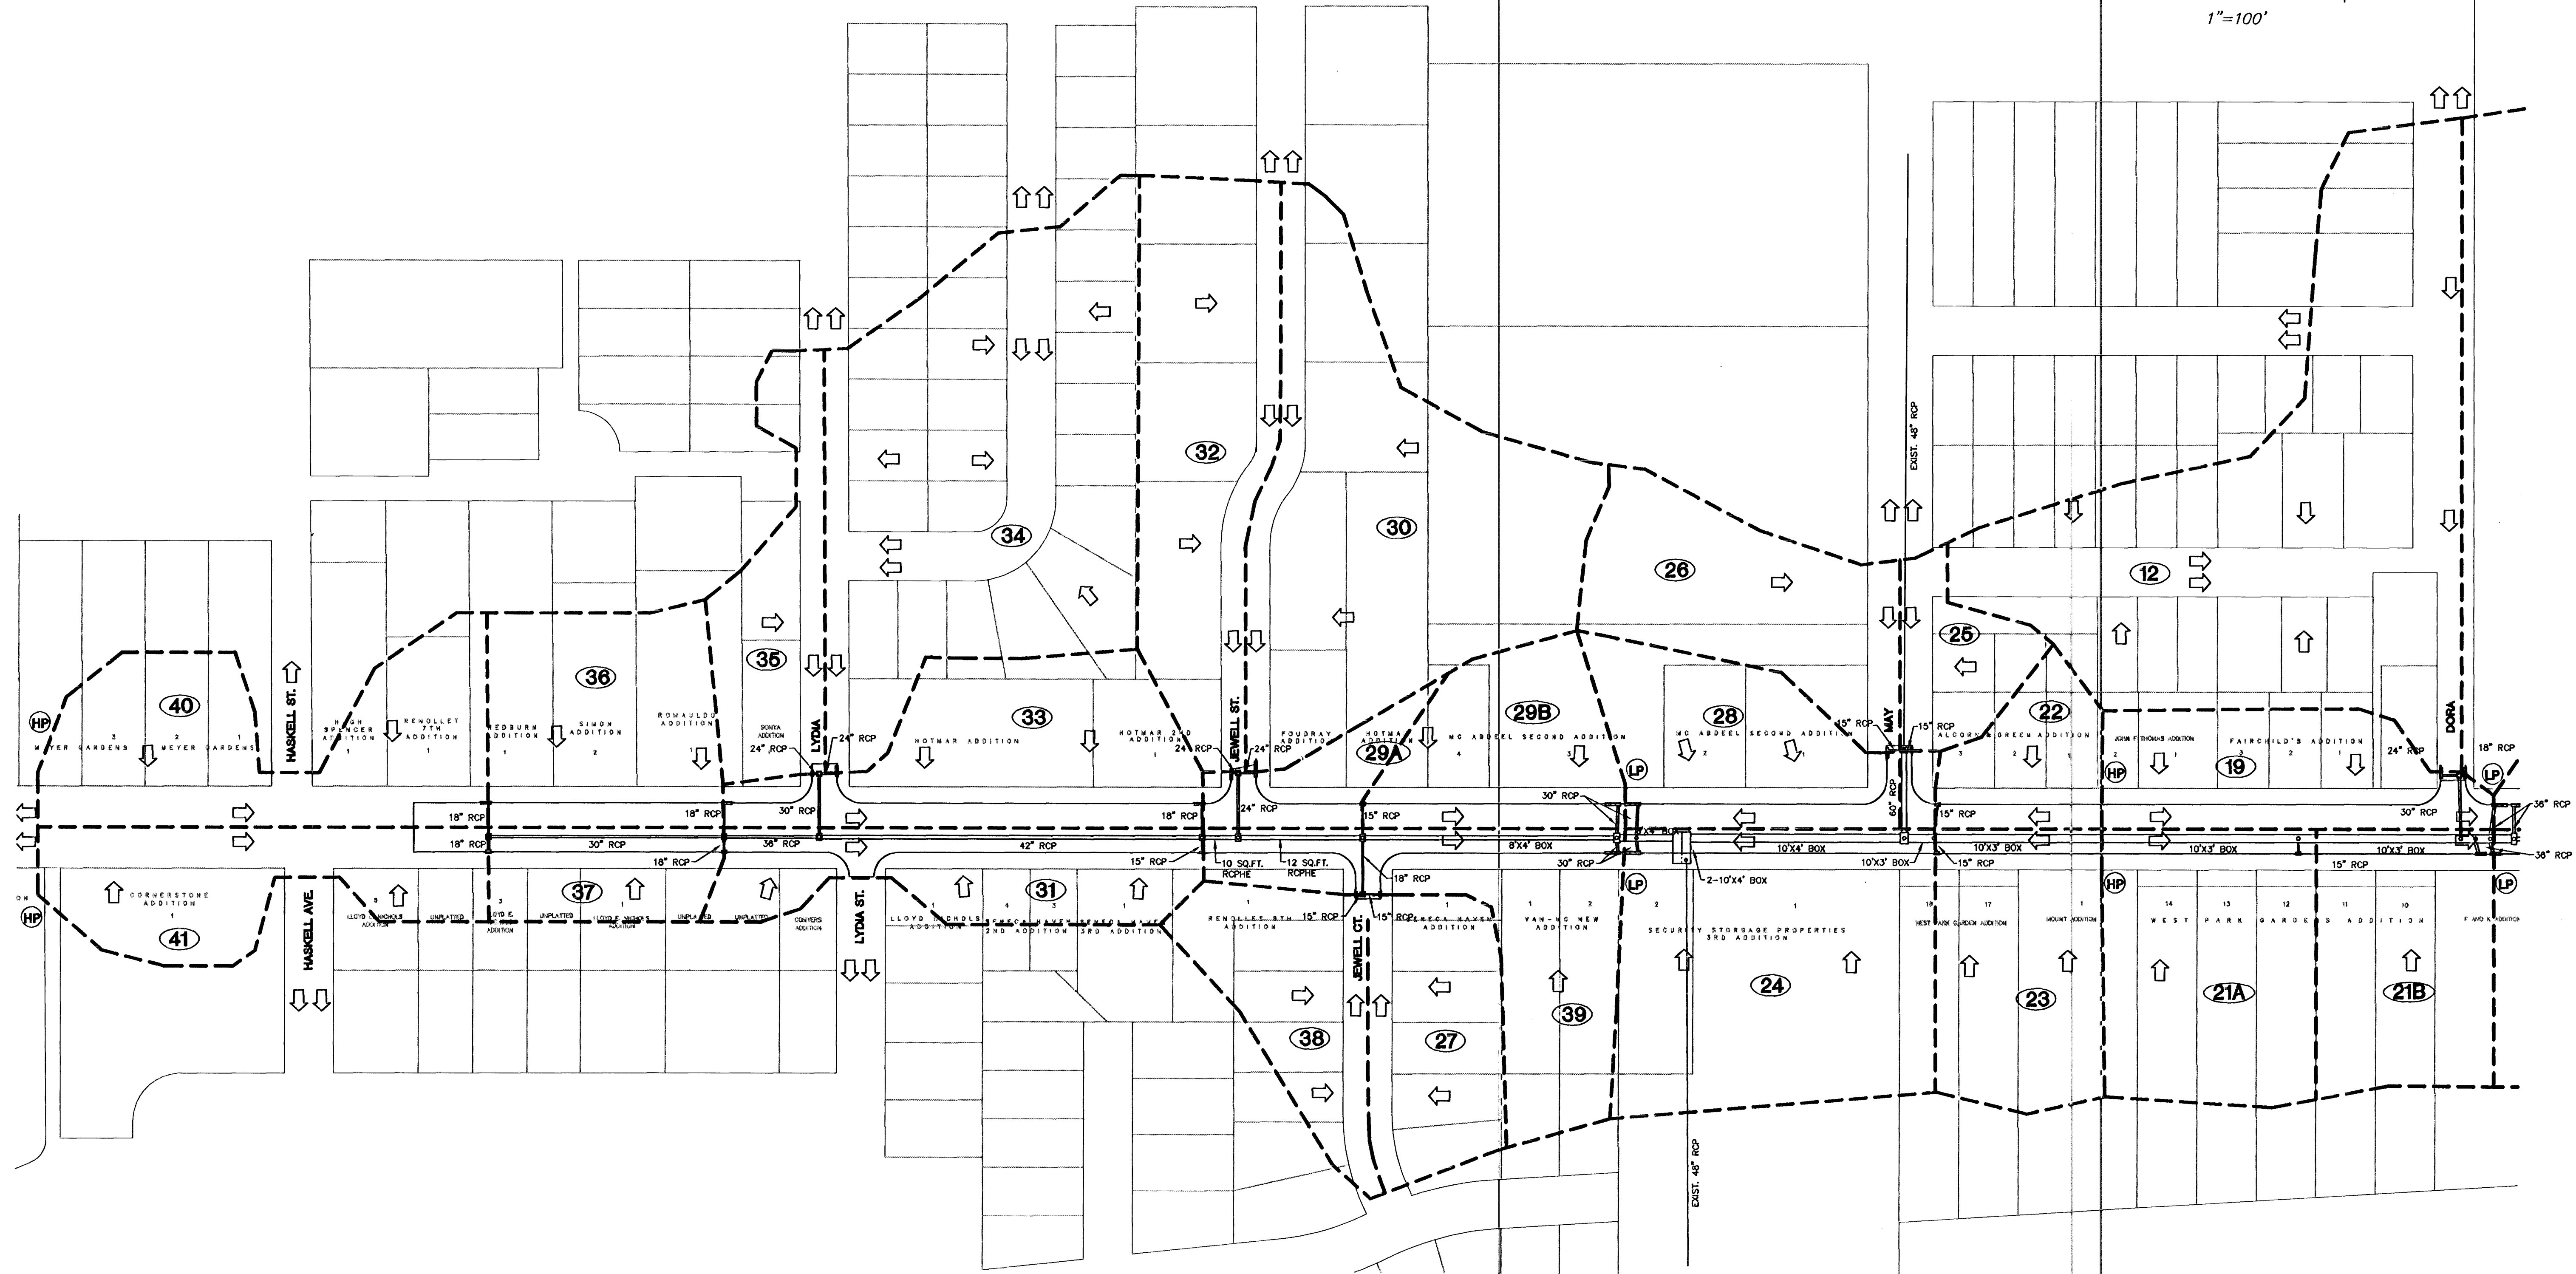

KANSAS DEPARTMENT OF TRANSPORTATION

**SOUTH SENECA STREET
DRAINAGE PLAN**

PROJECT NO. 87N 0064-01 SEDGWICK CO.

MID-KANSAS ENGINEERING CONSULTANTS, INC.
WICHITA, KANSAS

DESIGNED BY: GJA,PAF CHECKED BY: GJA
DRAWN BY: PAF DATE: 7/98 SHEET 106 OF 130

944003DR1

106