 



FHWA REG NO.	STATE	PROJECT NO.	YEAR	SHEET NO.	SHEETS
7	KANSAS	87N 0064-01	1997	108	130



1"=100'

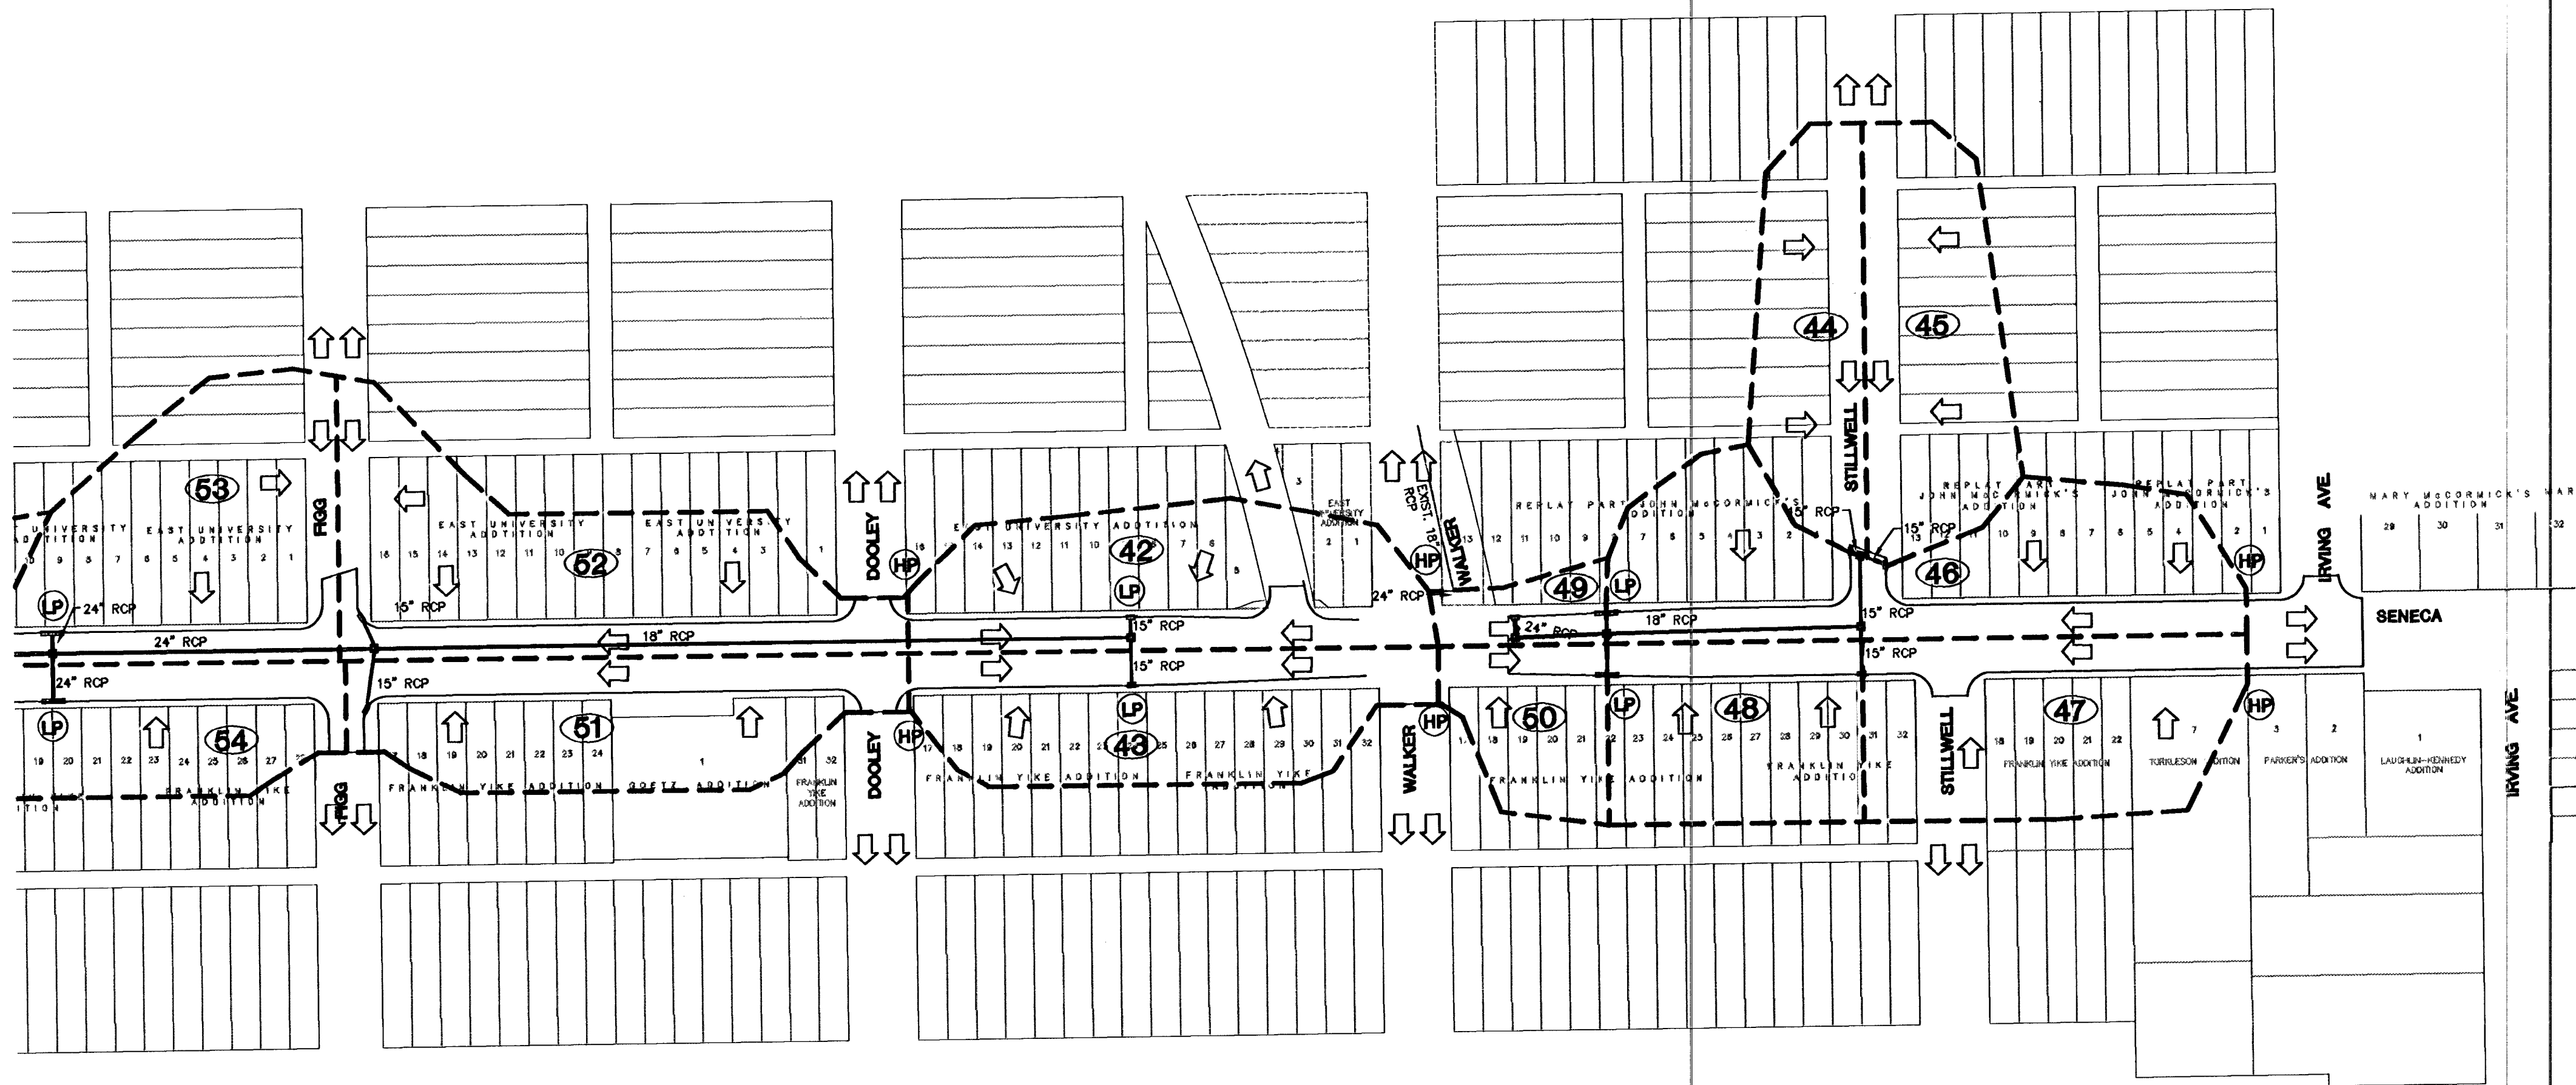

KANSAS DEPARTMENT OF TRANSPORTATION			
SOUTH SENECA STREET DRAINAGE PLAN			
PROJECT NO. 87N 0064-01		SEDGWICK CO.	
MID-KANSAS ENGINEERING CONSULTANTS, INC.			
WICHITA, KANSAS			
DESIGNED BY: GJA,PAF		CHECKED BY: GJA	
DRAWN BY: PAF		DATE: 7/98	SHEET 108 OF 130

94005DR3