


REVISIONS:	MARK	DATE	DESCRIPTION


PROJ NO: 472-85463  
 SCALE: 1" = 20'-0"  
 DATE: 09/30/2022  
 DESIGNED BY: S. Tucker  
 DRAWN BY: S. Tucker  
 CHECKED BY: .

SHEET TITLE:  
 SITE ELECTRICAL PLANS - AREAS  
 "A" & "B"


SHEET NO.  
 93  
 SHEET OF

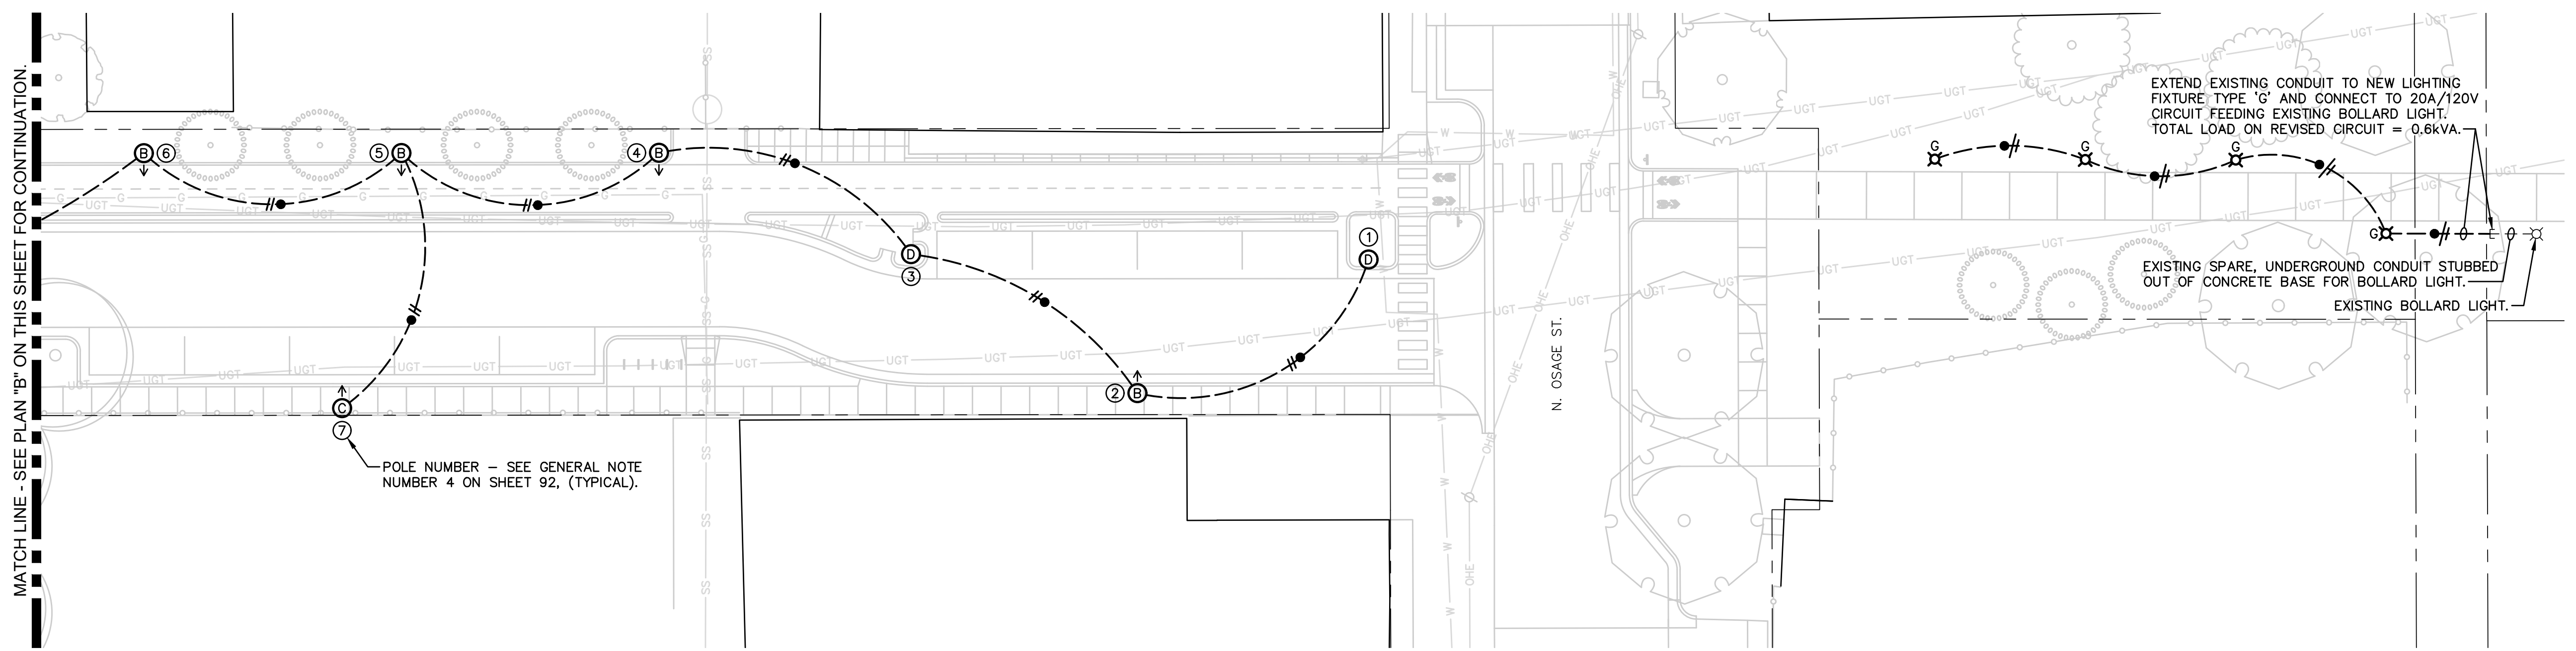

**A** SITE ELECTRICAL PLAN - AREA "A"

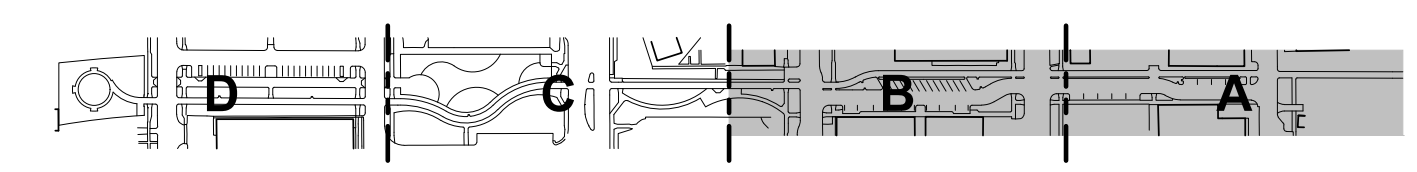

KEY PLAN

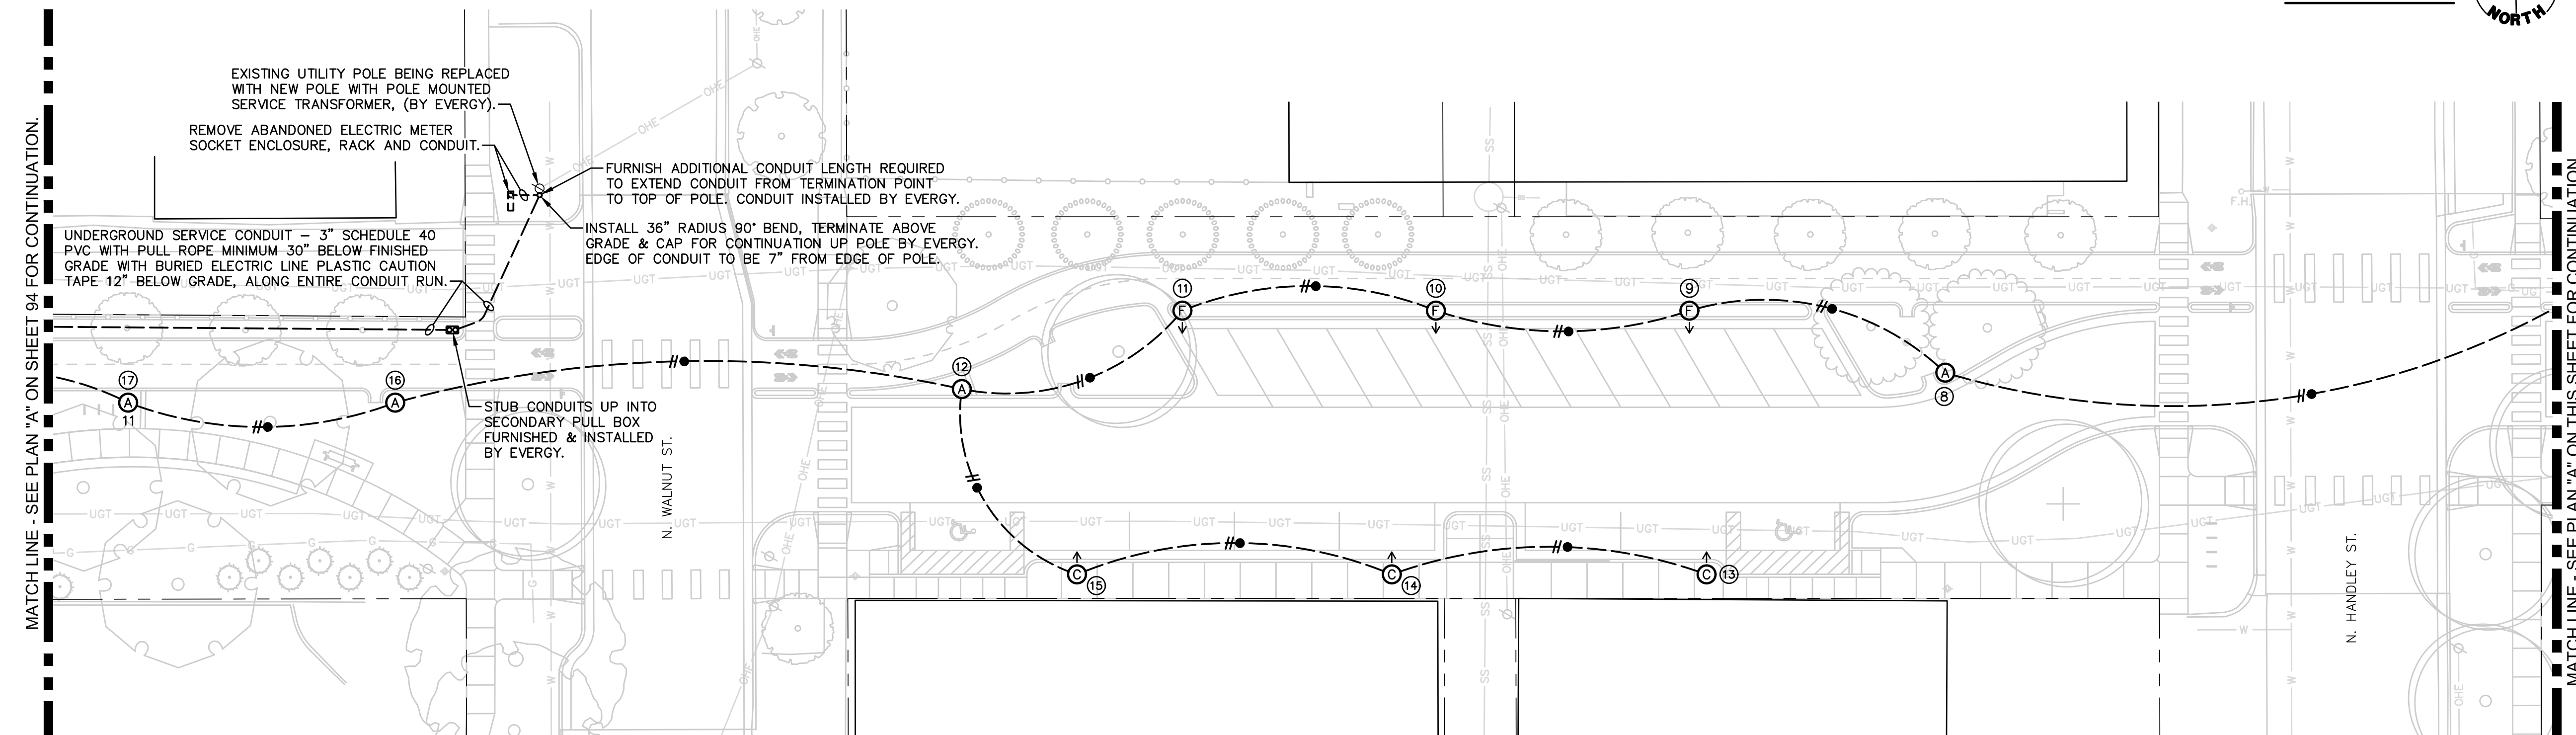

**B** SITE ELECTRICAL PLAN - AREA "B"

