
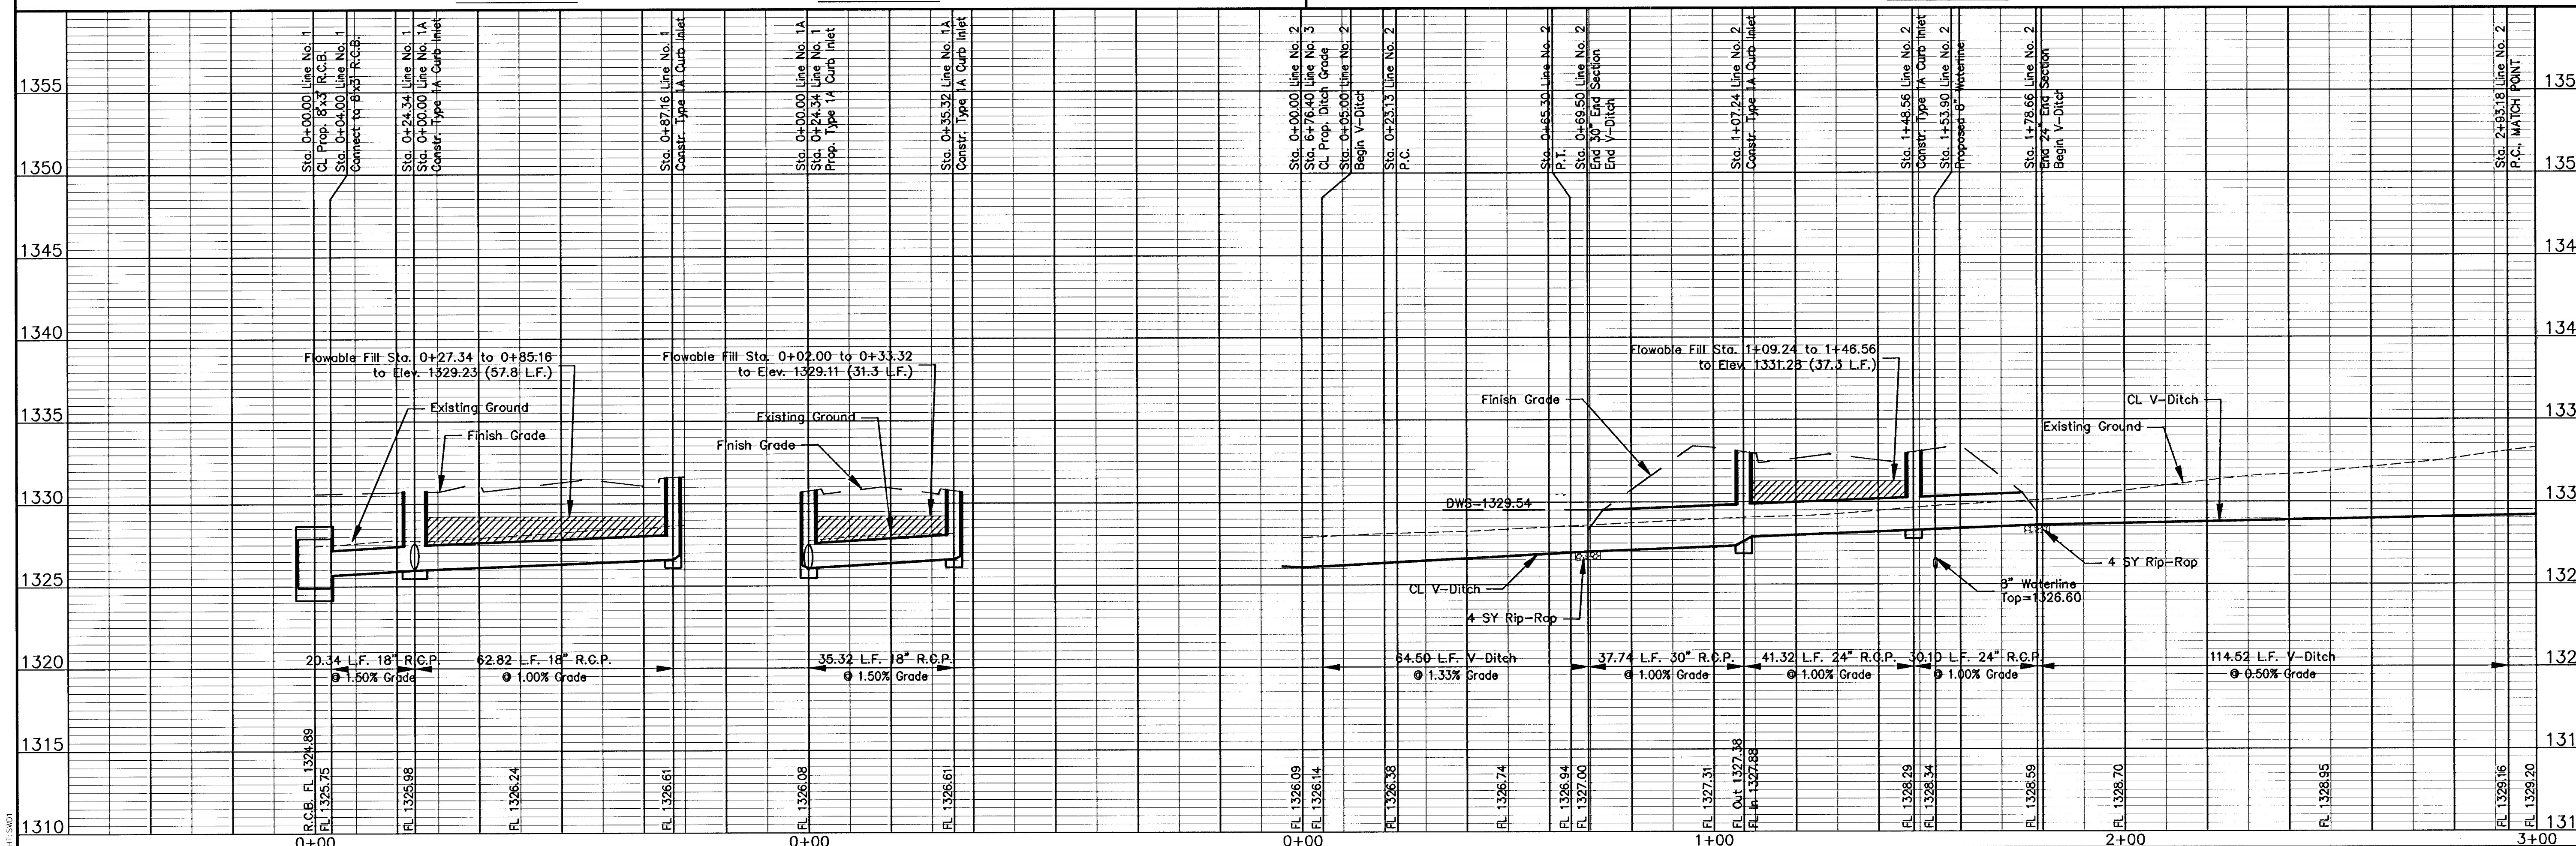
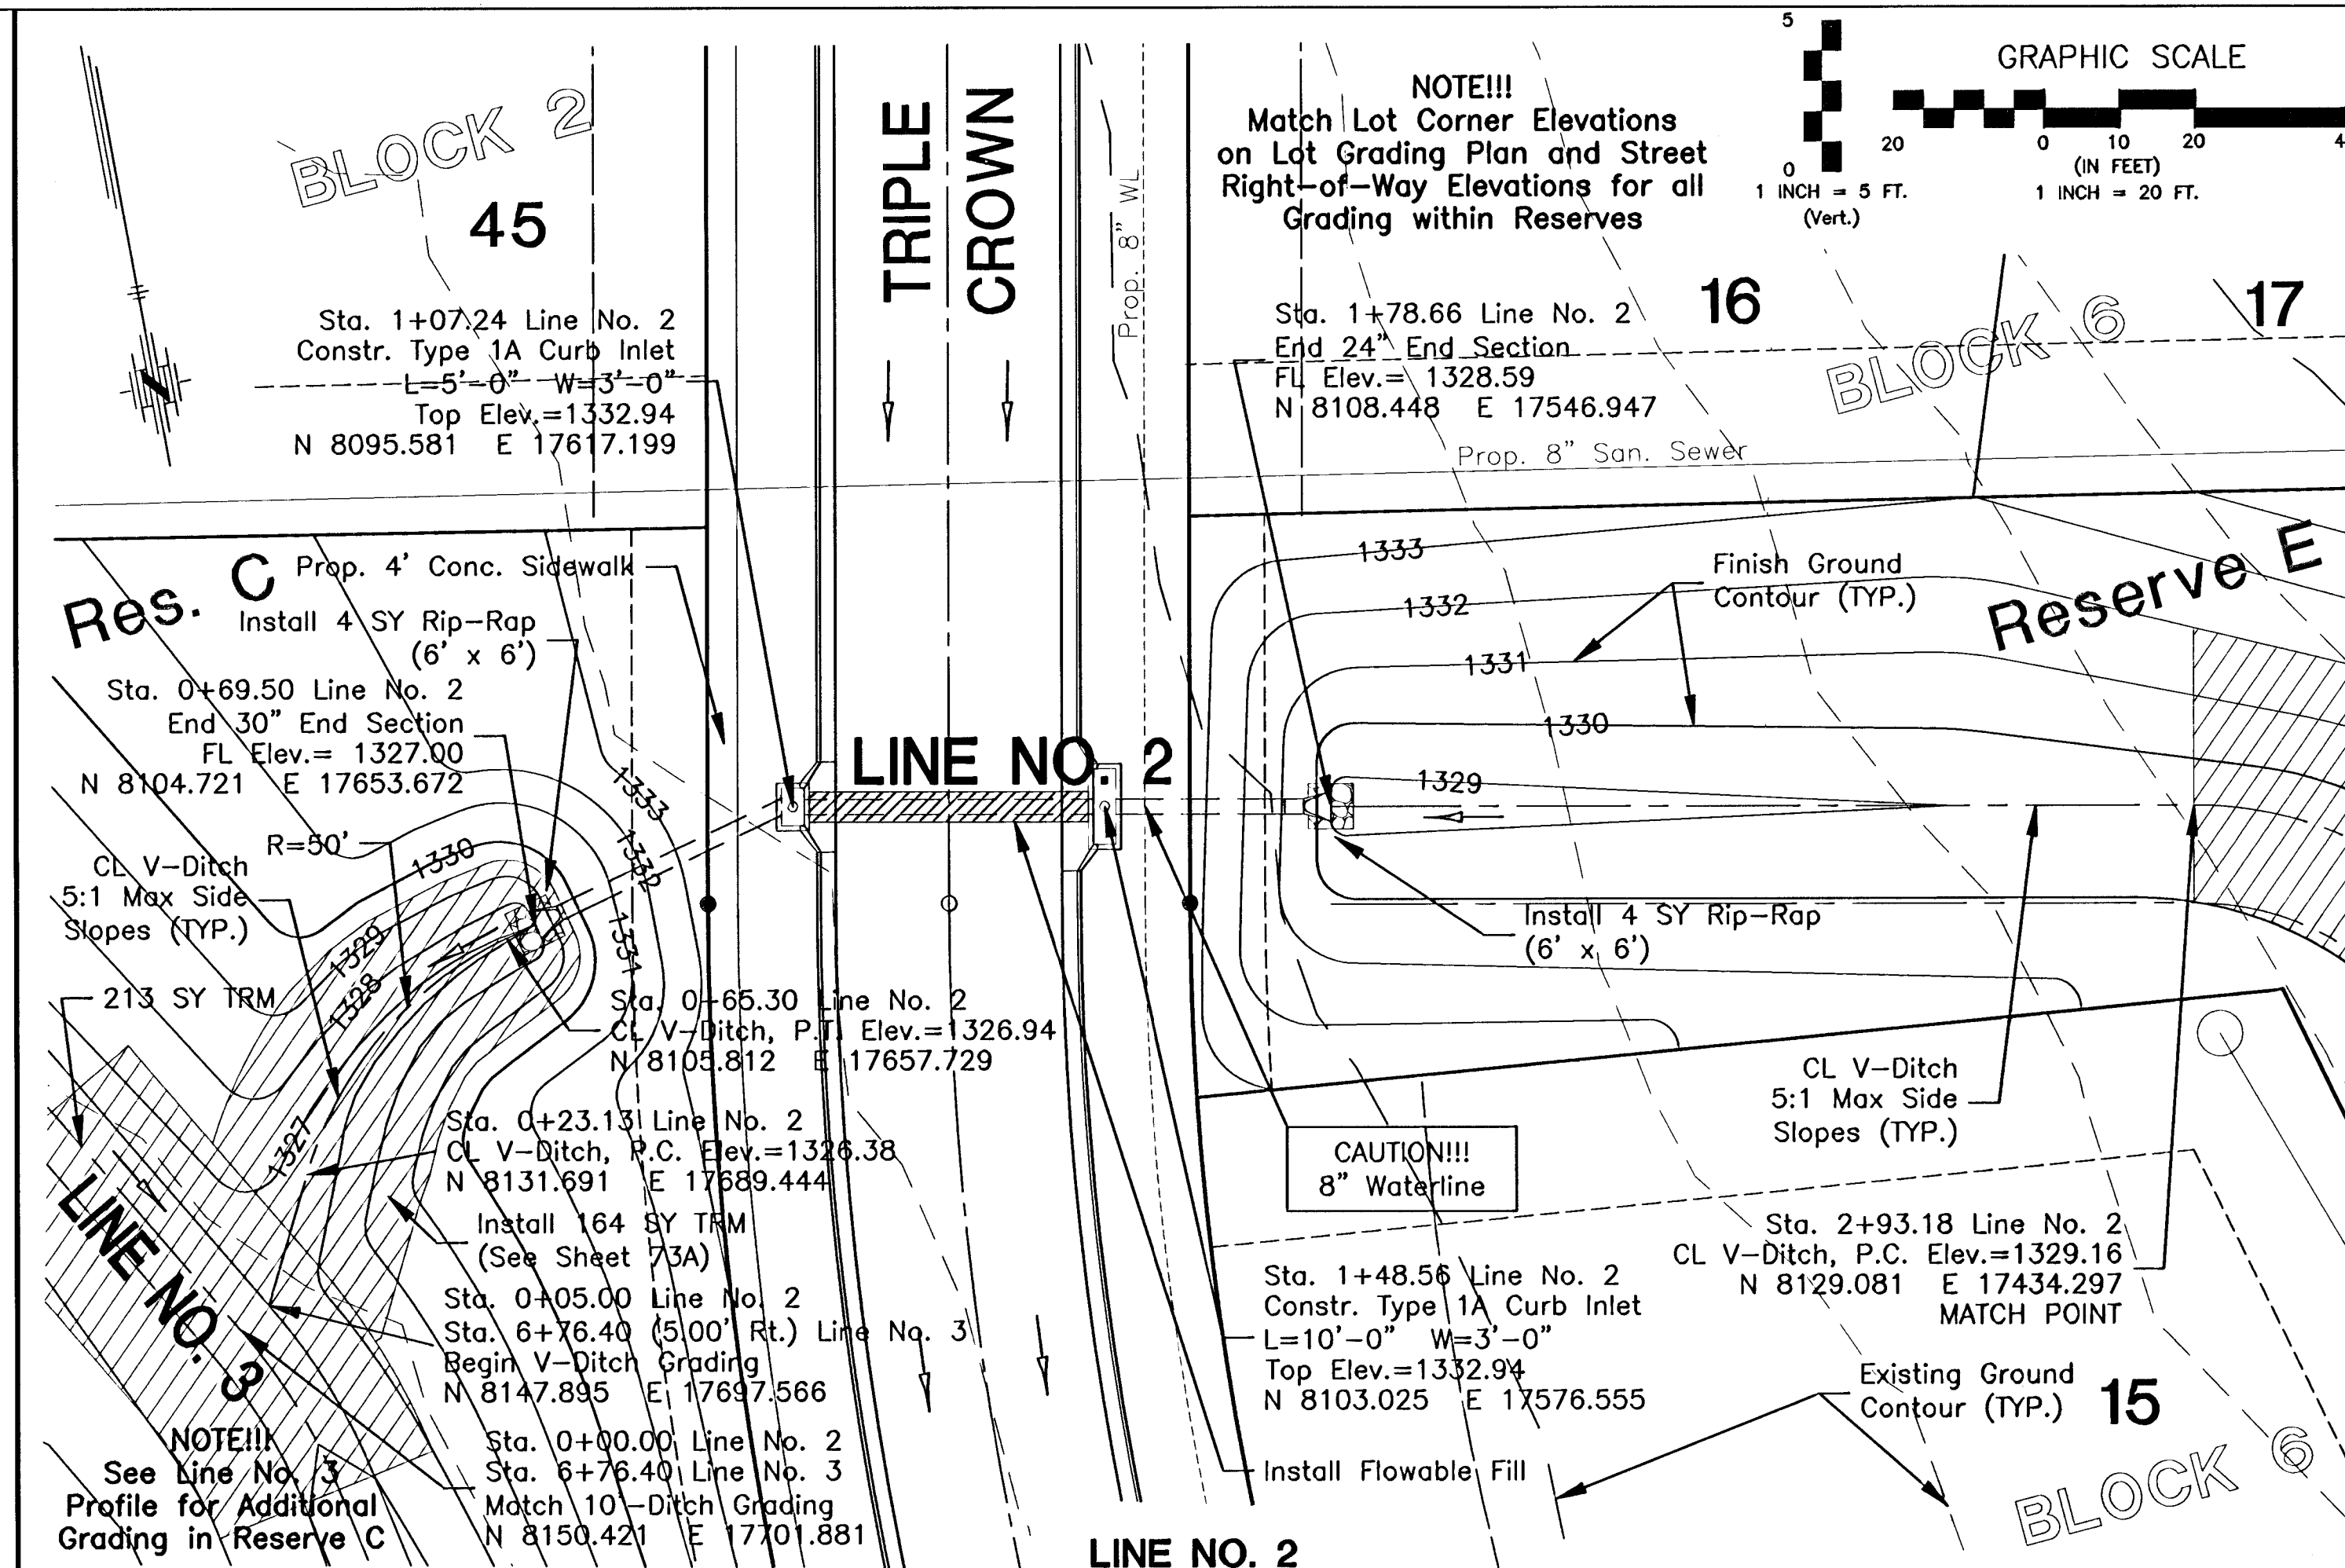


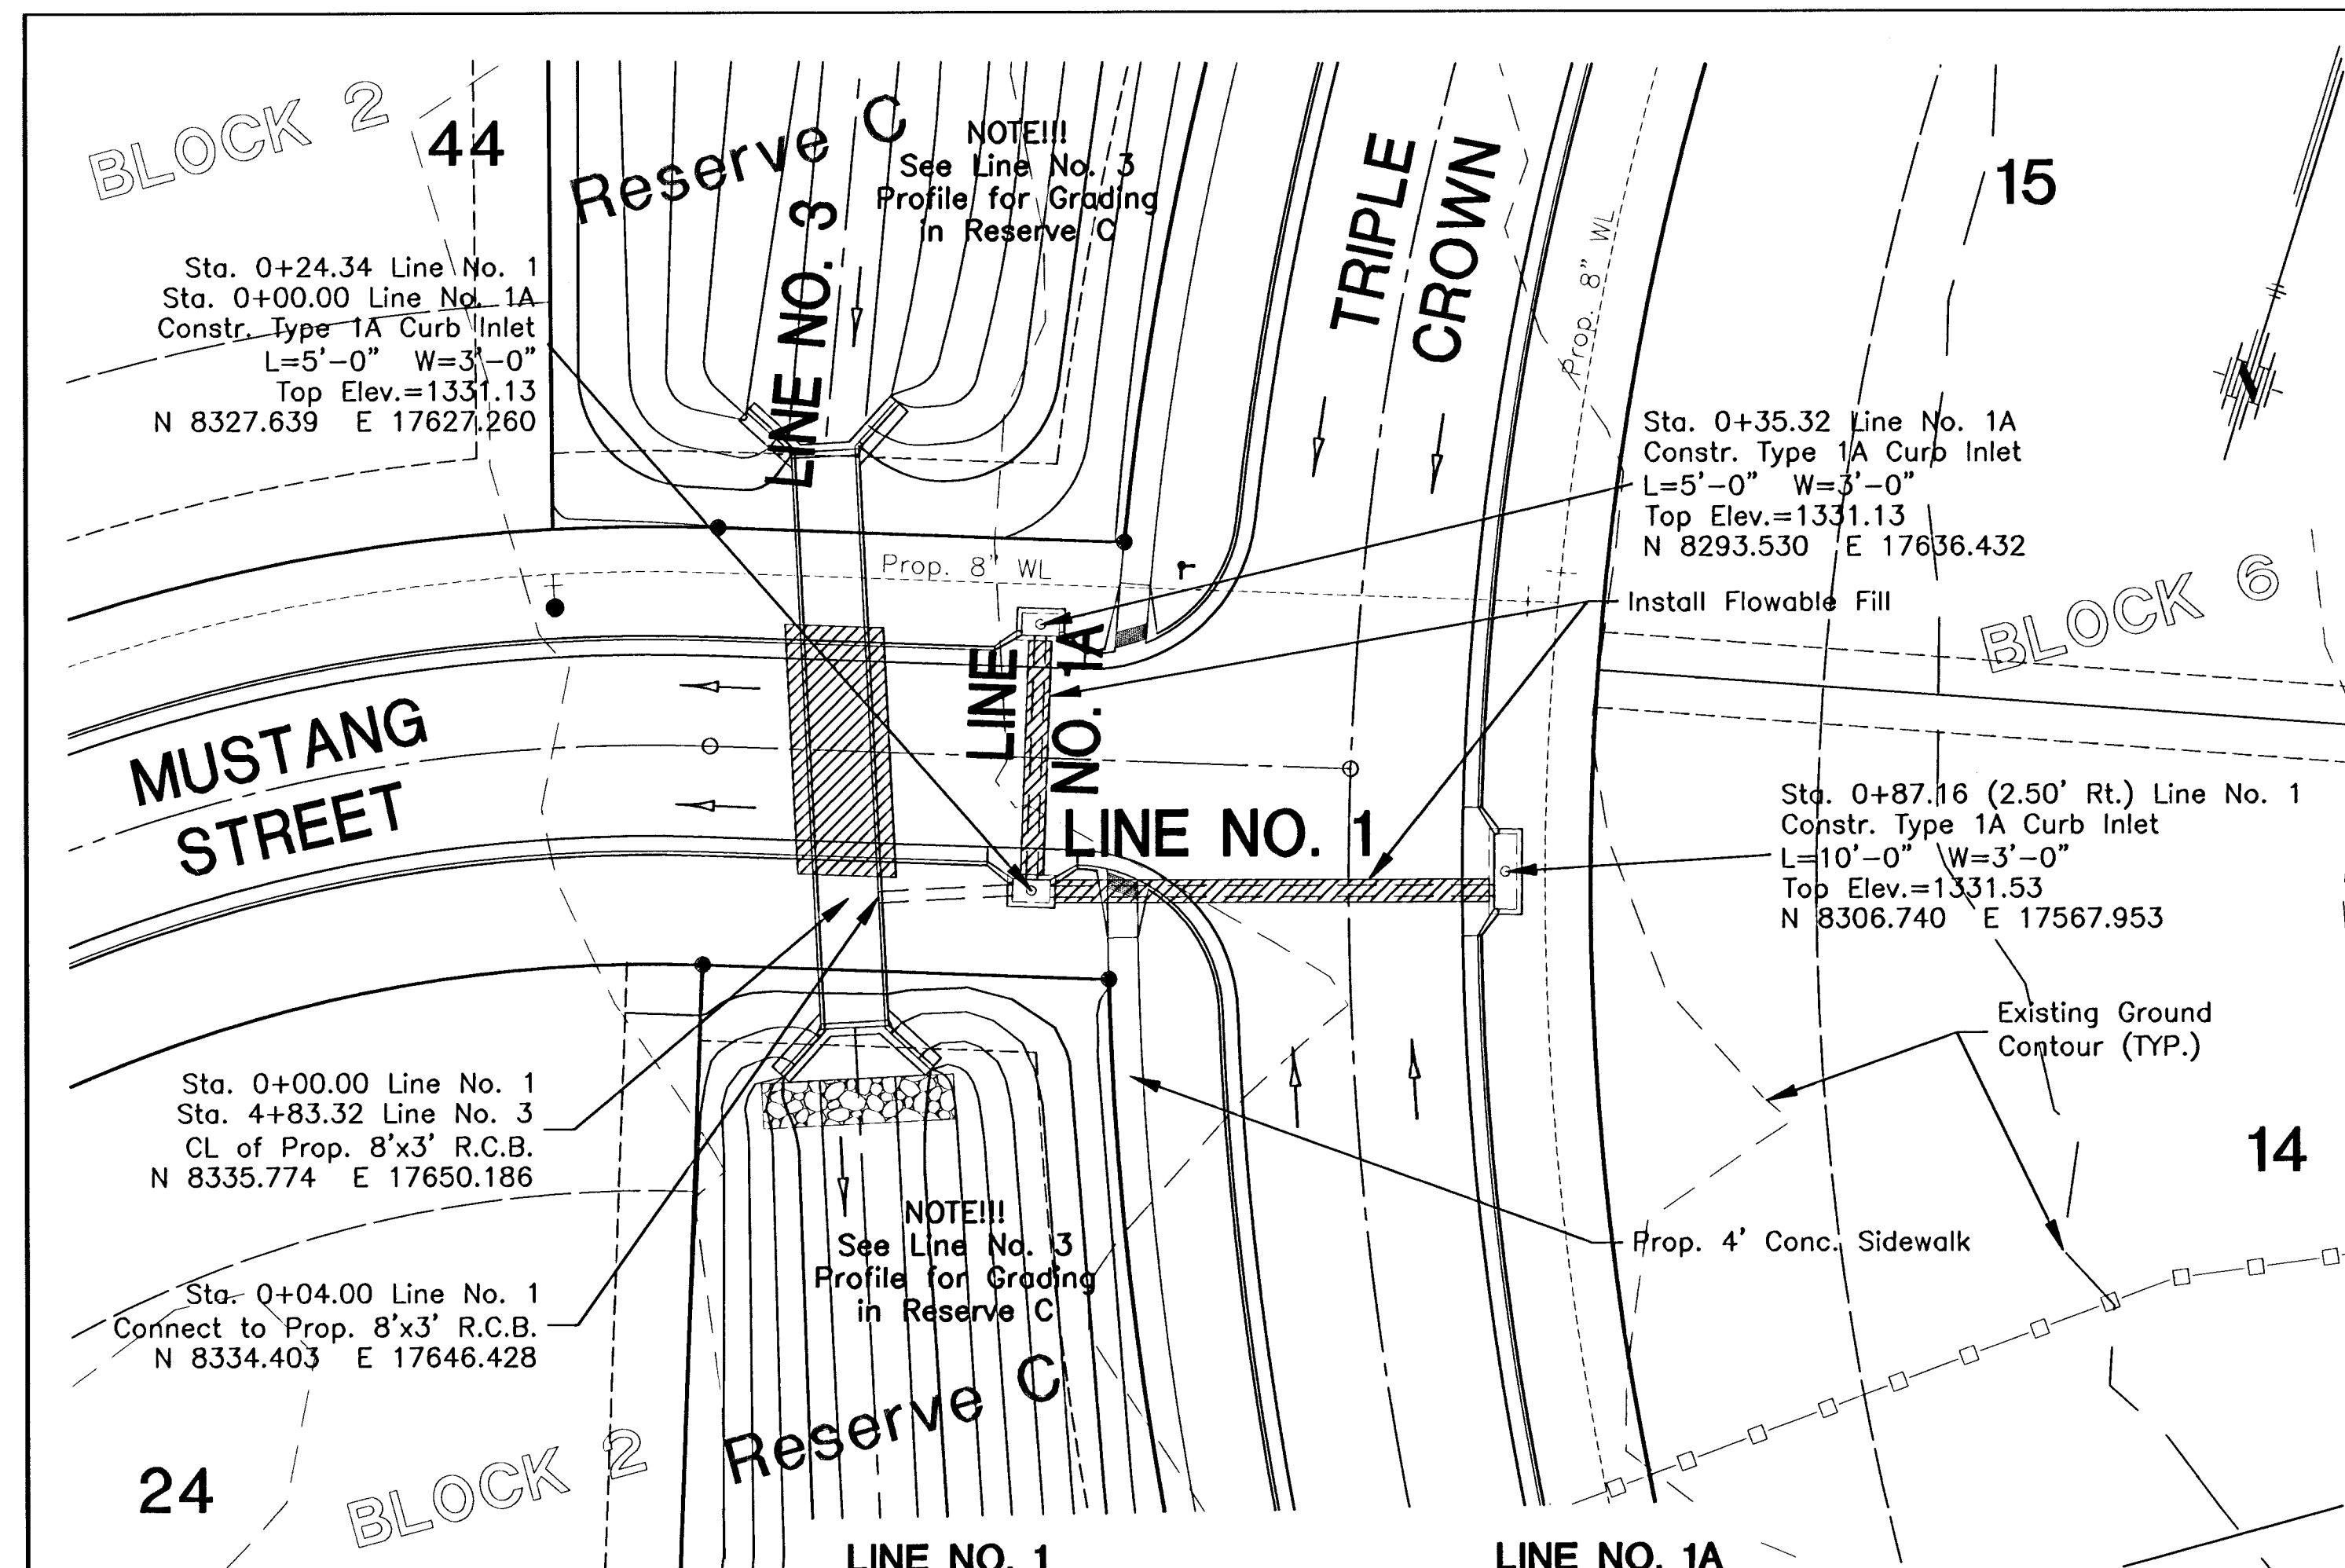

GRAPHIC SCALE

0 20 0 10 20 40
(IN FEET)

1 INCH = 5 FT.
(Vert.)

1 INCH = 20 FT.

NOTE!!!
Match Lot Corner Elevations on Lot Grading Plan and Street Right-of-Way Elevations for all Grading within Reserves

CAUTION!!!
8" Waterline

REVISION

No.	Date	By	Approved
1			
2			
3			

EQUESTRIAN ESTATES ADDITION - PHASE 2

STORM WATER SEWER

LINE NUMBER 1, 1A, & 2

CITY OF WICHITA, KANSAS

JAMES L. ARMOUR, P.E. - CITY ENGINEER

C.O.W. Proj# 472-83430 O.C.A.# 765969

POE & ASSOCIATES, INC.

CONSULTING ENGINEERS

5940 E. Central Suite 200 Wichita, KS 67208-4242

Phone 316/685-4111 FAX 316/685-4444

DESIGNED BY: JMU/JPD

DRAWN BY: JPD

POE JOB NO.: 1694J

January 2006

Sheet 14 of 78