


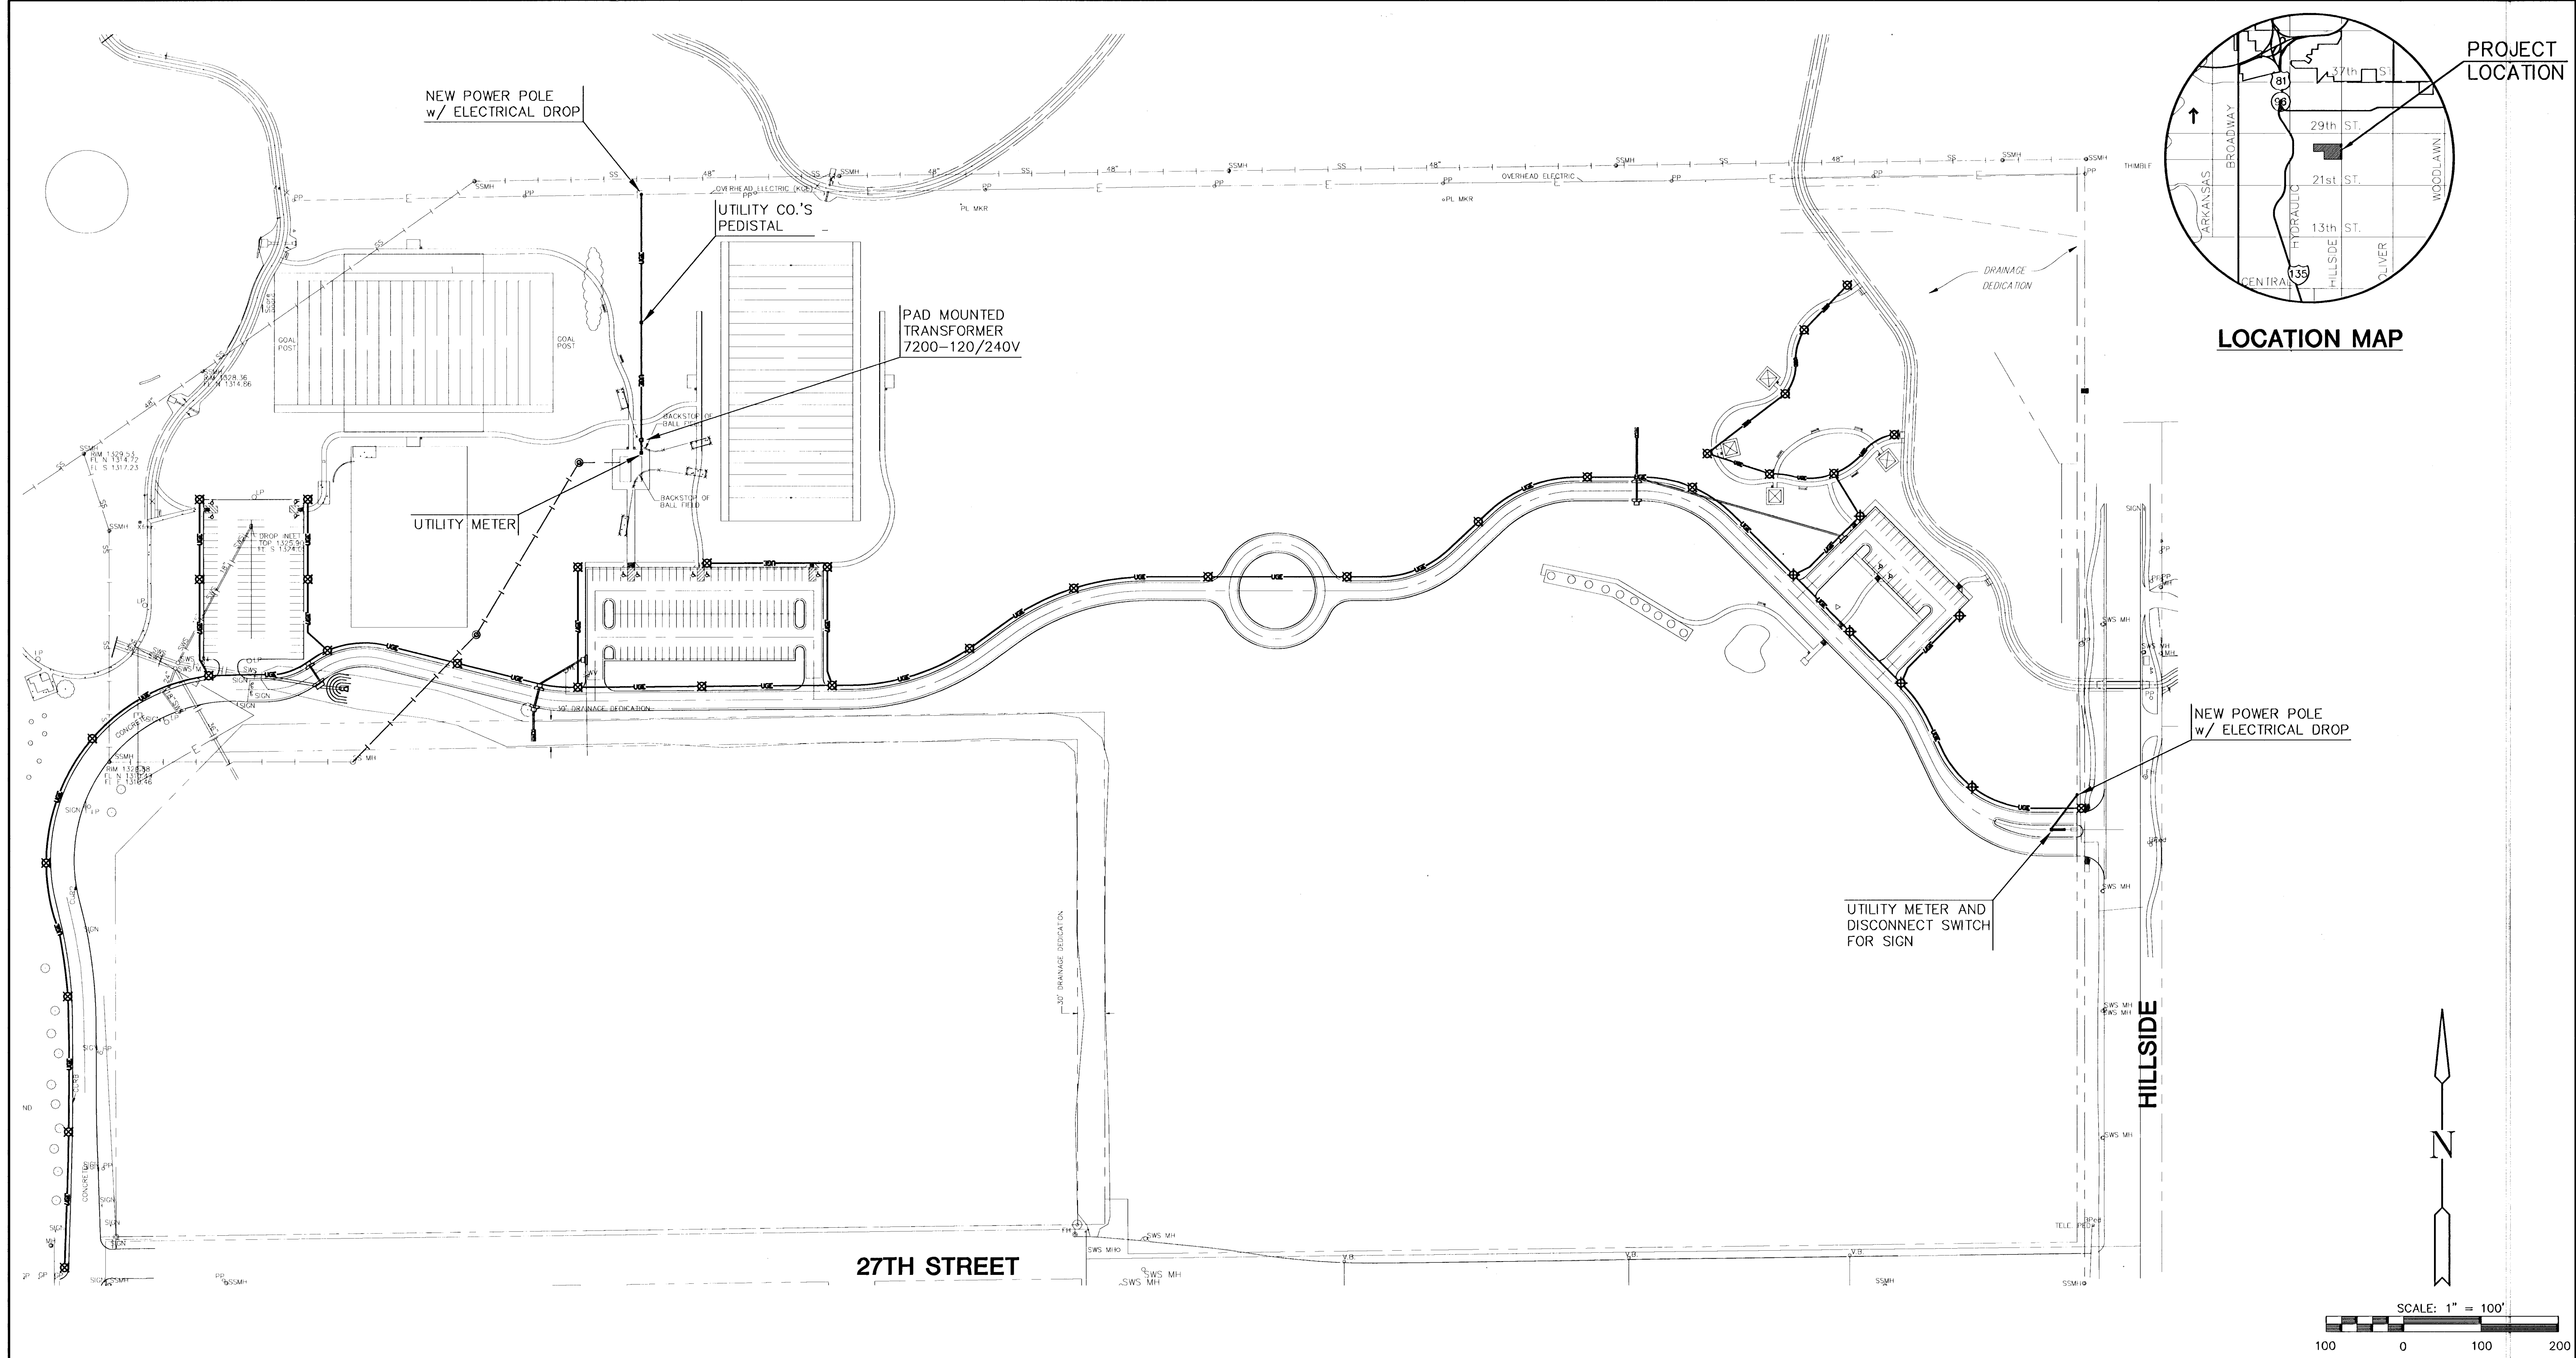

LEGEND

- 2" UNDERGROUND SCHEDULE 40 PVC CONDUIT WITH PULL CORD. BURY 36" BELOW FINISHED GRADE.
- NEW SITE LIGHTING POLES PROVIDED AND INSTALLED BY KG&E.



GROVE PARK IMPROVEMENTS
PROJECT NAME
OVERALL ELECTRICAL LIGHTING PLAN
SHEET TITLE
JTC DESIGN BY. GJR DRAWN BY. JTC CHECKED BY.
OCTOBER 2001 DATE 01060ELE JOB NO. ES 101 / 50 SHEET/OF