


S.V.A. DWG. NAME: 8003E002.DWG; DATE: 04/30/98; TIME: 09:15

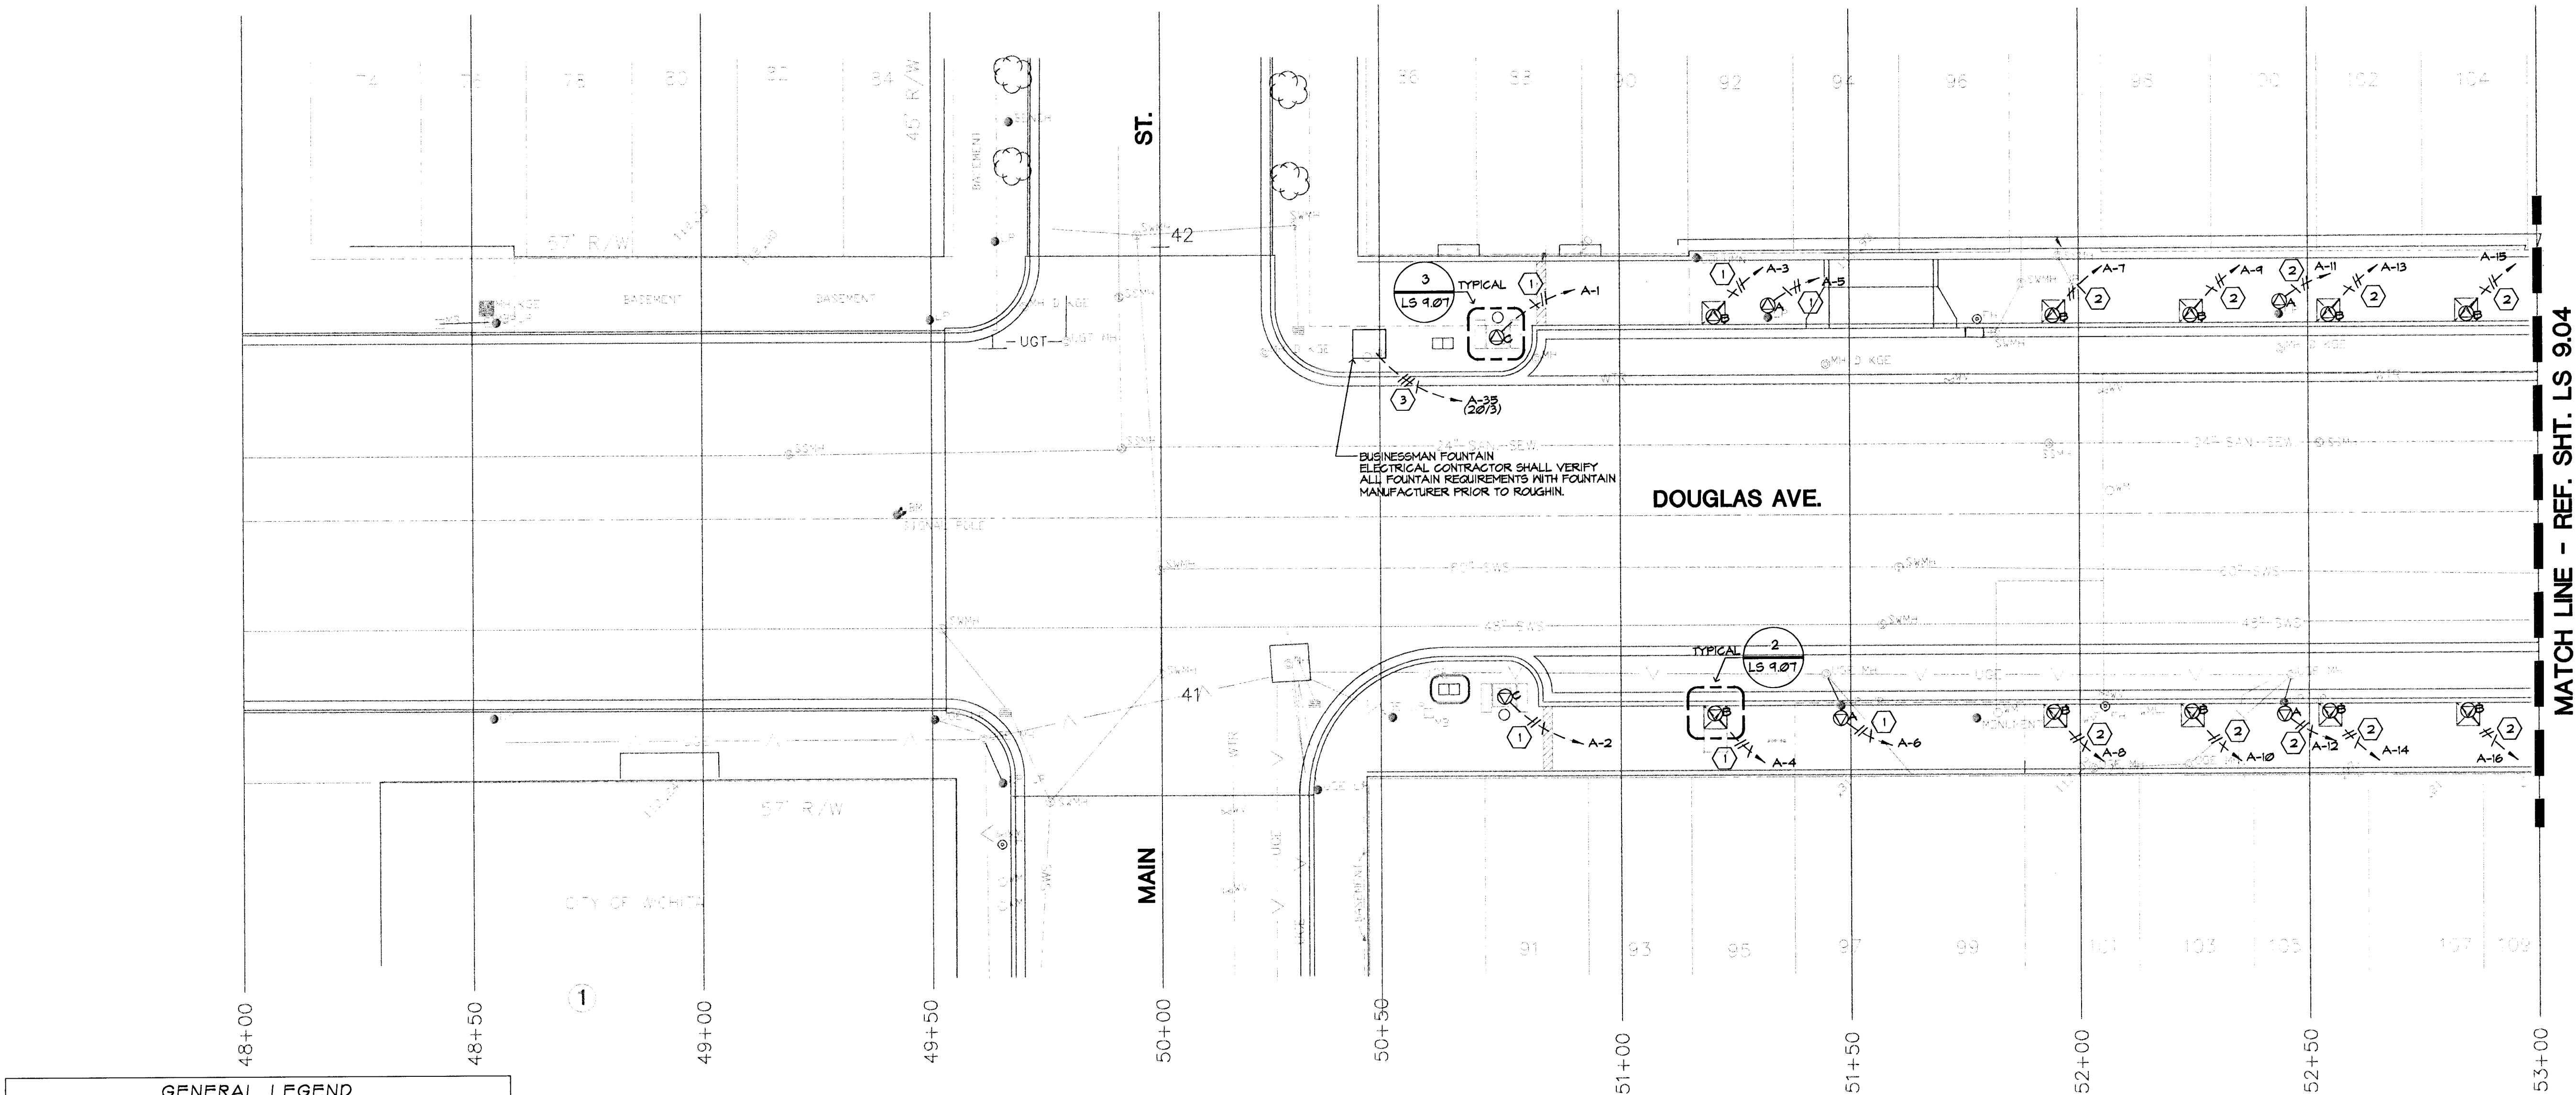

MATCH LINE - REF. SHT. LS 9.04

GENERAL LEGEND

--- PROPERTY LINE
--- CLL --- CONTRACT LIMIT LINE
--- CENTER LINE
--- WTR ---
--- UGT GAS ---
--- SWS ---
--- UGE ---
EXISTING UTILITY LINES

--- EDGE OF BASEMENT

DETAIL REFERENCE

1 --- DETAIL NO.
LS 9.07 --- SHEET NO.

EXISTING VAULTS

PARTIAL DOUGLAS AVE. POWER PLAN


SCALE: 1"=20'

NOTES:

1. BRANCH CIRCUITS ARE INDICATED AS ONE CIRCUIT HOME RUNS FOR CLARITY ONLY. CONTRACTOR MAY GROUP SINGLE POLE BRANCH CIRCUITS IN MULTIPLE CIRCUIT HOME RUNS (3 CIRCUIT MAXIMUM). A GROUND CONDUCTOR SIZED PER N.E.C. ARTICLE 250 IS REQUIRED IN ALL POWER, RECEPTACLE, AND LIGHTING CIRCUITS.



Electrical Engineering
and Design
349 S. Hydraulic
Wichita, KS 67211-1908
(316) 264-3061
FAX: (316) 264-3542

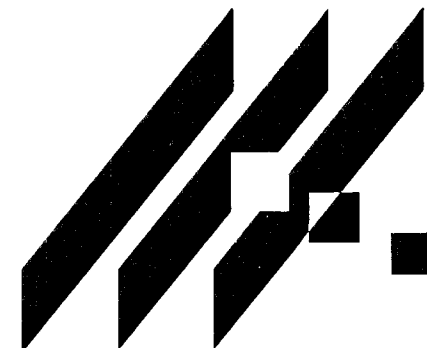

MID-KANSAS ENGINEERING
CONSULTANTS, INC.
411 N. WEBB ROAD
WICHITA, KS. 67206
316-684-9600

STREETSCAPES
PROJECT NAME

DOUGLAS AVE @ 50+00 TO 53+00
SHEET TITLE

SVA
DESIGN BY:
MAY 1998
DATE

SVA
DRAWN BY:
92010
JOB NO.

SVA
CHECKED BY:
LS 9.03
SHEET/OF