


S.V.A. DWG. NAME: 8003E003.DWG; DATE: 05/12/99; TIME: 16:11

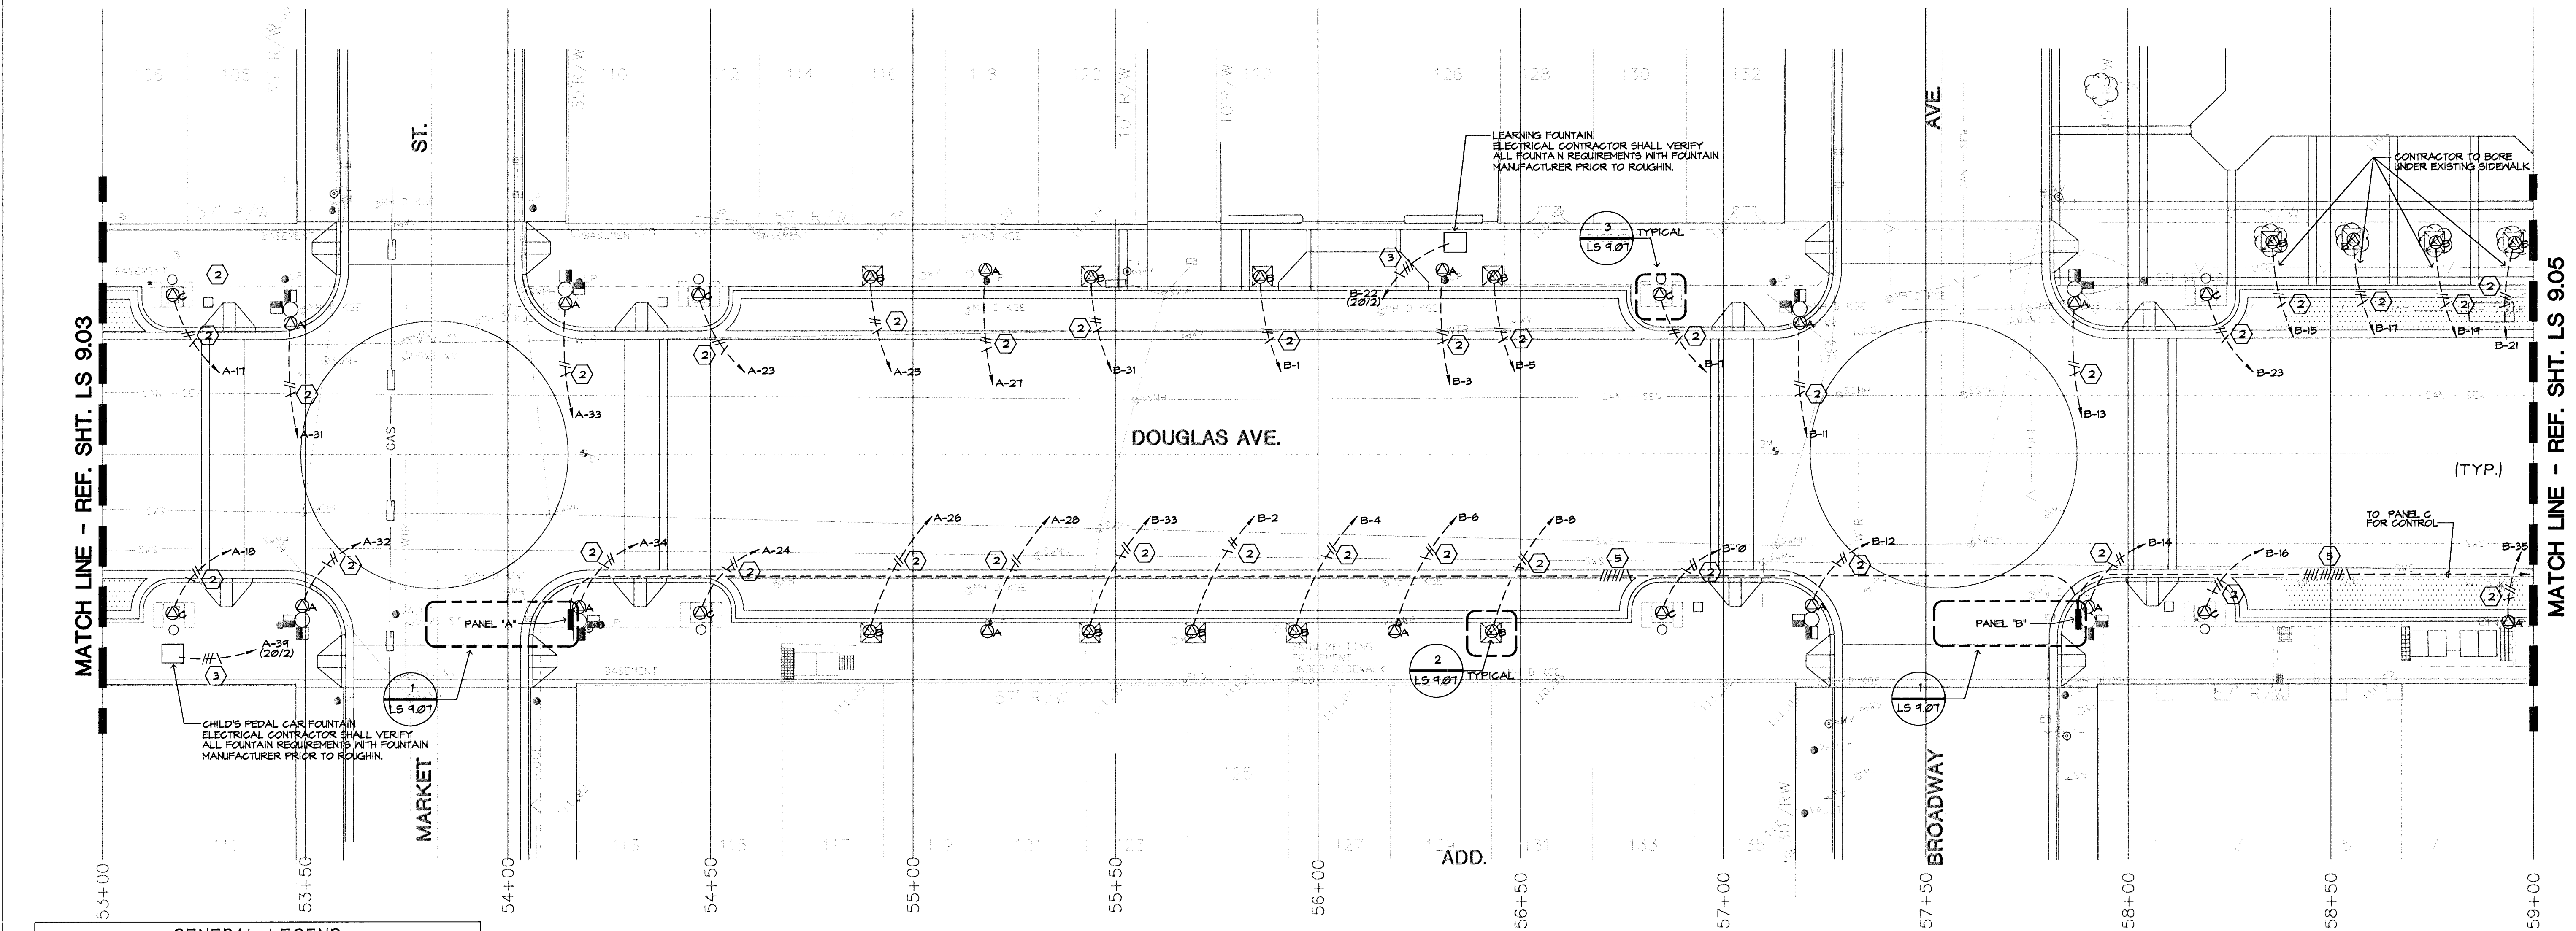

**GENERAL LEGEND**

— — — — — PROPERTY LINE  
- - - - - CONTRACT LIMIT LINE  
- - - - - CENTER LINE

WTR — WATER  
GAS — GAS  
SWS — SEWER  
UG — UNDERGROUND


EXISTING UTILITY LINES

— — — — — EDGE OF BASEMENT

**DETAIL REFERENCE**

1 — DETAIL NO.  
LS 9.07 — SHEET NO.



EXISTING VAULTS

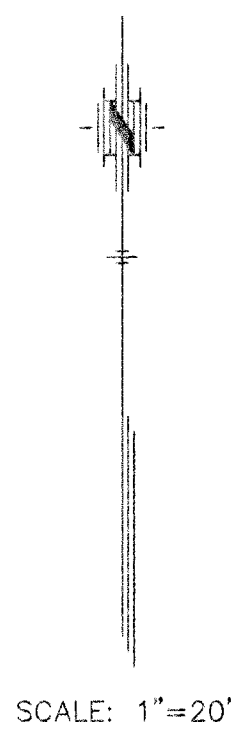

**PARTIAL DOUGLAS AVE. POWER PLAN**

**NOTES:**

1. BRANCH CIRCUITS ARE INDICATED AS ONE CIRCUIT HOME RUNS FOR CLARITY ONLY. CONTRACTOR MAY GROUP SINGLE POLE BRANCH CIRCUITS IN MULTIPLE CIRCUIT HOME RUNS (3 CIRCUIT MAXIMUM). A GROUND CONDUCTOR SIZED PER N.E.C. ARTICLE 250 IS REQUIRED IN ALL POWER, RECEPTACLE, AND LIGHTING CIRCUITS.

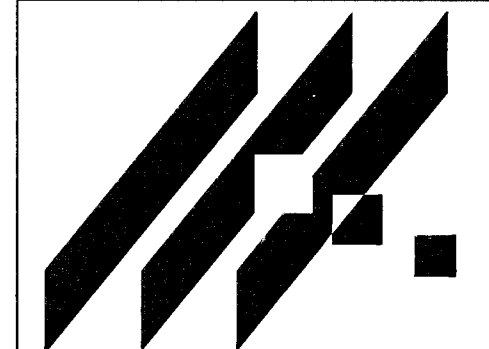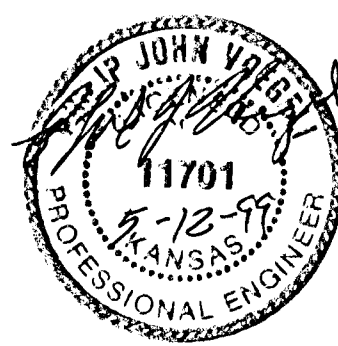

|                                                     |                  |                       |
|-----------------------------------------------------|------------------|-----------------------|
| <b>STREETSCAPES</b><br>PROJECT NAME                 |                  |                       |
| <b>DOUGLAS AVE. @ 53+00 TO 59+00</b><br>SHEET TITLE |                  |                       |
| SVA<br>DESIGN BY:                                   | SVA<br>DRAWN BY: | SVA<br>CHECKED BY:    |
| MAY 1998<br>DATE                                    | 92010<br>JOB NO. | LS 9.04<br>SHEET 4 OF |