
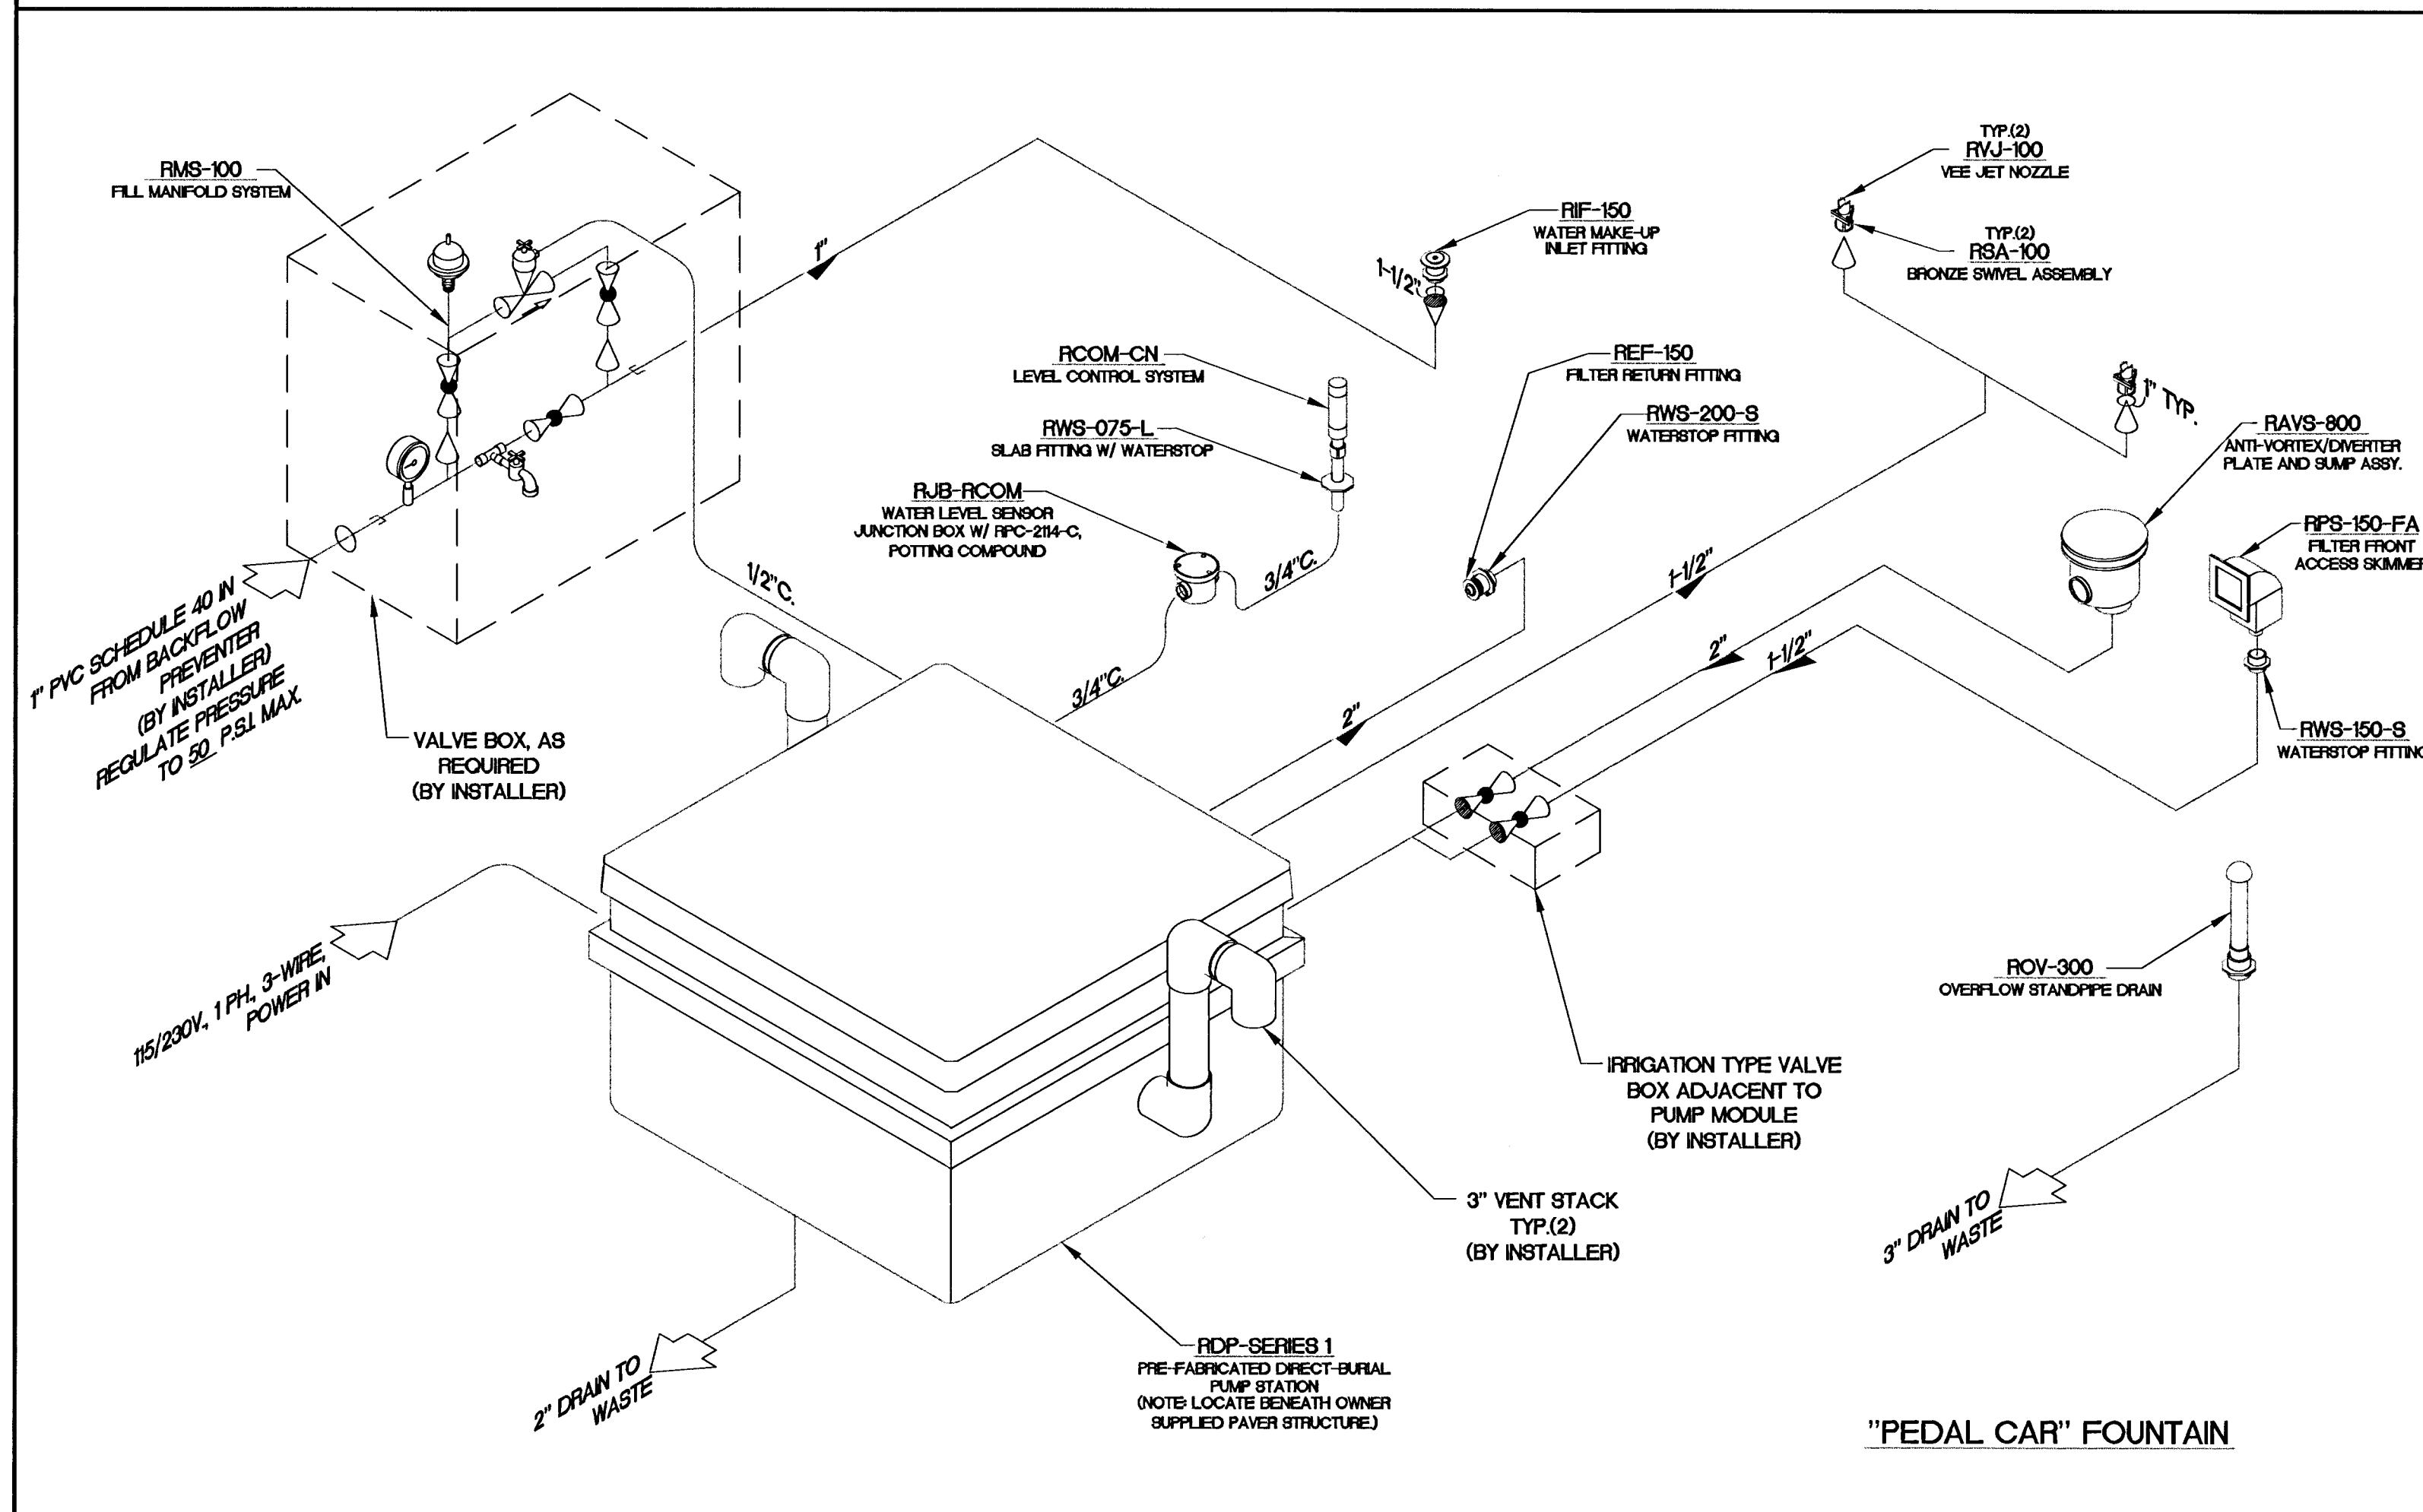
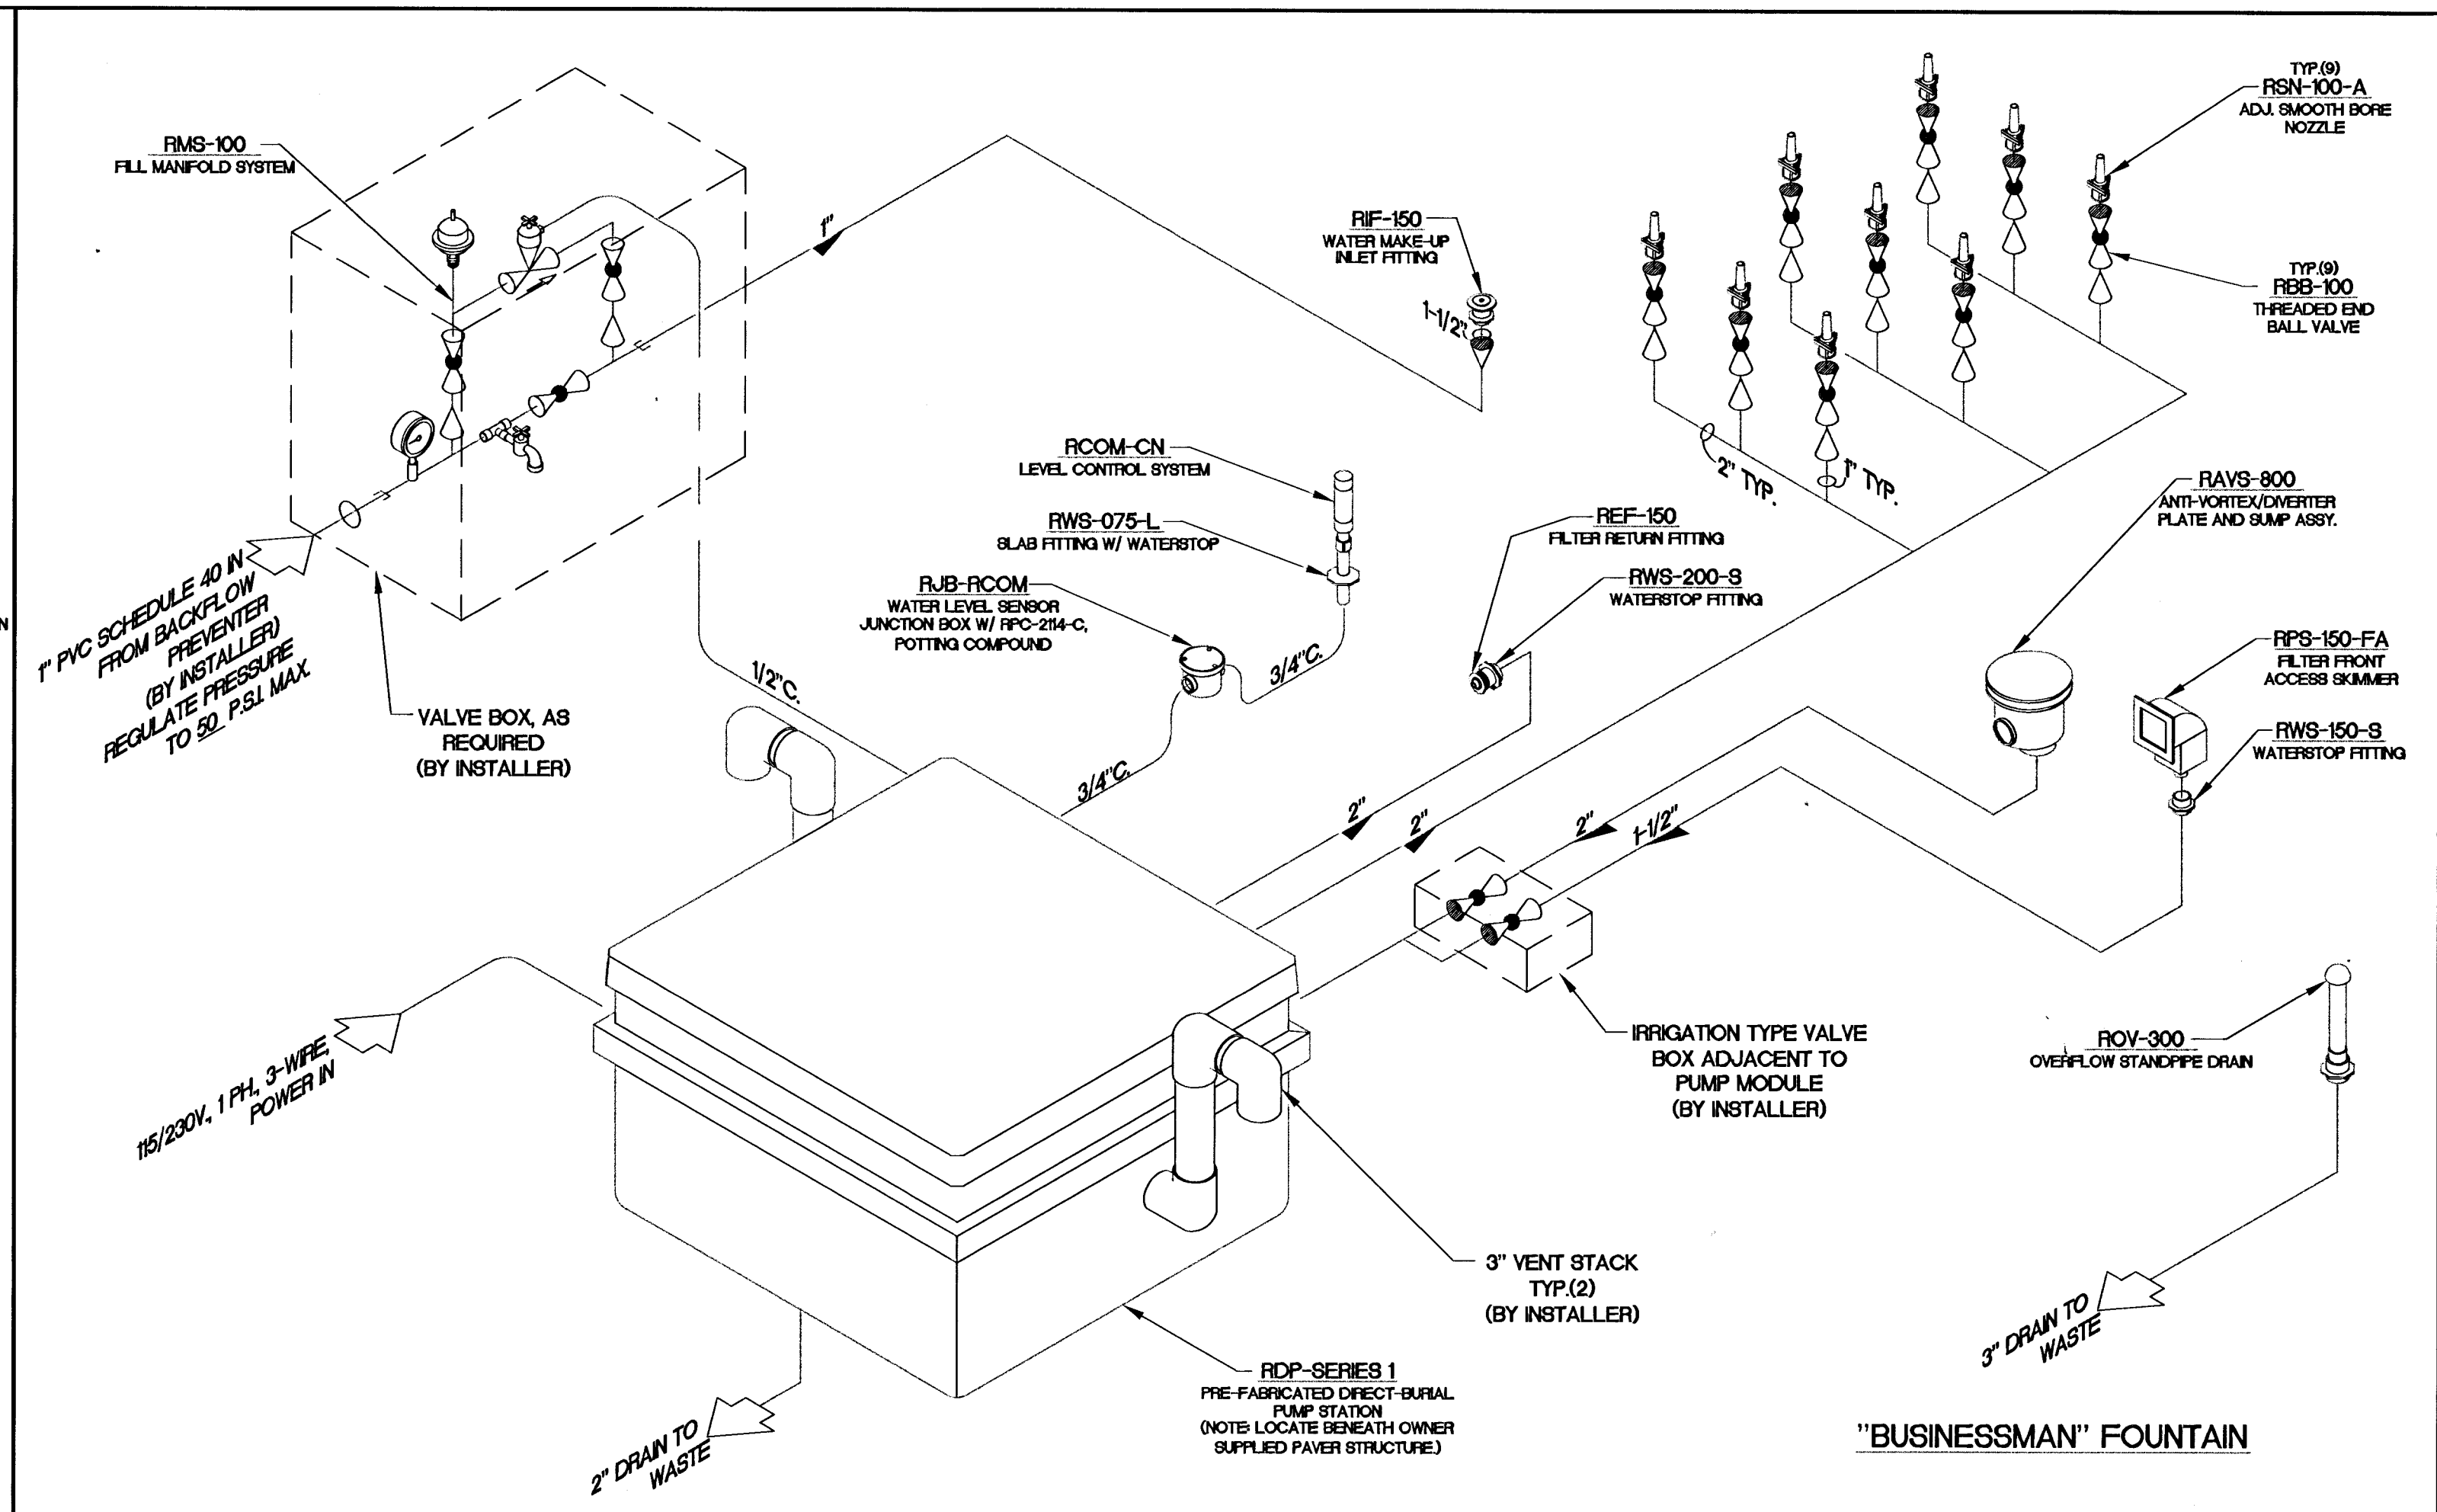


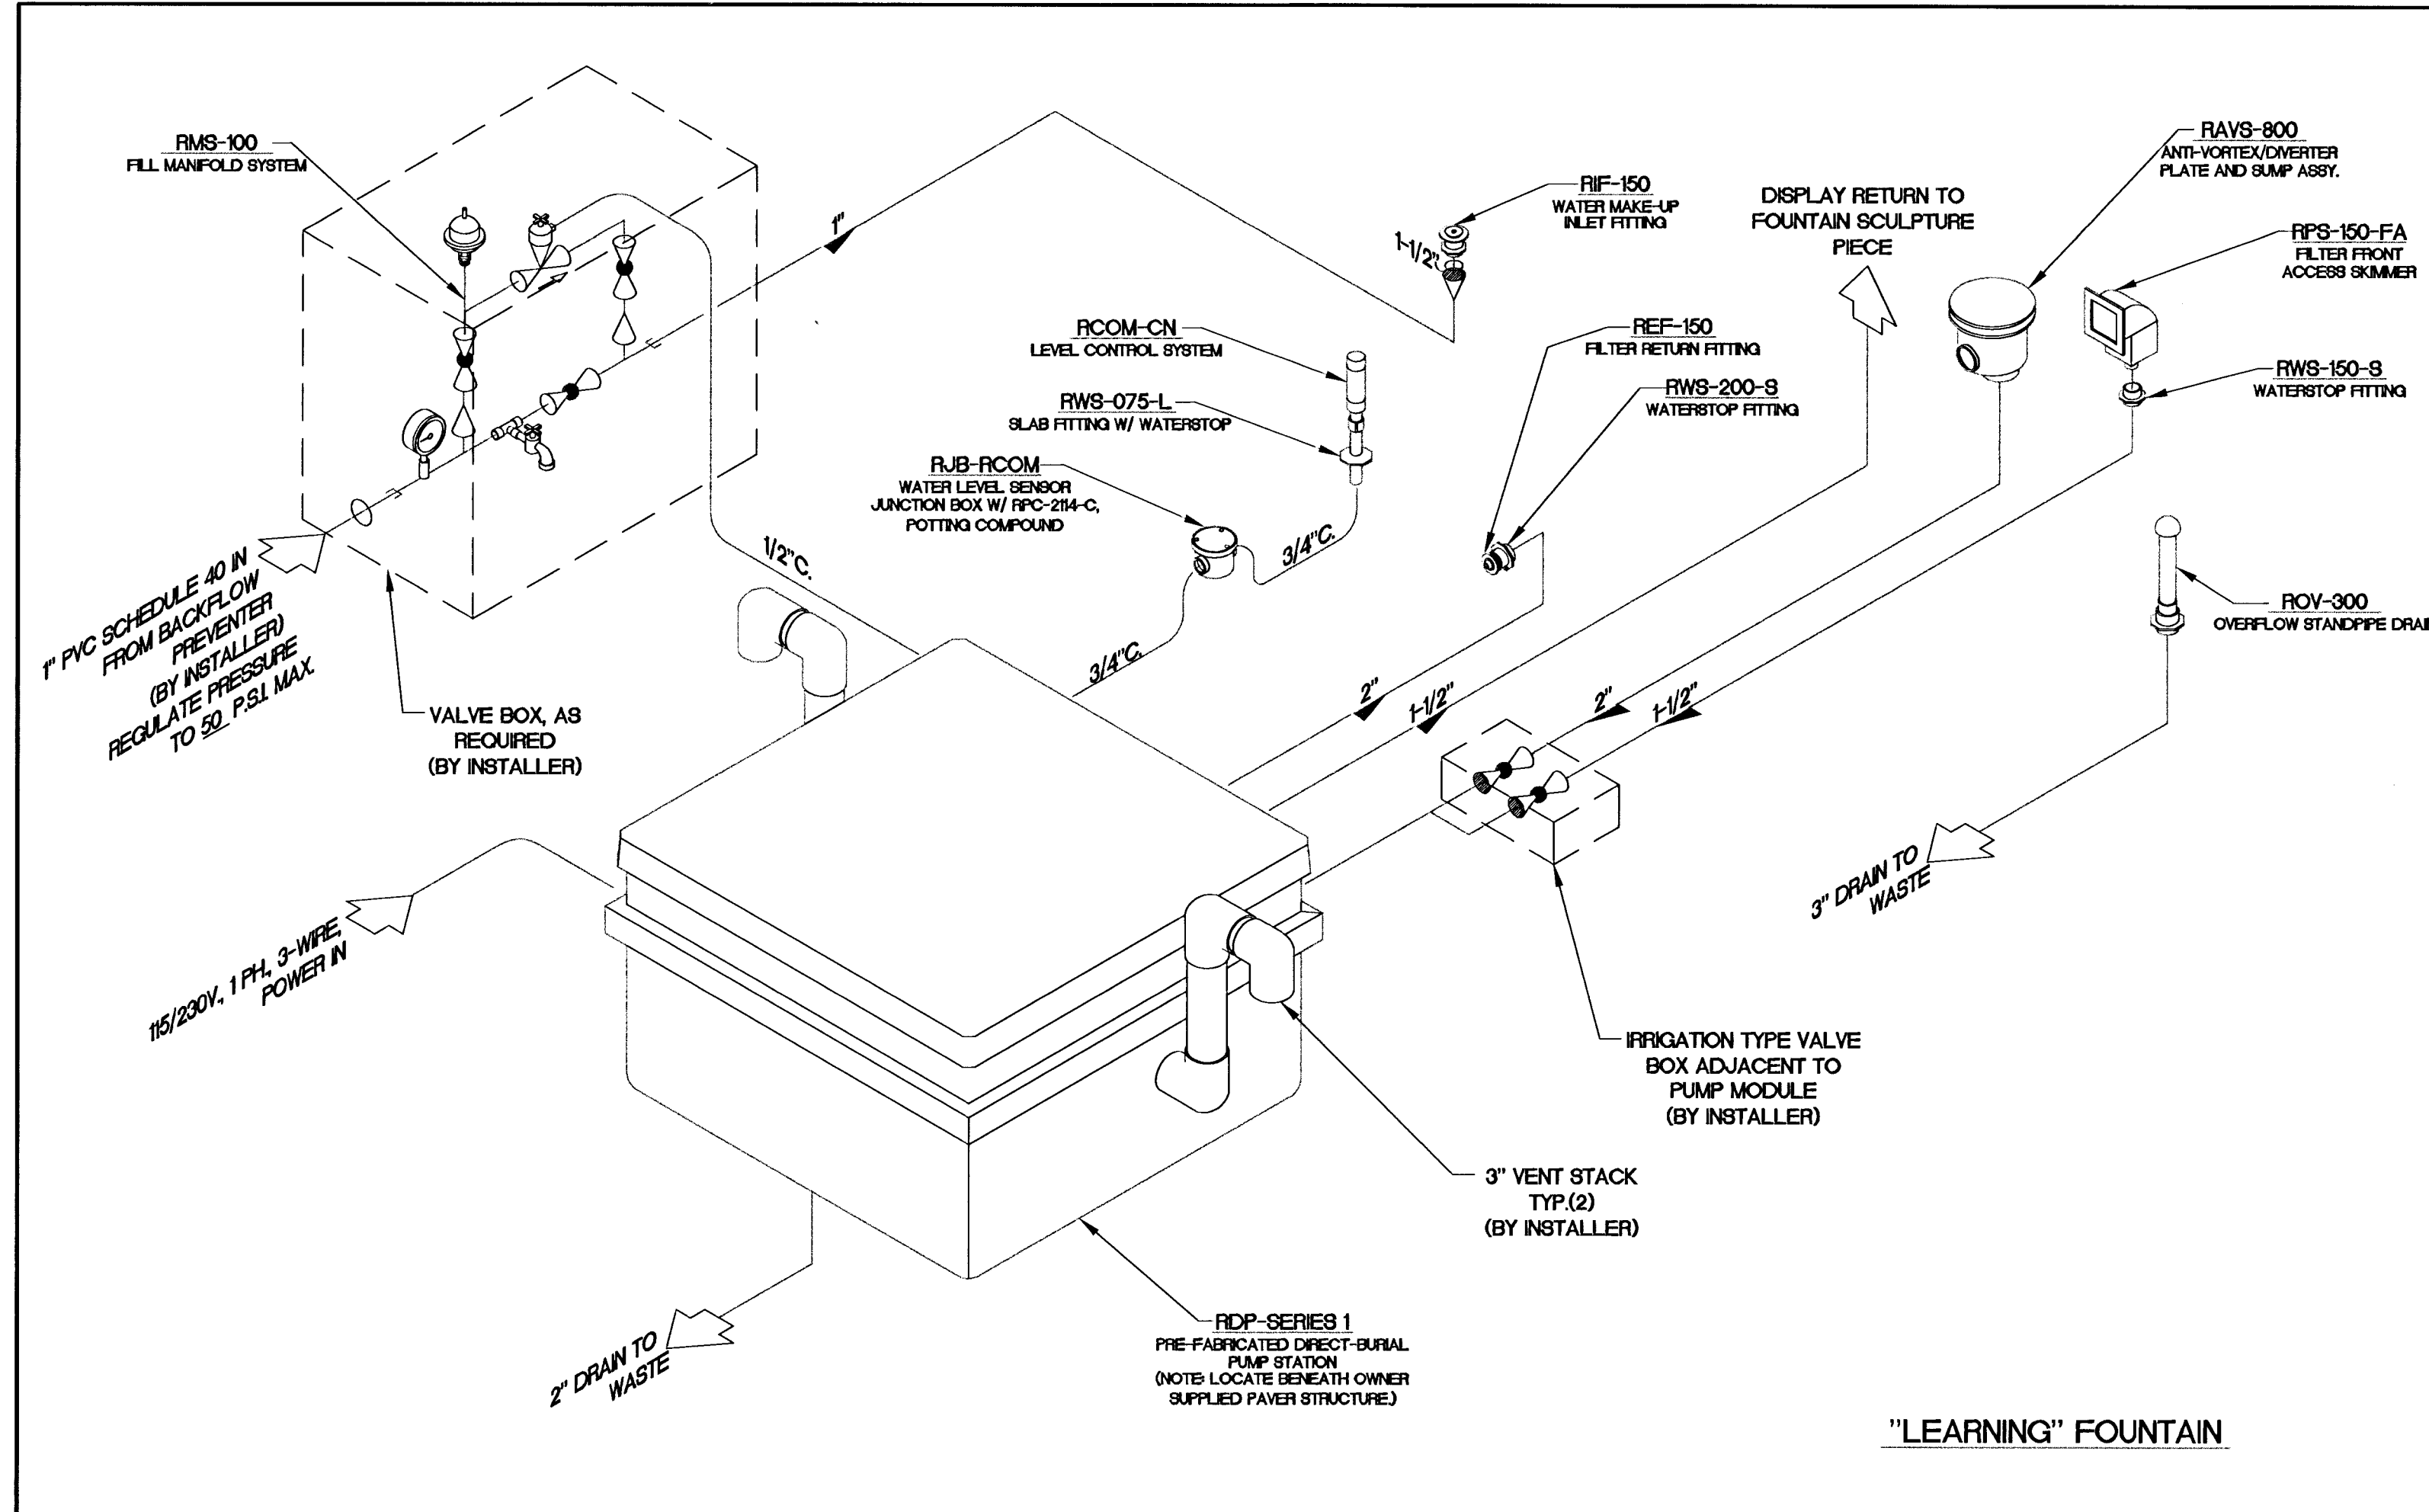

GENERAL NOTES:

- Fountain Schematics are provided for information only. Complete product data and shop drawings shall be submitted per Specifications.
- Coordinate with requirements for structural, electrical, paving and sculpture installations.
- Water supply for the fountains shall be obtained from the service side of the nearest irrigation system back flow preventer, unless otherwise approved by the Engineer. Coordinate with installation of the irrigation system.
- Fountain drains shall be connected to the nearest convenient sanitary or storm water sewer (see paving plans), and as approved by the Engineer.
- Coordinate location of fountain pump and equipment vaults with City Park and Recreation Department.
- See Specifications for vent stack location and color requirements.

NOTE: THE PROPER DESIGN, OPERATION AND PERFORMANCE OF THIS SYSTEM IS BASED ON THE SELECTION AND USE OF EQUIPMENT MANUFACTURED AND/OR SELECTED BY ROMAN FOUNTAINS CORPORATION, ALBUQUERQUE, NEW MEXICO, USA. (505) 343-8082. SUBSTITUTION OF EQUIPMENT OTHER THAN THAT SELECTED AND FURNISHED VOIDS THE SYSTEM WARRANTY AND PERFORMANCE GUARANTY AND INSTALLER ASSUMES FULL RESPONSIBILITY FOR ITS OPERATION AND PERFORMANCE.

roman fountains®

4804 Hawkins NE
Albuquerque, N.M. 87109
Phone #: (505) 343-8082
FAX #: (505) 343-8086
<http://www.romanfountains.com>

STREETSCAPES
PROJECT NAME

FOUNTAIN SCHEMATICS
SHEET TITLE

DCH
DESIGN BY:

GJR
DRAWN BY:

DCH
CHECKED BY:

APRIL 1998
DATE

SCHEMATIC(9210)
JOB NO.

LS 9.10
SHEET OF

MID-KANSAS ENGINEERING
CONSULTANTS, INC.
411 N. WEBB ROAD
WICHITA, KS. 67206
316-684-9600