




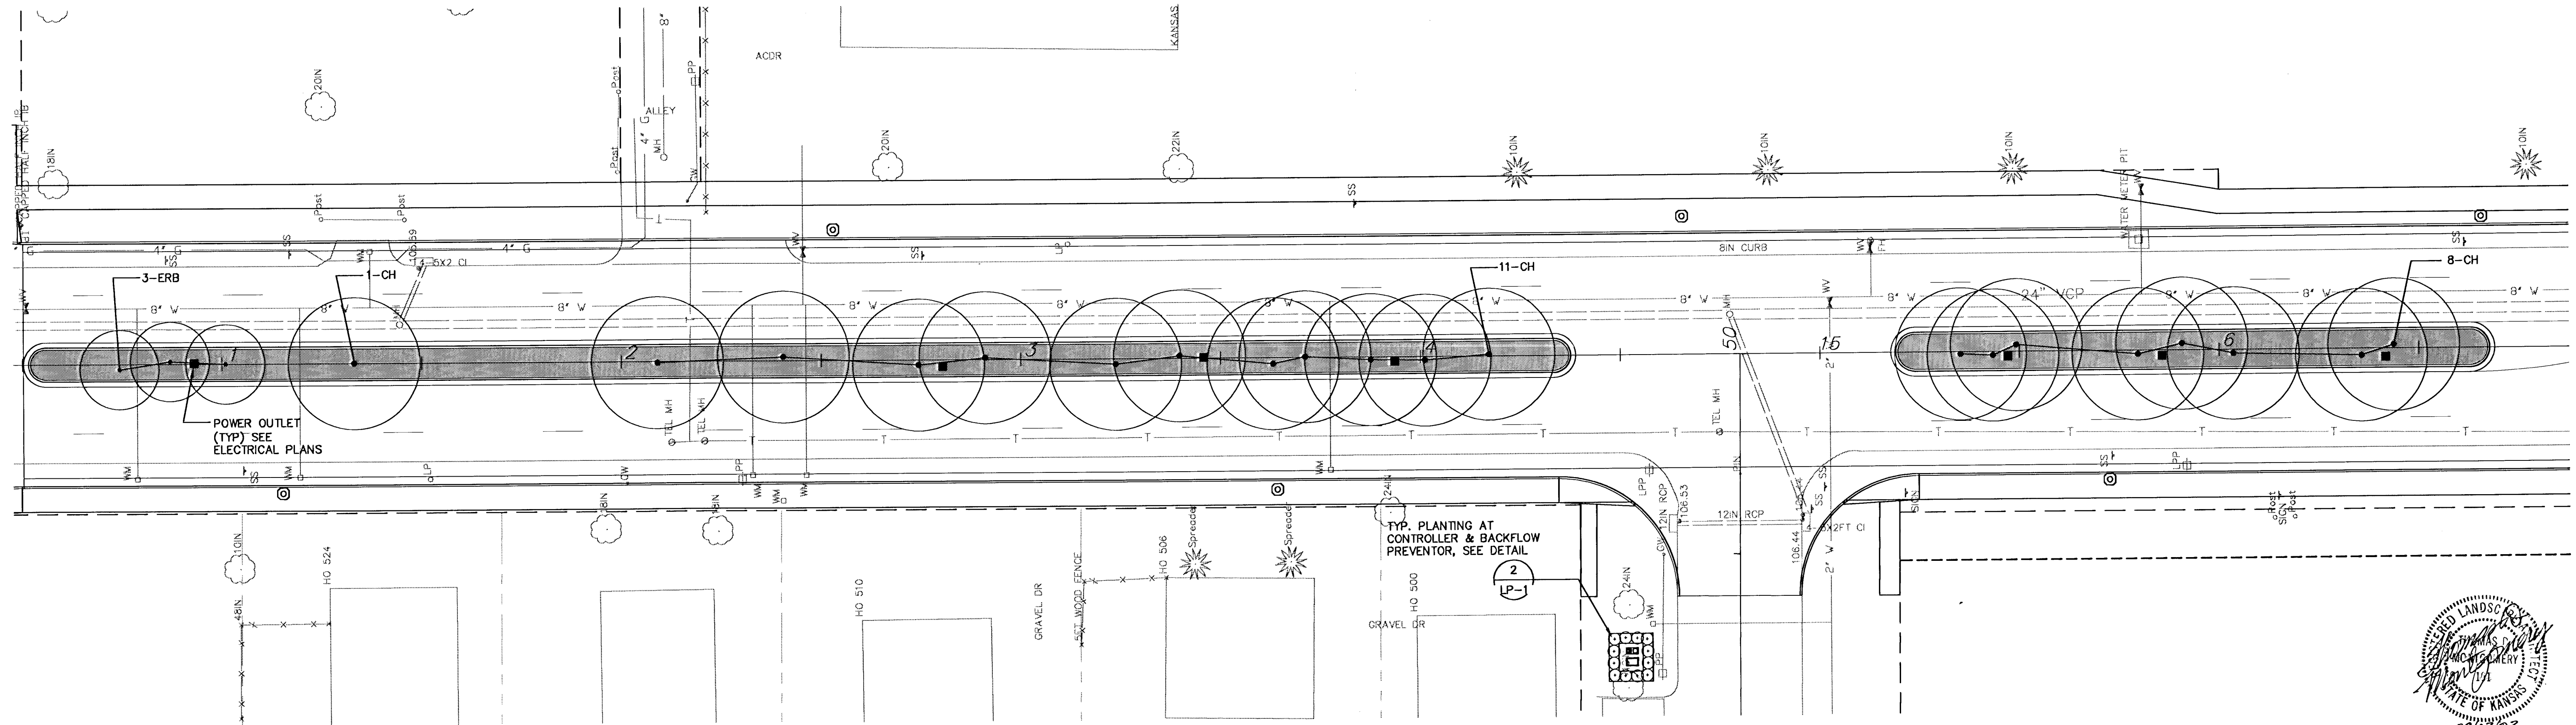

A LANDSCAPE PLAN NO. 1

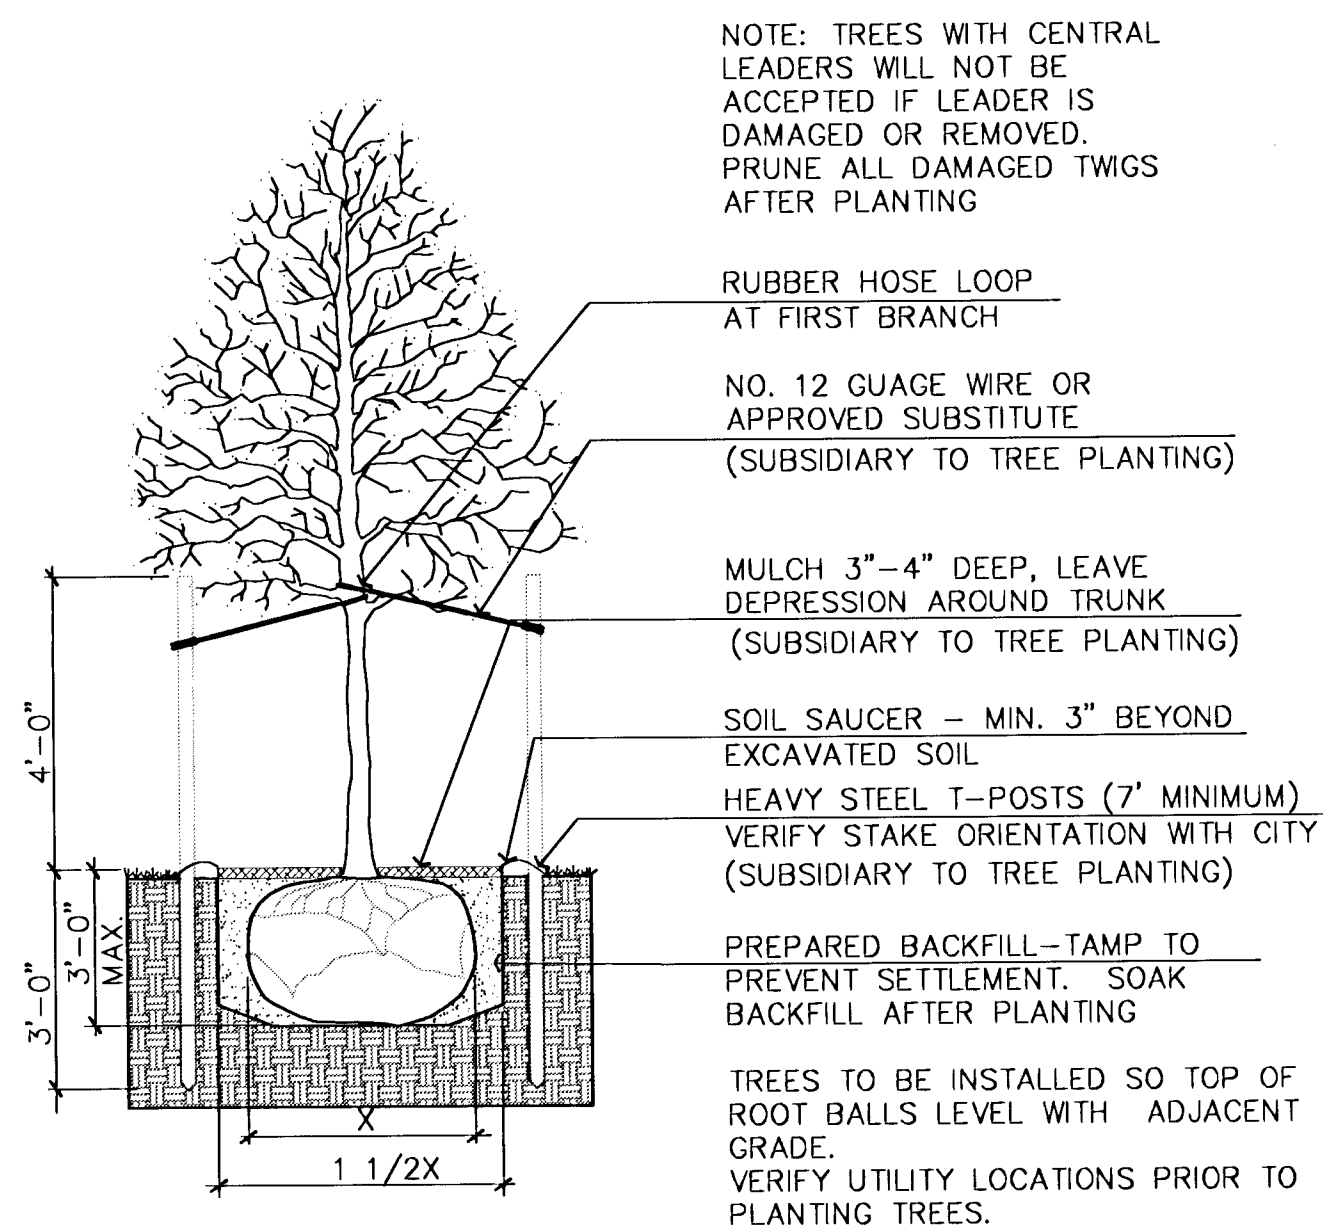


1 DECIDUOUS TREE PLANTING DETAIL

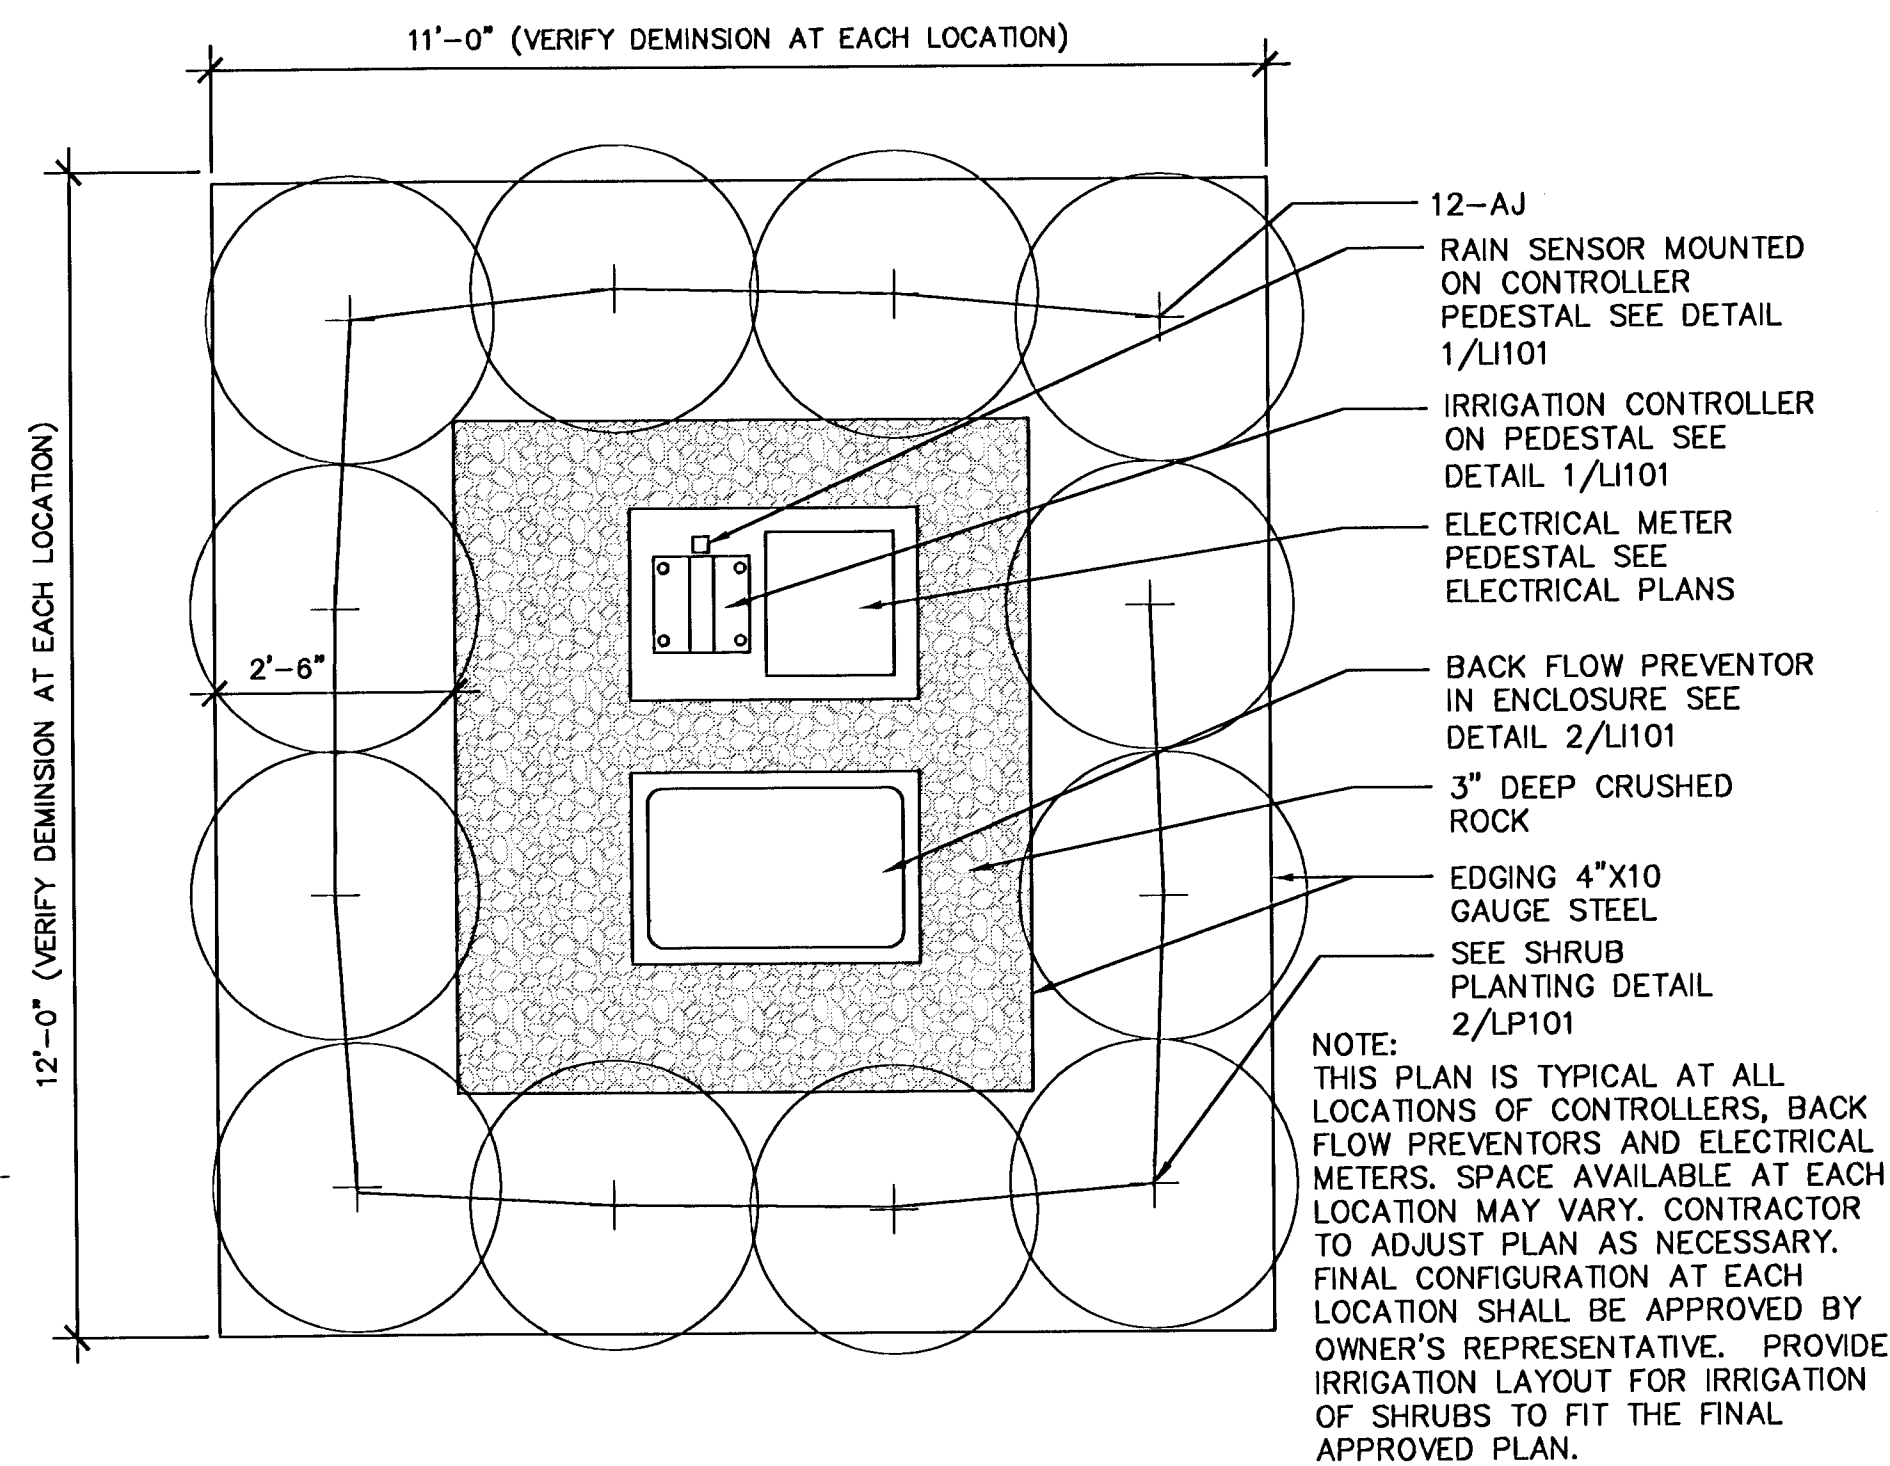

2 TYP. PLANTING AT CONTROLLER & BACKFLOW PREVENTOR

PLANT LIST

KEY	QTY.	COMMON NAME	BOTANICAL NAME	SIZE	CONDITION
DECIDUOUS TREES					
CH	45	COMMON HACKBERRY	<i>Celtis occidentalis</i>	4" cal.	Balled-in-Burlap
ERB	70	EASTERN REDBUD	<i>Cercis canadensis</i>	4" cal.	Balled-in-Burlap
AJ	48	ARMSTRONG JUNIPER	<i>Juniperus chinensis 'Armstrong'</i>	5 gal.	Container
SODDING					
	2750 S.Y.	TURF-TYPE FESCUE BLEND	<i>Festuca</i>		

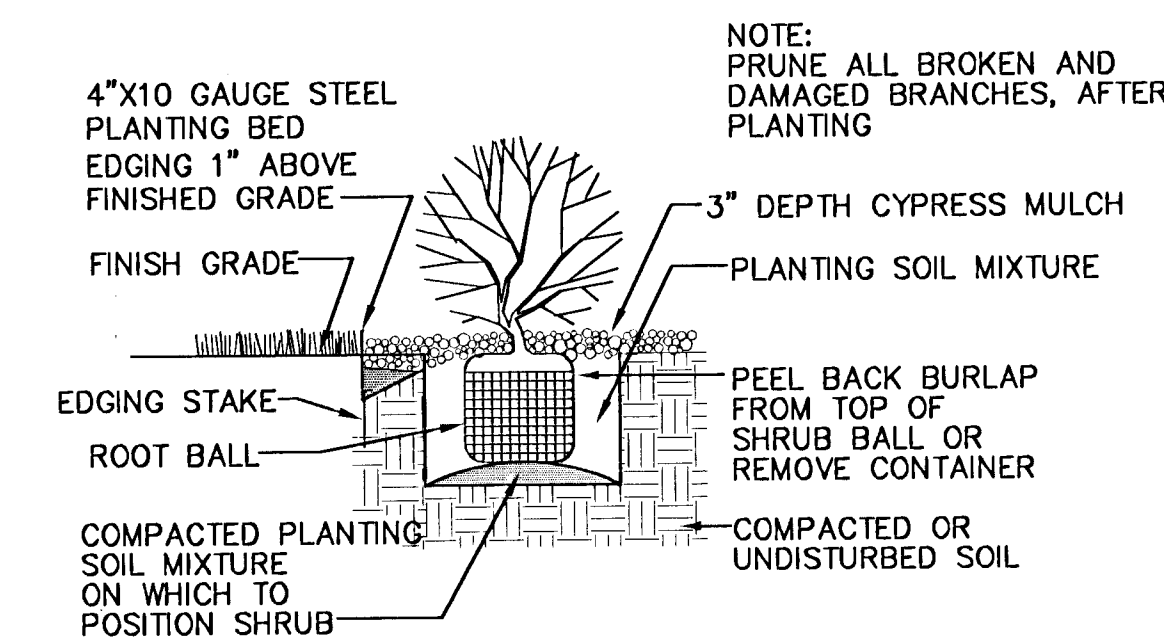

3 SHRUB PLANTING DETAIL

LEGEND


AREAS TO BE SODDED WITH A TURF-TYPE FESCUE BLEND

NEW TREES

POWER OUTLET SEE ELECTRICAL PLANS

GENERAL NOTES:

- SEE SHEET LP101 FOR DECIDUOUS TREE PLANTING DETAIL AND PLANT LIST.
- REFERENCE THE CITY OF WICHITA STANDARD SPECIFICATIONS FOR LANDSCAPE AND IRRIGATION REQUIREMENTS.
- REMOVE EXISTING SOIL IN MEDIANS TO A DEPTH OF 18" AND REPLACE WITH TOPSOIL. TOPSOIL SHALL BE APPROVED BY OWNER'S REPRESENTATIVE.

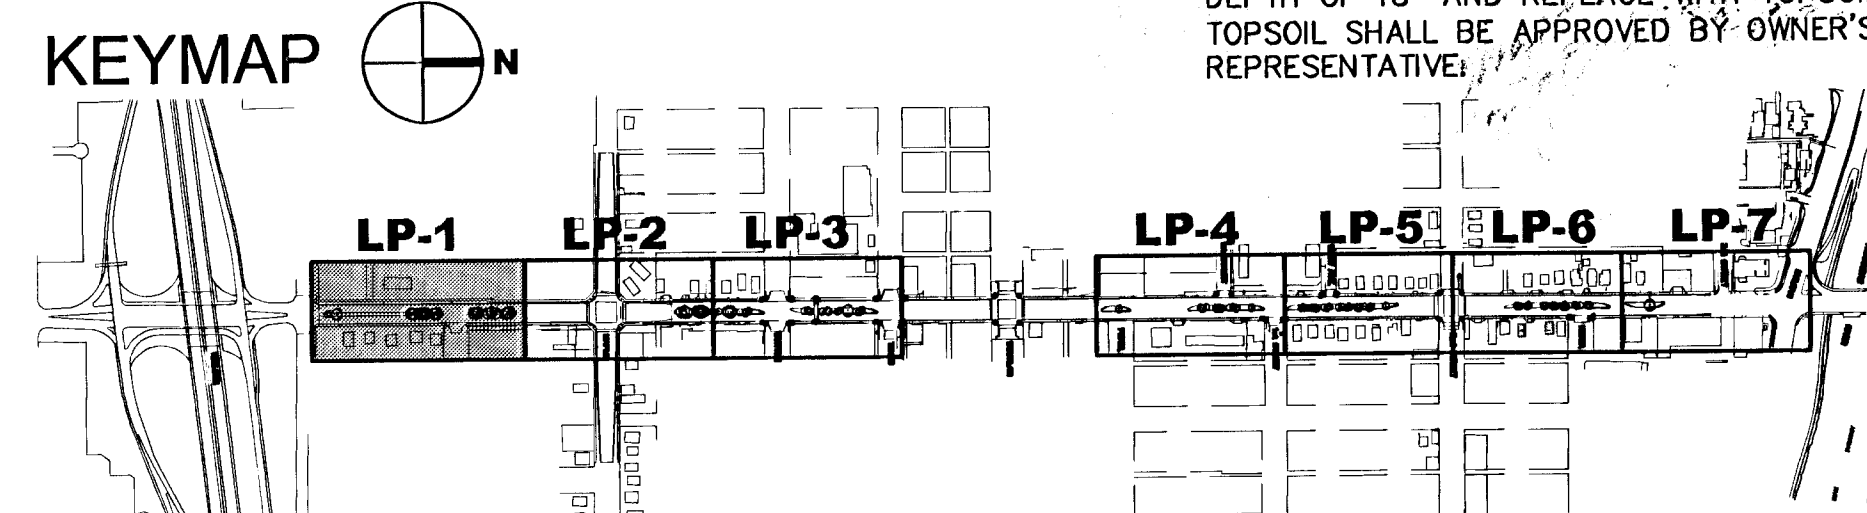

MKEC
ENGINEERING CONSULTANTS
411 N. WEBB ROAD
WICHITA, KS. 67206
316-684-9600

SENECA STREET
PROJECT NAME

LANDSCAPE PLAN NO. 1
SHEET TITLE

DESIGN BY: TDM
DRAWN BY: LES
DATE: 02/03/03

CHECKED BY: TDM
DRAWING NAME: LP101
SHEET OF: LP1 7