


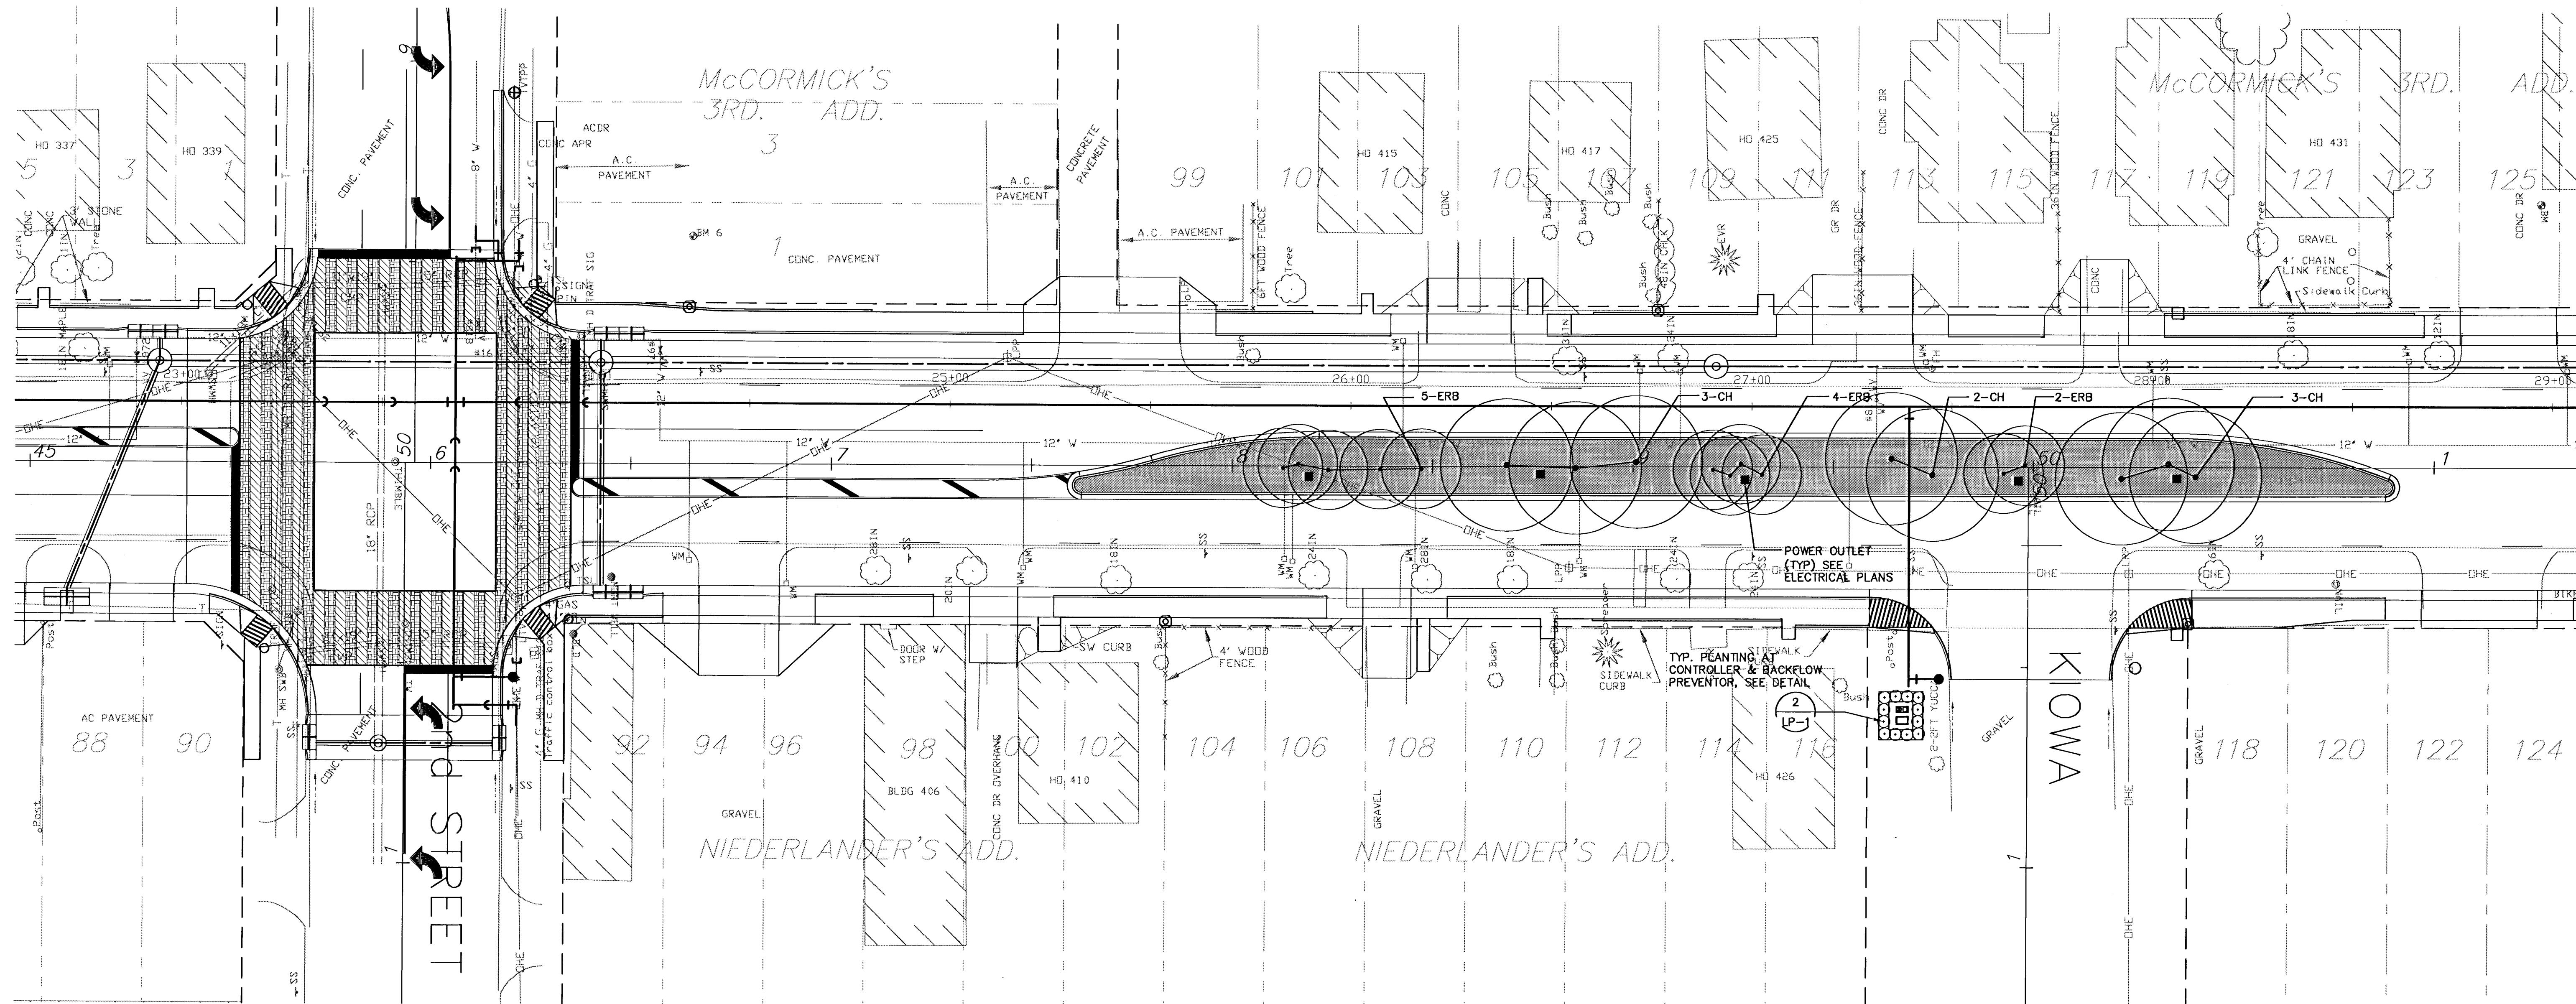


A LANDSCAPE PLAN NO. 6

0' 10' 20' 40' 1"=20.0'

LEGEND


AREAS TO BE SODDED WITH A TURF-TYPE FESCUE BLEND

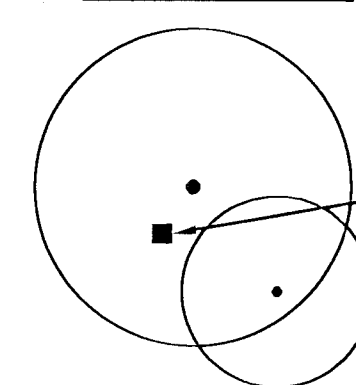

NEW TREES

POWER OUTLET SEE ELECTRICAL PLANS

KEYMAP

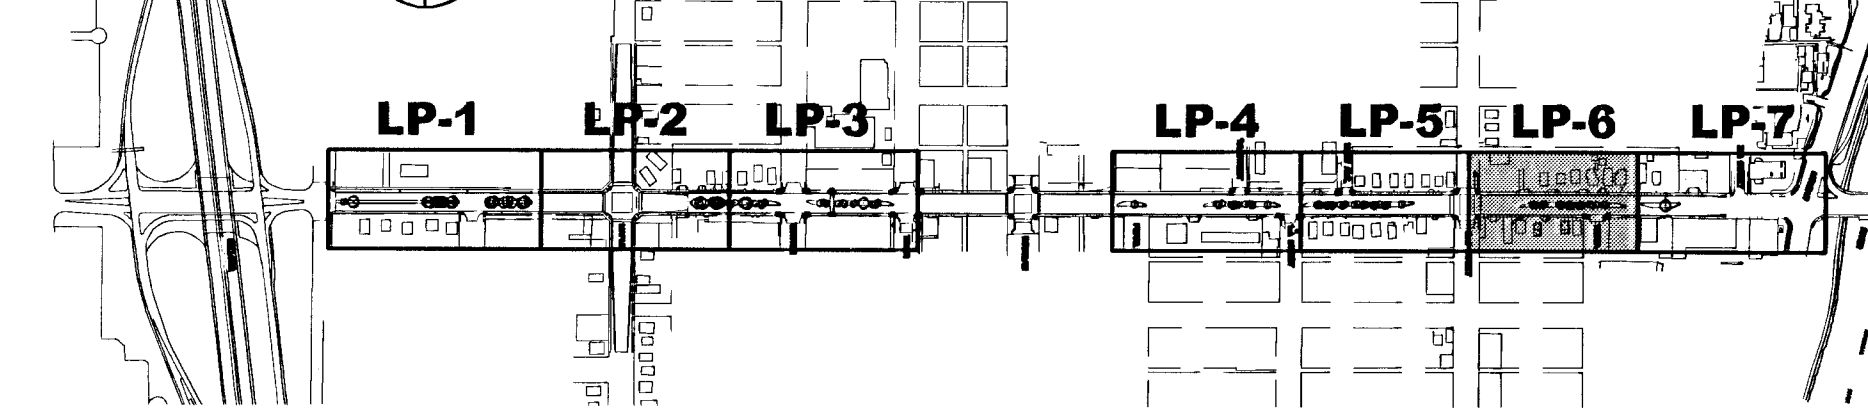

GENERAL NOTES:

1. SEE SHEET LP101 FOR DECIDUOUS TREE PLANTING DETAIL AND PLANT LIST.
2. REFERENCE THE CITY OF WICHITA STANDARD SPECIFICATIONS FOR LANDSCAPE AND IRRIGATION REQUIREMENTS.
3. REMOVE EXISTING SOIL IN MEDIANS TO A DEPTH OF 18" AND REPLACE WITH TOPSOIL. TOPSOIL SHALL BE APPROVED BY OWNER'S REPRESENTATIVE.



SENECA STREET
PROJECT NAME

LANDSCAPE PLAN NO. 6
SHEET TITLE

DESIGN BY:
DATE

LES
DRAWN BY:
DRAWING NAME

TDM
CHECKED BY:
SHEET 7 OF 7

LP106
DATE

LP6
SHEET 7 OF 7