

**SHEET SCHEDULES**

**ARCHITECTURAL**

| NO.               | CONTENT   |
|-------------------|---|
| 1                 | EXISTING/NEW SITE PLAN                          |
| 1A                | PLANT/SCREEN ADDITION                           |
| 1B                | SEAL/CONCRETE ADDITION                          |
| 2                 | FLOOR PLAN                                      |
| 3                 | ROOM FINISH SCHEDULE/WALL CONDITIONS            |
| 4                 | DOOR SCHEDULES/DOOR DETAILS                     |
| 5                 | ELEVATIONS                                      |
| 6                 | 1/2" BUILDING SECTIONS                          |
| 7                 | 3/4" WALL SECTIONS                              |
| 8                 | 3/4" BUILDING SECTIONS (PENTHOUSE/COILING DUCT) |
| 9                 | 3/4" BUILDING SECTIONS (LOBBY/STAIR CASES)      |
| 10                | ROOF PLAN/EXTERIOR SITE DETAILS                 |
| 11                | INTERIOR ROOM ELEVATIONS                        |
| 12                | LOBBY MILLWORK/PA PARTITIONS                    |
| 13                | W.C. DETAILS/MANHOLE DETAILS                    |
| 14                | REFLECTED CEILING PLAN                          |
| 15                | LANDSCAPE PLAN                                  |
| 16                | LAWN IRRIGATION PLAN                            |
| <b>STRUCTURAL</b> |   |
| S1                | FOUNDATION PLAN - S-1 DETAILS                   |
| S2                | ROOF FRAMING PLAN                               |
| <b>MECHANICAL</b> |   |
| M1                | M-1 MECH. R.V. P.L.R. PLAN                      |
| M2                | M-2 PLUMBING P.L.R. PLAN - M-2 DETAIL SHEET     |
| M3                | M-3 HVAC P.L.R. PLAN - M-3 DETAIL SHEET         |
| M4                | M-4 MECH. CENTER                                |
| <b>ELECTRICAL</b> |   |
| E1                | E-1 ELECTRICAL P.L.R. PLAN                      |
| E2                | E-2 PARTIAL BLDG. PLAN/PANEL SCHEDULES          |

**BZA48**

**NEW SITE PLAN 1"=40'-0"**


GRADES TO FALL UNIFORMLY & RADIIALLY FROM 115.0 HIGH POINT (N 210 MARKING). EXISTING TREE LOCATIONS TO BE VERIFIED. TREE IN RED FOR OPERATIONS. TREE LOCATIONS & SHADES ARE APPROXIMATE.

**LEGENDS**

|   |   |
|---|---|
| <p><b>REFERENCES:</b></p> <p>SECTION NO. BUILDING SECTION</p> <p>SECTION NO. WALL SECTION</p> <p>SECTION NO. PARTIAL BLDG. SECTION</p> <p>SCHEDULE NO. DOOR REFERENCE</p> <p>WALL NUMBER REFERENCE</p> <p>DETAIL NO. REFERENCE</p> <p>FLYING REFERENCE</p> <p>RM. NO. REFERENCE</p> <p>REF. SYMBOL BY REFERENCE</p> | <p><b>BLDG. MATLS.</b></p> <p>CONC. MASS UNITS</p> <p>FACE BRICK</p> <p>PG-FASCAD</p> <p>CAST CONC.</p> <p>MTL STUD PARTITION</p> <p>GYP DO</p> <p>STPL</p> <p>ALUMINUM</p> <p>ROOF INSUL</p> <p>BATT INSUL</p> <p>PLYWOOD</p> <p>TOUGH FRAMING</p> |
|---|---|

REVISED

TOTAL PROJECT AREA = 76,800'²  
 BLDG. AREA = 23,800'²  
 FUTURE ADDITIONS = 4,000'²  
 PARKING AREA = 26,000'²  
 ASCEND, STG. = 7,000'²  
 RESTROOMS, ELEVATORS, STG. = 11,000'²  
 LANDSCAPE, BLDG. = 2,177'²  
 TOTAL OCCUPANTS = 1,157  
 TYPE 2 + CONSTRUCTION  
 \*SCALE = 1/8" = 24,000' x 250' = 78'

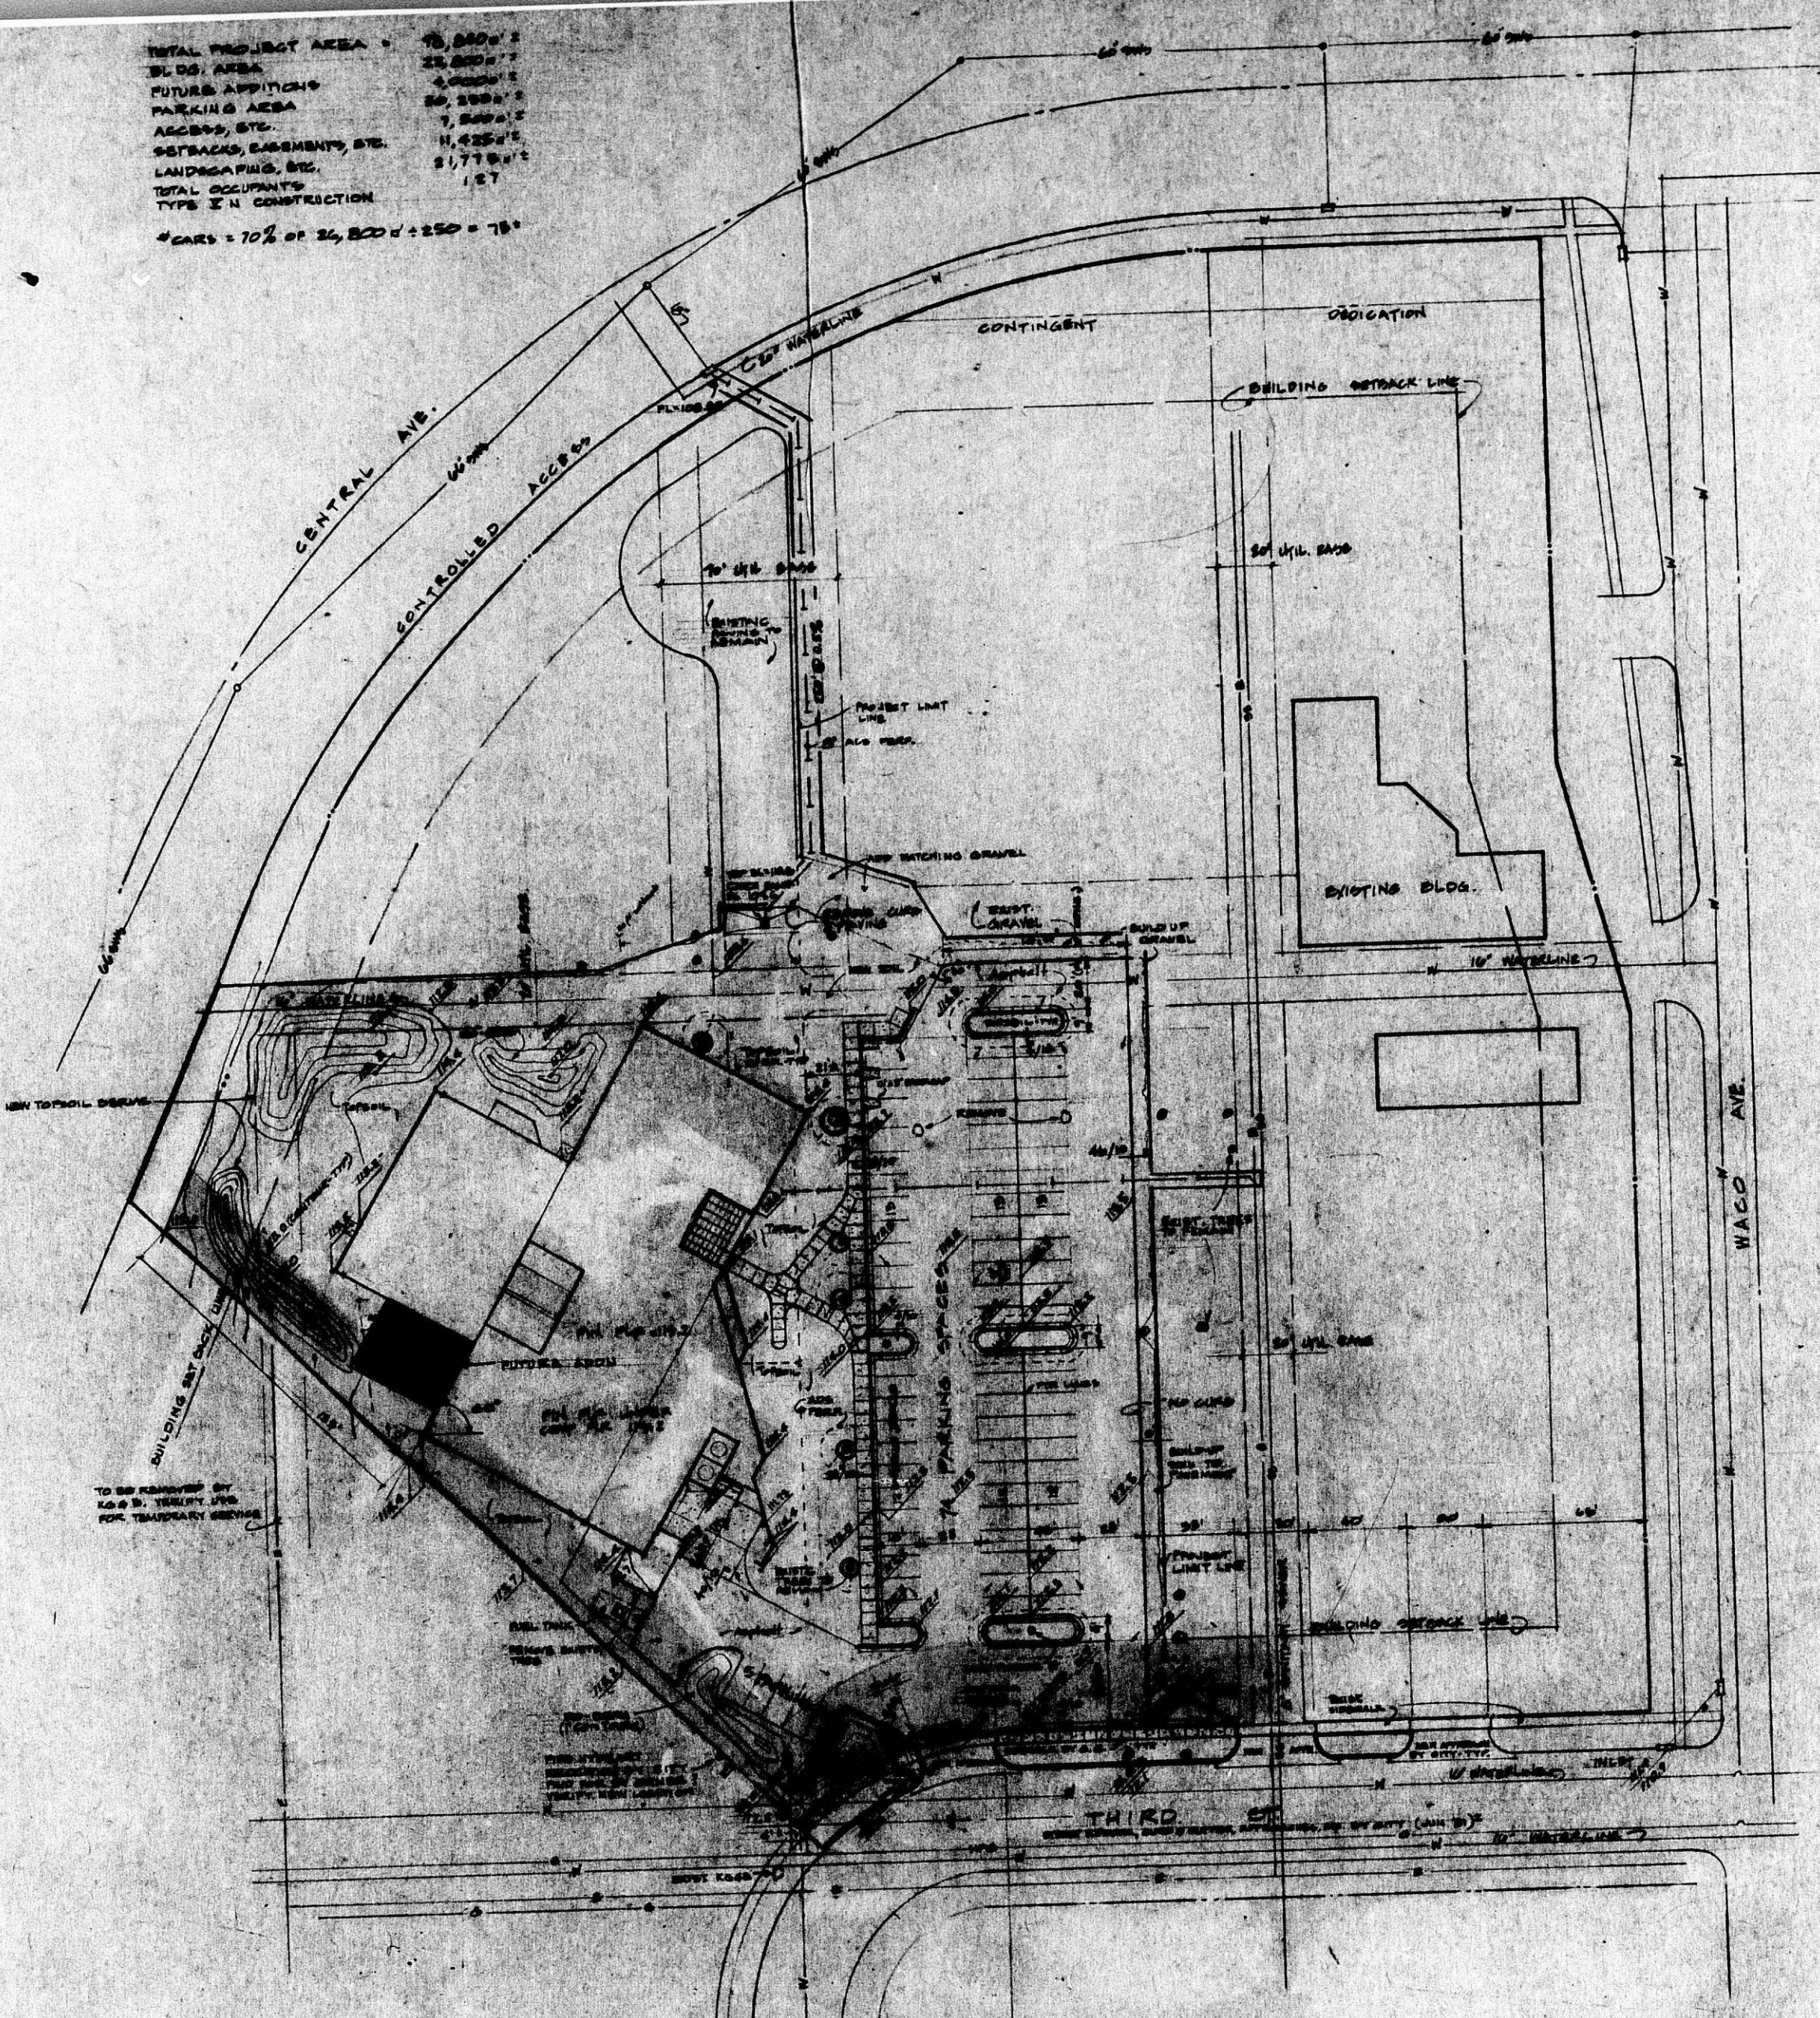

BZA 4-81

BZA 4-81

**SHEET SCHEDULE**

**ARCHITECTURAL**

| NO.               | CONTENT                               |
|-------------------|---------------------------------------|
| 1                 | EXISTING/NEW SITE PLAN                |
| 1A                | PLATTENBERGER ADDITION                |
| 2                 | GRADE PLAN/EMBANKMENT ADDITION        |
| 3                 | FLOOR PLAN                            |
| 4                 | ROOM FINISH SCHEDULE/WALL CONNECTIONS |
| 4A                | DOOR SCHEDULE/DOOR DETAILS            |
| 5                 | ELEVATIONS                            |
| 6                 | WALL SECTIONS                         |
| 7                 | WALL SECTIONS                         |
| 8                 | WALL SECTIONS (PARTIALS/COILING OVER) |
| 9                 | WALL SECTIONS (W/STY PLUMBING/GUAGES) |
| 10                | ROOF PLAN/EXTERIOR SITE DETAILS       |
| 11                | INTERIOR ROOM ELEVATIONS              |
| 12                | W/STY MILLWORK/PA PARTITIONS          |
| 13                | W/STY DETAILS/LANDMARK DETAILS        |
| 14                | REFLECTED CEILING PLAN                |
| 15                | LANDSCAPE PLAN                        |
| 16                | LAWN IRRIGATION PLAN                  |
| <b>STRUCTURAL</b> |                                       |
| S-1               | FOUNDATION PLAN - S-1 DETAILS         |
| S-2               | ROOF FRAMING PLAN                     |
| <b>MECHANICAL</b> |                                       |
| M-1               | M-1 MECH. PLAN                        |
| M-2               | M-2 MECH. PLAN                        |
| M-3               | M-3 MECH. PLAN                        |
| M-4               | M-4 MECH. PLAN                        |
| M-5               | M-5 MECH. PLAN                        |
| M-6               | M-6 MECH. PLAN                        |
| M-7               | M-7 MECH. PLAN                        |
| M-8               | M-8 MECH. PLAN                        |
| M-9               | M-9 MECH. PLAN                        |
| M-10              | M-10 MECH. PLAN                       |
| M-11              | M-11 MECH. PLAN                       |
| M-12              | M-12 MECH. PLAN                       |
| M-99              | M-99 MECH. PLAN                       |
| M-100             | M-100 MECH. PLAN                      |
| <b>ELECTRICAL</b> |                                       |
| E-1               | ELECTRICAL PLAN - E-1                 |
| E-2               | ELECTRICAL PLAN - E-2                 |
| E-3               | ELECTRICAL PLAN - E-3                 |
| E-4               | ELECTRICAL PLAN - E-4                 |
| E-5               | ELECTRICAL PLAN - E-5                 |
| E-6               | ELECTRICAL PLAN - E-6                 |
| E-7               | ELECTRICAL PLAN - E-7                 |
| E-8               | ELECTRICAL PLAN - E-8                 |
| E-9               | ELECTRICAL PLAN - E-9                 |
| E-10              | ELECTRICAL PLAN - E-10                |
| E-11              | ELECTRICAL PLAN - E-11                |
| E-12              | ELECTRICAL PLAN - E-12                |
| E-99              | ELECTRICAL PLAN - E-99                |
| E-100             | ELECTRICAL PLAN - E-100               |

**LEGENDS**

| REFERENCE | DESCRIPTION                      |
|-----------|----------------------------------|
| 1         | SECTION NO. BUILDING SECTION     |
| 2         | SECTION NO. WALL SECTION         |
| 3         | SECTION NO. PARTIAL BLDG SECTION |
| 4         | SCHEDULE NO. DOOR REFERENCE      |
| 5         | WALL NUMBER REFERENCE            |
| 6         | WALL NUMBER REFERENCE            |
| 7         | WALL NUMBER REFERENCE            |
| 8         | WALL NUMBER REFERENCE            |
| 9         | WALL NUMBER REFERENCE            |
| 10        | WALL NUMBER REFERENCE            |
| 11        | WALL NUMBER REFERENCE            |
| 12        | WALL NUMBER REFERENCE            |
| 99        | WALL NUMBER REFERENCE            |
| 100       | WALL NUMBER REFERENCE            |

**NEW SITE PLAN** 1"=40'-0"  
 GRADES TO FALL UNIFORMLY & RADIIALLY FROM 118.0 HIGH POINT (N. END PARKING).  
 EXISTING TREE LOCATIONS TO BE VERIFIED. TRIM AS REQ'D FOR OPERATIONS.  
 BUSH LOCATIONS & SHAPES ARE APPROXIMATE.

**BLDG. MATLS.**

|          |                     |
|----------|---------------------|
| [Symbol] | CONC. MASS UNITS    |
| [Symbol] | FACE BRICK          |
| [Symbol] | PC-FACED            |
| [Symbol] | CAST CONC.          |
| [Symbol] | MTL. STD. PARTITION |
| [Symbol] | STY. BR.            |
| [Symbol] | STYL.               |
| [Symbol] | ALUMINUM            |
| [Symbol] | ROOF INSUL.         |
| [Symbol] | STY. WEL.           |
| [Symbol] | PLYWOOD             |
| [Symbol] | TOUGH FRAMES        |