



PLOTTED: Friday, August 01, 2025 @ 11:07AM

J:\PROJECTS\2023\2301010431\_COW\_WDC\_BRIDGE REPLACEMENT AT 15TH STREET\00\_230431\_CADD\SHR1\10\_BLDG MEP/ELECTRICAL DETAILS.DWG

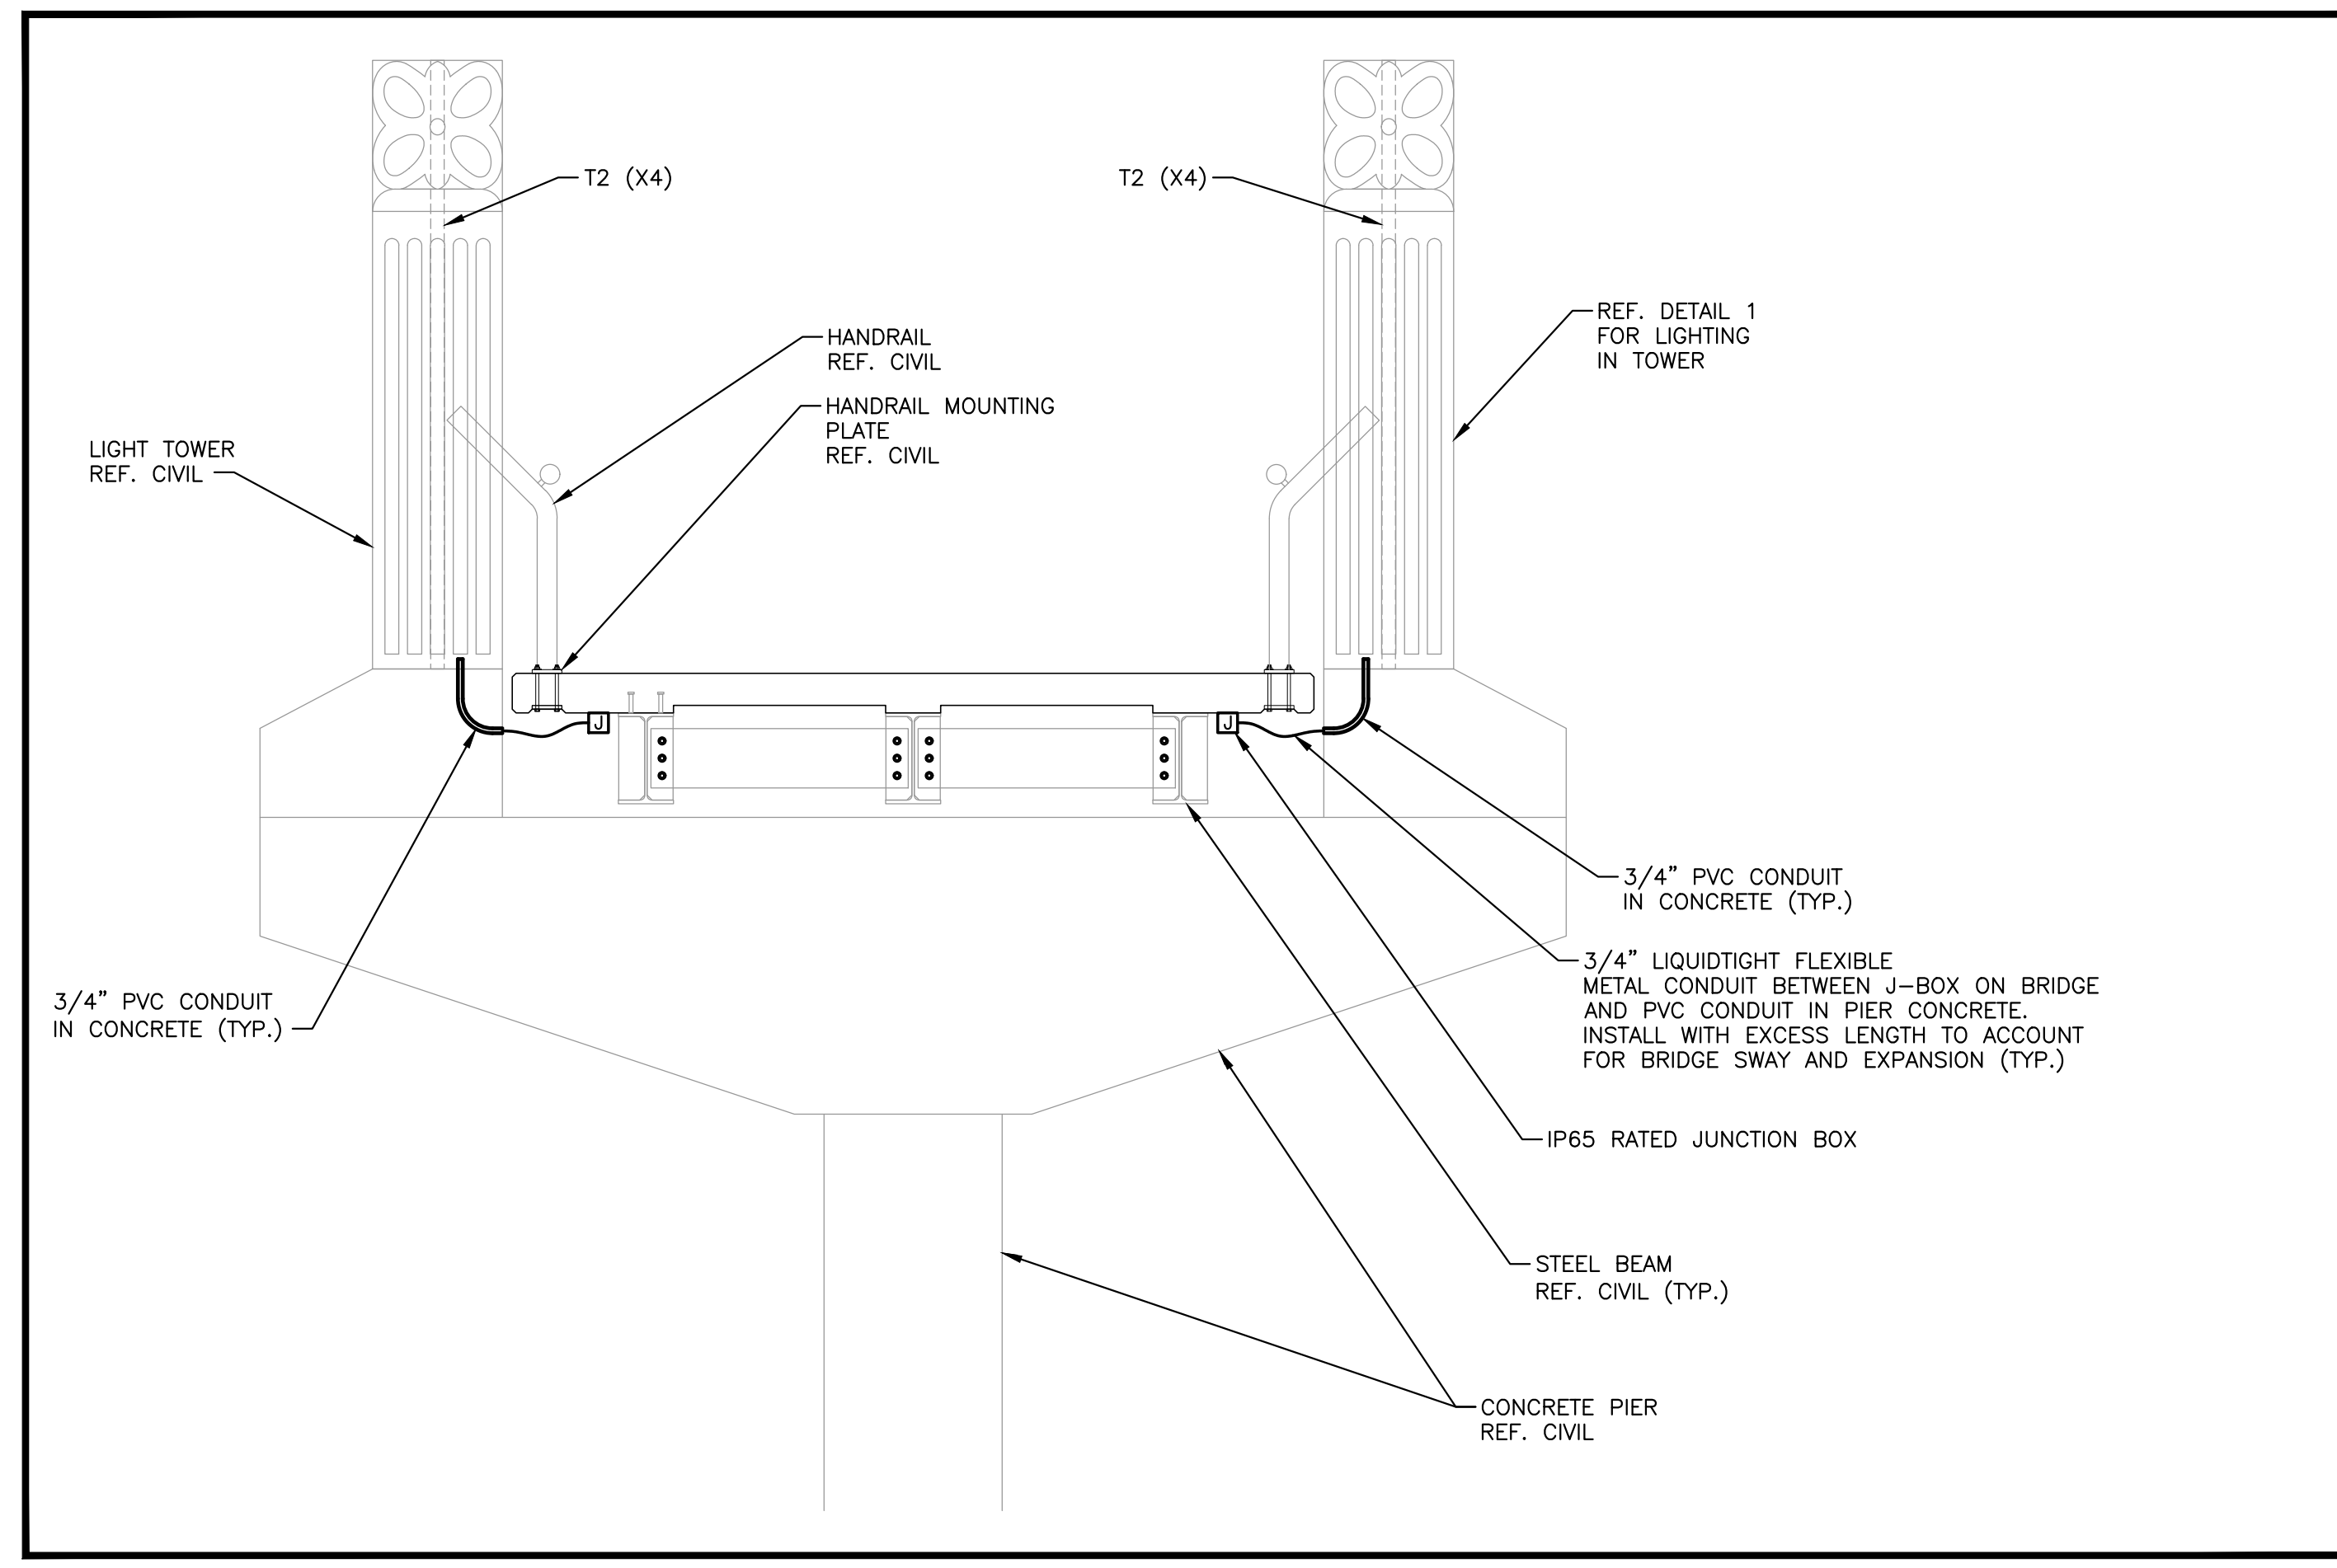

**2** SLAB & PIER CONDUIT ROUTING DETAIL  
SCALE: 3/8"=1'-0"

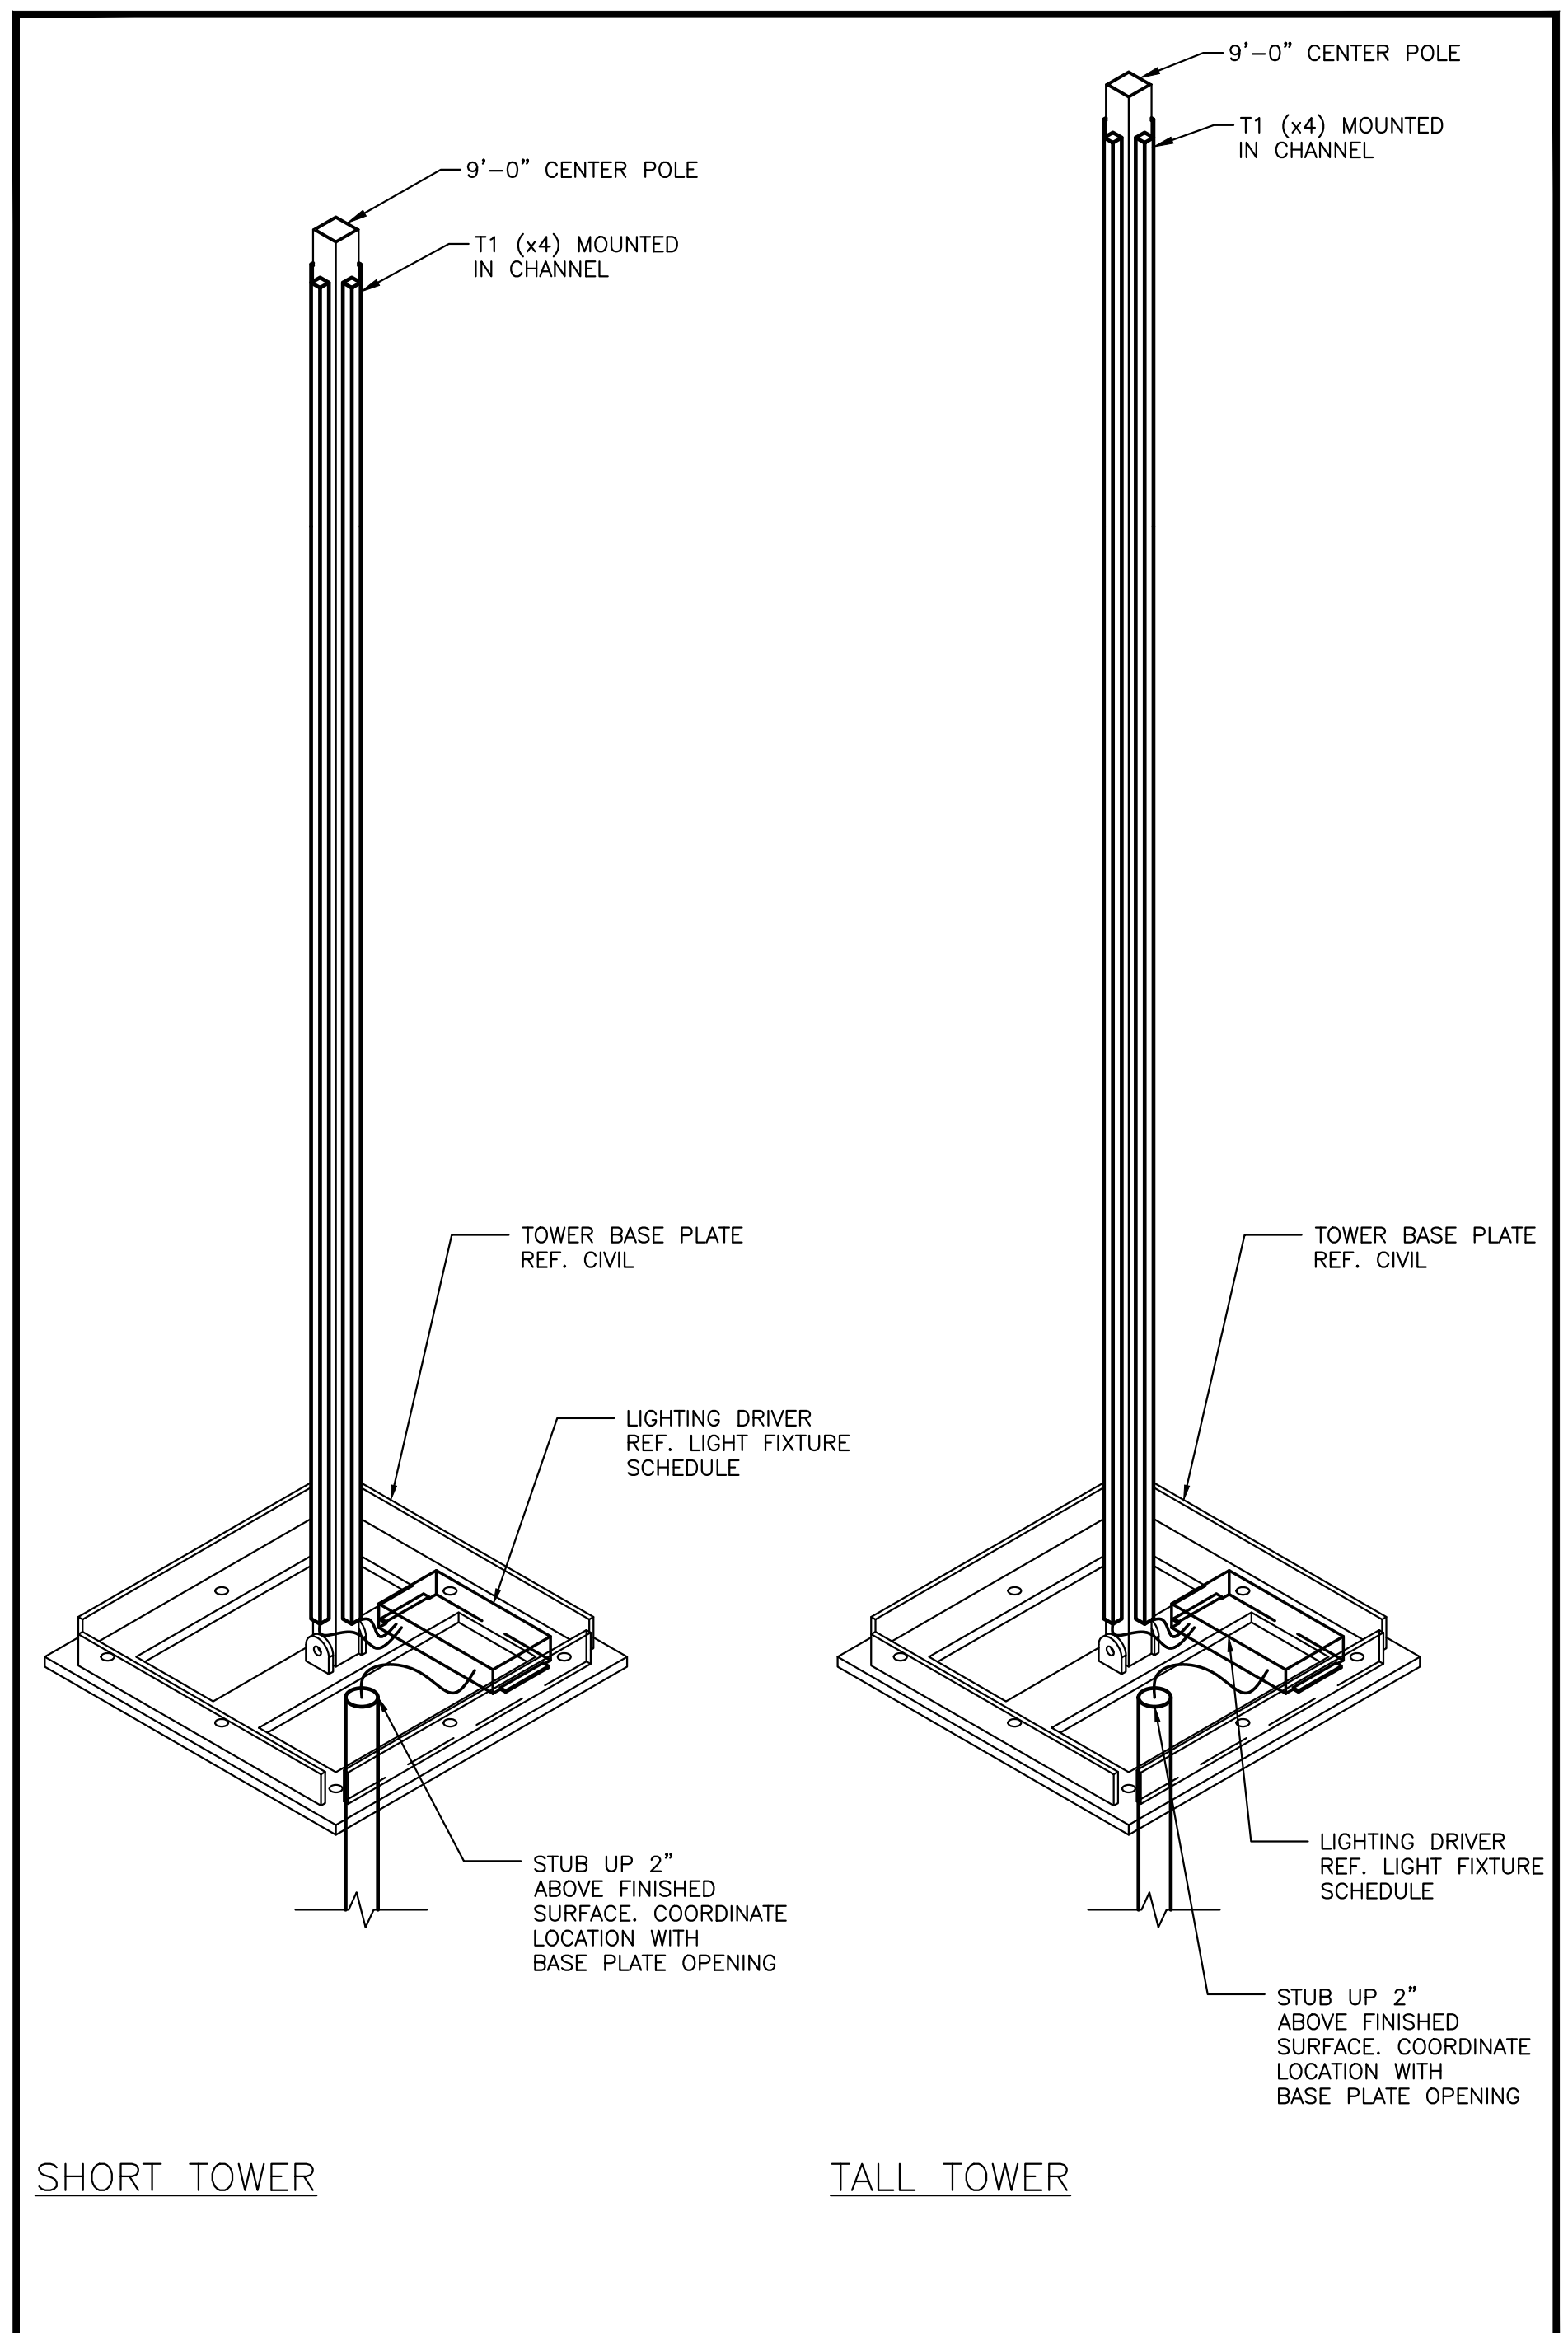

**1** LIGHT TOWER DETAIL  
SCALE: 1"=1'-0"



IMPROVEMENT PLANS FOR  
**15TH STREET BRIDGE OVER THE WICHITA DRAINAGE CANAL**  
WICHITA, KS

ELECTRICAL DETAILS

PROJECT NO.	472-2023-085864	
SCALE	AS NOTED	
DRAWN	DESIGNED	CHECKED
NAS	SW	SW

NO.	REVISION	DATE

©2025 MKEC ENGINEERING, INC. ALL RIGHTS RESERVED WWW.MKEC.COM. THESE DRAWINGS AND THEIR CONTENTS, INCLUDING, BUT NOT LIMITED TO, ALL CONCEPTS, DESIGNS, & DETAILS ARE THE EXCLUSIVE PROPERTY OF MKEC ENGINEERING, INC. (MKEC), AND MAY NOT BE USED OR REPRODUCED IN ANY WAY WITHOUT THE EXPRESS CONSENT OF MKEC.