


CONSTRUCTION PLANS FOR 24" WATER SUPPLY LINE IN 159TH ST. E.

CITY OF WICHITA PROJECT NO. 448-90296

OCA #635684


TO SERVE

SERENDIPITY ADDITION THE CITY OF WICHITA, KANSAS SEDGWICK COUNTY, KANSAS

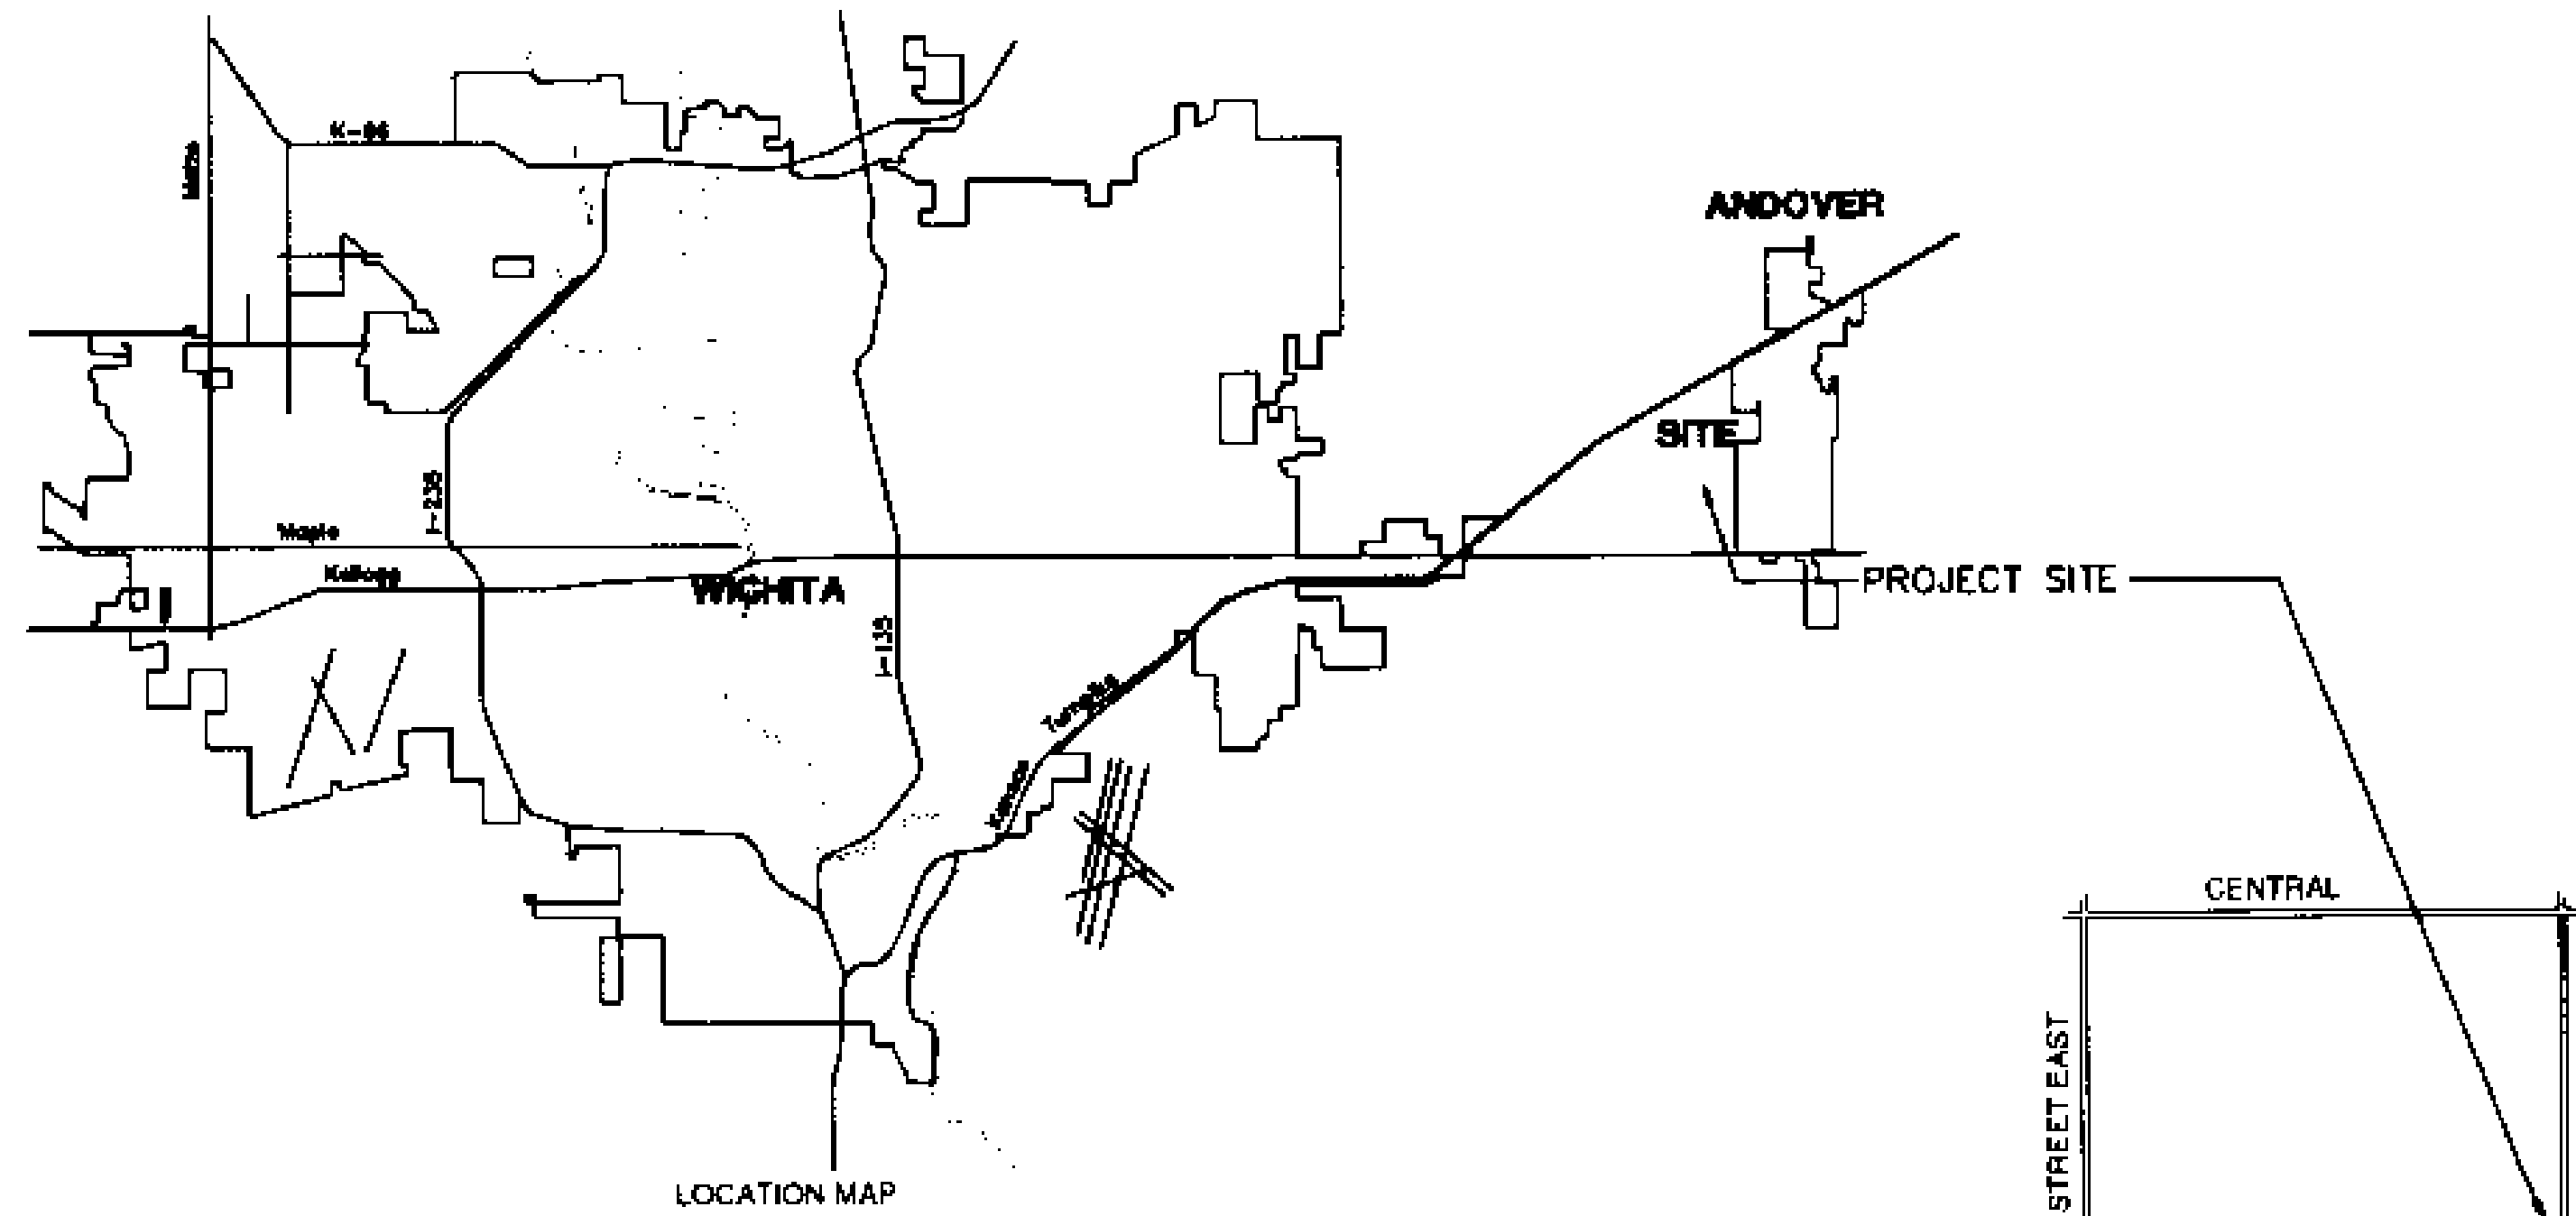

INDEX OF SHEETS

SHEET NO. 1	TITLE SHEET
SHEET NO. 2	KEY MAP
SHEET NO. 3	STANDARD DETAILS
SHEET NO. 4	PLAN PROFILE
SHEET NO. 5-9	EROSION CONTROL DETAILS
SHEET NO. 10-13	TRAFFIC CONTROL DETAILS
SHEET NO. 14	COORDINATE POINTS LIST
SHEET NO. 15	PLAT

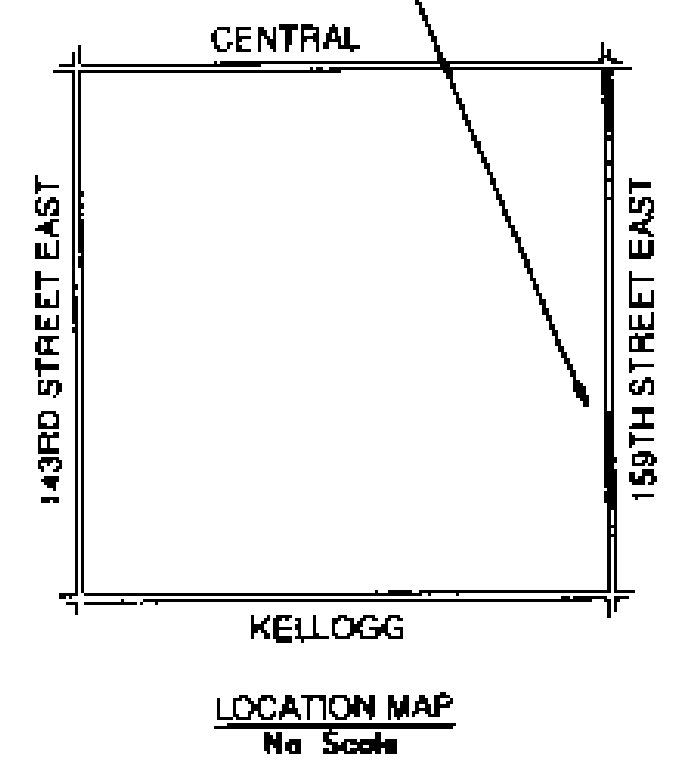

SEPTEMBER 2007

PLANS PREPARED BY

POE & ASSOCIATES, INC.
5949 E. Central, Suite 200 • Wichita, KS 67208-4242
Phone 316-685-4114 • FAX 316-685-4444

James M. Usher

 9-24-07