



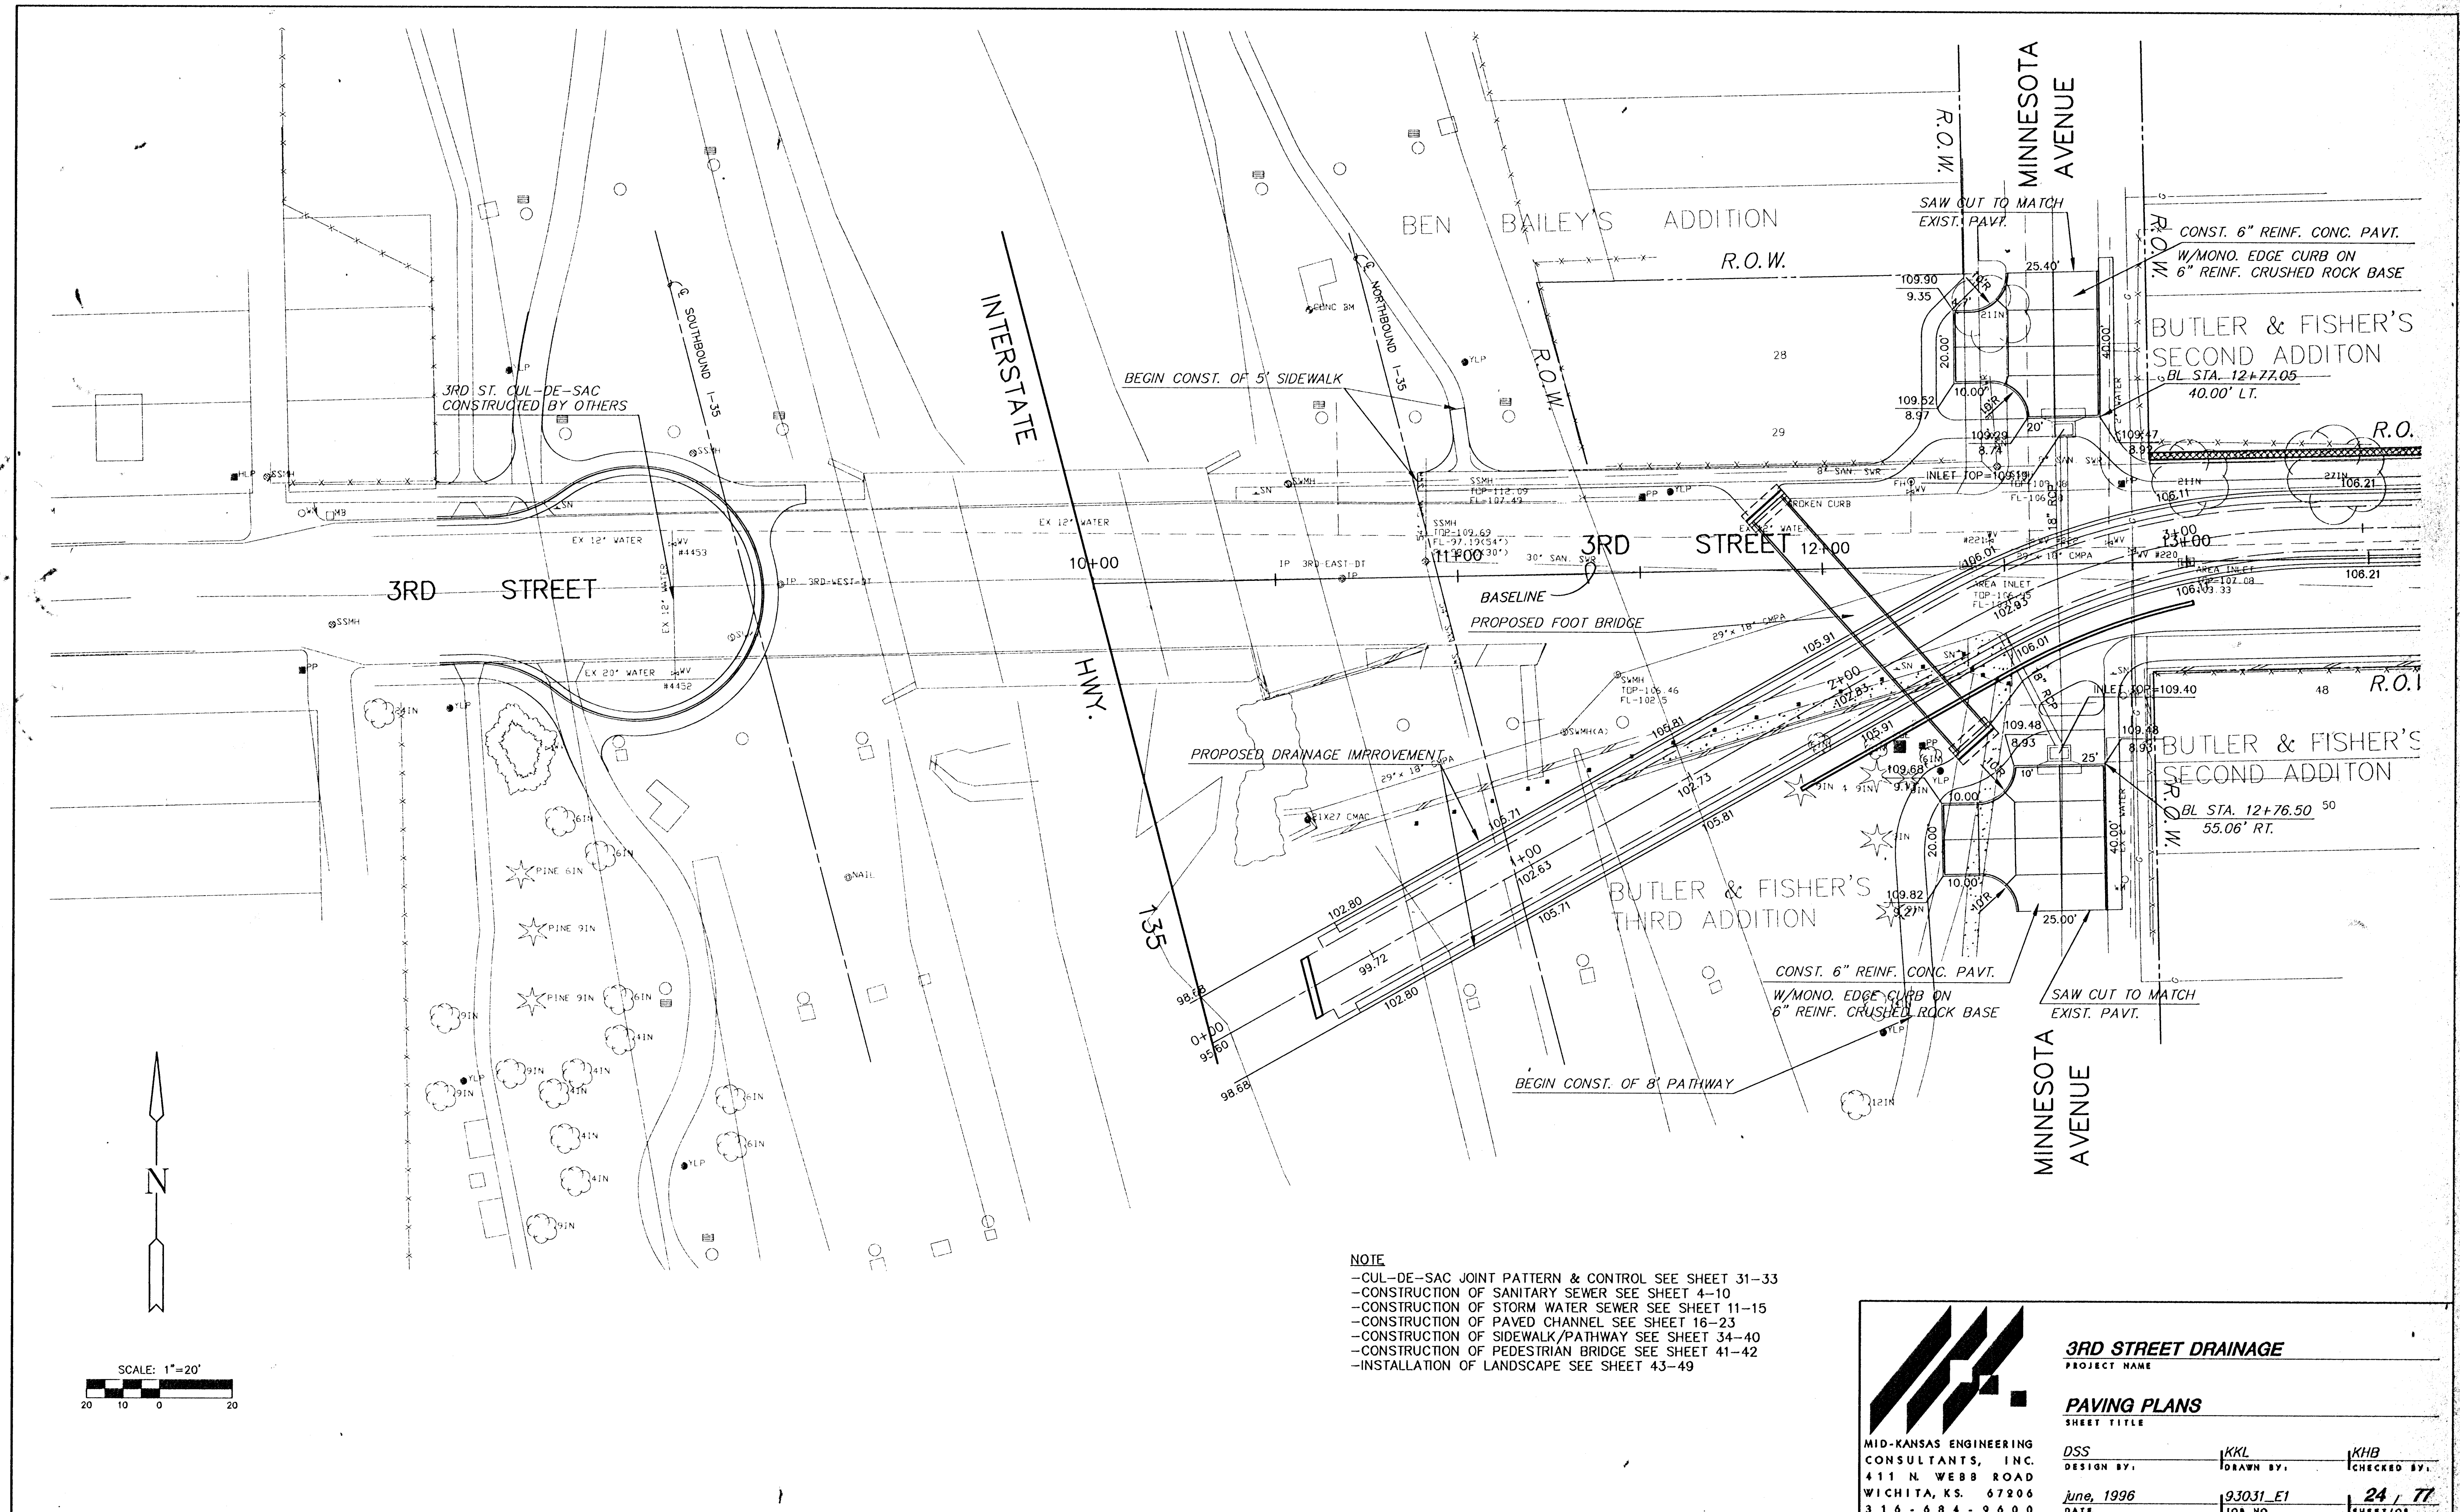

NOTE
-CUL-DE-SAC JOINT PATTERN & CONTROL SEE SHEET 31-33
-CONSTRUCTION OF SANITARY SEWER SEE SHEET 4-10
-CONSTRUCTION OF STORM WATER SEWER SEE SHEET 11-15
-CONSTRUCTION OF PAVED CHANNEL SEE SHEET 16-23
-CONSTRUCTION OF SIDEWALK/PATHWAY SEE SHEET 34-40
-CONSTRUCTION OF PEDESTRIAN BRIDGE SEE SHEET 41-42
-INSTALLATION OF LANDSCAPE SEE SHEET 43-49

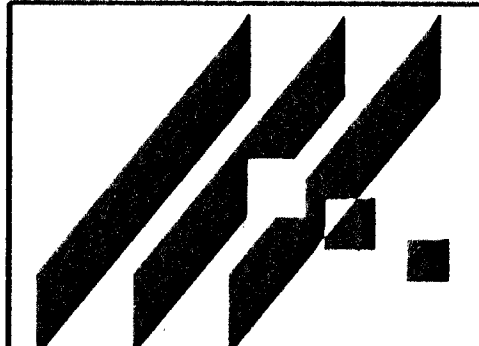

MID-KANSAS ENGINEERING
CONSULTANTS, INC.
411 N. WEBB ROAD
WICHITA, KS. 67206
316-684-9600

3RD STREET DRAINAGE
PROJECT NAME

PAVING PLANS
SHEET TITLE

DSS DESIGN BY.	KKL DRAWN BY.	KHB CHECKED BY.
June, 1996 DATE	93031_E1 JOB NO.	24 / 77 SHEET/OF