
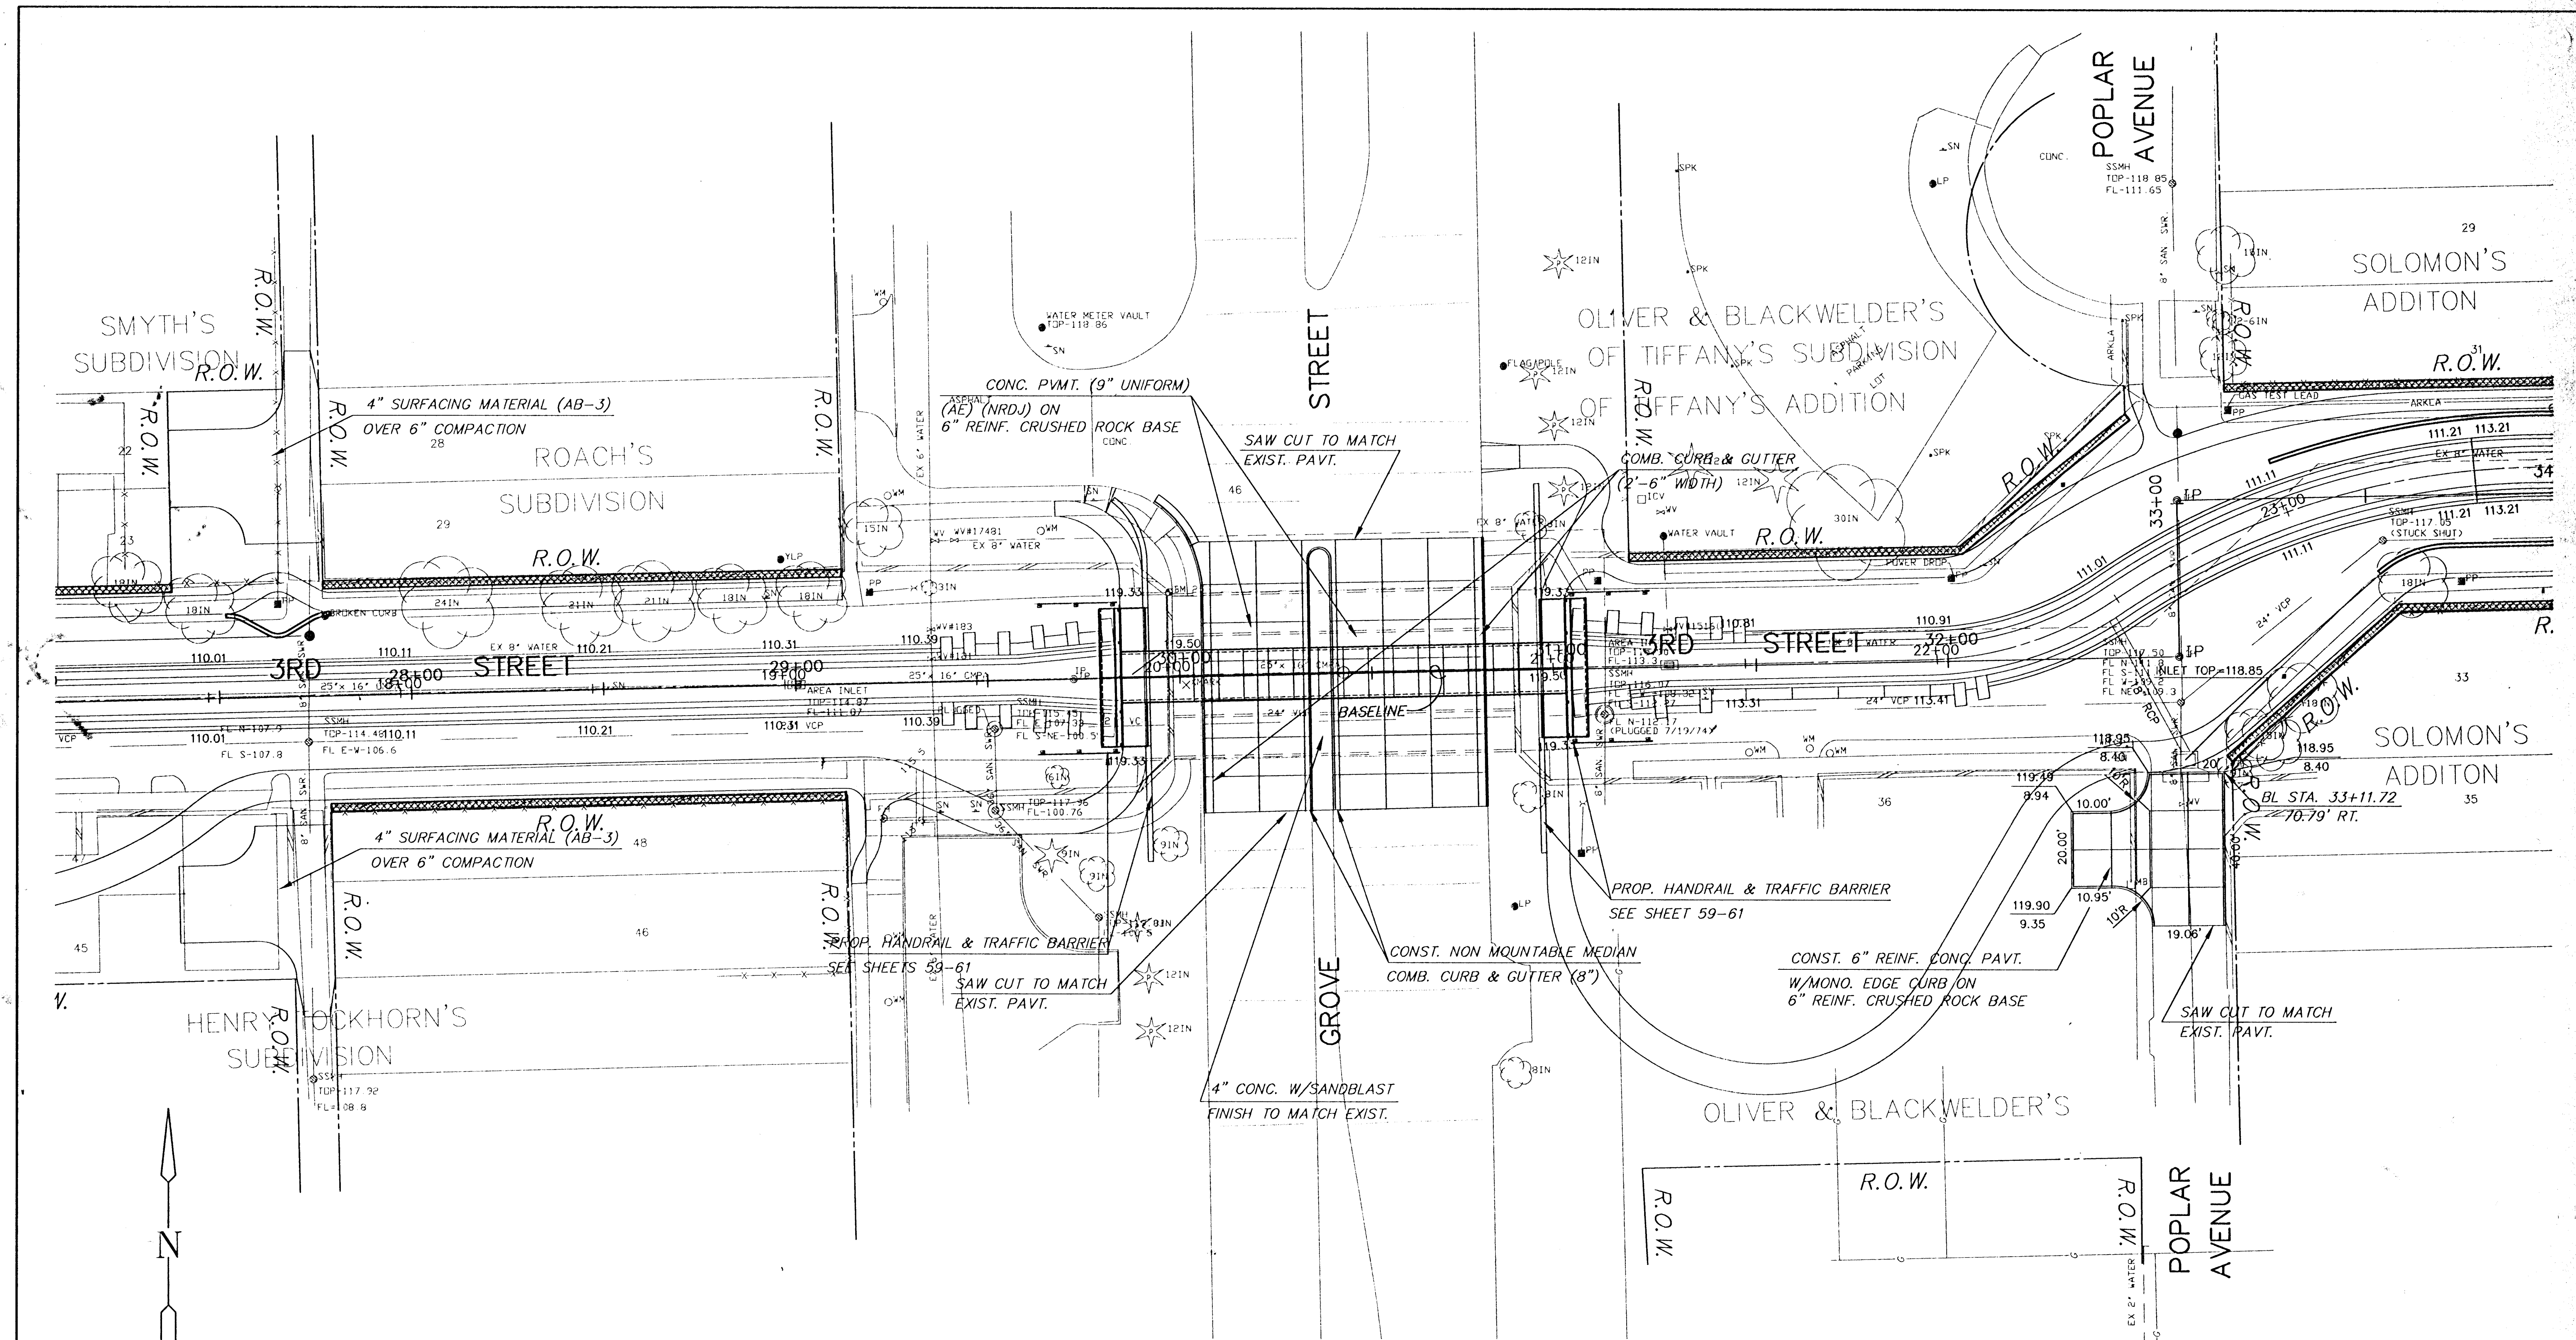


- NOTE
- CUL-DE-SAC JOINT PATTERN & CONTROL SEE SHEET 31-33
 - CONSTRUCTION OF SANITARY SEWER SEE SHEET 4-10
 - CONSTRUCTION OF STORM WATER SEWER SEE SHEET 11-15
 - CONSTRUCTION OF PAVED CHANNEL SEE SHEET 16-23
 - CONSTRUCTION OF SIDEWALK/PATHWAY SEE SHEET 34-40
 - CONSTRUCTION OF PEDESTRIAN BRIDGE SEE SHEET 41-42
 - INSTALLATION OF LANDSCAPE SEE SHEET 43-49

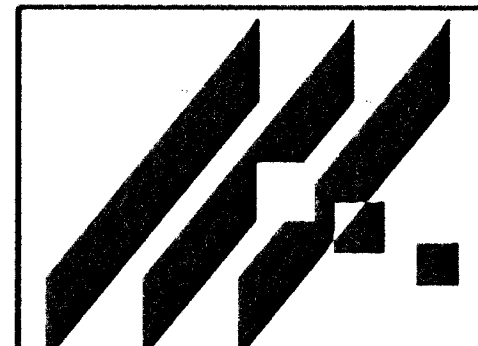

MID-KANSAS ENGINEERING
CONSULTANTS, INC.
411 N. WEBB ROAD
WICHITA, KS. 67206
316-684-9600

3RD STREET DRAINAGE

PROJECT NAME

PAVING PLANS

SHEET TITLE

DSS

DESIGN BY:

KKL

DRAWN BY:

KHB

CHECKED BY:

JUNE, 1996

DATE

93031_E4

JOB NO.

27 / 77

SHEET/OF