


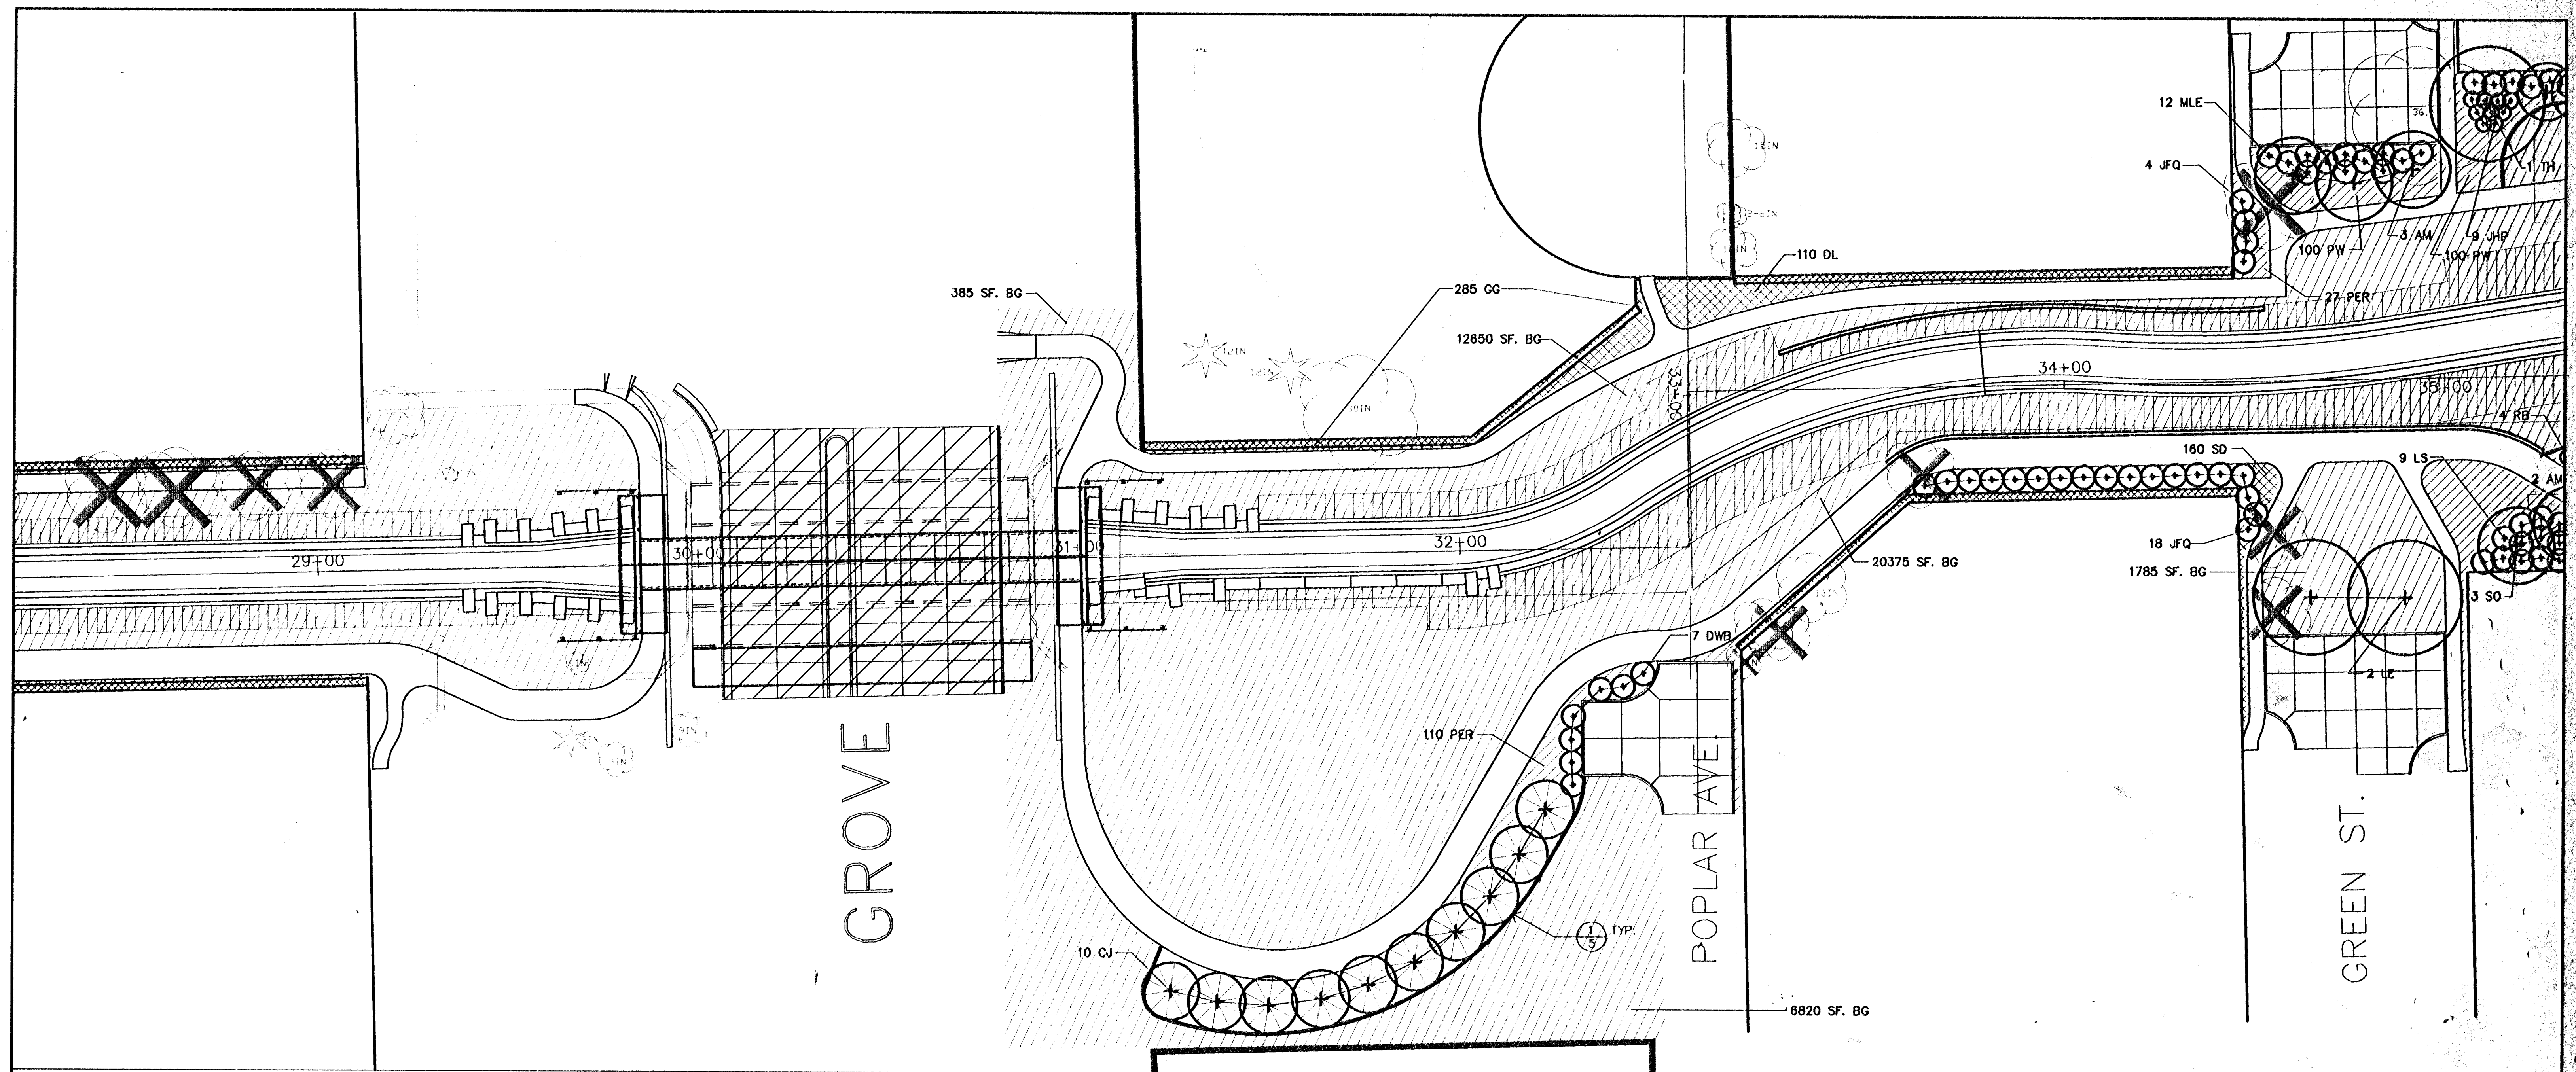

A STATION 28+00.00 TO STATION 35+00.00

0' 10' 20' 1"=20'-0"

N


PLANT LIST FOR THIS SHEET

KEY	QTY.	COMMON NAME	BOTANICAL NAME	SIZE	CONDITION
LARGE DECIDUOUS TREES					
TH	1	THORNLESS HONEYLOCUST	Gleditsia triacanthos 'Shademaster'	2" to 2 1/2" cal.	Balled-in-Burlap
LE	2	LACEBARK ELM	Ulmus parvifolia	2" to 2 1/2" cal.	Balled-in-Burlap
SMALL TO MEDIUM DECIDUOUS TREES					
AM	3	AMUR MAPLE	Acer ginnala 'Flame'	2" to 2 1/2" cal.	Balled-in-Burlap
SO	3	SAWTOOTH OAK	Quercus acutissima	2" to 2 1/2" cal.	Balled-in-Burlap
SMALL TO MEDIUM BROADLEAF EVERGREEN TREES					
CJ	10	CANAERT JUNIPER	Juniperus virginiana 'Canaertii'	2" to 2 1/2" cal.	Balled-in-Burlap
MEDIUM TO LARGE DECIDUOUS SHRUBS					
RB	4	REDLEAF BARBERRY	Berberis thunbergii 'atropurpurea'	5 gal.	Container
JFQ	22	JAPANESE FLOWERING QUINCE	Chaenomeles japonica	5 gal.	Container
DWB	7	DWARF WINGED BURNING BUSH	Euonymus alatus 'compacta'	5 gal.	Container

MLE	12	MEDIUM LEAF EUONYMUS	Euonymus kiautschovicus	5 gal.	Container
LS	9	LILAC	Lilac Syringa	5 gal.	Container
EVERGREEN SHRUBS					
JHP	9	ANDORRA JUNIPER	Juniperus horizontalis 'Plumosa'	2 gal.	Container
GROUNDCOVERS					
PW	200	PURPLELEAF WINTERCREEPER	Euonymus fortunei 'coloratus'	1 gal., 24" O.C.	Container
PER	137	PERIWINKLE	Vinca minor	1 gal., 24" O.C.	Container
PERENNIALS					
GG	285	BLANKET FLOWER	Gaillardia grandiflora	2 1/4" pot, 18" O.C.	Container
DL	110	DAYLILY	Hemerocallis hybrida	1 gal., 24" O.C.	Container
SD	180	SHASTA DAISY	Chrysanthemum superbum	2 1/4" pot, 18" O.C.	Container
GRASS					
BG	42015 SF.	COMMON BERMUDA GRASS	Cynodon dactylon	Seed	Drilled


NOTE

- CONSTRUCTION OF SANITARY SEWER SEE SHEET 4-10
- CONSTRUCTION OF STORM WATER SEWER SEE SHEET 11-15
- CONSTRUCTION OF PAVED CHANNEL SEE SHEET 16-23
- CONSTRUCTION OF PAVED CUL-DE-SACS SEE SHEET 24-33
- CONSTRUCTION OF PEDESTRIAN BRIDGE SEE SHEET 41-42
- CONSTRUCTION OF SIDEWALK/PATHWAY SEE SHEET 34-40

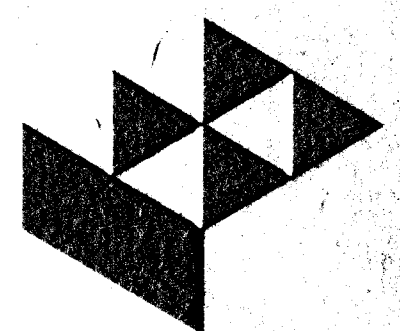

GossinLivingston

Architectural
Site Plans
Landscape
Civil
Mechanical
Electrical
Plumbing
HVAC
Structural
Foundation
Roofing
Interior
Exterior
Furniture
Lighting
Signage
Security
Fire Protection
Energy
Water
Waste
Transportation
Agriculture
Forestry
Mining
Manufacturing
Healthcare
Education
Government
Military
Aerospace
Marine
Aviation
Automotive
Aerospace
Marine
Aviation
Automotive

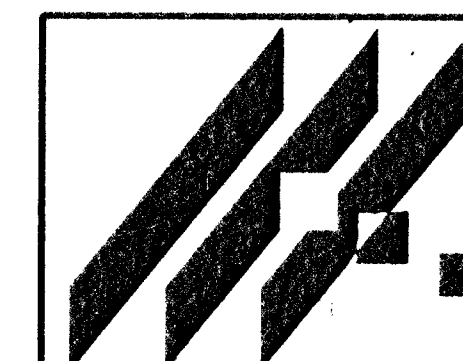

MID-KANSAS ENGINEERING
CONSULTANTS, INC.
411 N WEBB ROAD
WICHITA, KS. 67206
316-684-9600

AREA "K" 3RD. STREET CHANNEL
PROJECT NAME

LANDSCAPE PLAN
SHEET TITLE

TDM, JRS
DESIGN BY: TDM, JRS
DRAWN BY: CHECKED BY:
JUNE 98 19331_B4 48/77
DATE JOB NO. SHEET OF