



ADMINISTRATION PLUMBING FLOOR PLAN  
SCALE 1/8"=1'-0"

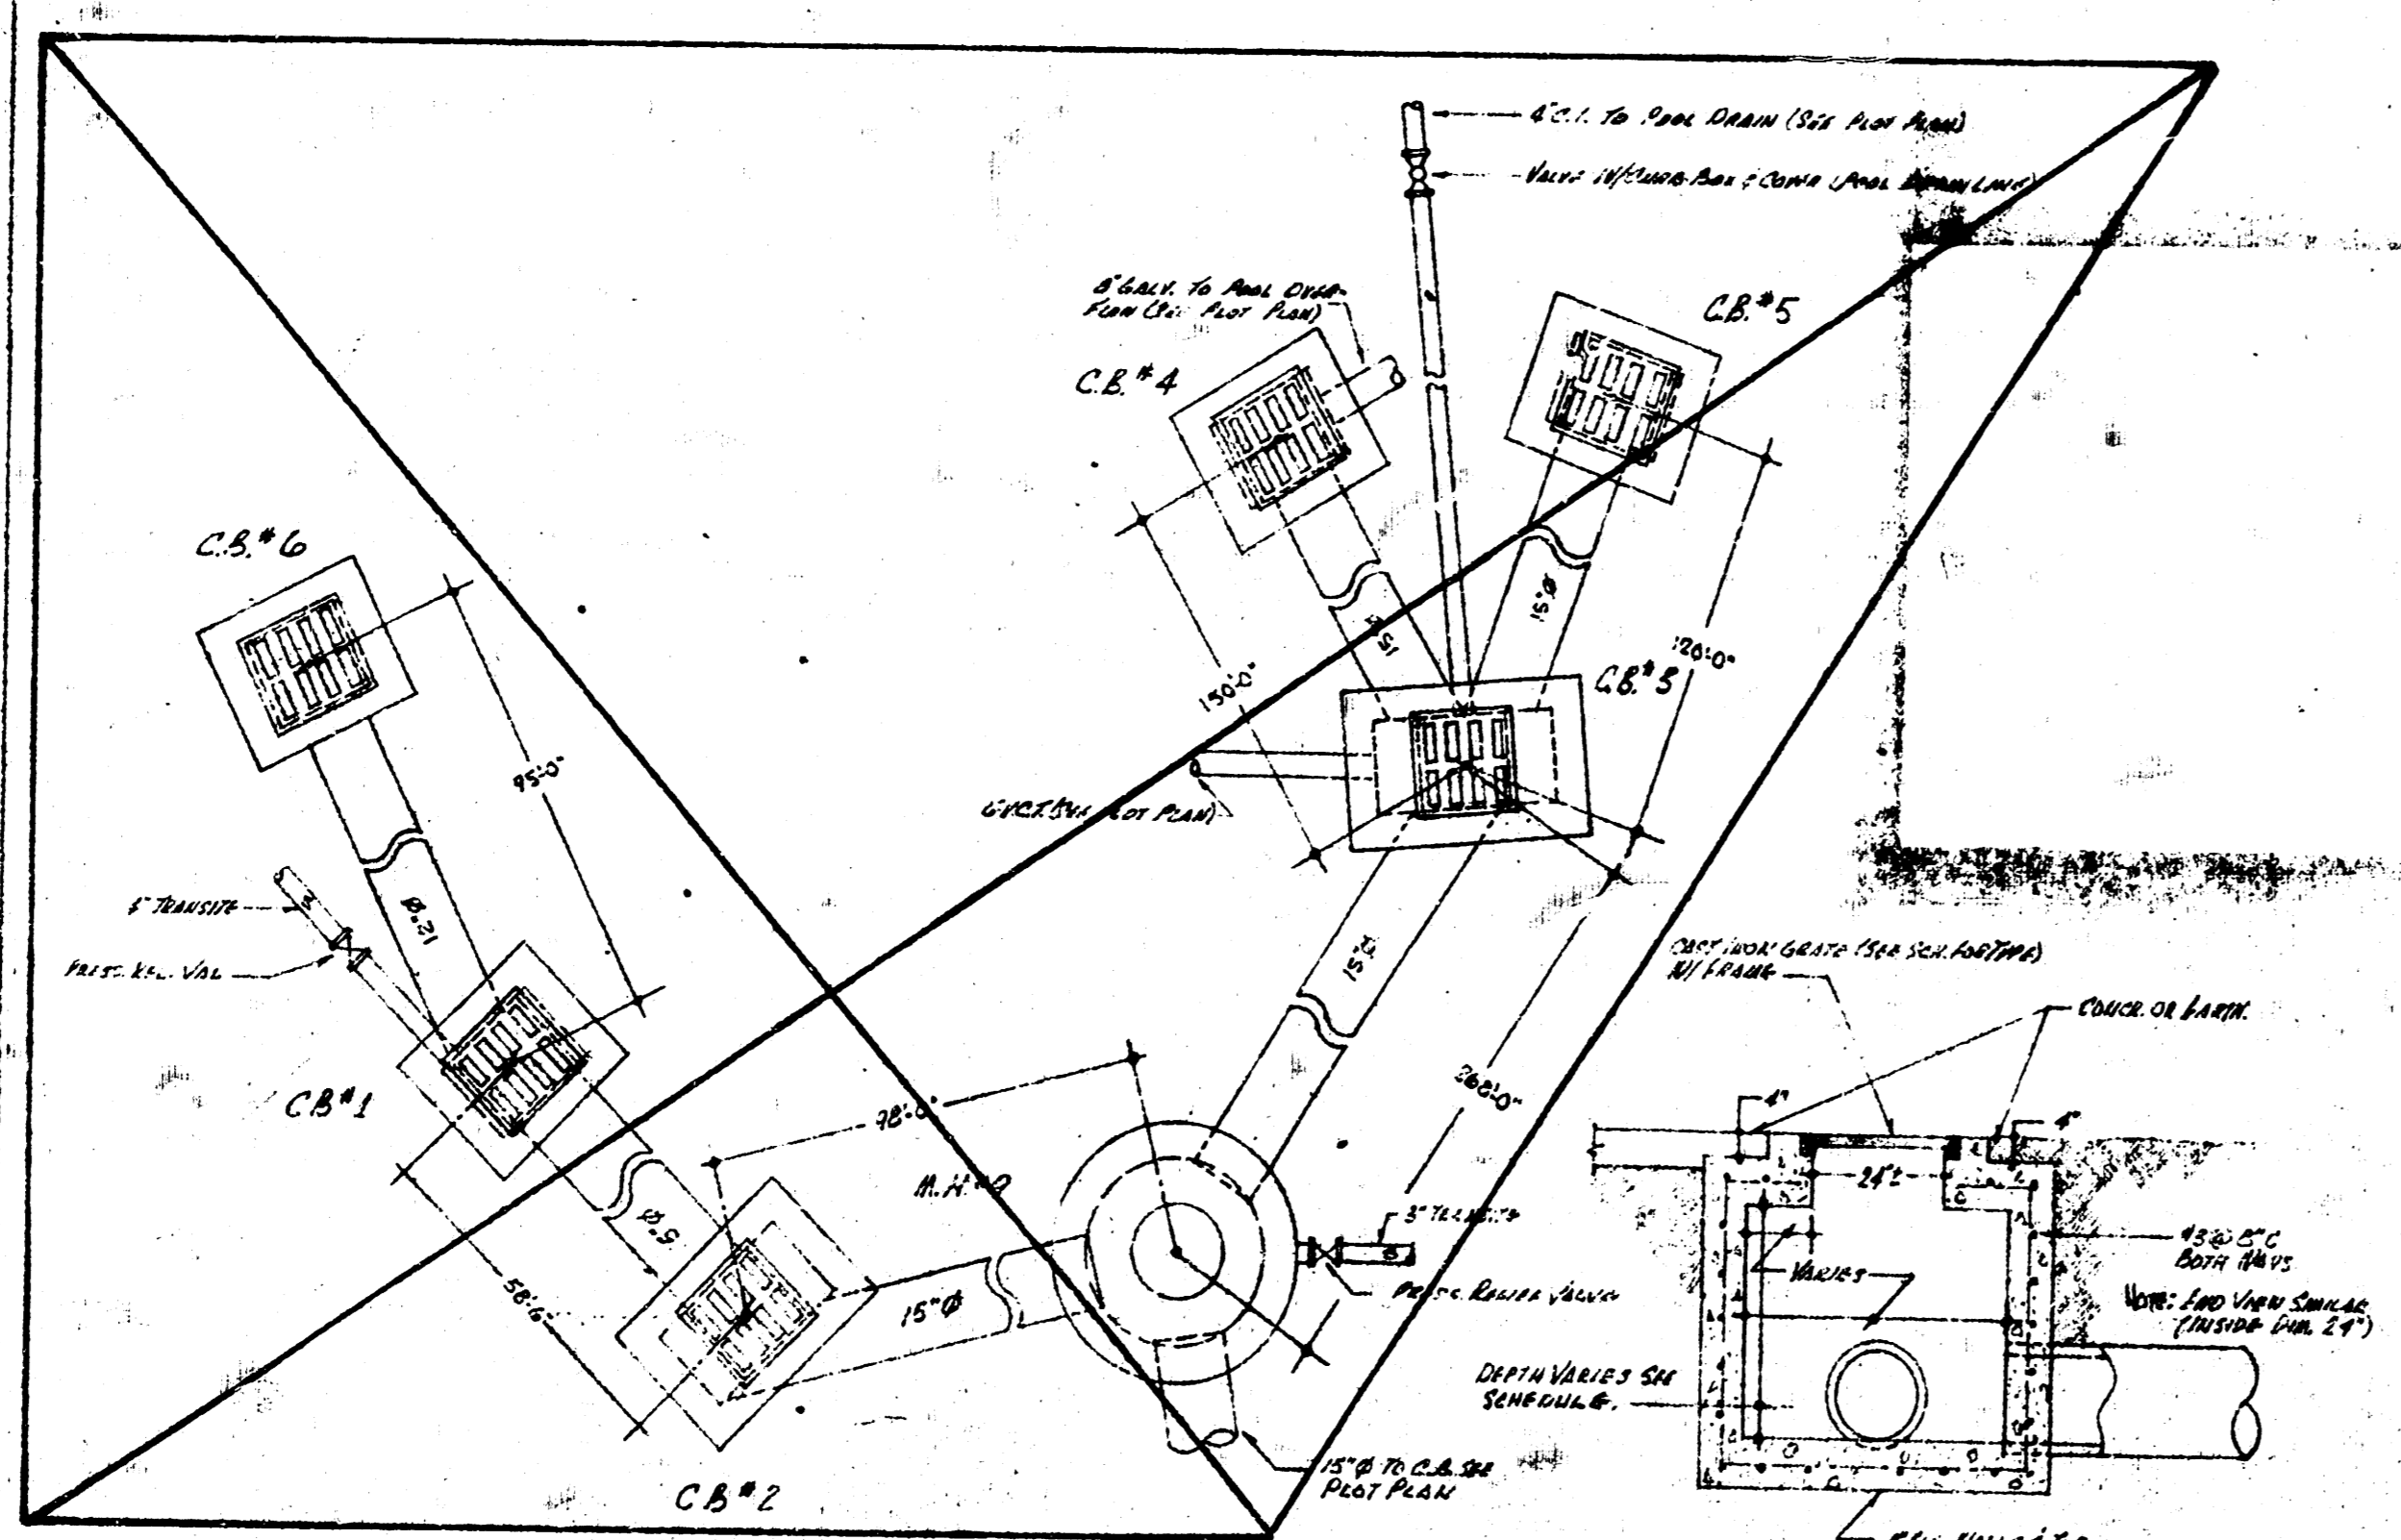


CATCH BASIN PIPING LAYOUT  
SCALE 1/4"=1'-0"


TYPICAL SECTION THRU CATCH BASIN  
SCALE 1/4"=1'-0"

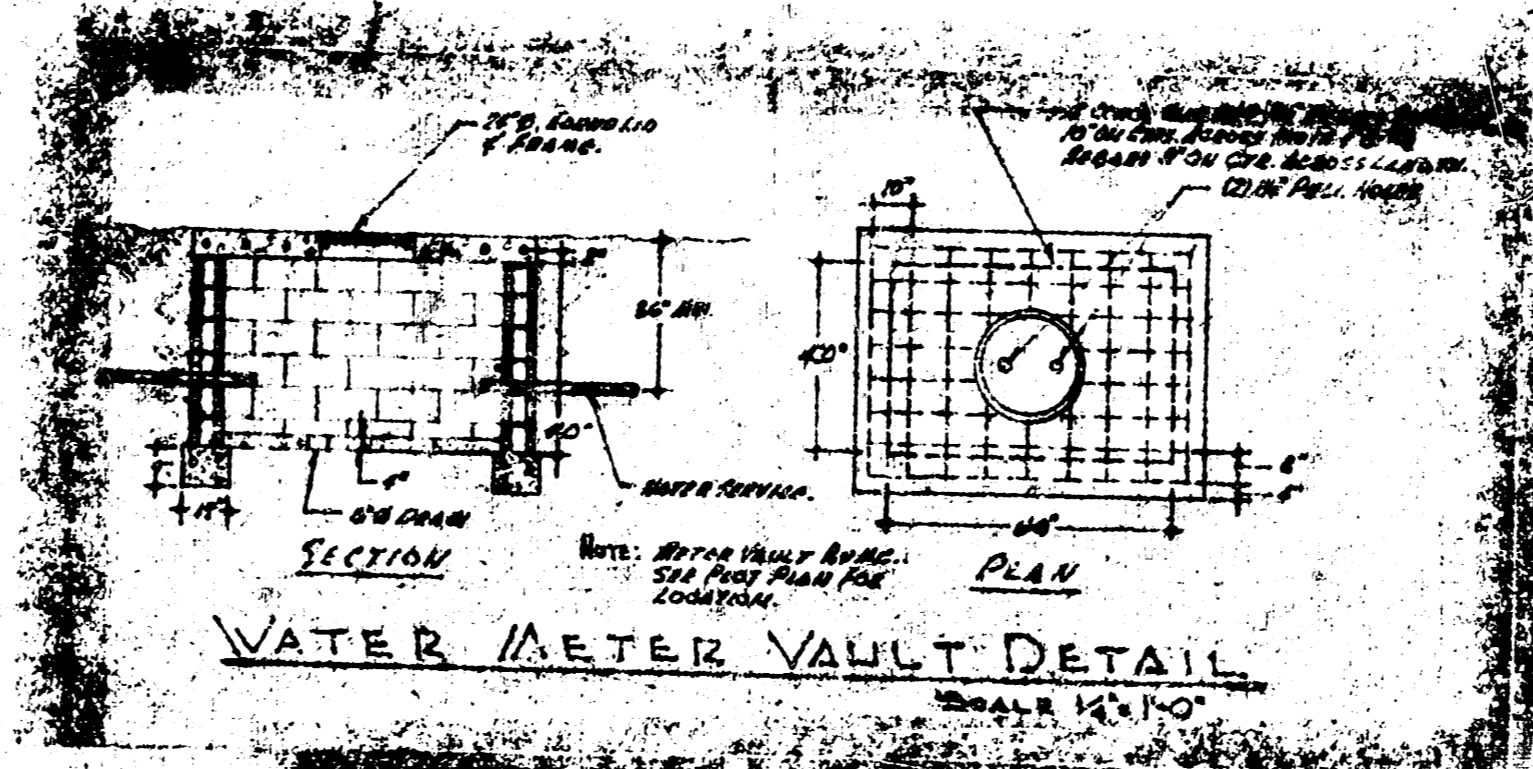

WATER METER VAULT DETAIL  
SCALE 1/4"=1'-0"

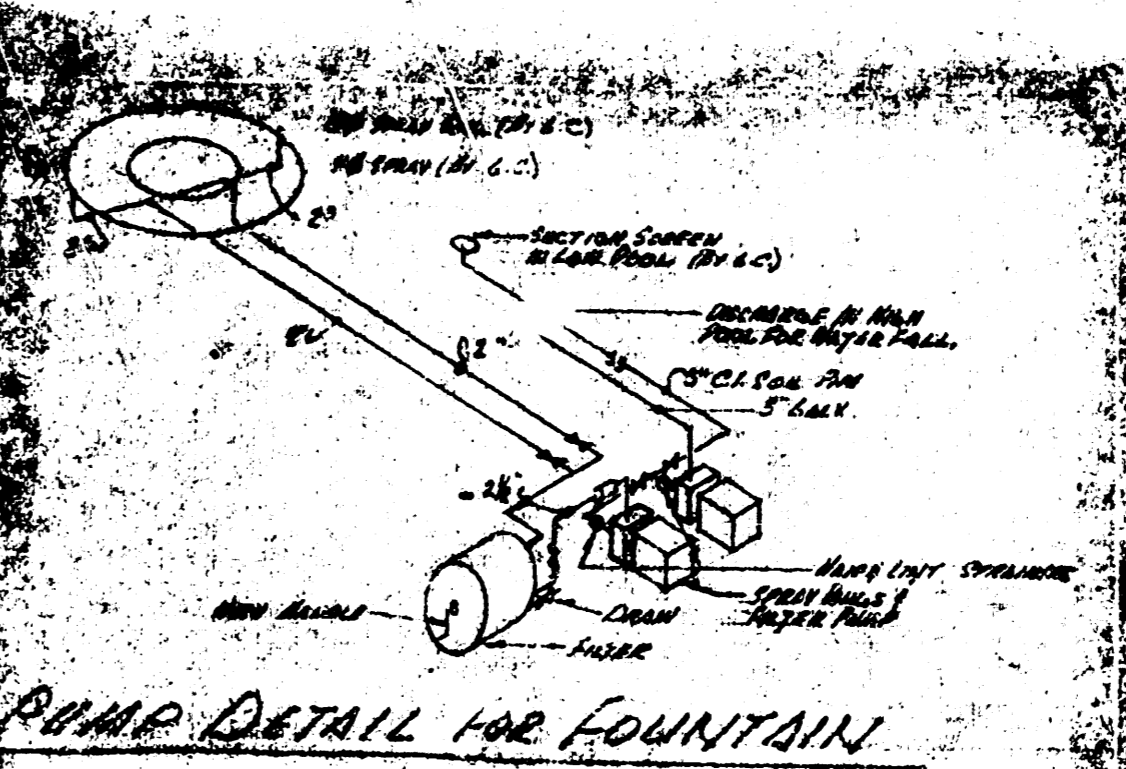

PUMP DETAIL FOR FOUNTAIN  
SCALE 1/4"=1'-0"

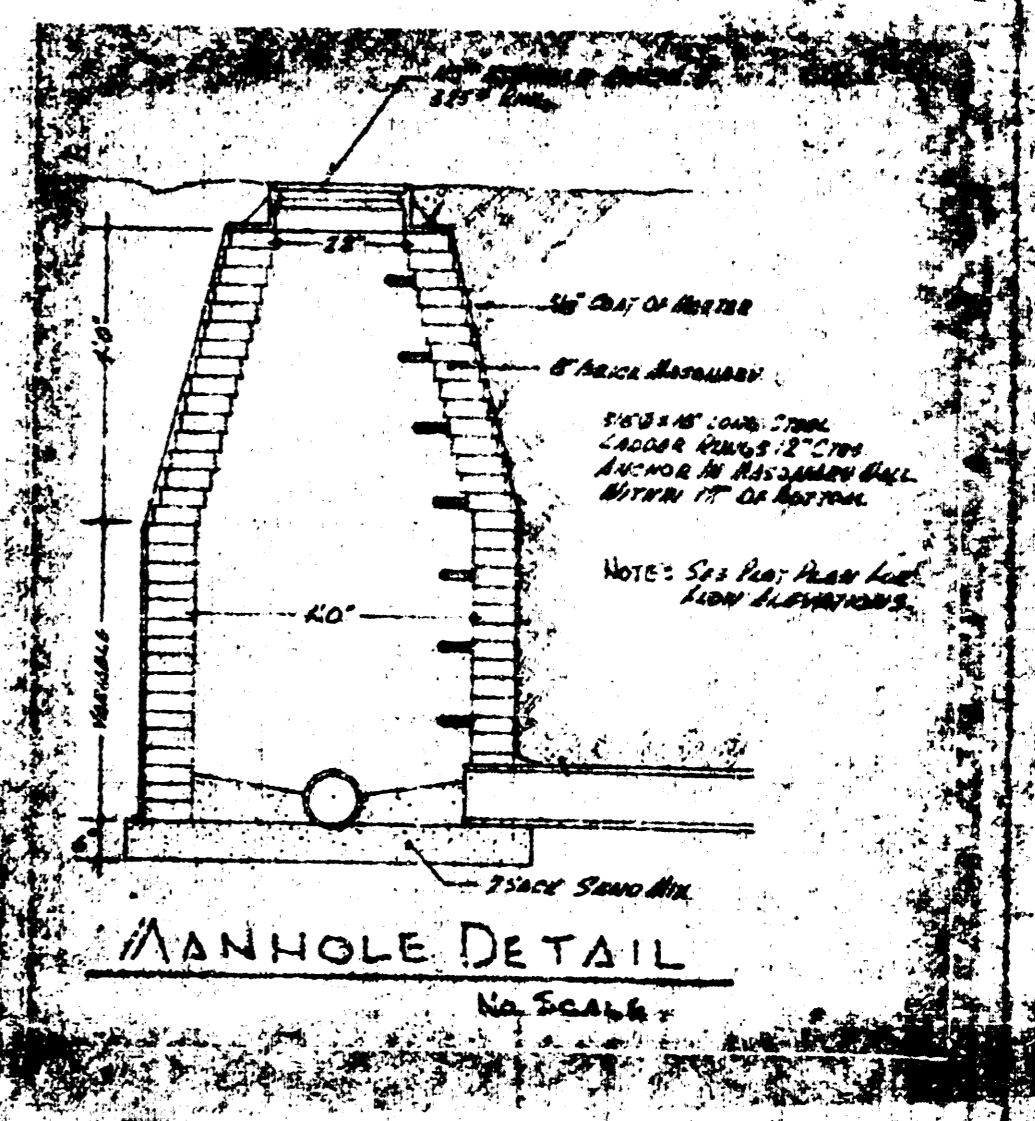

MANHOLE DETAIL  
SCALE 1/4"=1'-0"

HOME FOR ELDERLY - ABE WICHITA, KANSAS

CONTRACTOR: WICHITA, KANSAS  
DATE: 11-9-66  
COMM NO: 6208  
M-4

