
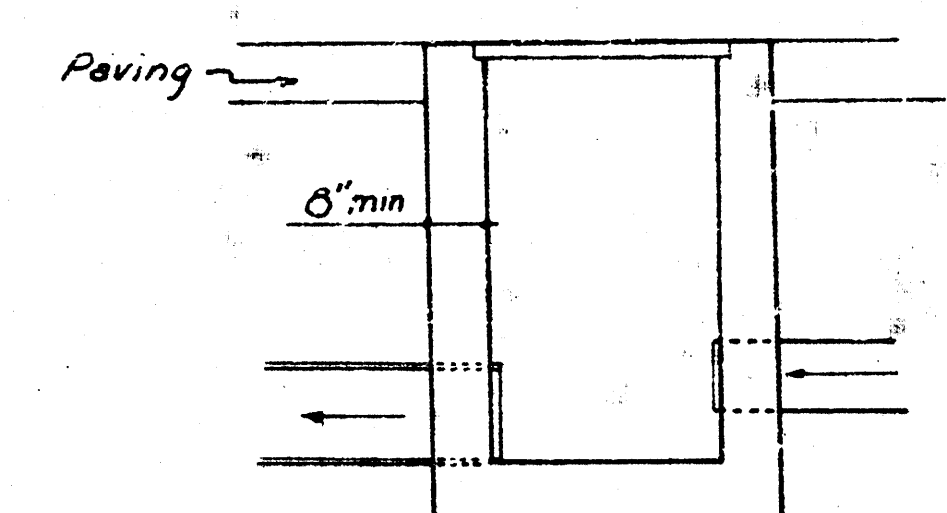


PLAN	DATE
REVISION	
NOTE BOOK	
NO.	


PROFILE	DATE
REVISION	
NOTE BOOK	
NO.	

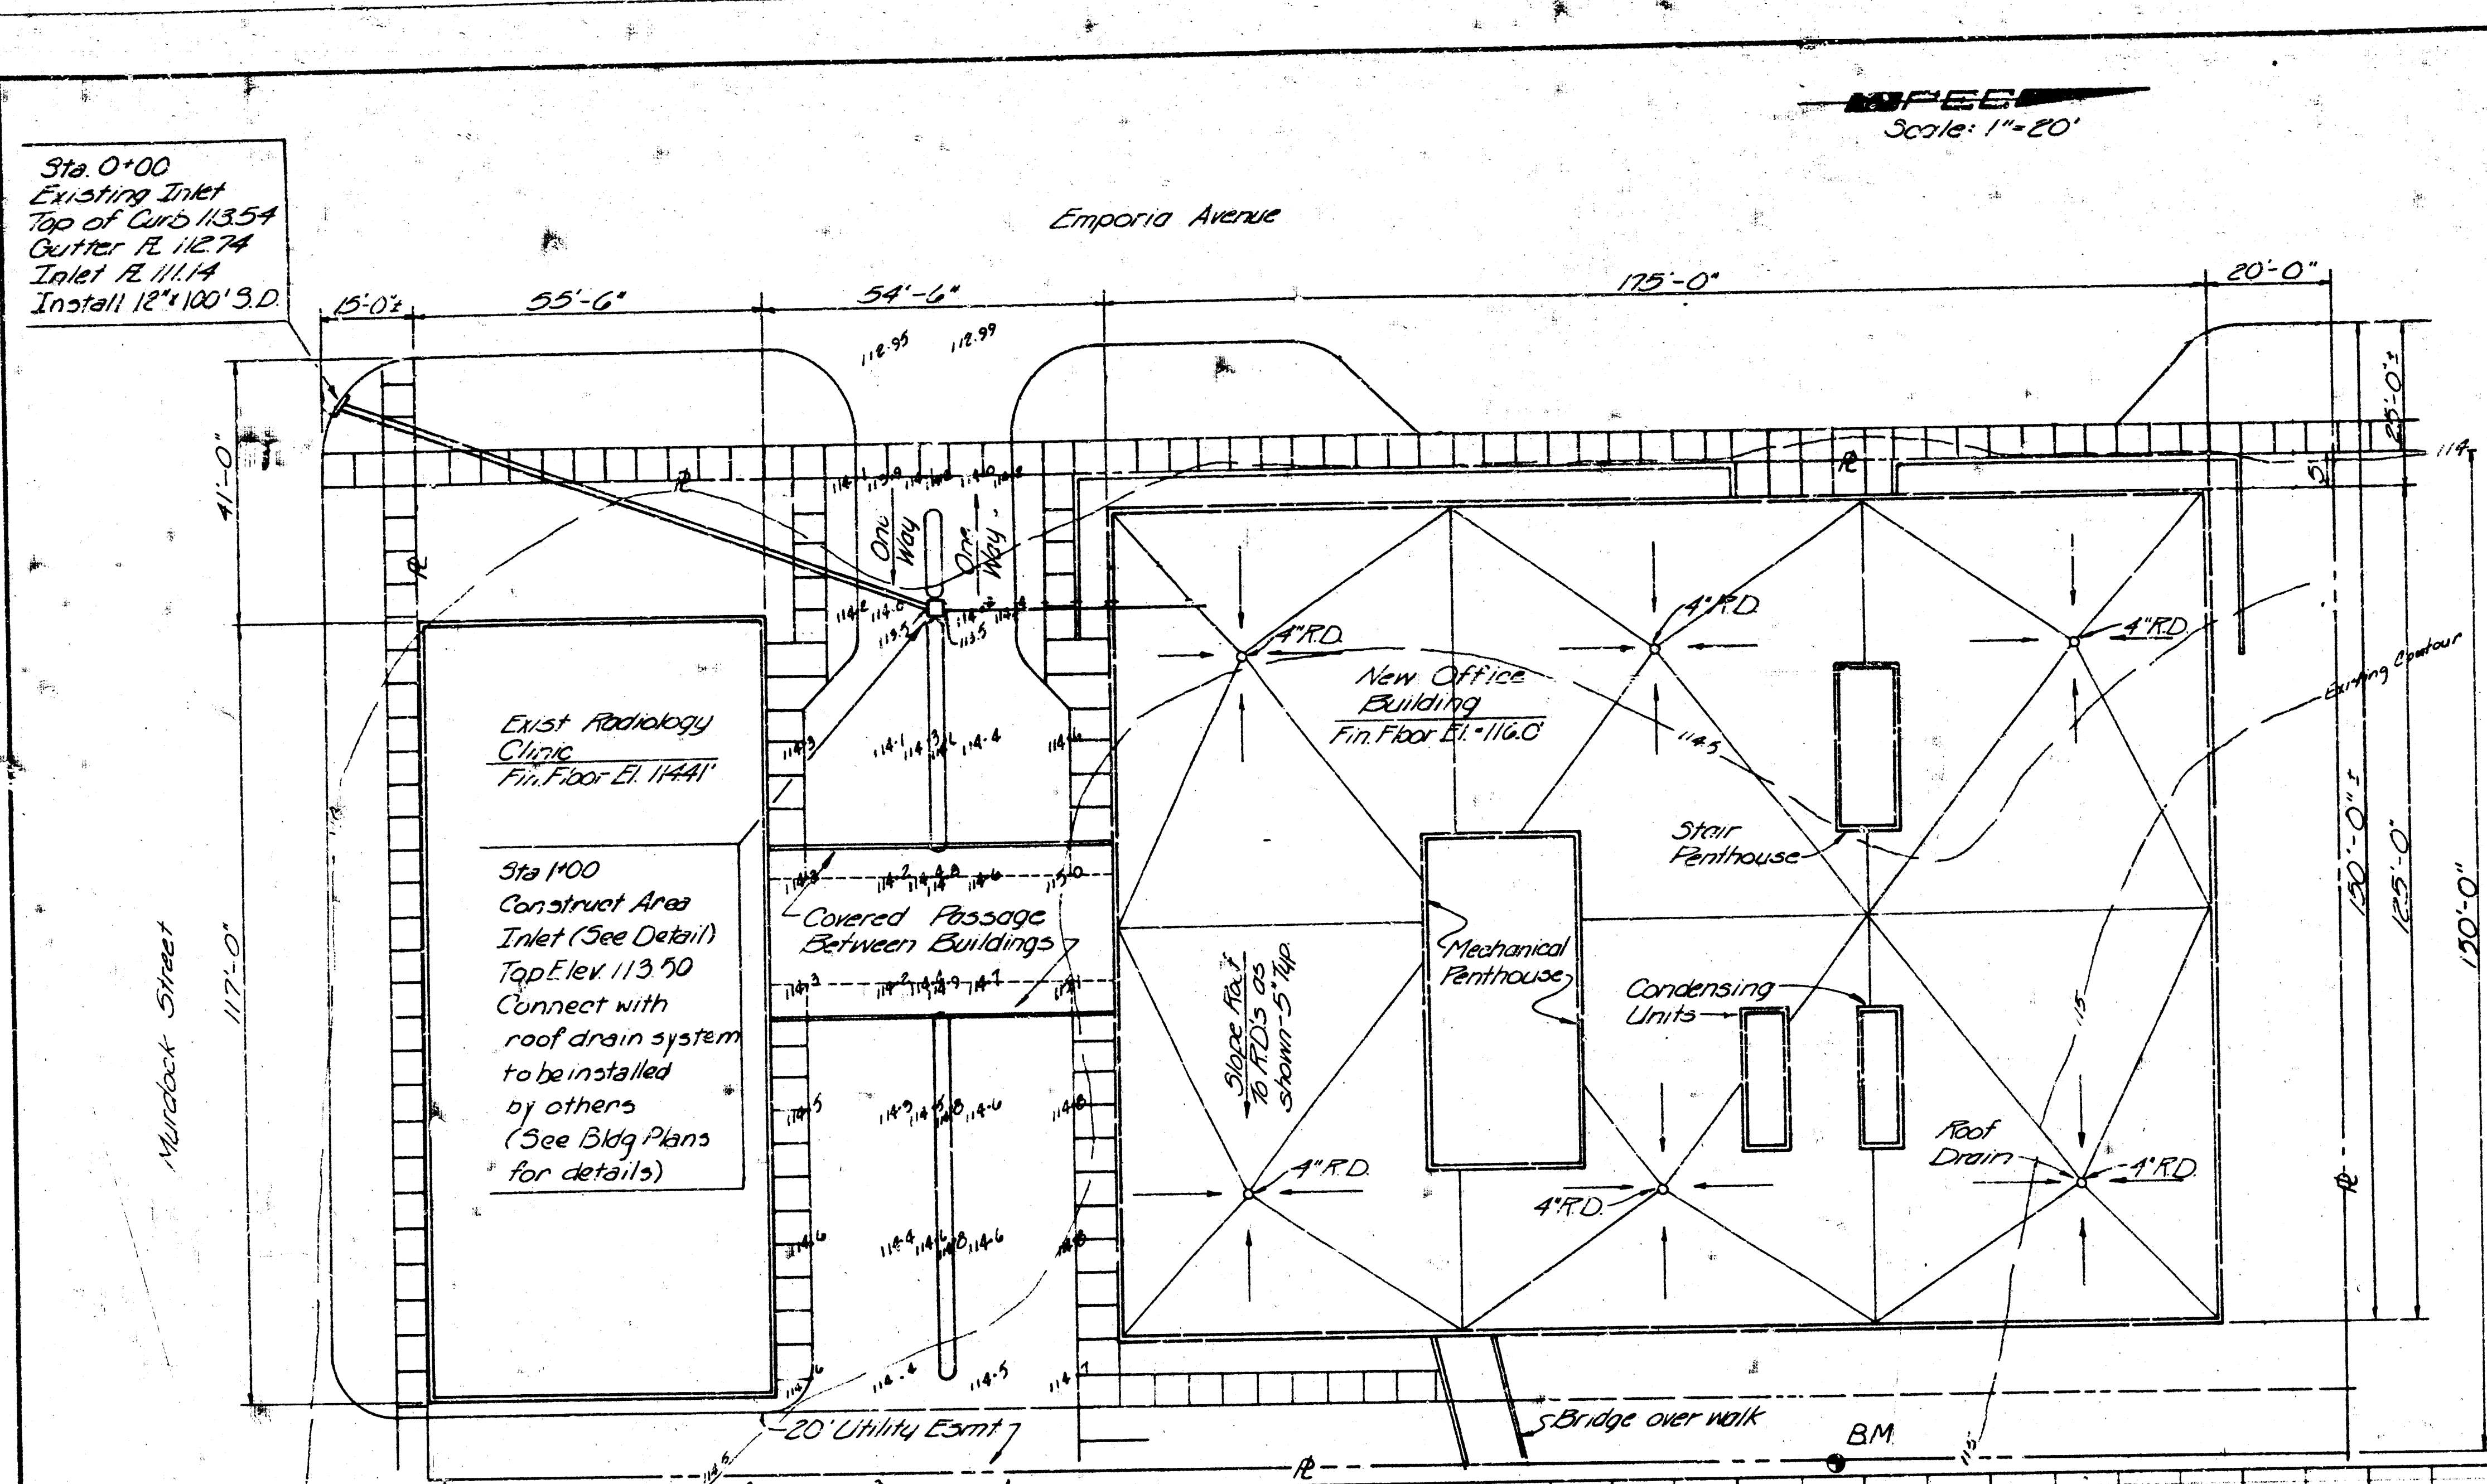

Area Inlet Detail
City of Wichita Std. 2x2 Inlet

NOTE: SEE ATTACHED FIRST FLOOR PLUMBING PLAN FOR DETAILS OF ROOF DRAIN SYSTEM AND CONNECTION TO STORM SEWER SYSTEM

B.M. San Sewer Manhole 82' 3 of NE Property Corner
Top Ring Elev. - 114.08

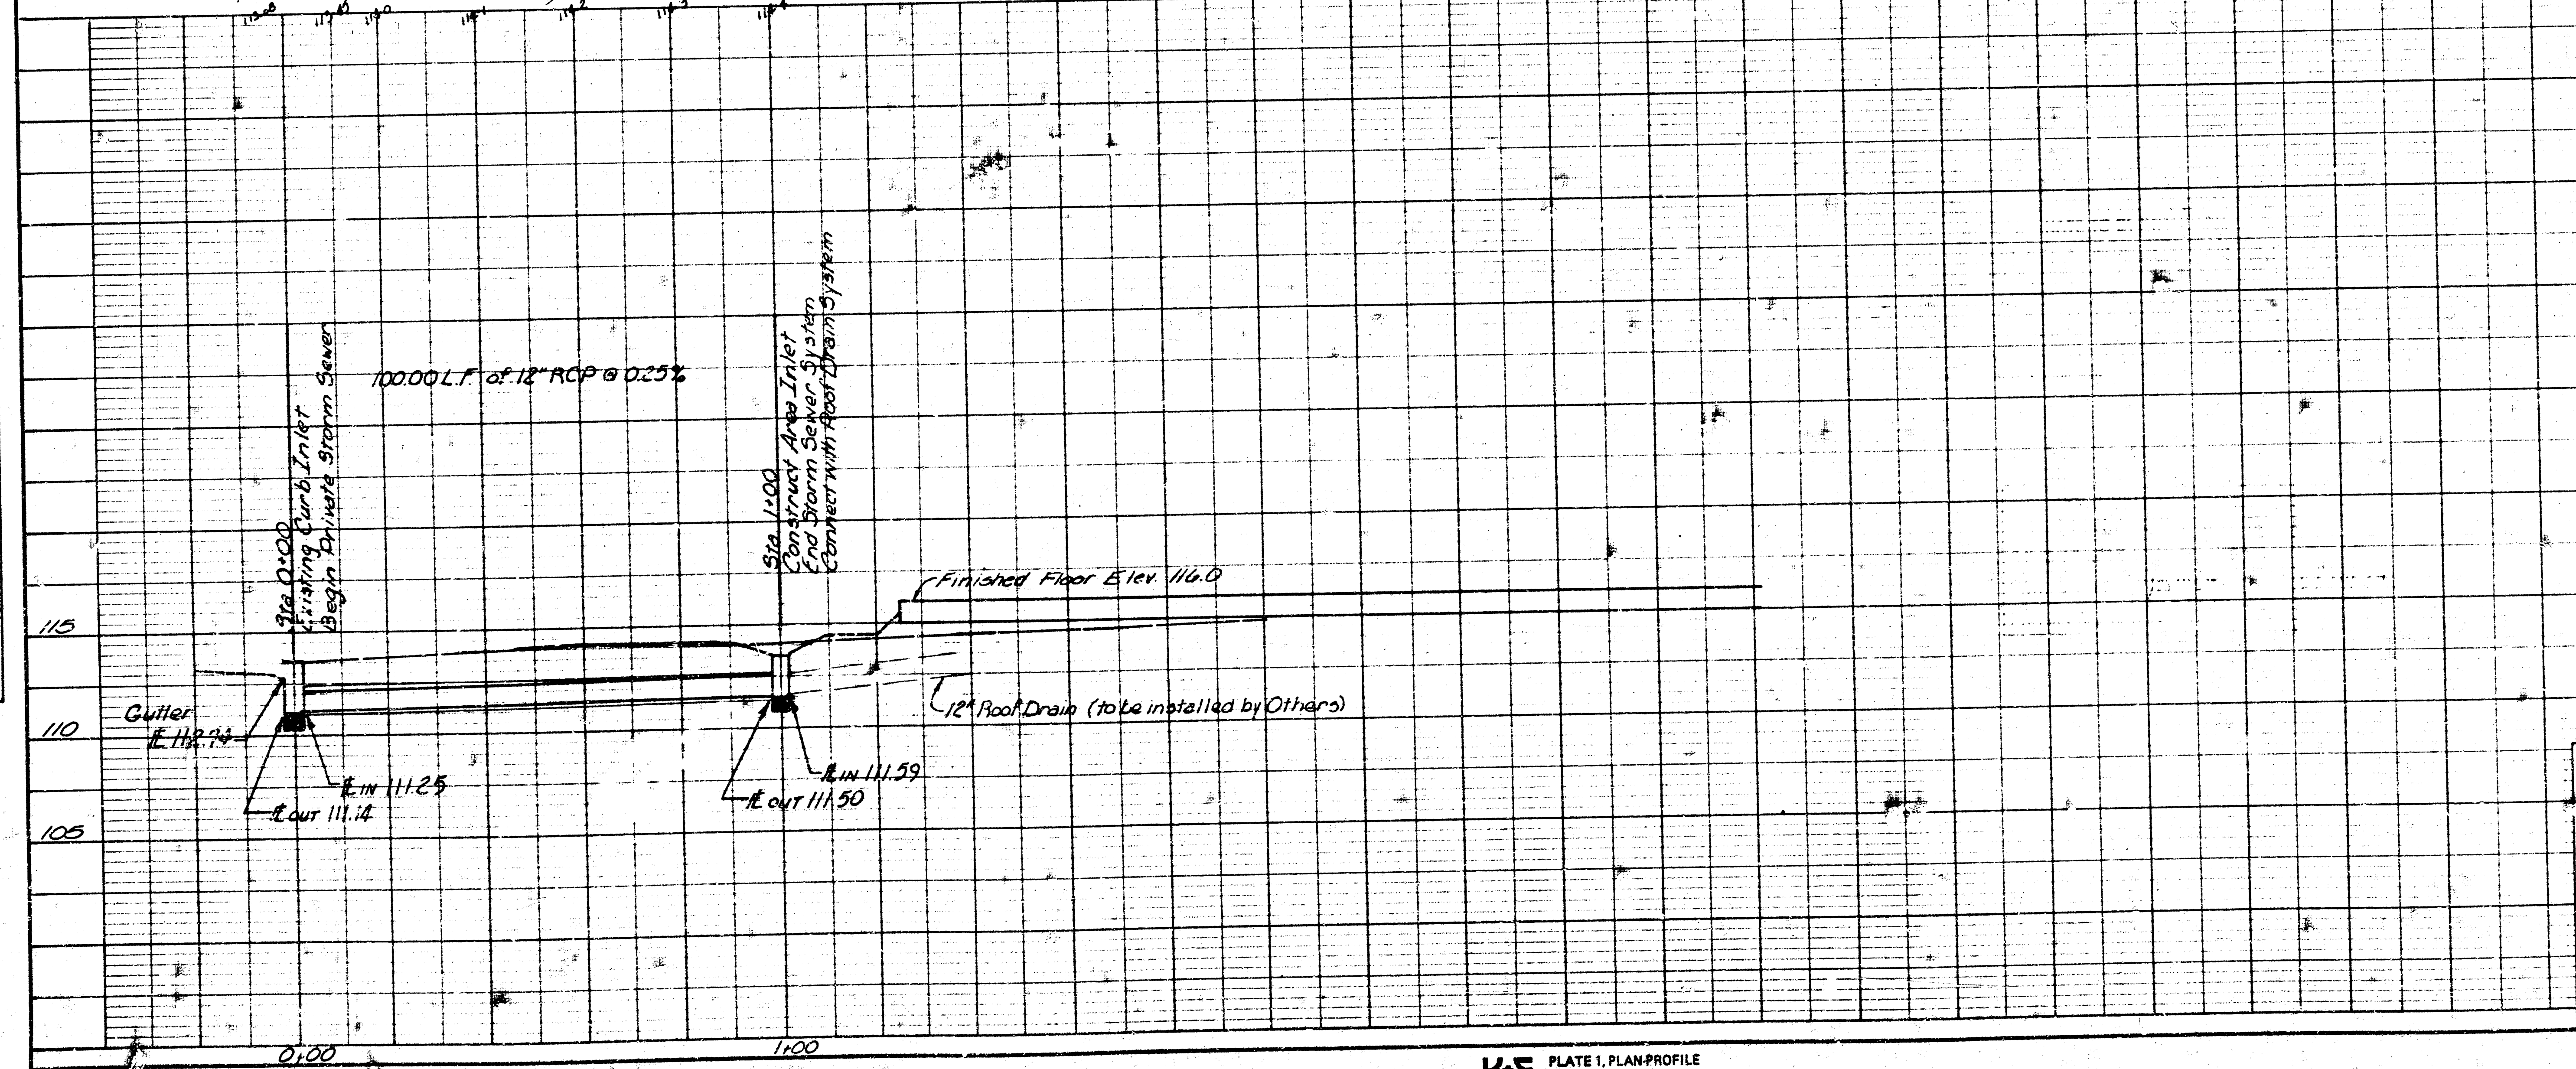

2	Added Note re: Plumbing Plan	By	CMB	Date	6/20/79
1	Added Inlet Detail of B.M.	By	CMB	Date	6/12/79
No.	Revision	By		Date	
CITY OF WICHITA PRIVATE STORM SEWER NO. 468-245-80775-000-000-008					
EAGLE CENTER STORM SEWER WICHITA, KANSAS					
PROFESSIONAL ENGINEERING CONSULTANTS, P.A.					
ENGINEERS WICHITA, KANSAS					
Designed by	CMB	Job No.	79123-220	Sht.	1 of 1
Drawn by	BS	Date	6/20/79		



[illegible]

4 4 1 9 3 0 0 1 1 7 2 9 1 4

PROFESSIONAL ENGINEERING CONSULTANTS
Westville, Kansas 66204

ТОТНОВА СЪМНА ДИВЪД

15 JUL 51 0120Z