


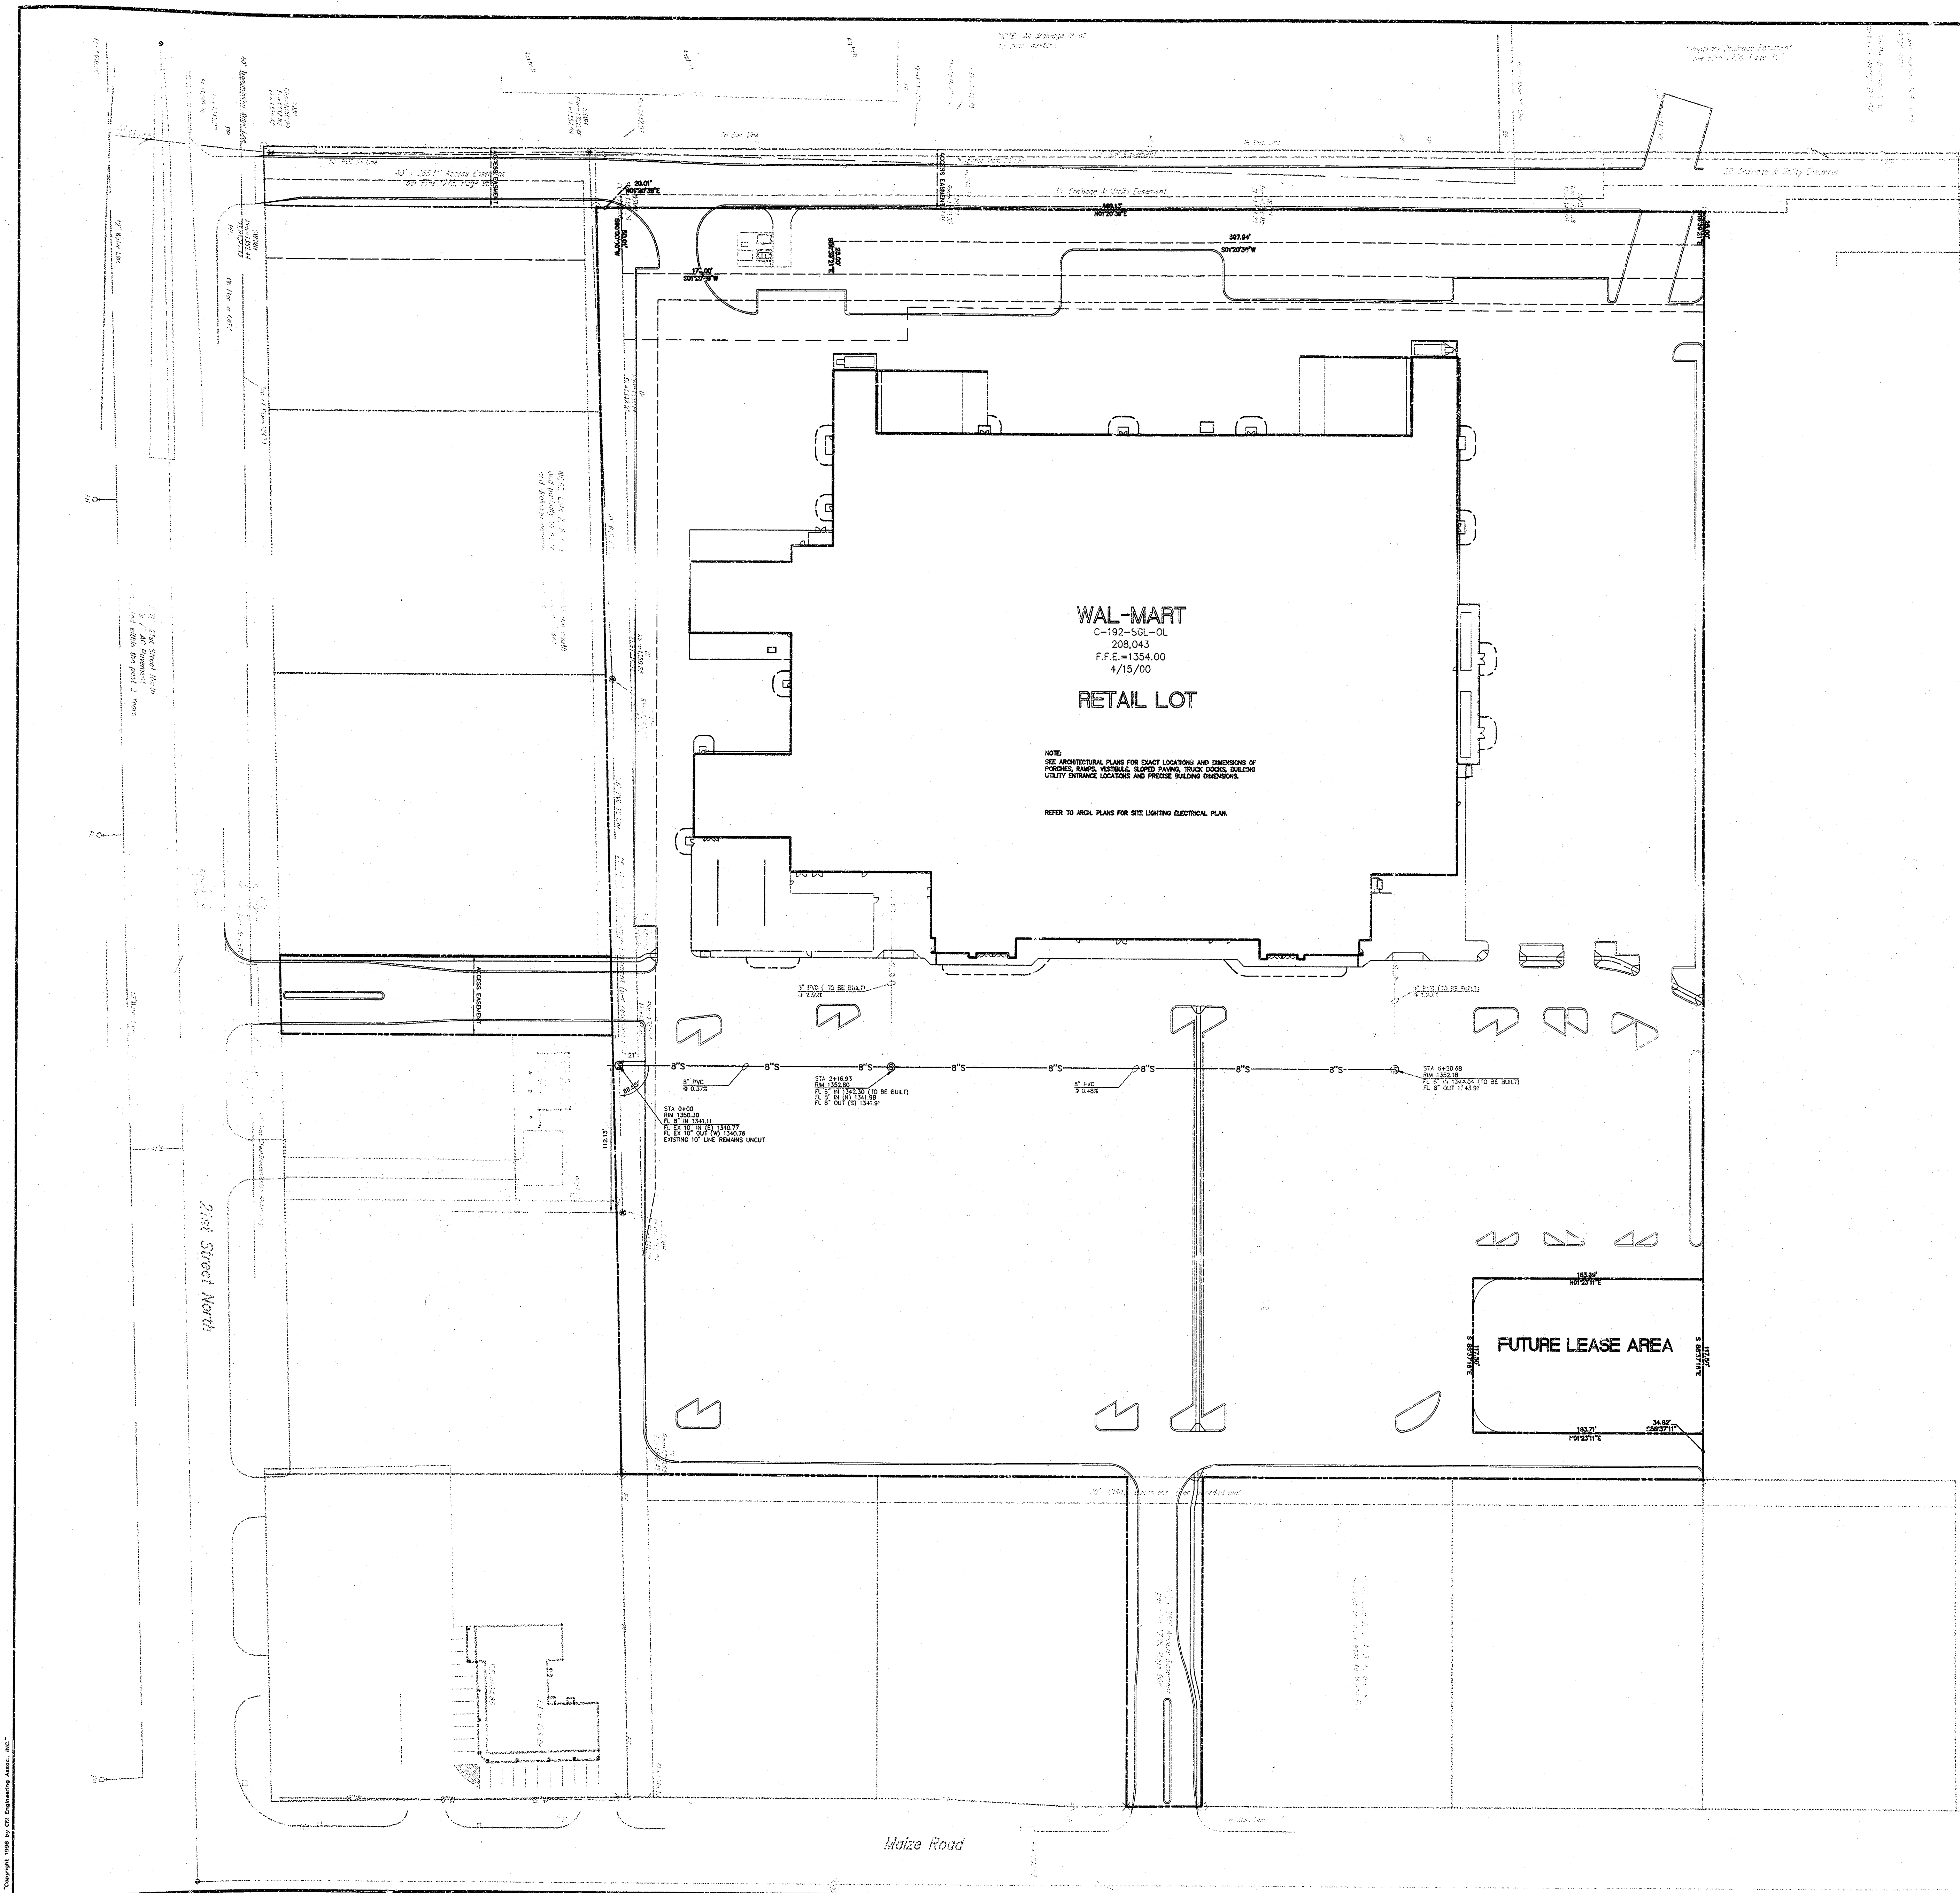

SCALE IN FEET  
0 25' 50' 100'

**LEGEND**

EXISTING

- 1. 1" = 1' SCALE
- 2. 1" = 1' SCALE
- 3. 1" = 1' SCALE
- 100. 1" = 1' SCALE

**WAL-MART**  
C-102-SQL-OL  
208,043  
F.F.E. = 1354.00  
4/15/00

**RETAIL LOT**

NOTE:  
SEE ARCHITECTURAL PLANS FOR EXACT LOCATION AND DIMENSIONS OF  
FORCED MAINS, VENTILATION, SLOPED MAINS, TRUCK DOCKS, BUILDING  
UTILITY ENTRANCE LOCATIONS AND PRECISE BUILDING DIMENSIONS.

REFER TO AREA PLANS FOR SITE LIGHTING ELECTRICAL PLAN.

**FUTURE LEASE AREA**

Lot 1, Blk 1 Newmarket Square  
1085 PPS

Booked  
P-165  
2-14-01  
KPL

AS-BUILT SEWER LINE INFORMATION PROVIDED BY:  
GARDNER SURVEYING SERVICE, P.A.

CITY OF WICHITA, KANSAS  
PRIVATE PROJECT 1085 PPS(607861)

| INITIAL DESIGN                   | DATE    | PRN | PM  | ENG | DES |
|----------------------------------|---------|-----|-----|-----|-----|
| WAL-MART<br>SUPERCENTER #3283-00 | 3-13-00 | WCM | WCM | HOV | HOV |

**CEI ENGINEERING ASSOCIATES, INC.**  
PLANNERS  
SURVEYORS

110 W. Central Ave.  
Bentonville, AR 72712  
(501) 273-0472 FAX (501) 273-0814 JPB NO: 15242.0  
DWS NAME: 5243PRCJ

**AS-BUILT SEWER LINE**  
21ST STREET & MAIZE ROAD  
WICHITA, KANSAS

DATE: 01-29-00  
TIME: 2:58 PM  
SHEET NO: 1 OF 1