


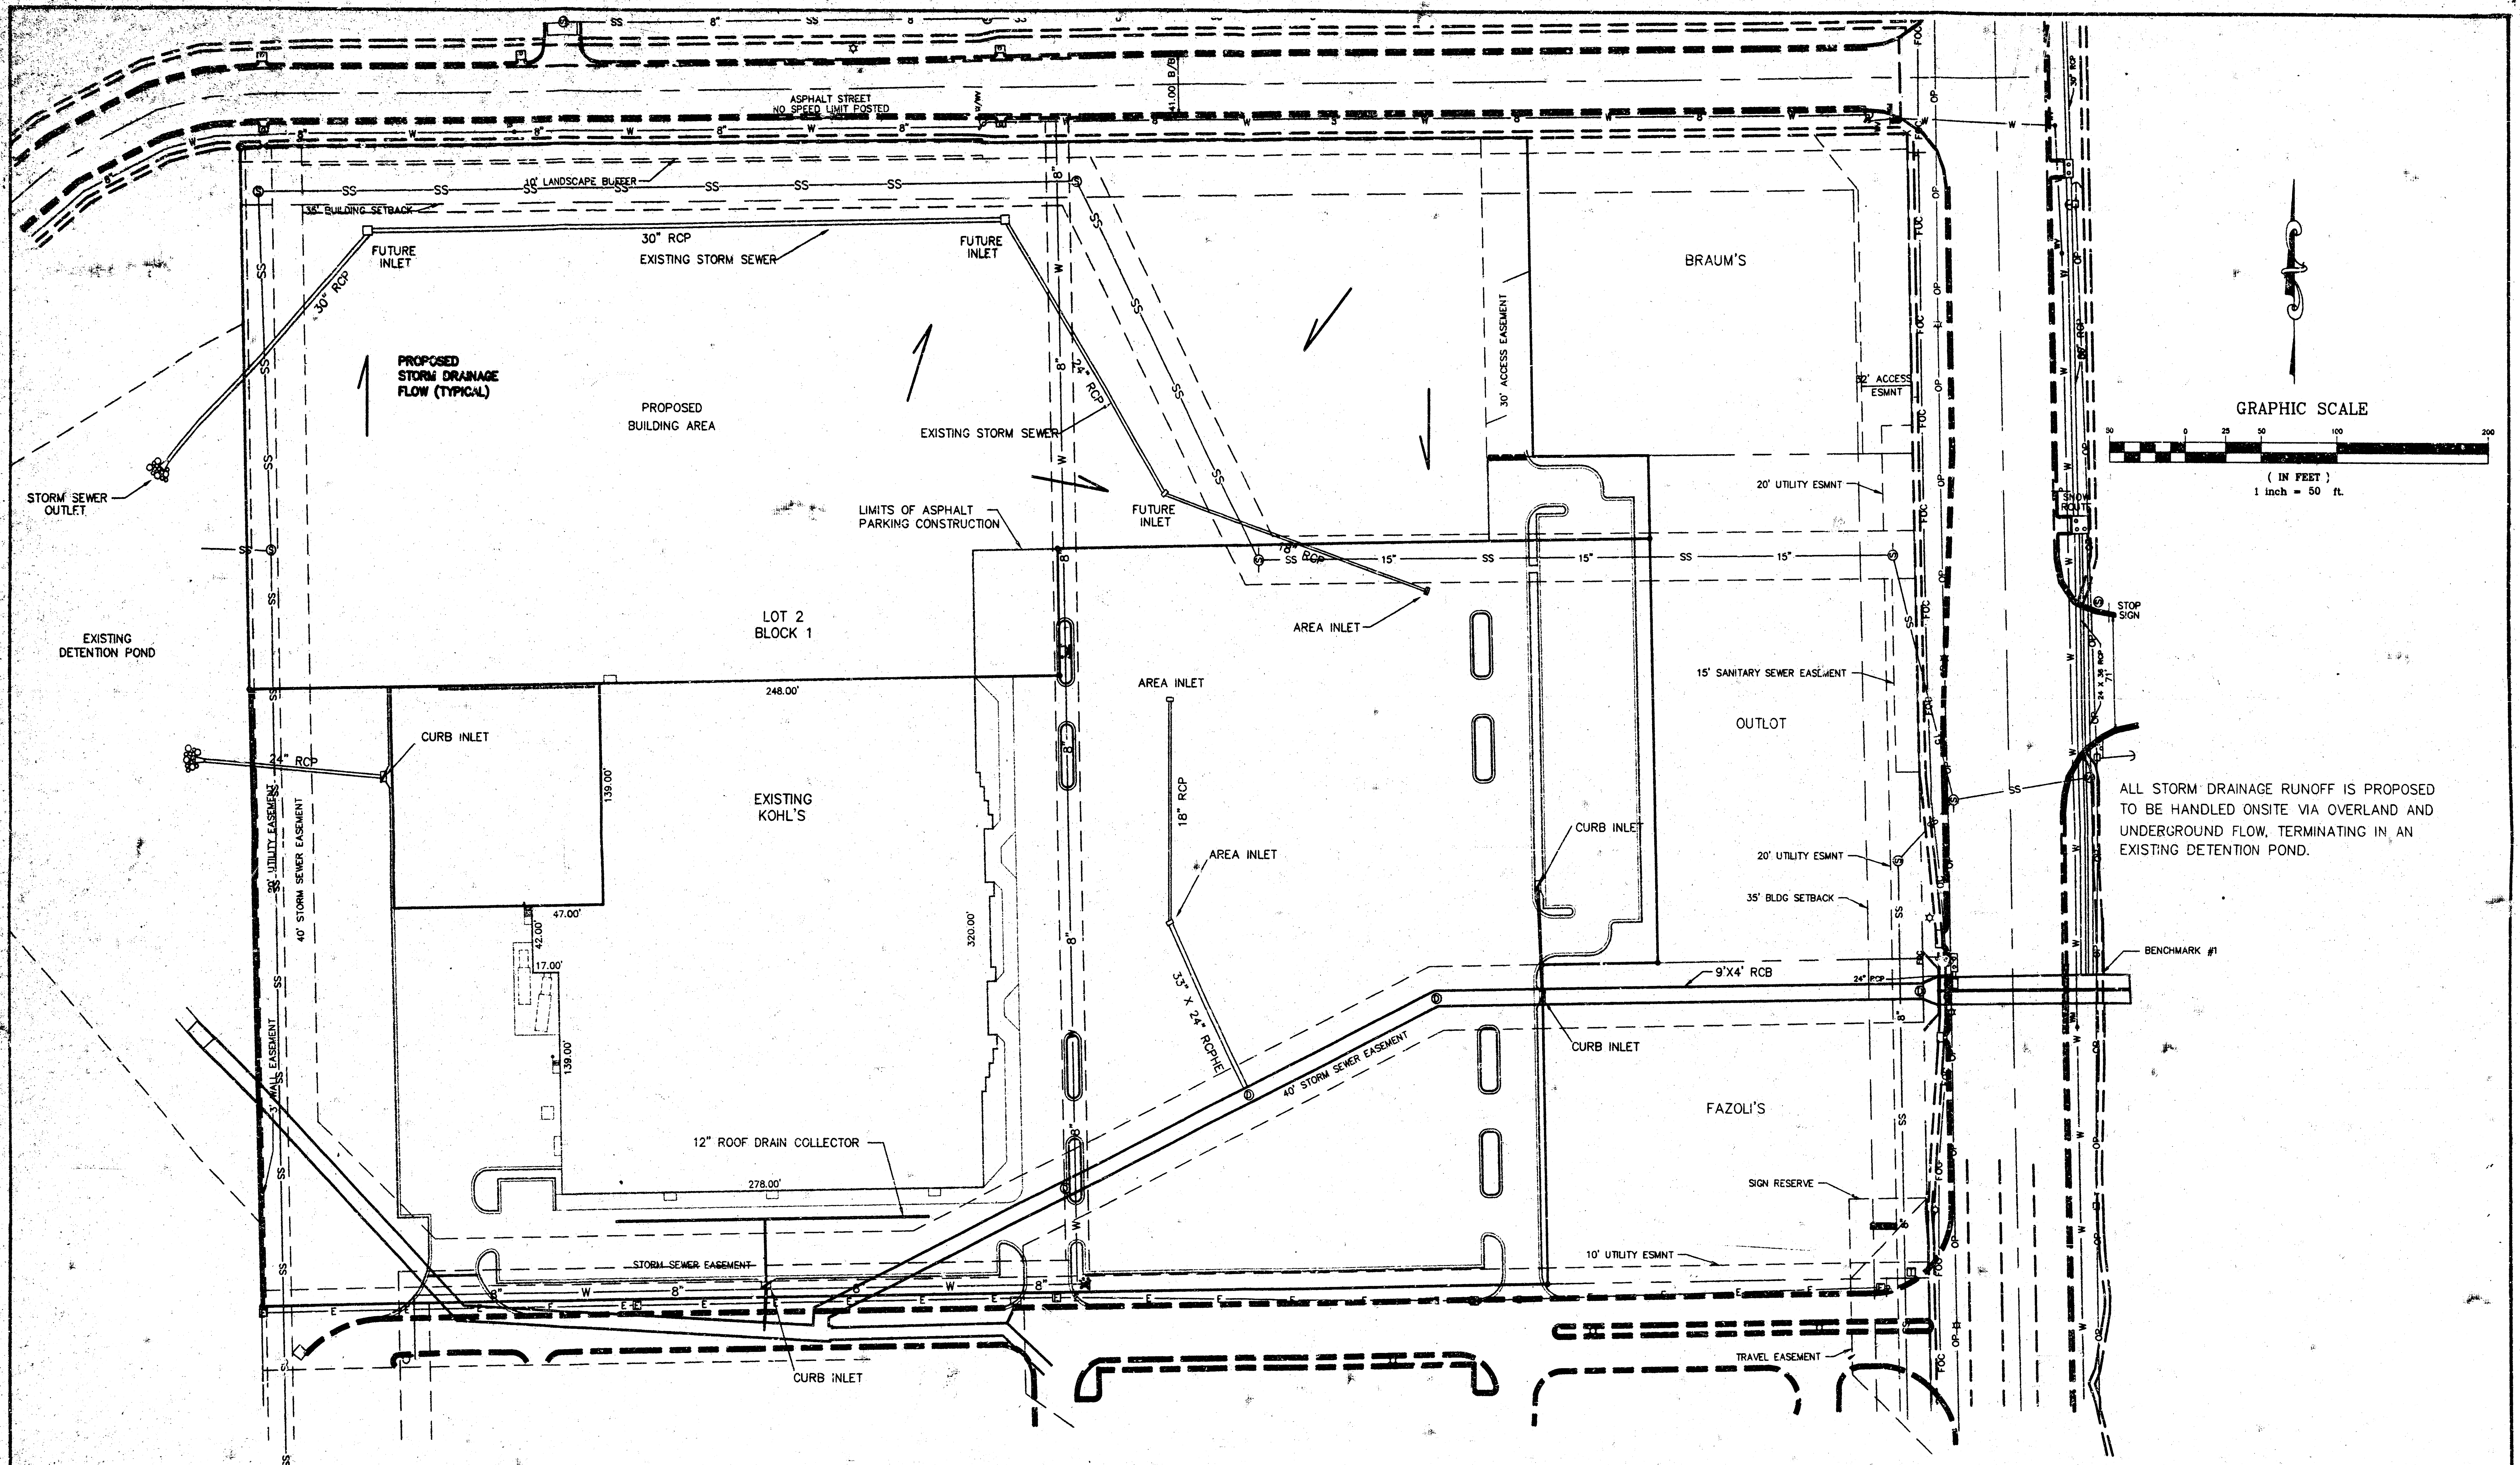

NO.	DATE	REVISION	BY
LOT 2, BLOCK 1, COMOTARA POWER CENTER 2ND ADDITION, STORM DRAINAGE PLAN			
P.O. BOX 1304 2319 NORTH JACKSON JUNCTION CITY, KANSAS (913) 782-5040 FAX 913-782-7744	KAW VALLEY ENGINEERING, INC.		
122 N.W. PARKWAY RIVERSIDE, MISSOURI 64150 (816) 587-5043 FAX 816-587-0129	DATE: JULY 8, 1999	DESIGNER: SM	DRAWN BY: SM
	CHECKED BY: JCN	SHEET 1 OF 1	