
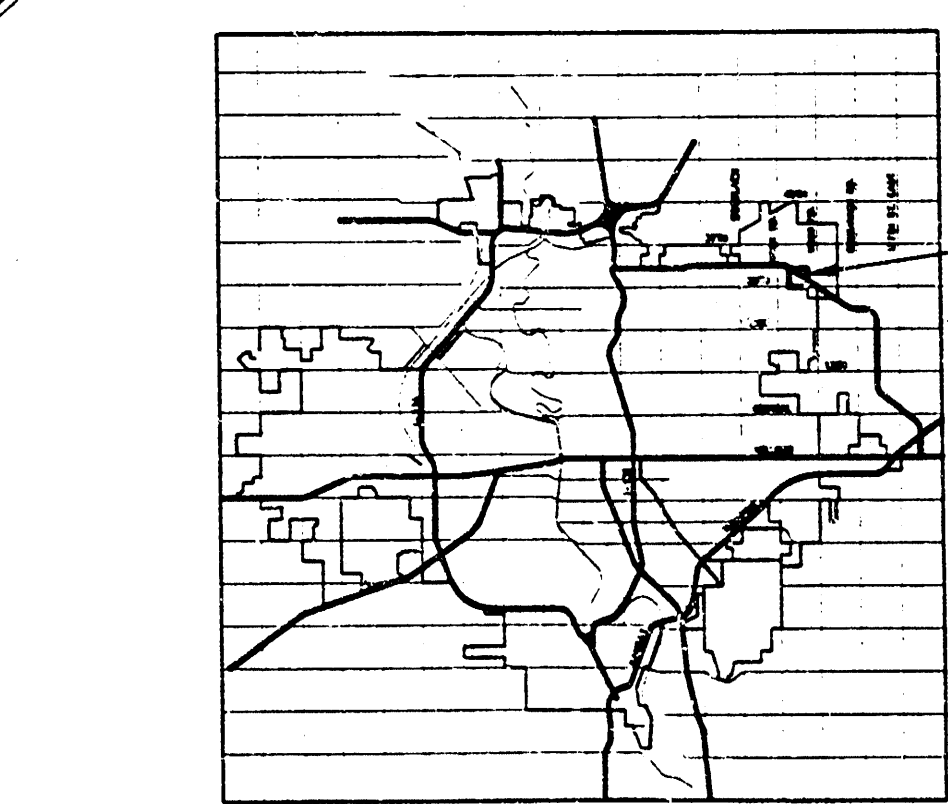
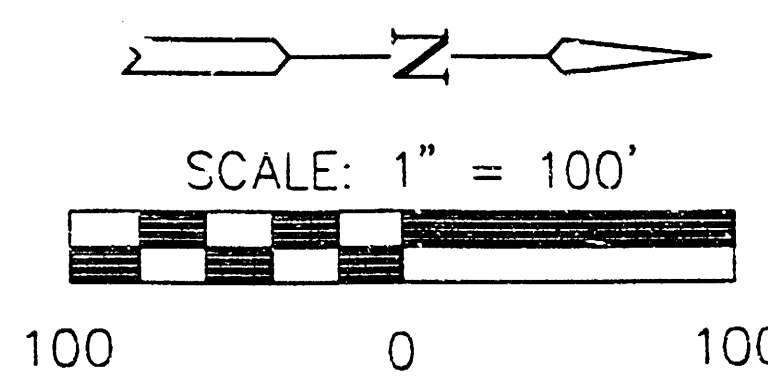


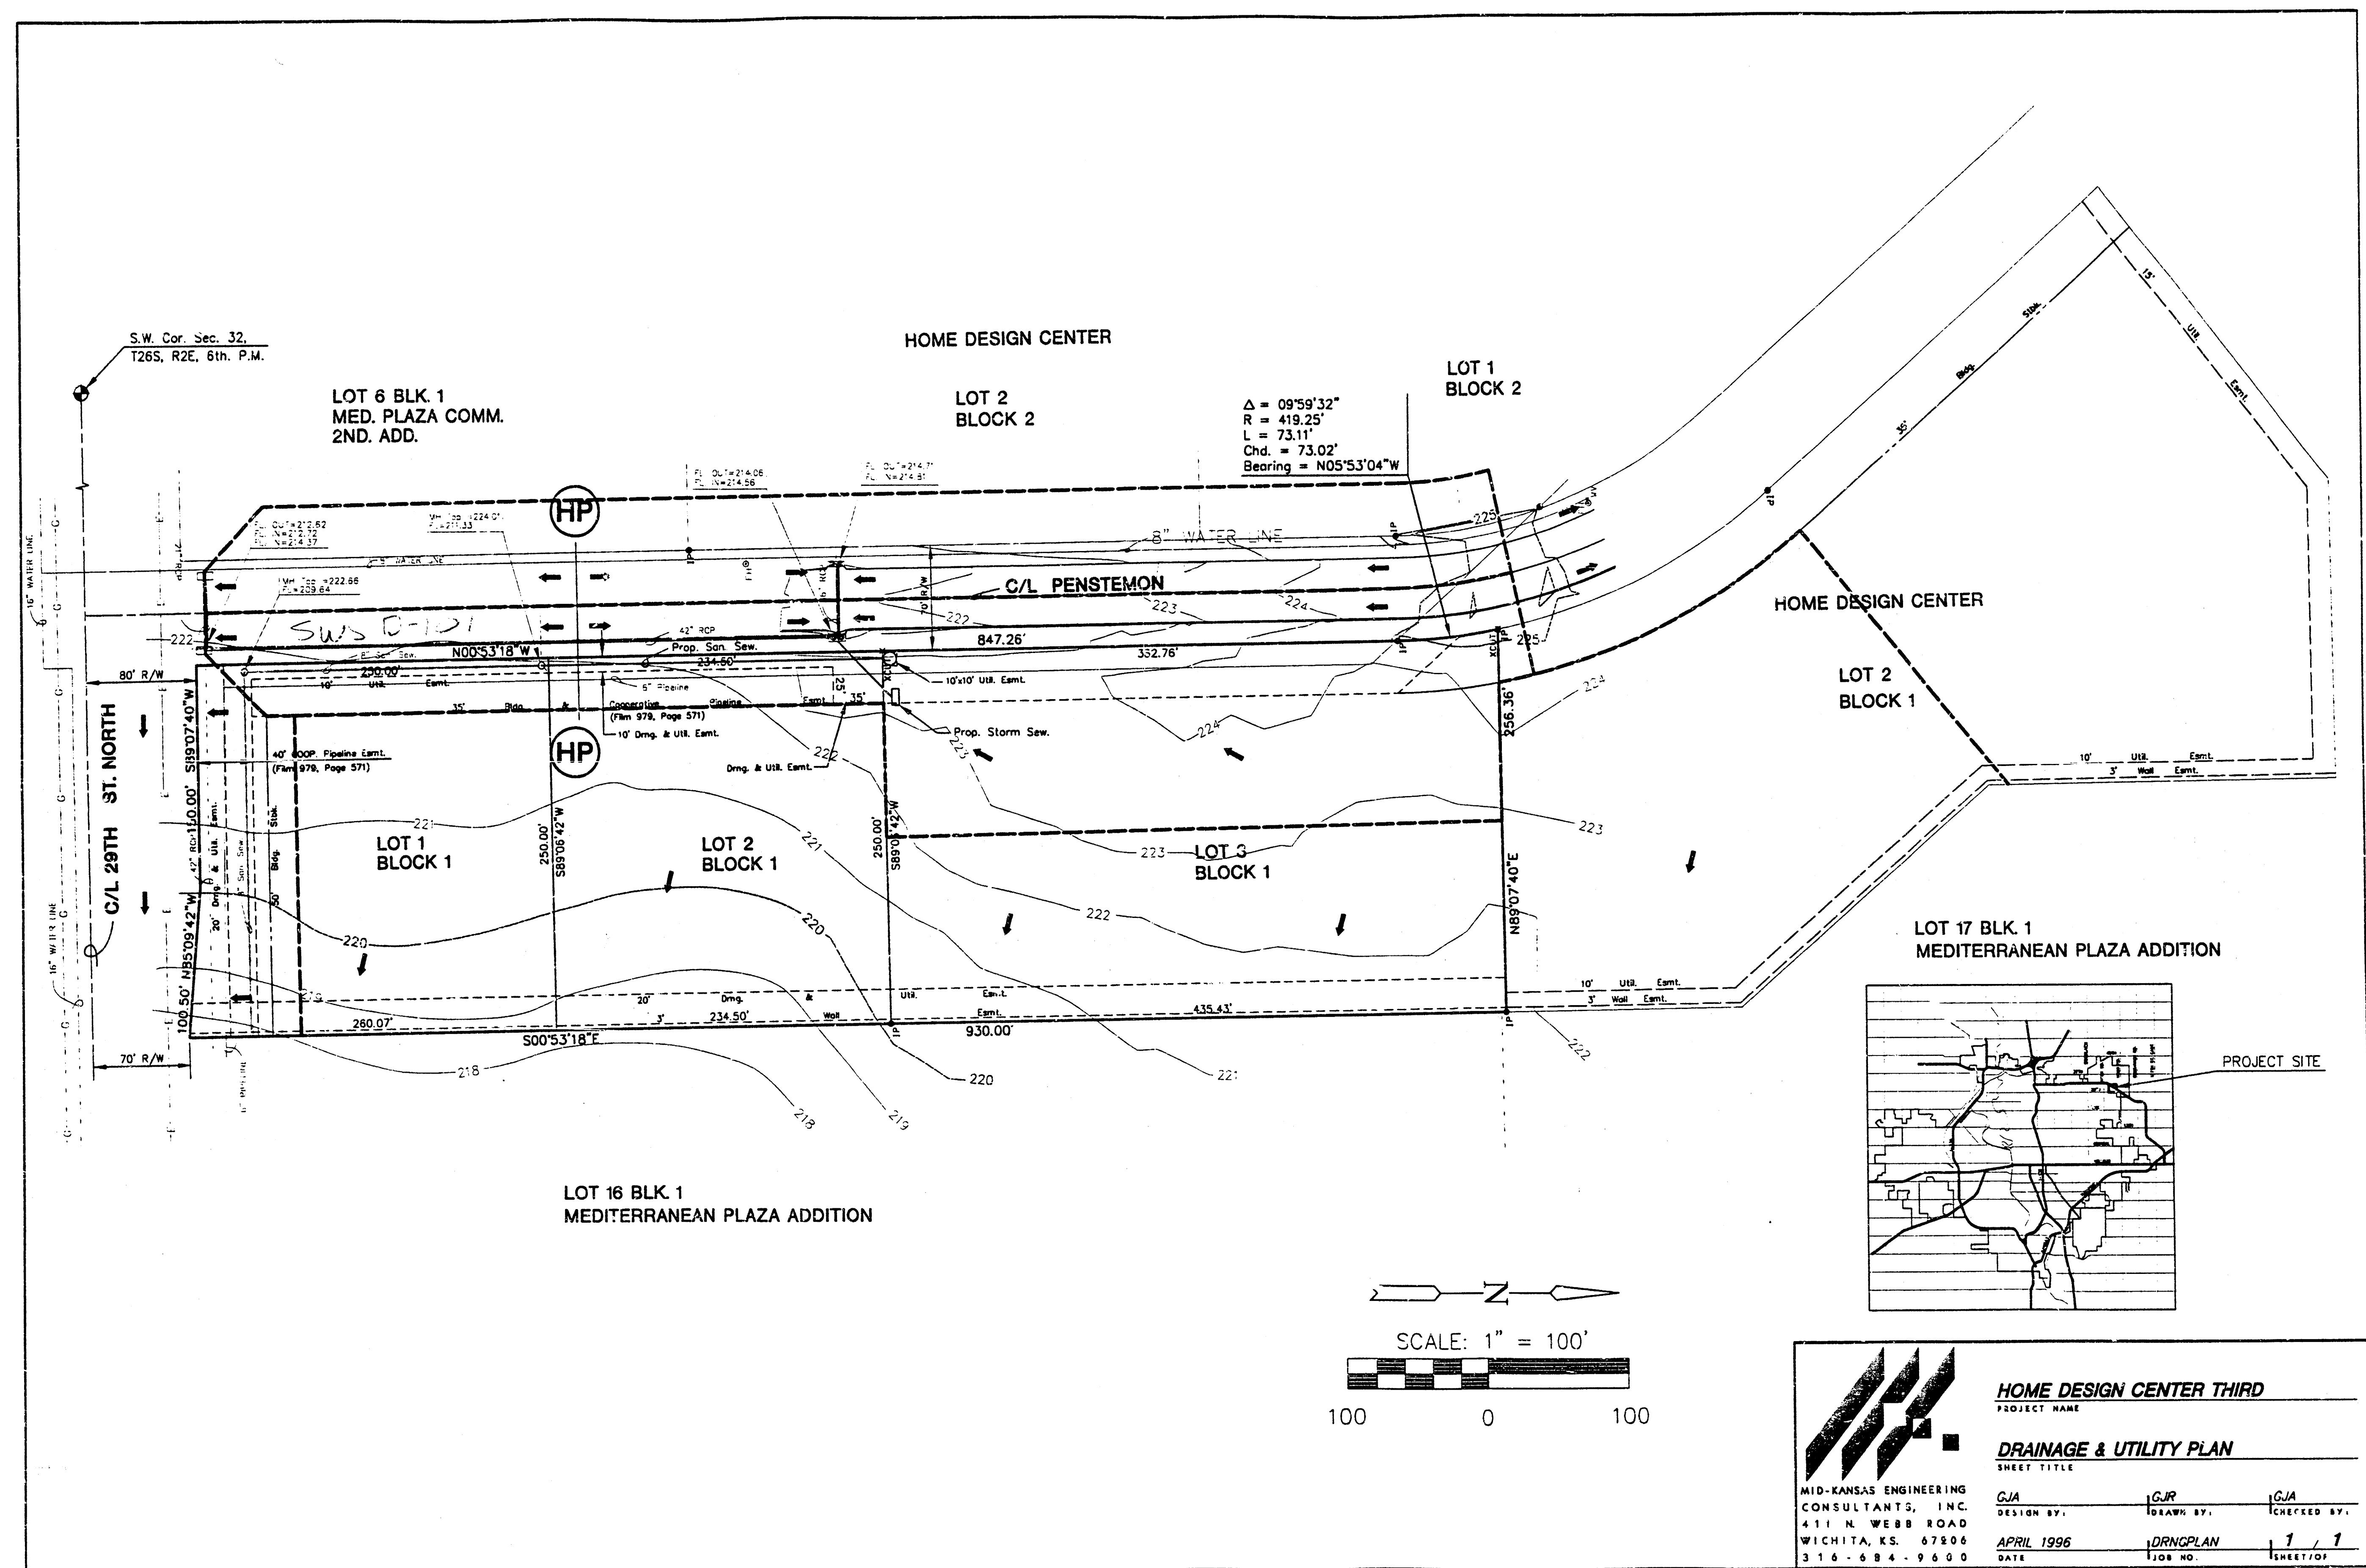

MID-KANSAS ENGINEERING CONSULTANTS, INC. 411 N. WEBB ROAD WICHITA, KS. 67206 316-684-9600	HOME DESIGN CENTER THIRD		
	PROJECT NAME		
	DRAINAGE & UTILITY PLAN		
	SHEET TITLE		
GJA DESIGN BY. APRIL 1996 DATE	GJR DRAWN BY. DRNGPLAN JOB NO.	GJA CHECKED BY. 1 / 1 SHEET/JOY	