



LETTER OF TRANSMITTAL

PROJECT: Kellogg West Square
Drainage and Utility Plan
PROJECT NO: 94024 DATE: 5/27/94

**MID-KANSAS ENGINEERING
CONSULTANTS, INC.**
3500 N. Rock Road, #800
Wichita, KS 67226
316-636-5566
FAX: 316-636-4125

TO: Vicky Huang, P.E.
City Hall - 7th Floor
455 N. Main
Wichita, KS 67202-1638

We are sending you the following items: ☒ Attached
☐ Under separate cover
☐ Via _____

☐ Prints ☐ Specifications ☐ Drawings
☐ Contract ☐ Petitions ☐ Other


COMMENTS:

Here is the revised Drainage and Utility Plan for the referenced plat for your review and comment. This revised plan indicates drainage onto public property, rather than private property. At this time we are not able to get the required Cross Lot Drainage Agreement. By designing the site to public streets and storm sewers this agreement should not be required. If you have any questions, please contact me.

☐ For Your Approval ☐ As Requested
☐ For Your Use ☐ For Your Files
☐ Approved As Noted ☐ For Review and Comment


REMARKS:

Signed: Greg Allison
Greg Allison, P.E.

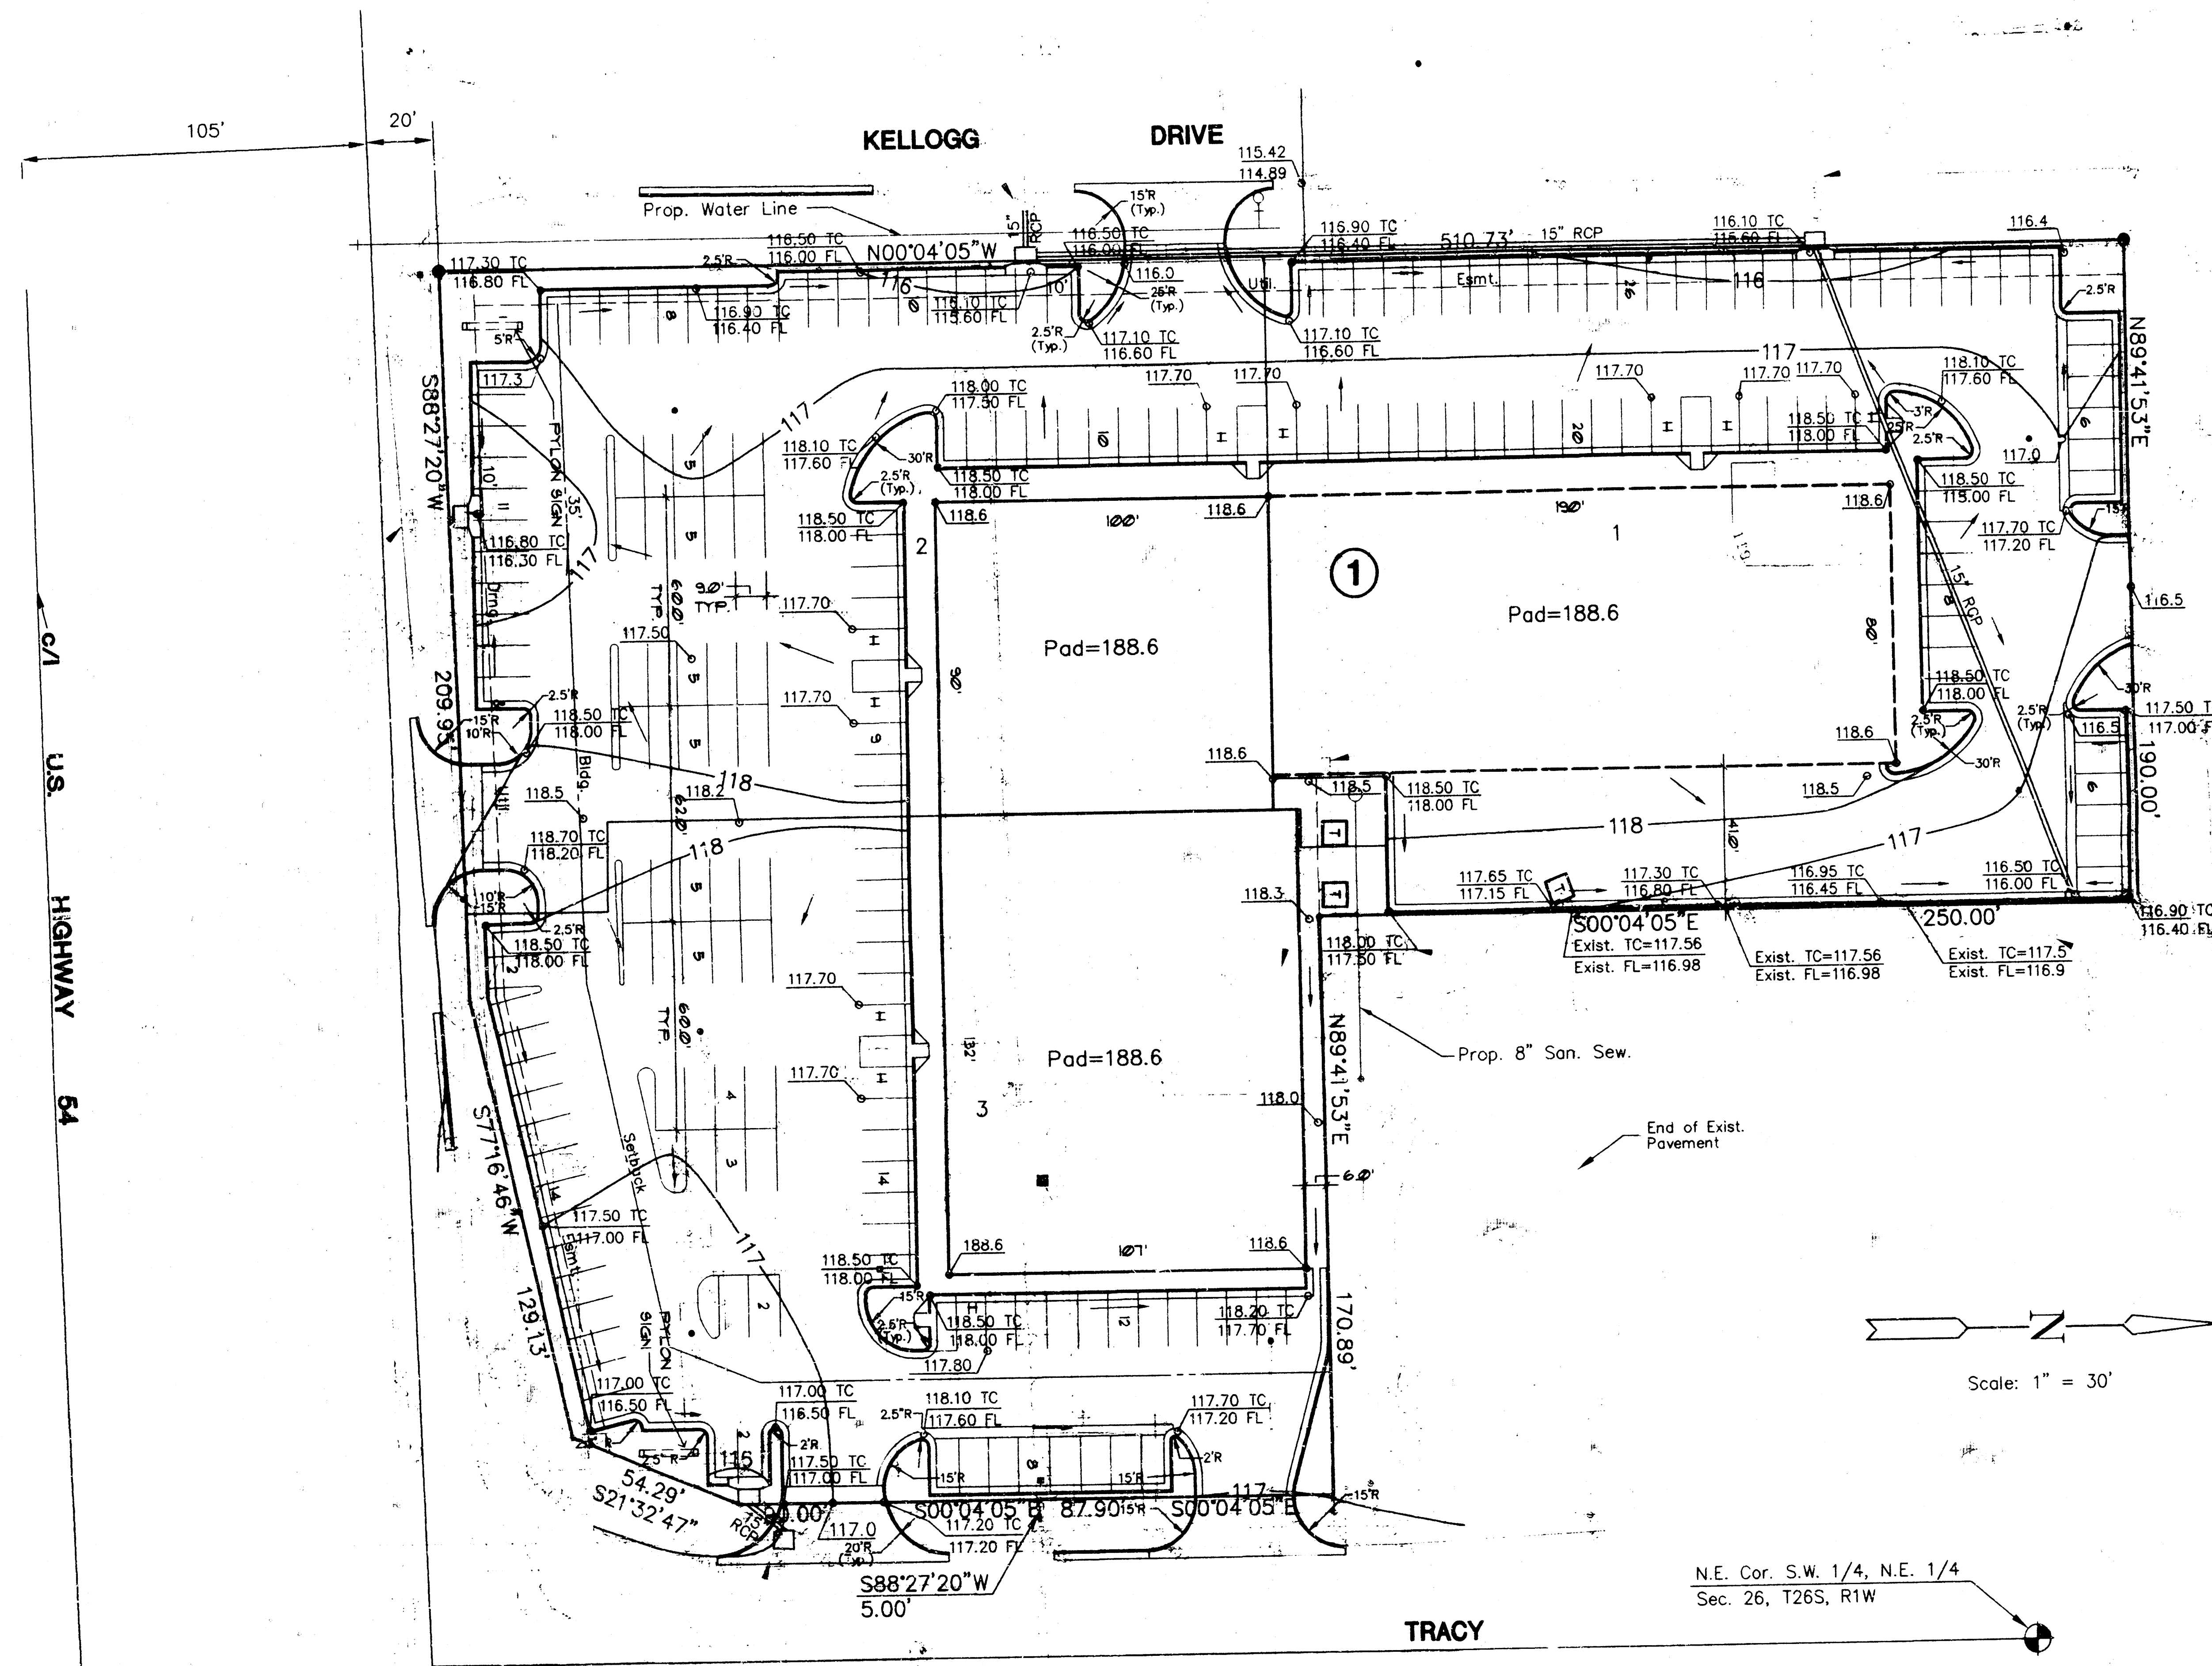

Scale: 1" = 30'

N.E. Cor. S.W. 1/4, N.E. 1/4
Sec. 26, T26S, R1W


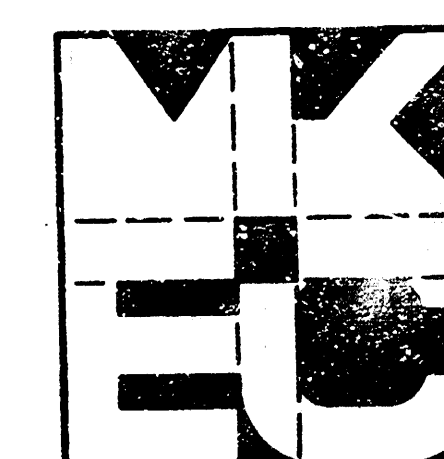


KELLOGG WEST SQUARE
DRAINAGE, GRADING,
AND UTILITY PLAN

Design
GJA
Drawn by
WNJ
Checked by
Date
MAY 1994
Job No.
9423GRD

MID-KANSAS ENGINEERING CONSULTANTS INC.
3500 NORTH ROCK ROAD
BUILDING #800
WICHITA, KANSAS 67226

(316) 636-5566

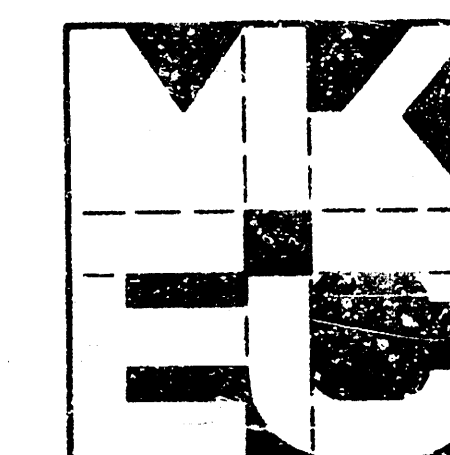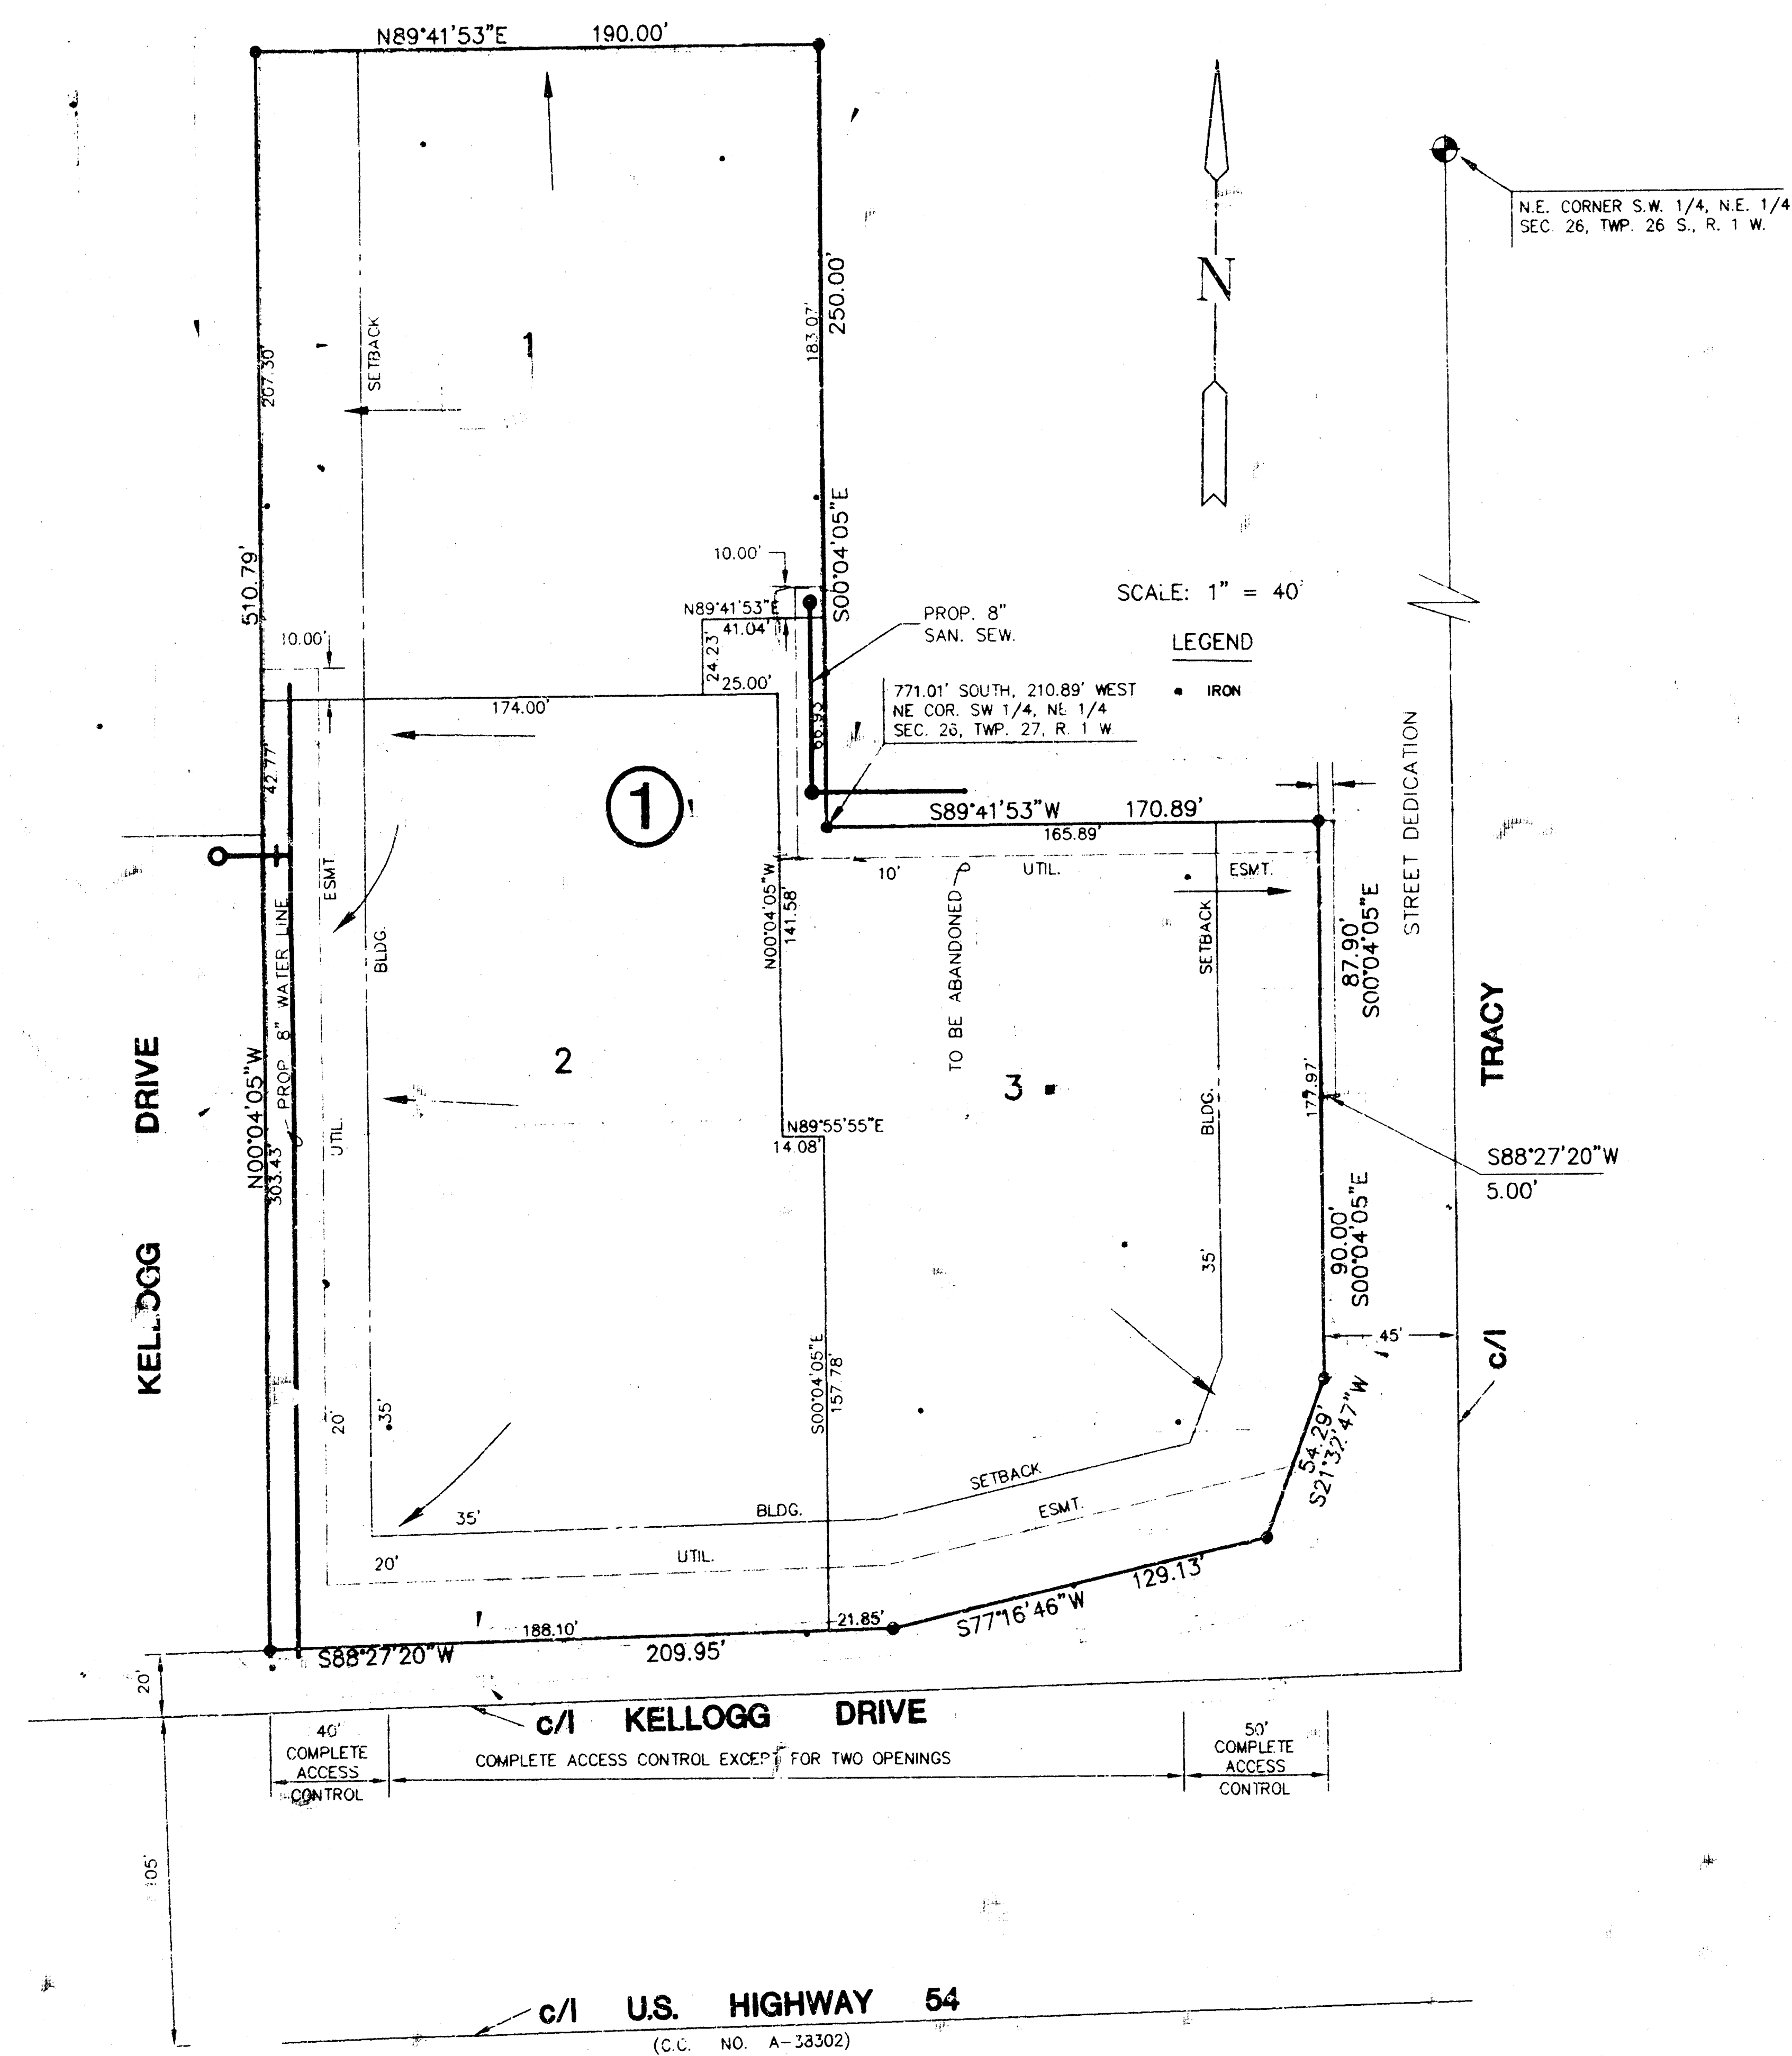

KELLOGG WEST SQUARE
DRAINAGE AND UTILITY
PLAN

MID-KANSAS ENGINEERING CONSULTANTS INC.
3500 NORTH ROCK ROAD
BUILDING #900
WICHITA, KANSAS 67226 (316) 636-5566

Design	
Drawn by	
Checked by	
Date	
Job no.	
Sheet	
Of	